

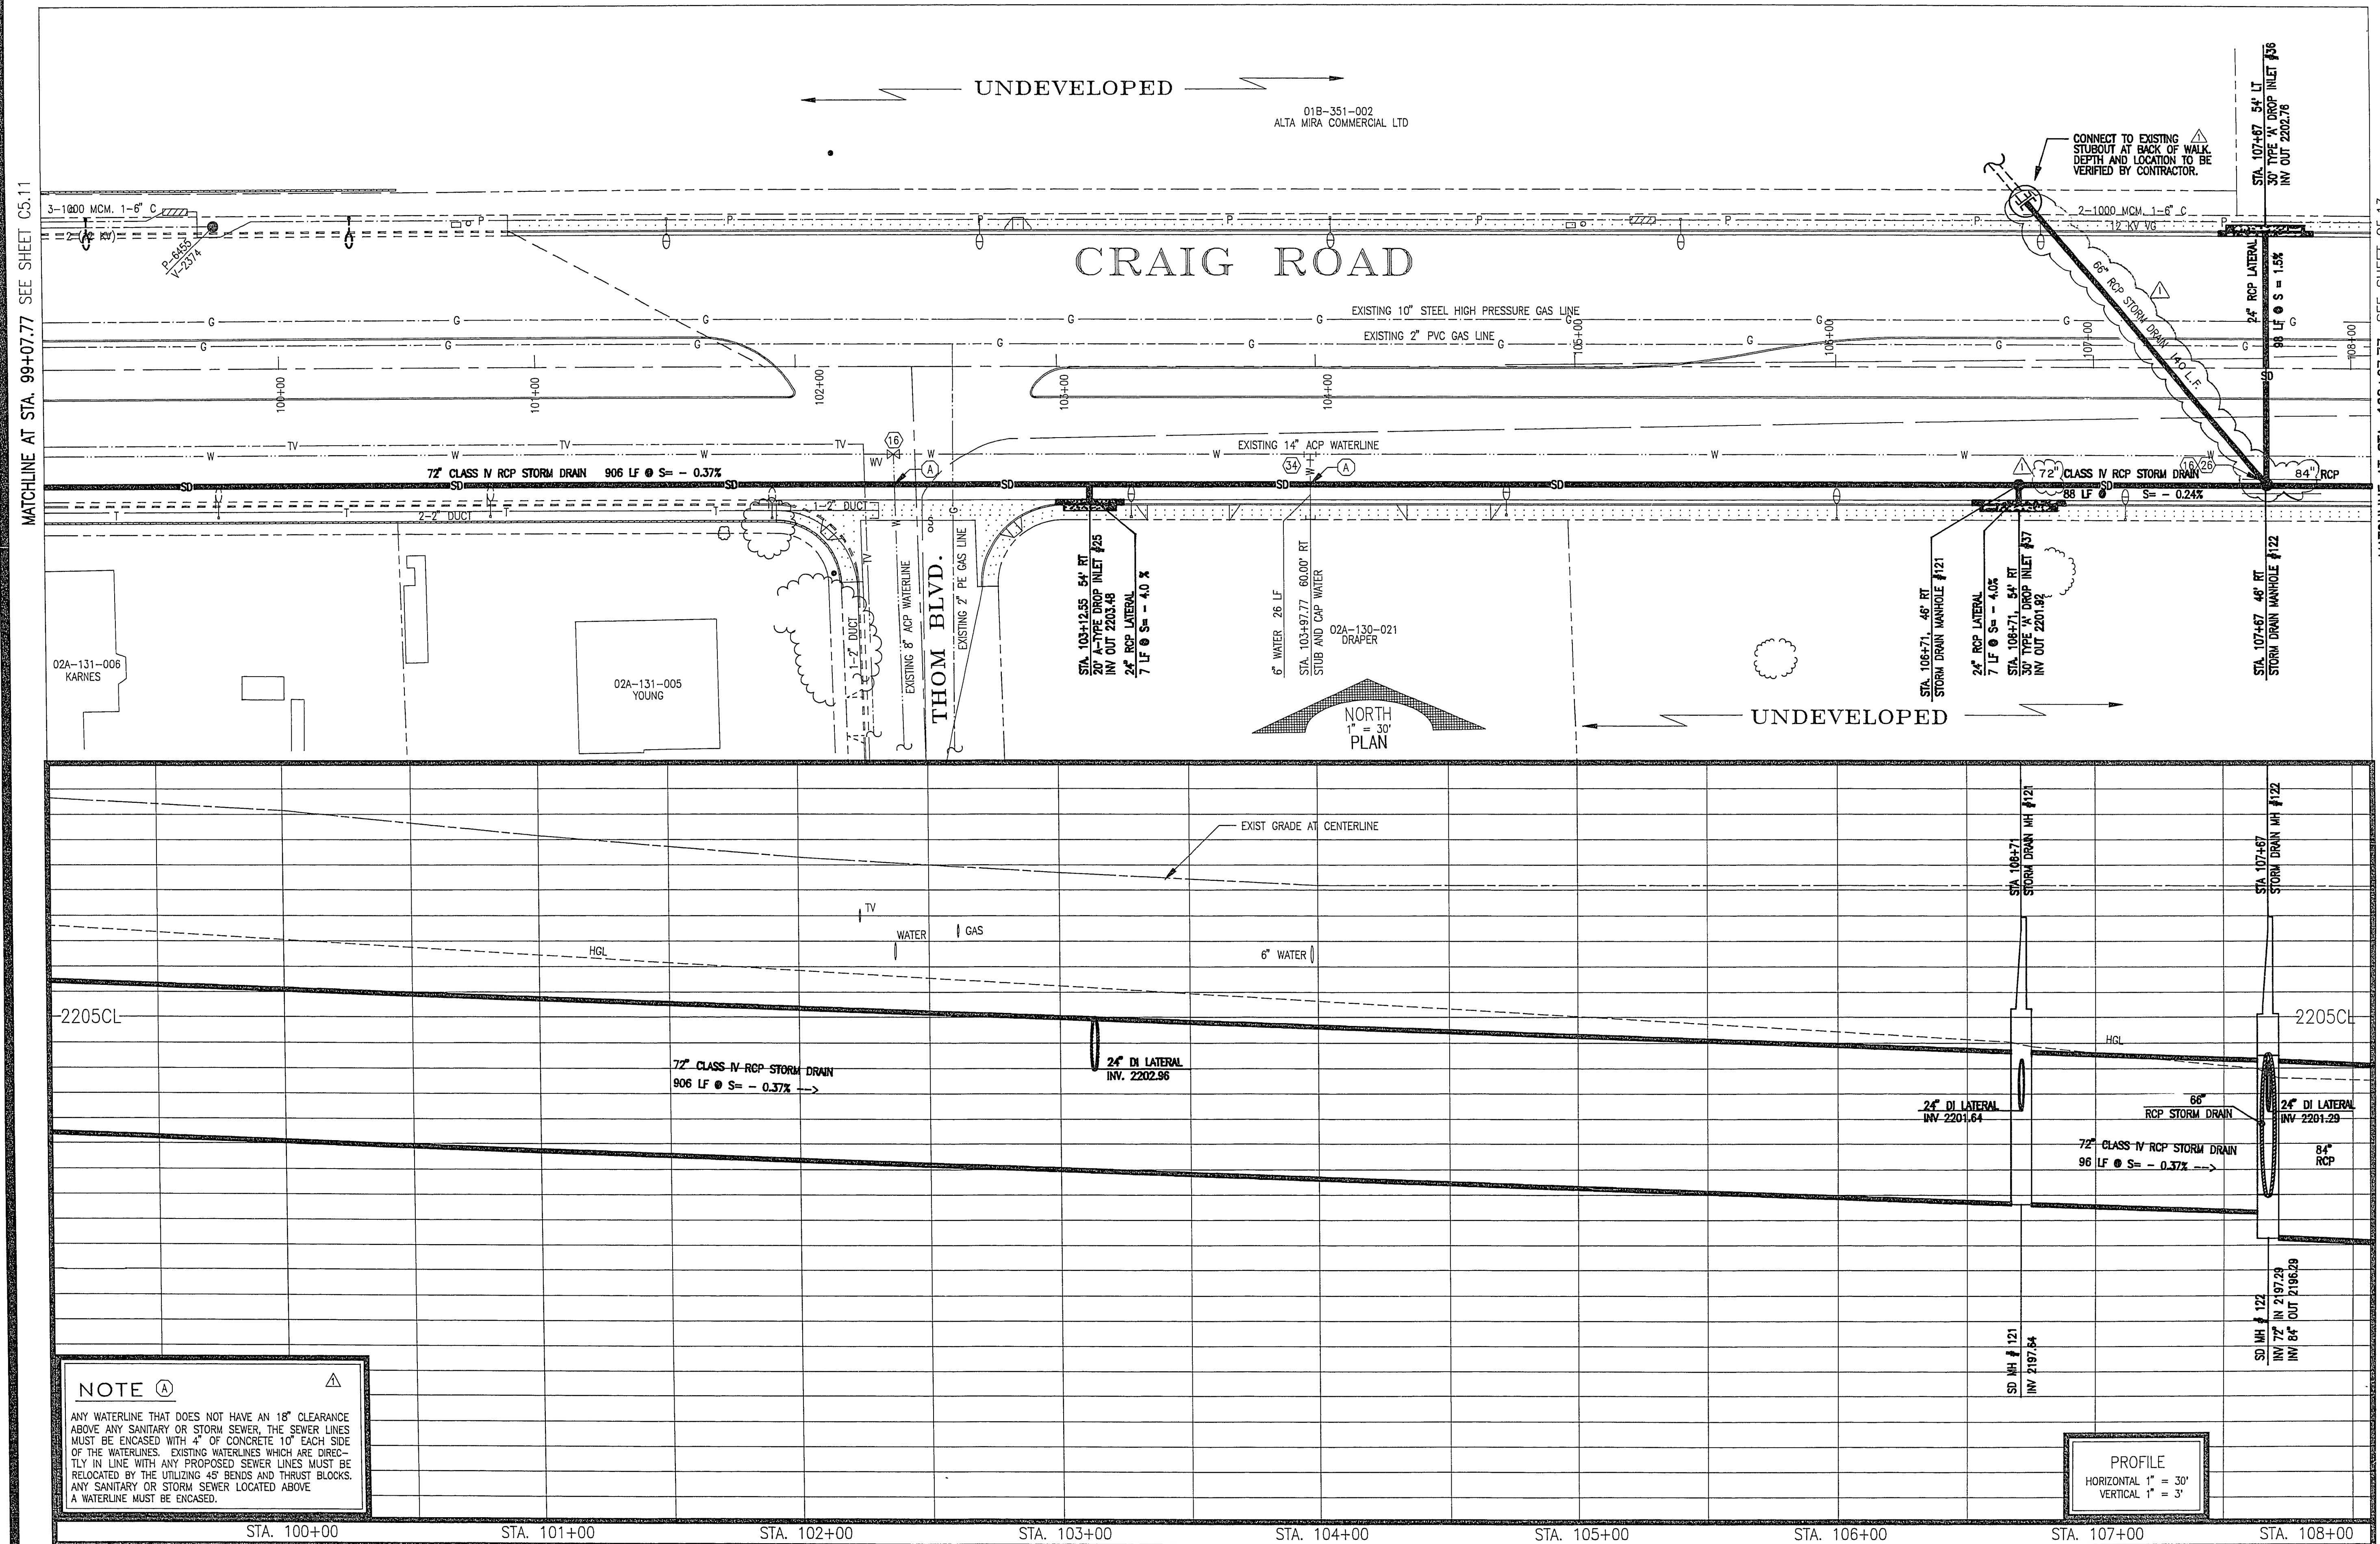


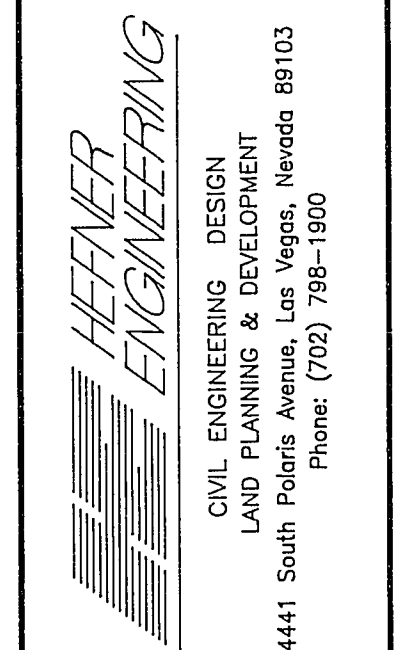

REVISIONS PERFORMED TO EXISTING DRAWINGS BY THE CITY OF LAS VEGAS ENGINEERING DIVISION
ORIGINAL HENNER ENGINEERING DESIGN DRAWINGS ON FILE AT THE CITY OF LAS VEGAS

DATE	REVISION
	CITY OF LAS VEGAS ENGINEERING DESIGN
9/92	△ DRAINAGE DESIGN REVISED ALONG WITH
	VARIOUS OTHER MINOR REVISIONS
12 JUNE 1992	△ CONNECT TO STUB ENGAGEMENT NOTE

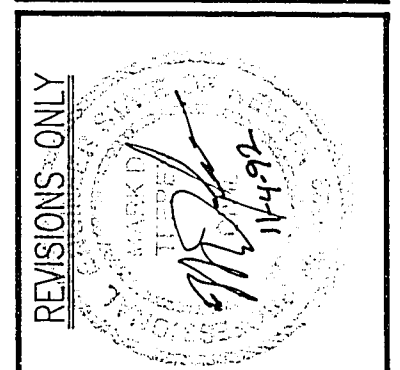

CRAIG ROAD
UTILITY PLAN AND PROFILE
STATION 99+07.77 TO STATION 108+07.77

SHEET NO.

C5.12.2

107-V1804