


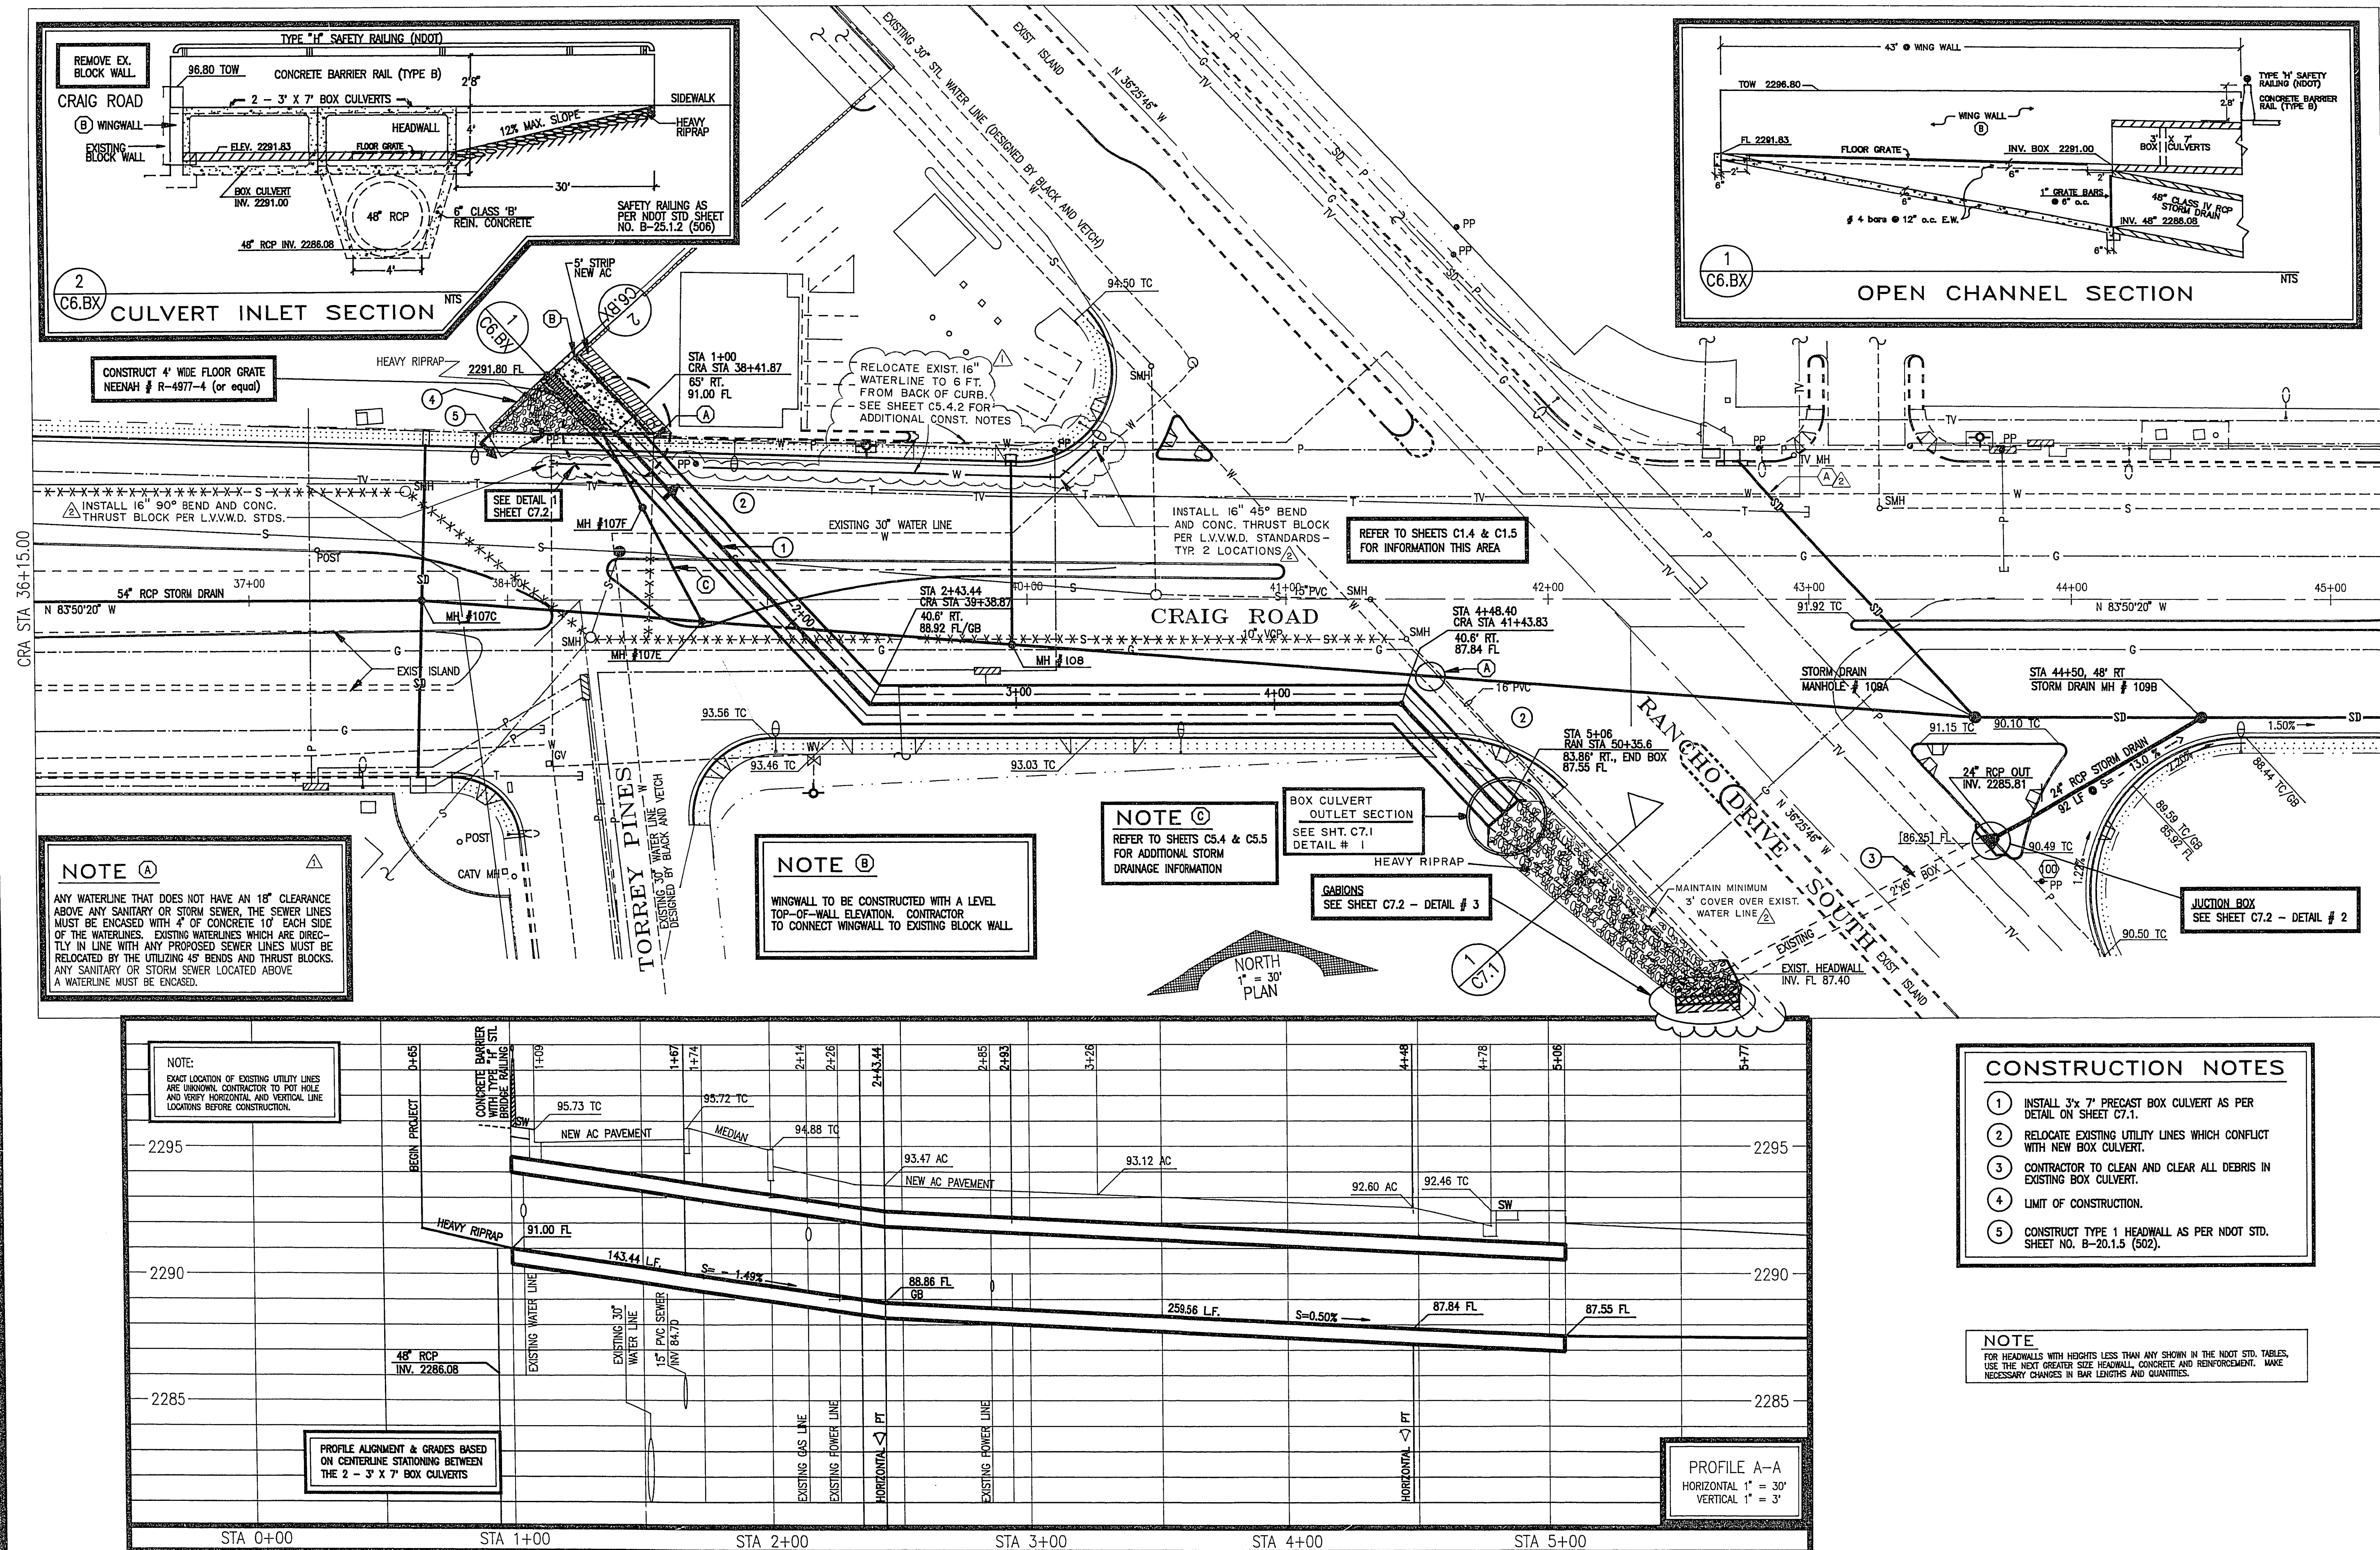

REVISION	CITY OF LAS VEGAS ENGINEERING DESIGN
DATE	9/92
REVISIONS ONLY	DRAINAGE DESIGN REVISED ALONG WITH VARIOUS OTHER MINOR REVISIONS
	ADD WATER LINE CONST. NOTES
	RELOCATE WATER LINE, MAKE ARROW
	ENCASEMENT NOTE

HEFNER ENGINEERING

CIVIL ENGINEERING DESIGN
LAND PLANNING & DEVELOPMENT
4441 South Polaris Avenue, Las Vegas, Nevada 89103
Phone: (702) 798-1500

CRAIG ROAD

UTILITY PLAN AND PROFILE

STATION 31+48.79 TO STATION 40+48.79

SHEET NO.

C6.BX.1

107-V1804
1080428X DATE: 11/07/91

REVISIONS PREFORMED TO EXISTING DRAWINGS BY THE CITY OF LAS VEGAS ENGINEERING DIVISION
ORIGINAL HEFNER ENGINEERING DESIGN DRAWINGS ON FILE AT THE CITY OF LAS VEGAS