



UTILITY NOTE

UTILITY LOCATIONS SHOWN HEREON ARE APPROXIMATE ONLY. IT SHALL BE THE CONTRACTOR'S RESPONSIBILITY TO DETERMINE THE EXACT HORIZONTAL AND VERTICAL LOCATION OF ALL EXISTING UNDERGROUND UTILITIES PRIOR TO COMMENCING CONSTRUCTION. NO REPRESENTATION IS MADE THAT ALL EXISTING UTILITIES ARE SHOWN HEREON. THE ENGINEER ASSUMES NO RESPONSIBILITY FOR UTILITIES NOT SHOWN OR UTILITIES NOT SHOWN IN THEIR PROPER LOCATION.

Avoid cutting underground utility lines. It's costly.
Call before you Dig
1-800-227-2600
UNDERGROUND SERVICE (USA)

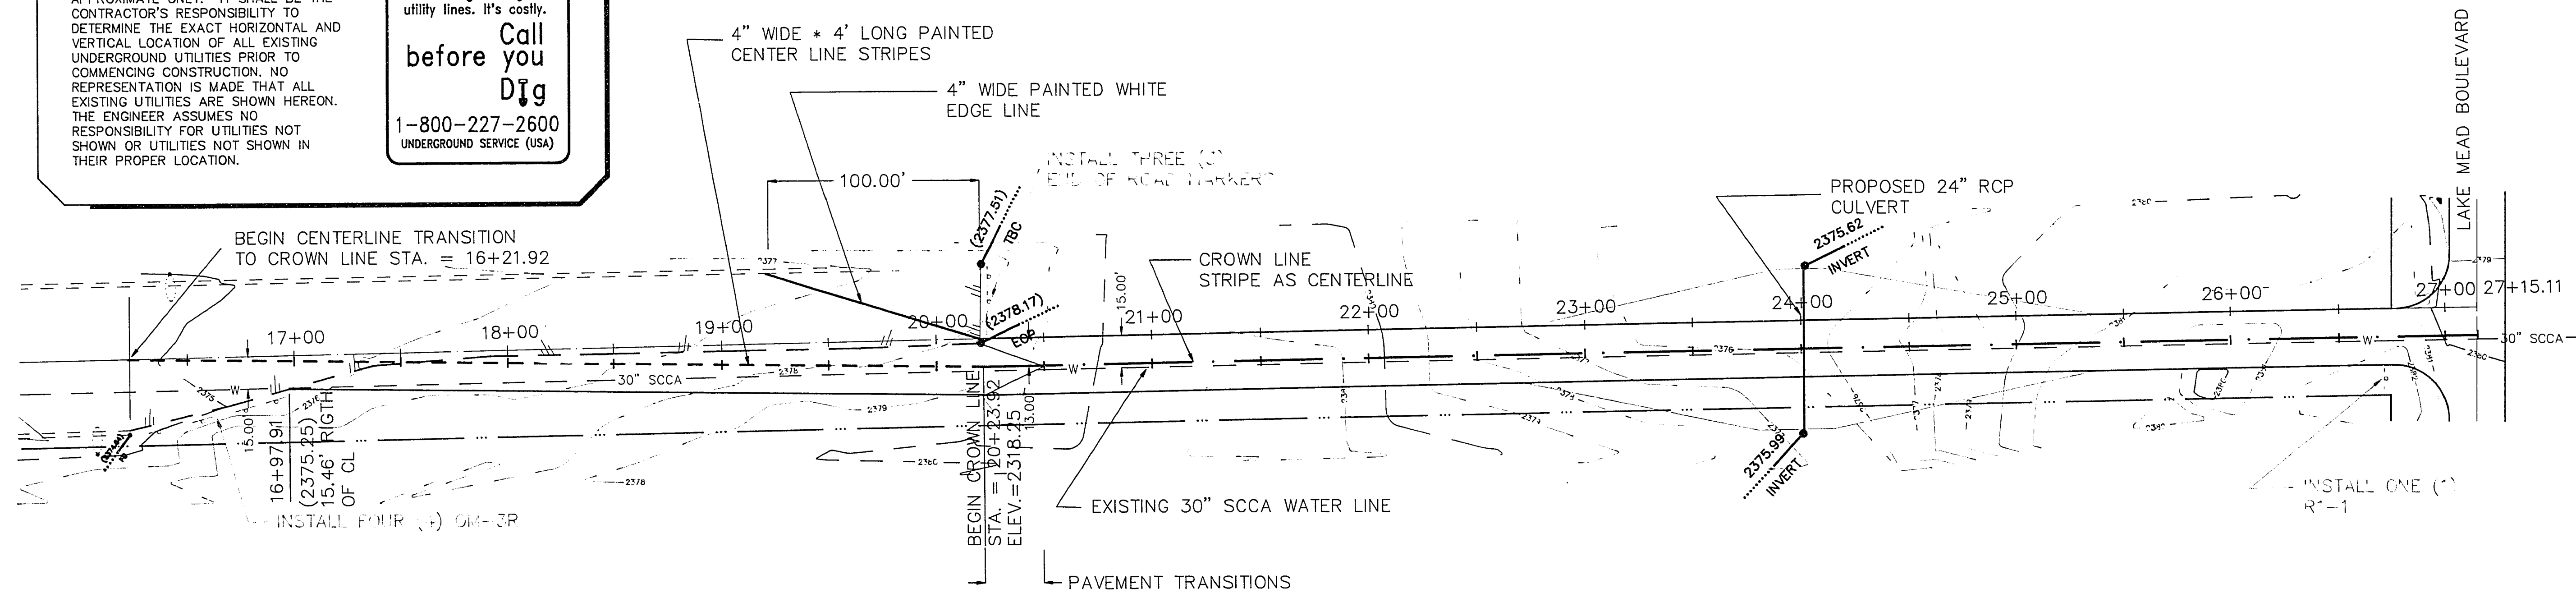

STREET SECTION

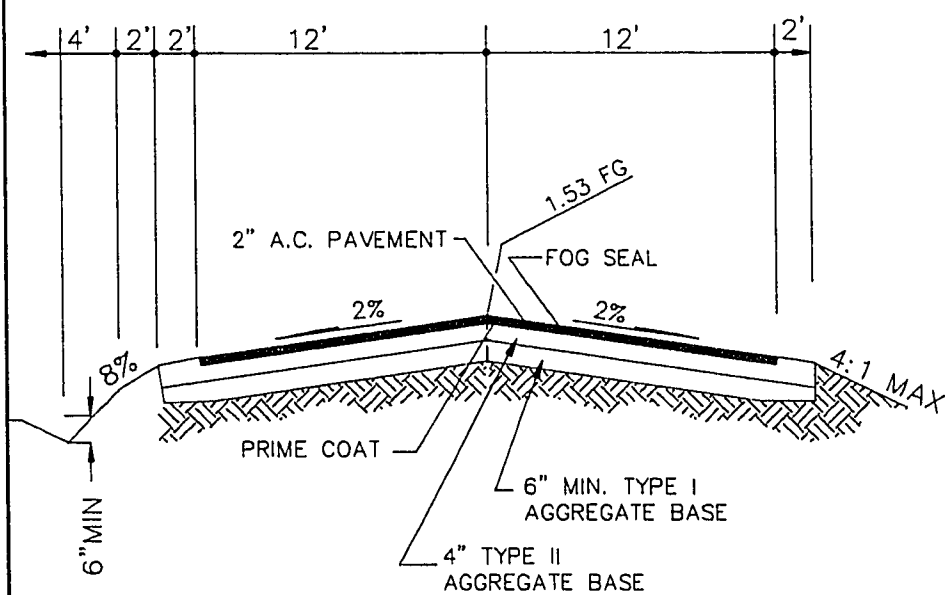


REFER TO CITY OF LAS VEGAS UNIFORM STANDARD DRAWINGS DWG NO.209

BENCHMARK

TOP OF CURB, WEST SIDE OF DURANGO DRIVE
- 250 FEET SOUTH OF WESTCLIFF DRIVE.
CITY OF LAS VEGAS DATUM = 2610.66
(G.C. WALLACE DATUM)

CONSTRUCTION NOTES

- 1.) STATION 0+00 IS AT THE INTERSECTION OF TENAYA AND SMOKE RANCH ROAD.


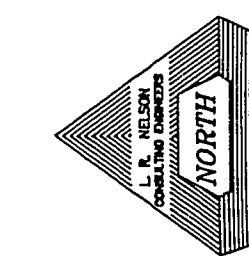


HORIZONTAL
VERTICAL
1" = 40'
1" = 4'

TENAYA WAY


APPROVALS

Gary A. Presswood 8-3-91
GARY A. PRESSWOOD DATE
CITY OF LAS VEGAS ENGINEER
John J. G. G. 8-06-91
LAS VEGAS VALLEY WATER DISTRICT DATE
John A. Williams 8/7/91
NEVADA POWER COMPANY DATE

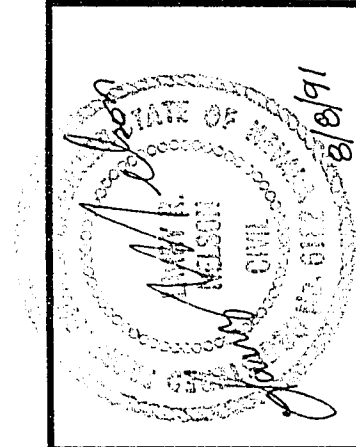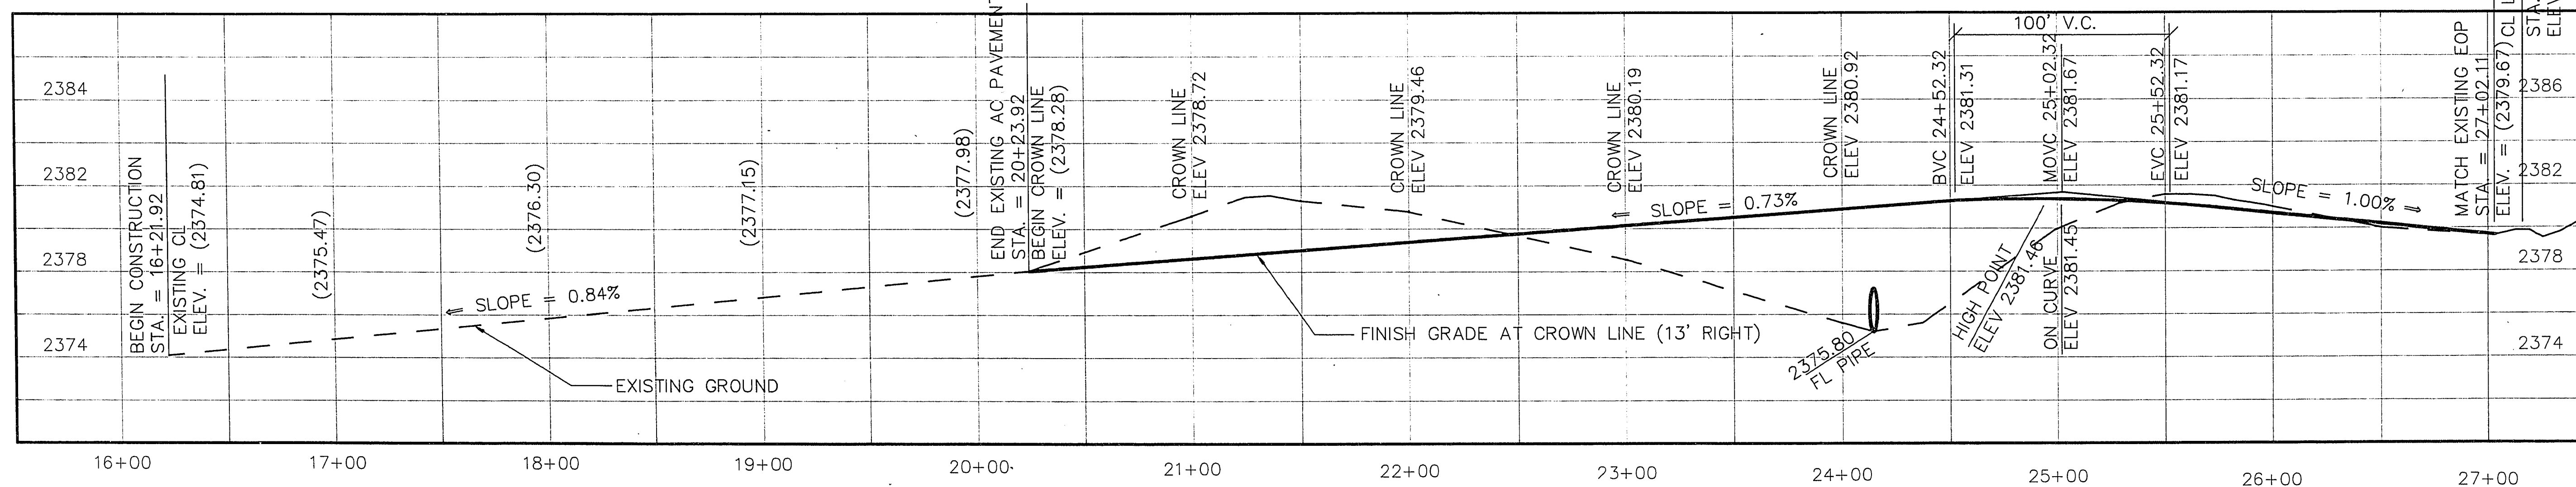

PROJECT NUMBER BY:	CSS
DATE:	01-08-93
NO.	REVISION
DATE:	JULY 1991

L.R. NELSON
CONSULTING ENGINEERS
6076 SOUTH EASTERN AVENUE
LAS VEGAS, NEVADA 89119
(702) 798-7978

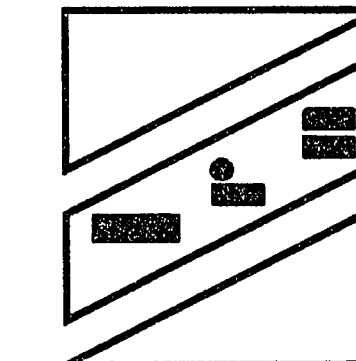

STREET PLAN AND PROFILE
CLARK COUNTY SCHOOL DISTRICT
TENAYA WAY 16+21.92 TO 27+15.32
CITY OF LAS VEGAS NEVADA

SHEET NUMBER
1
OF 1 SHEETS

107-V1925

28-3-185