


Scale 1" = 80'

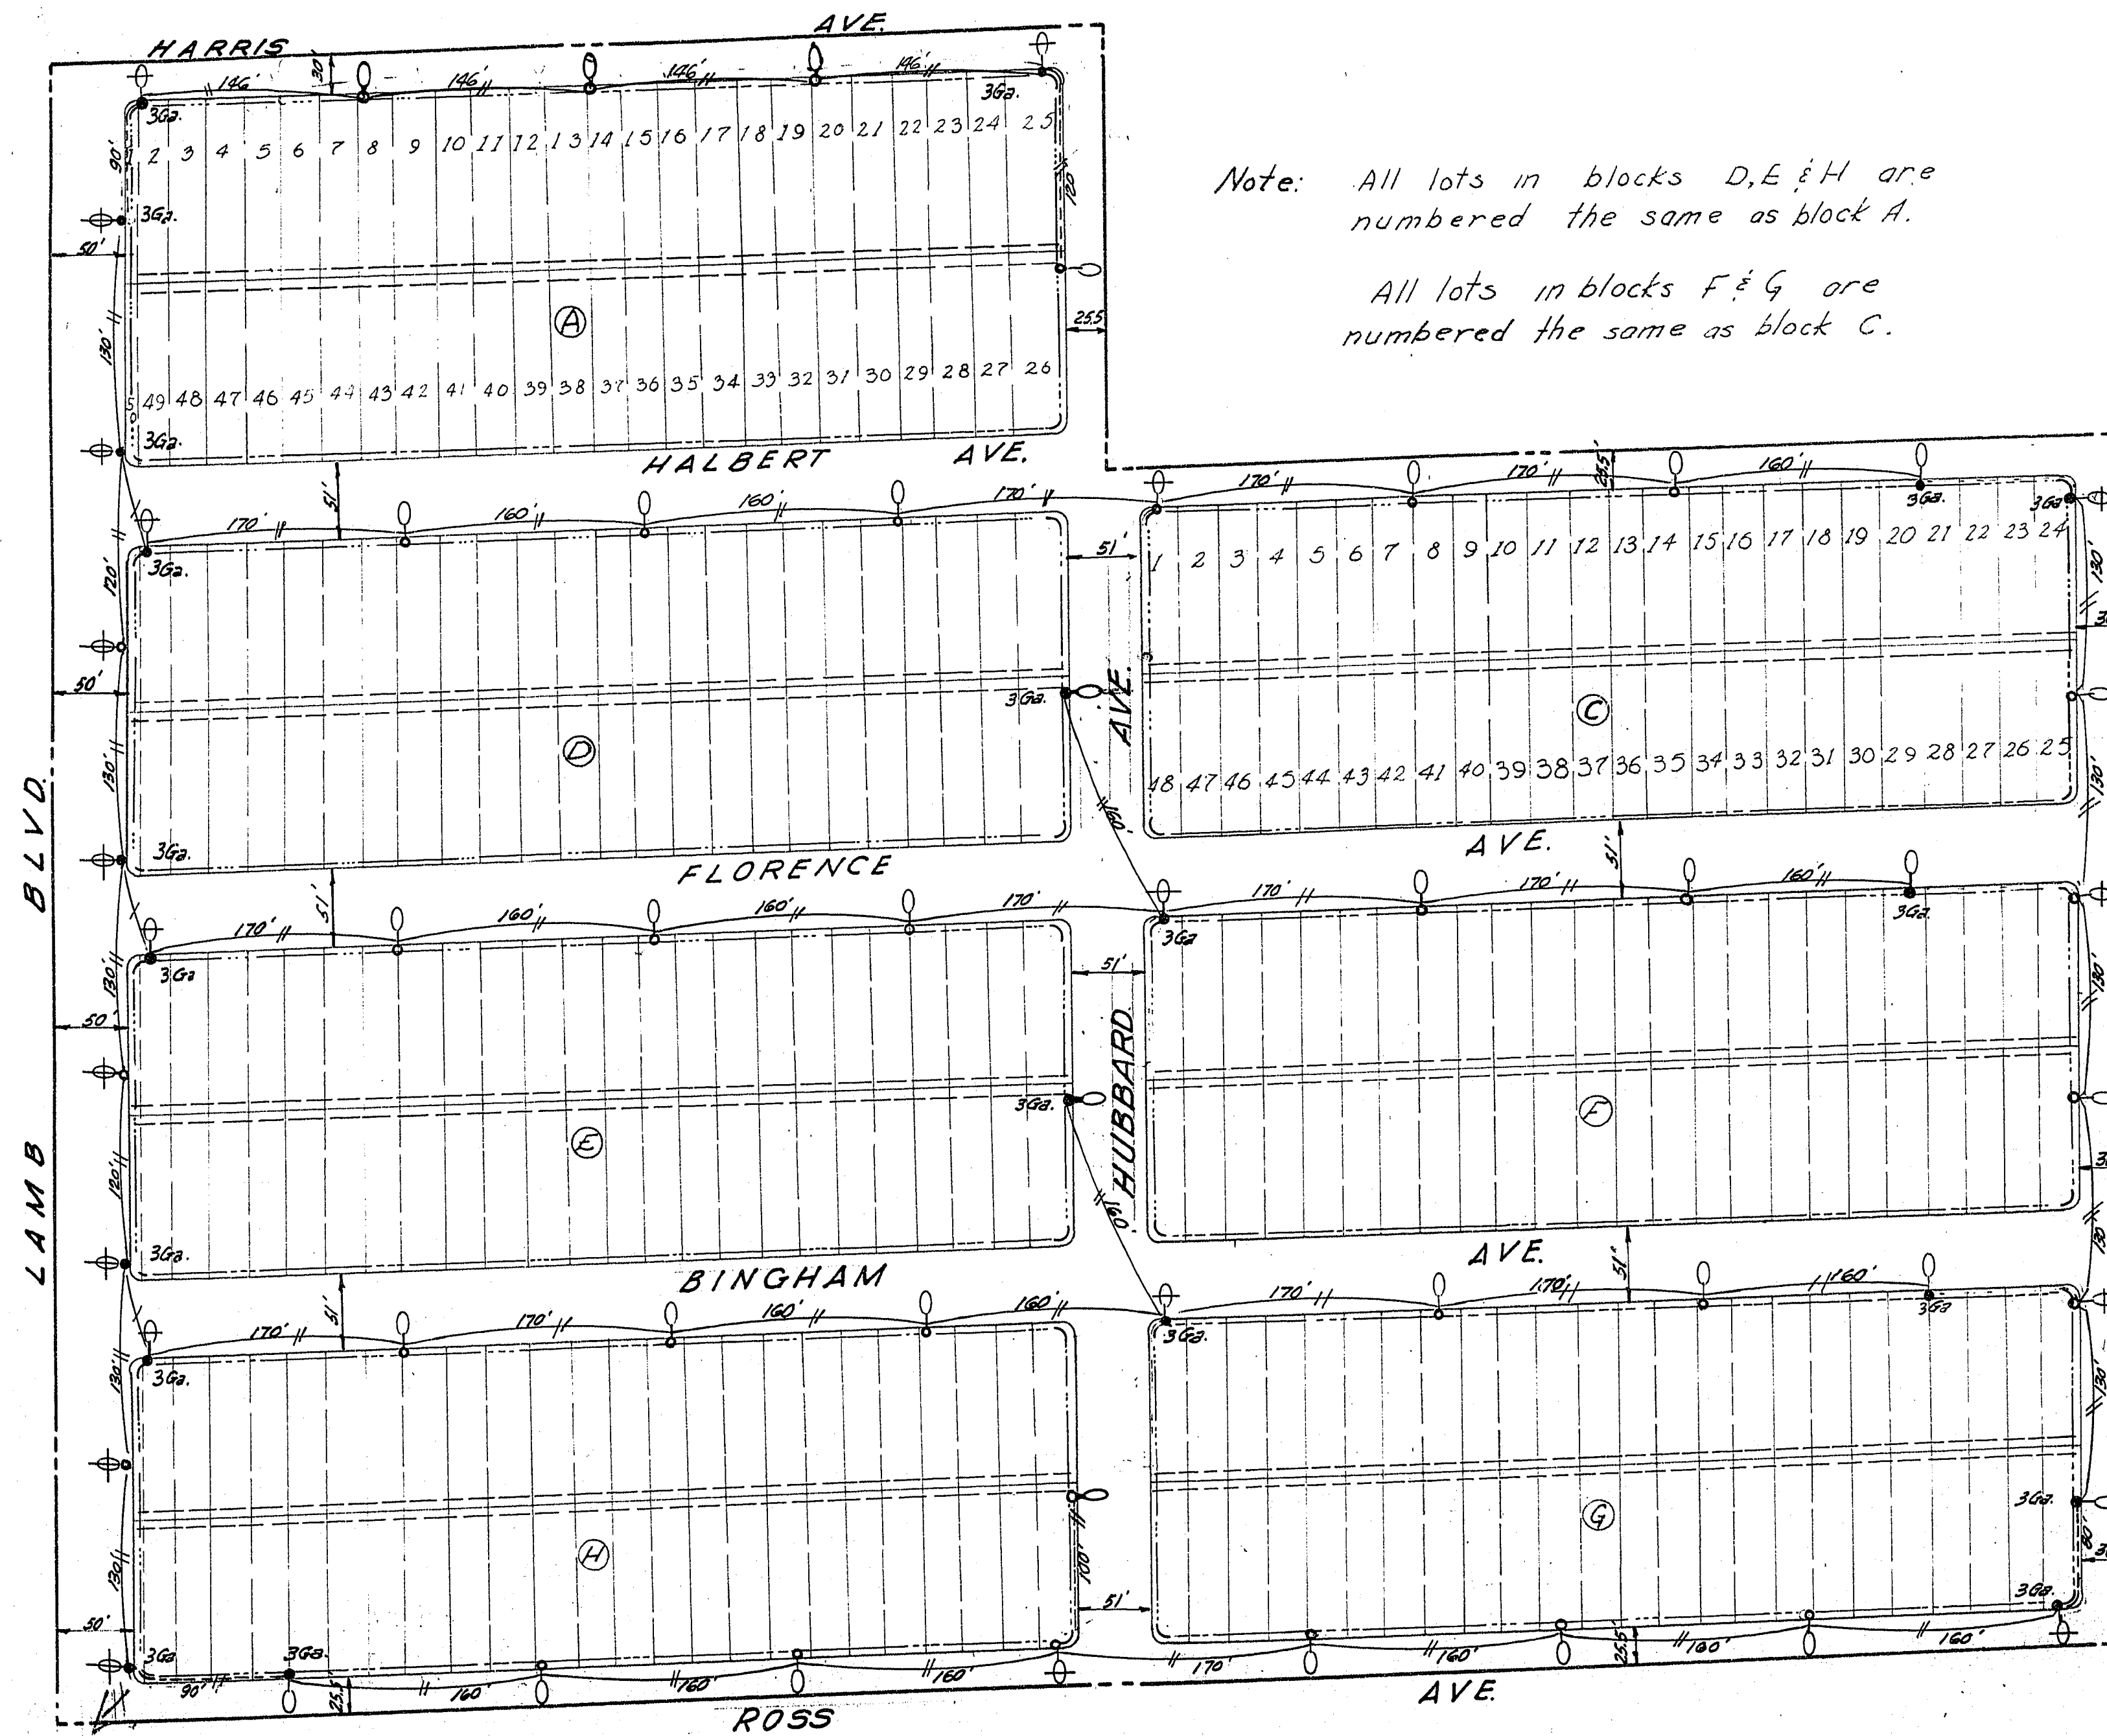

Note: All lots in blocks D, E & H are numbered the same as block A.

All lots in blocks F & G are numbered the same as block C.

LEGEND	
	8 ea.
	13 ea.
	34 ea.
	21 ea.
	34 ea.

APPROVED BY: *Richard Thomas*
NEVADA POWER CO.

9-25-63
DATE

APPROVED BY: *G. F. Bessant*
CITY ELECTRICIAN

12-9-63
DATE

R. F. Lane 12-9-63

QUANTITIES	
ITEM	AMOUNT
3 GA. LIGHT STANDARDS	21EA
11 " " " "	34EA
175 WATT MERC VAP LUMINAIRES	34EA
250 " " " "	13EA
400 " " " "	8EA

Submitted By: <i>Victor G. Krametbauer</i> Victor G. Krametbauer Nevada Cert. RCE 154	Boulder Heights Addition Street Lighting Layout
Drawn By: <i>R. F. Lane</i>	Checked By: <i>R. F. Lane</i>
Scale: 1" = 80'	14

51-6-63 2074-980-1