


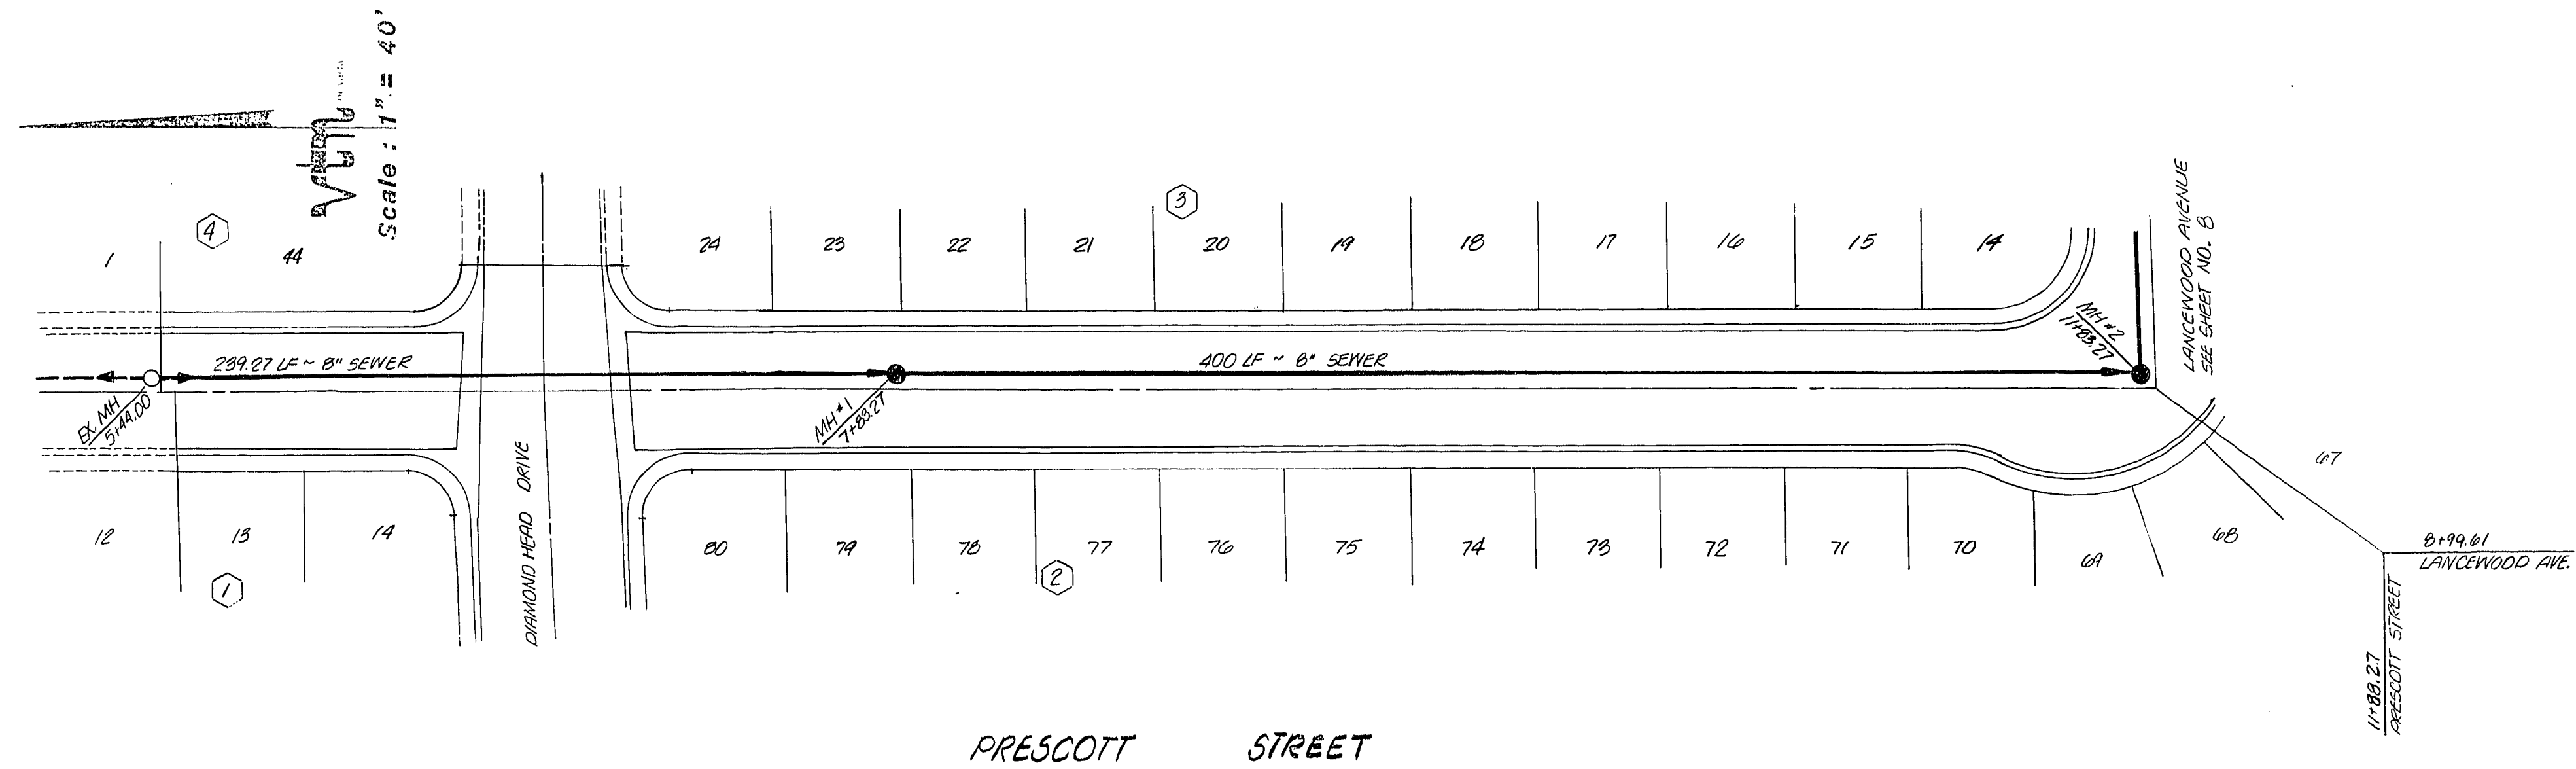

# APPROVALS

*[Signature]* 2-17-83  
CITY OF LAS VEGAS CITY ENGINEER DATE

*[Signature]* 4/6/83  
CITY OF LAS VEGAS QUALITY CONTROL DATE


\_\_\_\_\_  
CITY OF LAS VEGAS SANITARY ENGINEER DATE

TITLE  
**PRESCOTT STREET  
SEWER PLAN AND PROFILE**

PROJECT  
**CEDAR CREEK PARK  
UNIT 4**

WO NO. 3032-4  
BY VEG  
DATE DEC, 1982  
SCALE HORIZ. 1"=40'  
VERT. 1"=4'

SHEET  
**7**  
OF 11 SHEETS

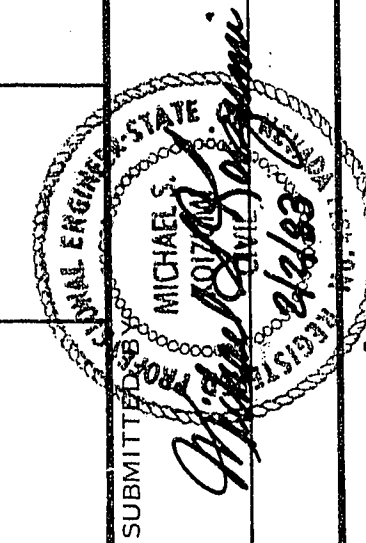

neveda  
**VTM**

CONSULTING ENGINEERS • PLANNERS  
2800 WEST SAHARA AVENUE  
LAS VEGAS, NEVADA 89102  
PHONE (702) 873-7550

