


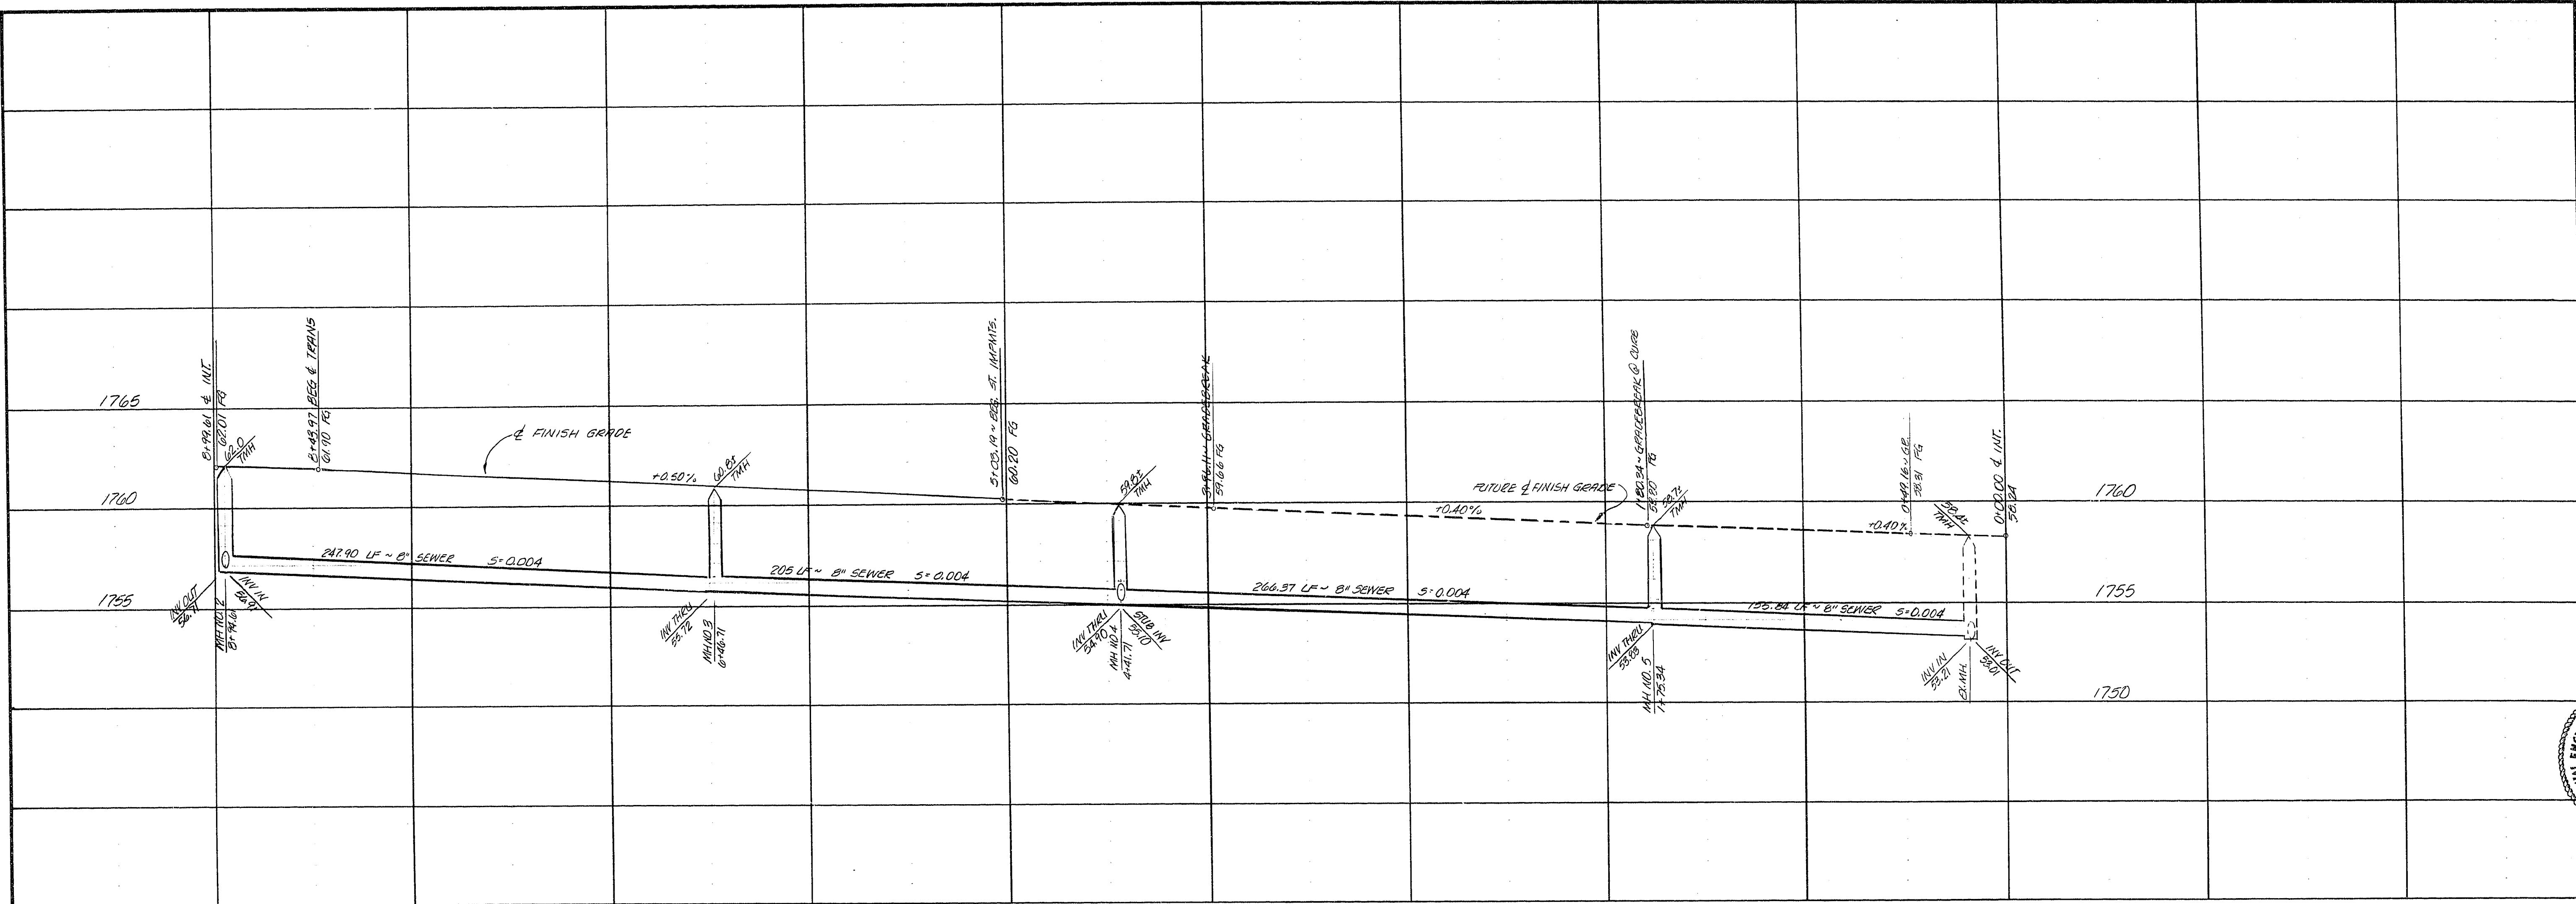

REV	DATE	BY	REVISION

DATE	
------	--

CONSULTING ENGINEERS	PLANNERS
2800 WEST SAHARA AVENUE	BUILDING 4 SUITE B
LAS VEGAS, NEVADA 89102	PHONE (702) 873-7550

SUBMITTED: *[Signature]*
 PROFESSIONAL ENGINEER
 STATE OF NEVADA
 NO. 10,131

LANCEWOOD AVENUE

SEWER PLAN AND PROFILE

CEDAR CREEK PARK

UNIT 4

WO NO. 3032-4

BY VEB

DATE DEC. 1982


SCALE VERT. 1"=4'

HORIZ. 1"=40'

SHEET

8

OF 11 SHEETS

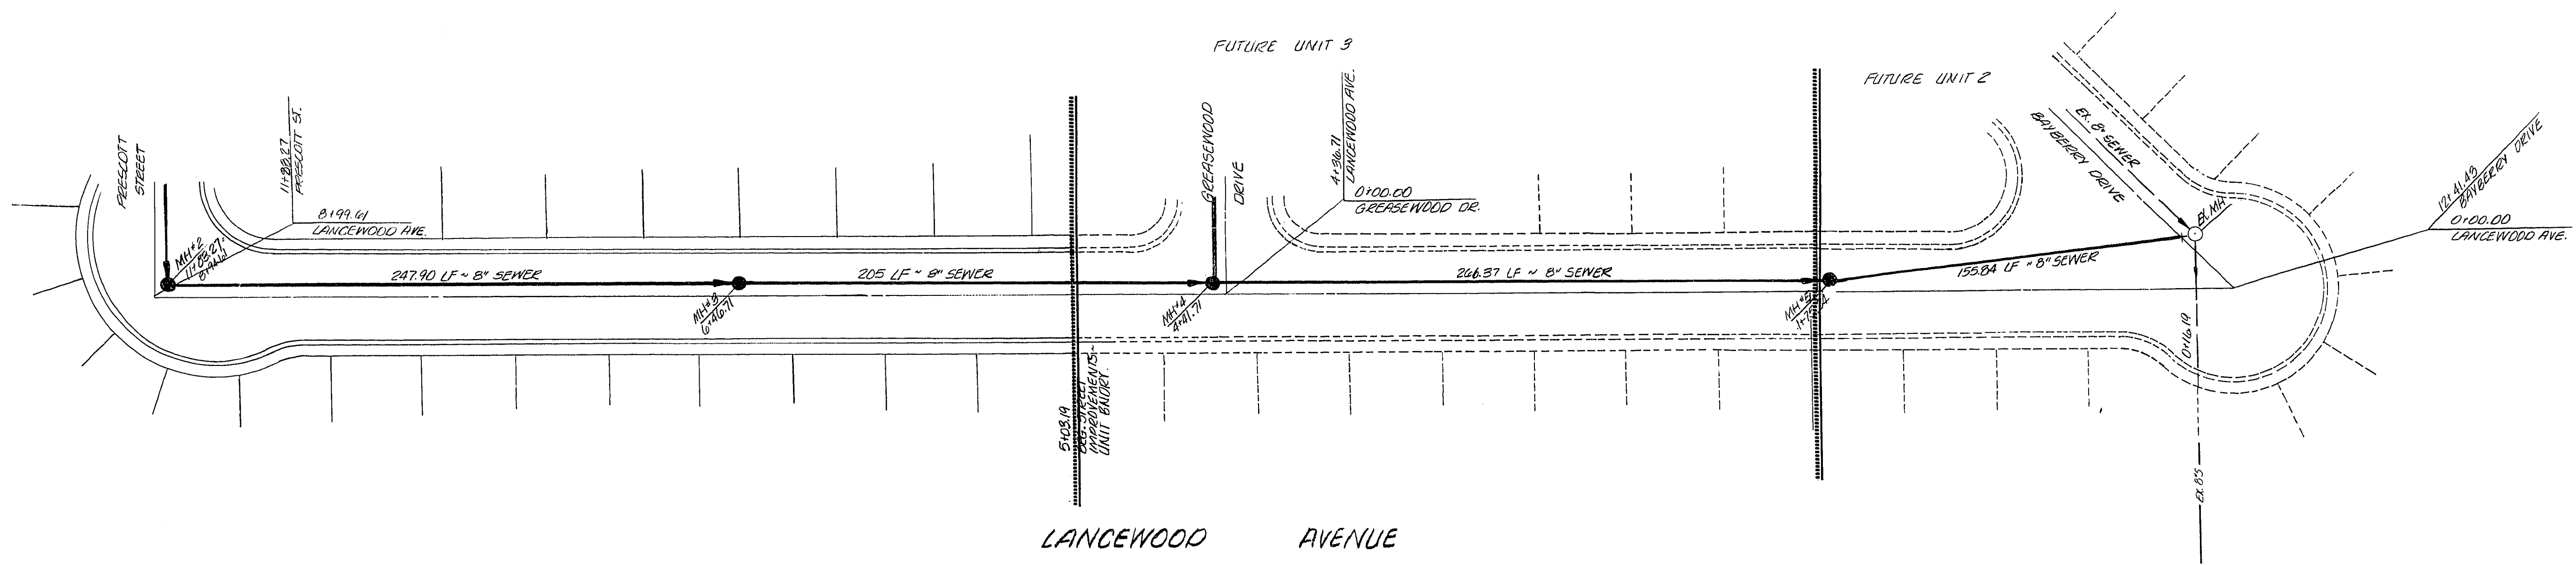

APPROVALS

[Signature] 2-11-83
 CITY OF LAS VEGAS CITY ENGINEER DATE

[Signature] 2/16/83
 CITY OF LAS VEGAS SANITARY ENGINEER DATE

[Signature] 2/16/83
 CITY OF LAS VEGAS QUALITY CONTROL DATE

28-6-50 3078-1020-4