



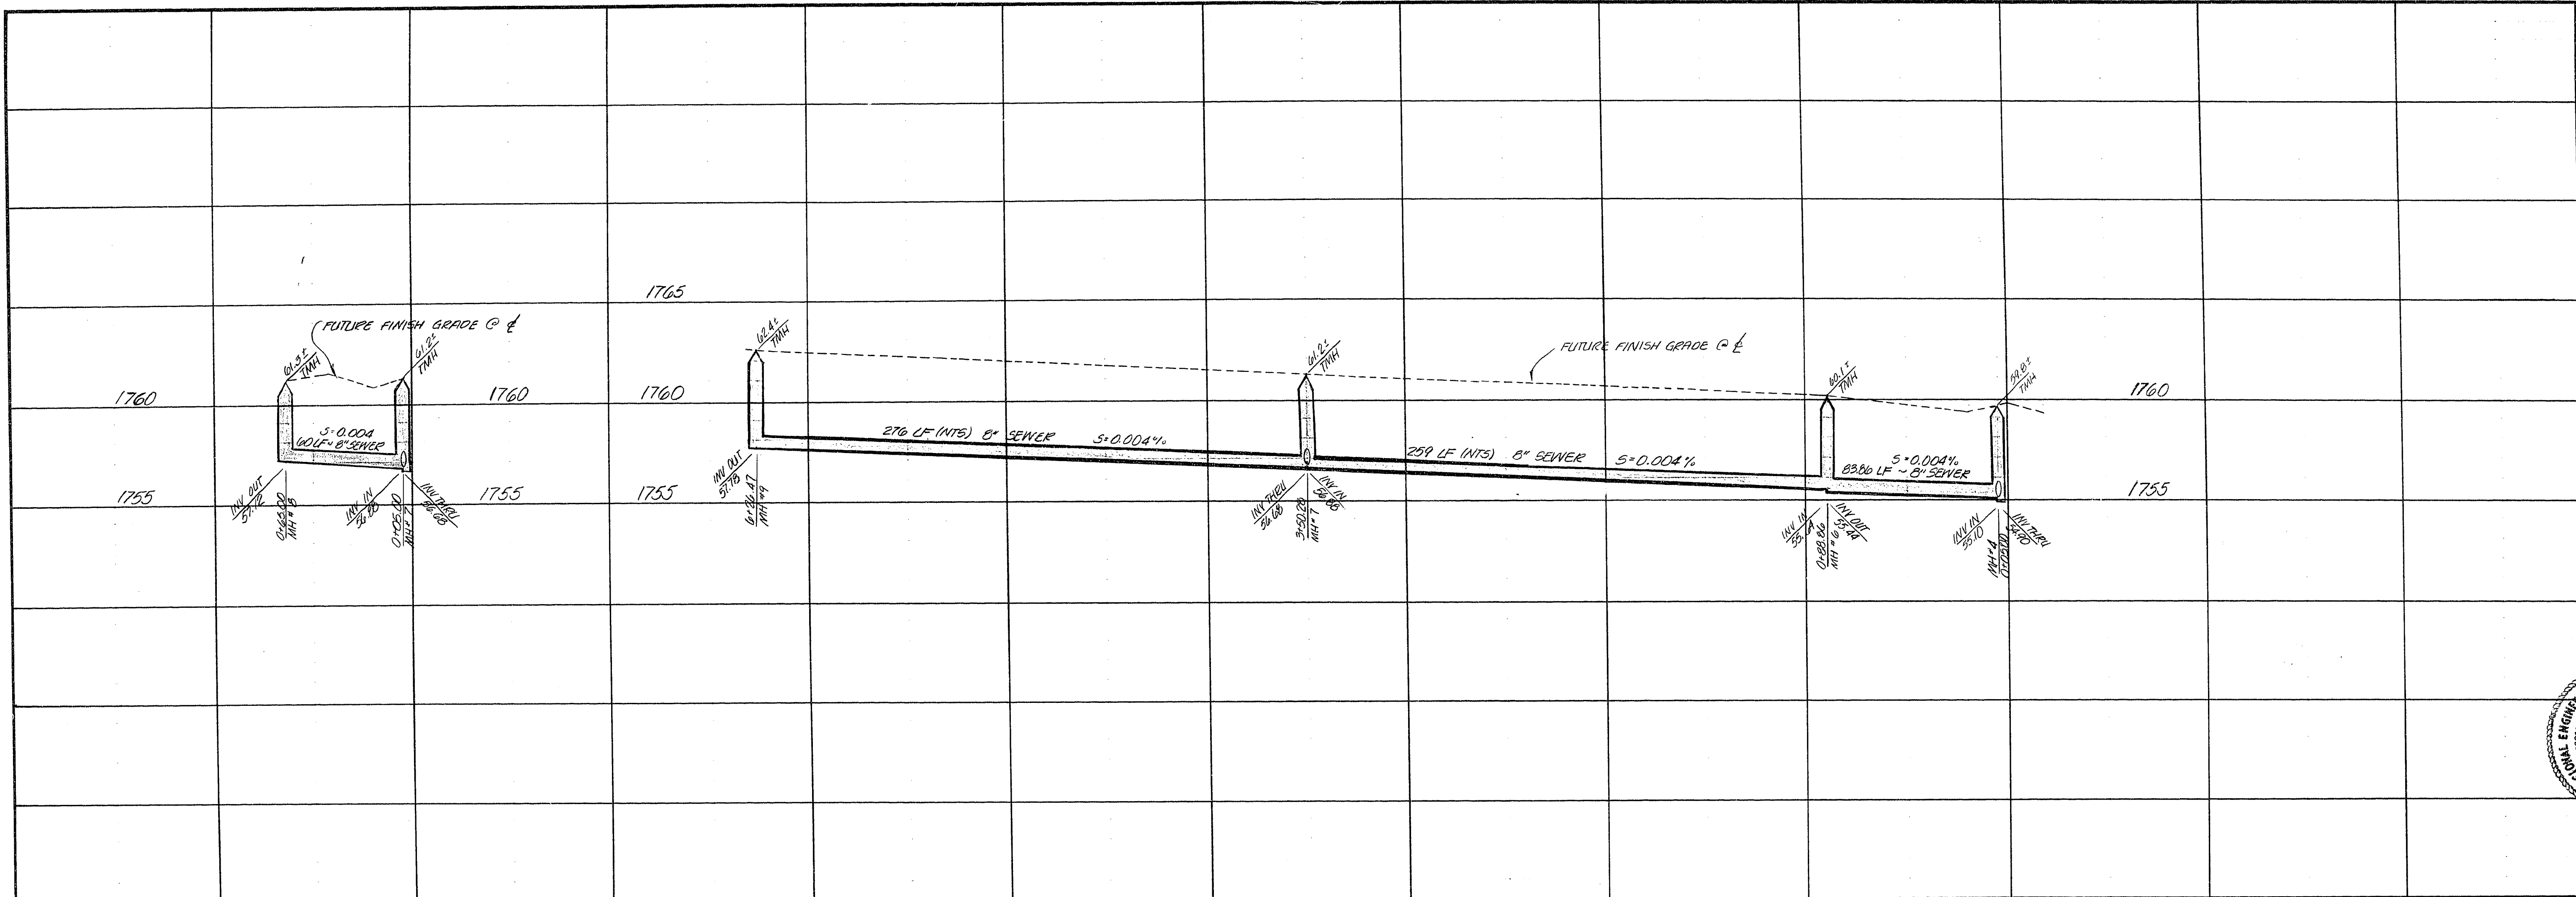

REV	DATE	BY	REVISION

SUBMITTED	DATE


CONSULTING ENGINEERS	PLANNERS
2800 WEST SAHARA AVENUE	BUILDING 4 SUITE B
LAS VEGAS, NEVADA 89102	PHONE (702) 873-7550

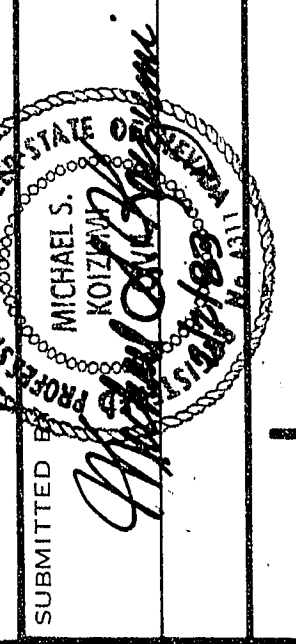

VTM nevada

TITLE	GREASEWOOD DRIVE
PROJECT	SEWER PLAN AND PROFILE
PROJECT	CEDAR CREEK PARK UNIT 4

WO NO.	9032-4
BY	VEB
DATE	DEC. 1982
SCALE	AS SHOWN - 1" = 40'
SHEET	9
OF 11 SHEETS	

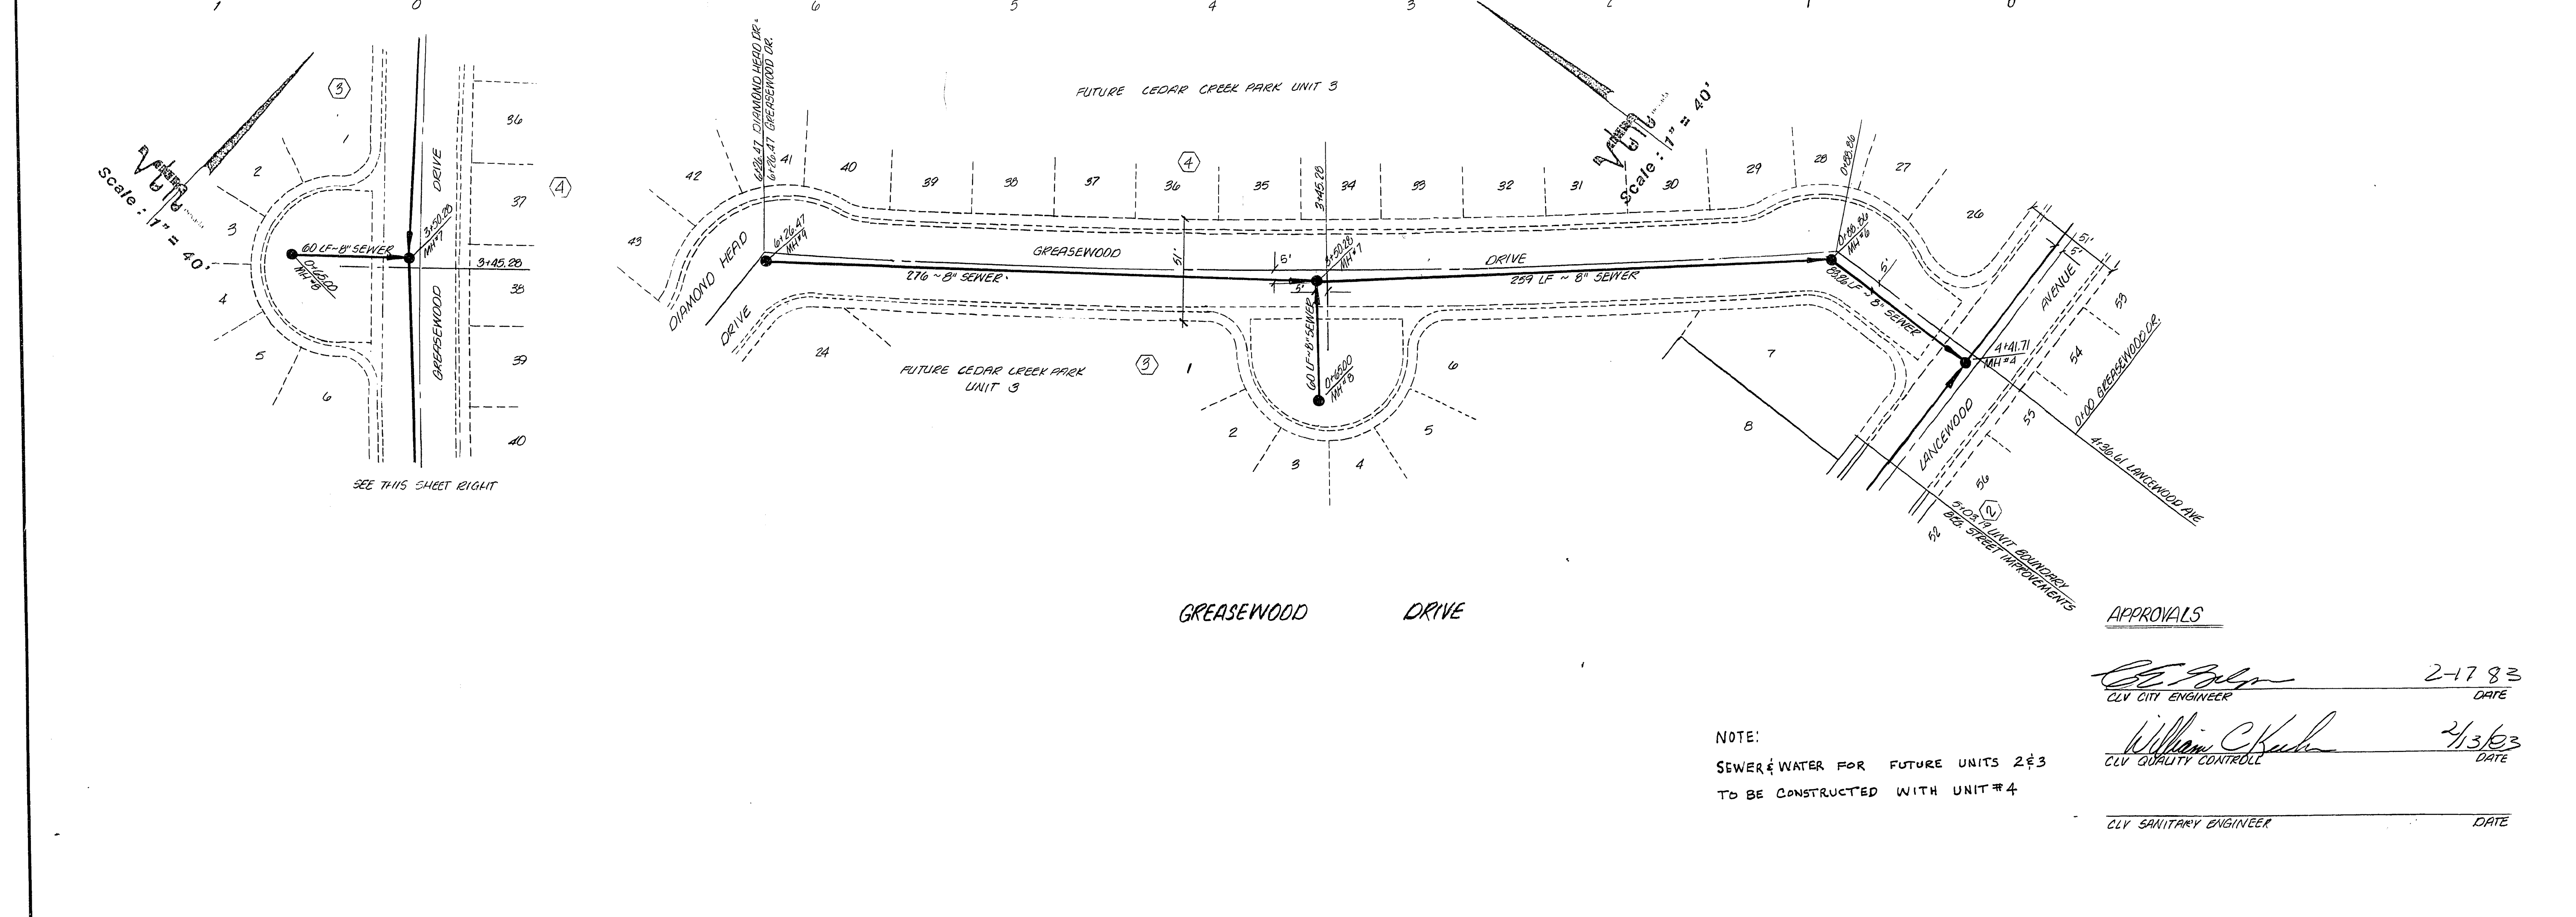

NOTE:
SEWER & WATER FOR FUTURE UNITS 2 & 3
TO BE CONSTRUCTED WITH UNIT #4

APPROVALS

CE Kozlowski 2-17-83
CLV CITY ENGINEER DATE

William C. Kuhn 2/13/83
CLV QUALITY CONTROL DATE

CLV SANITARY ENGINEER DATE

3078-1020-4