

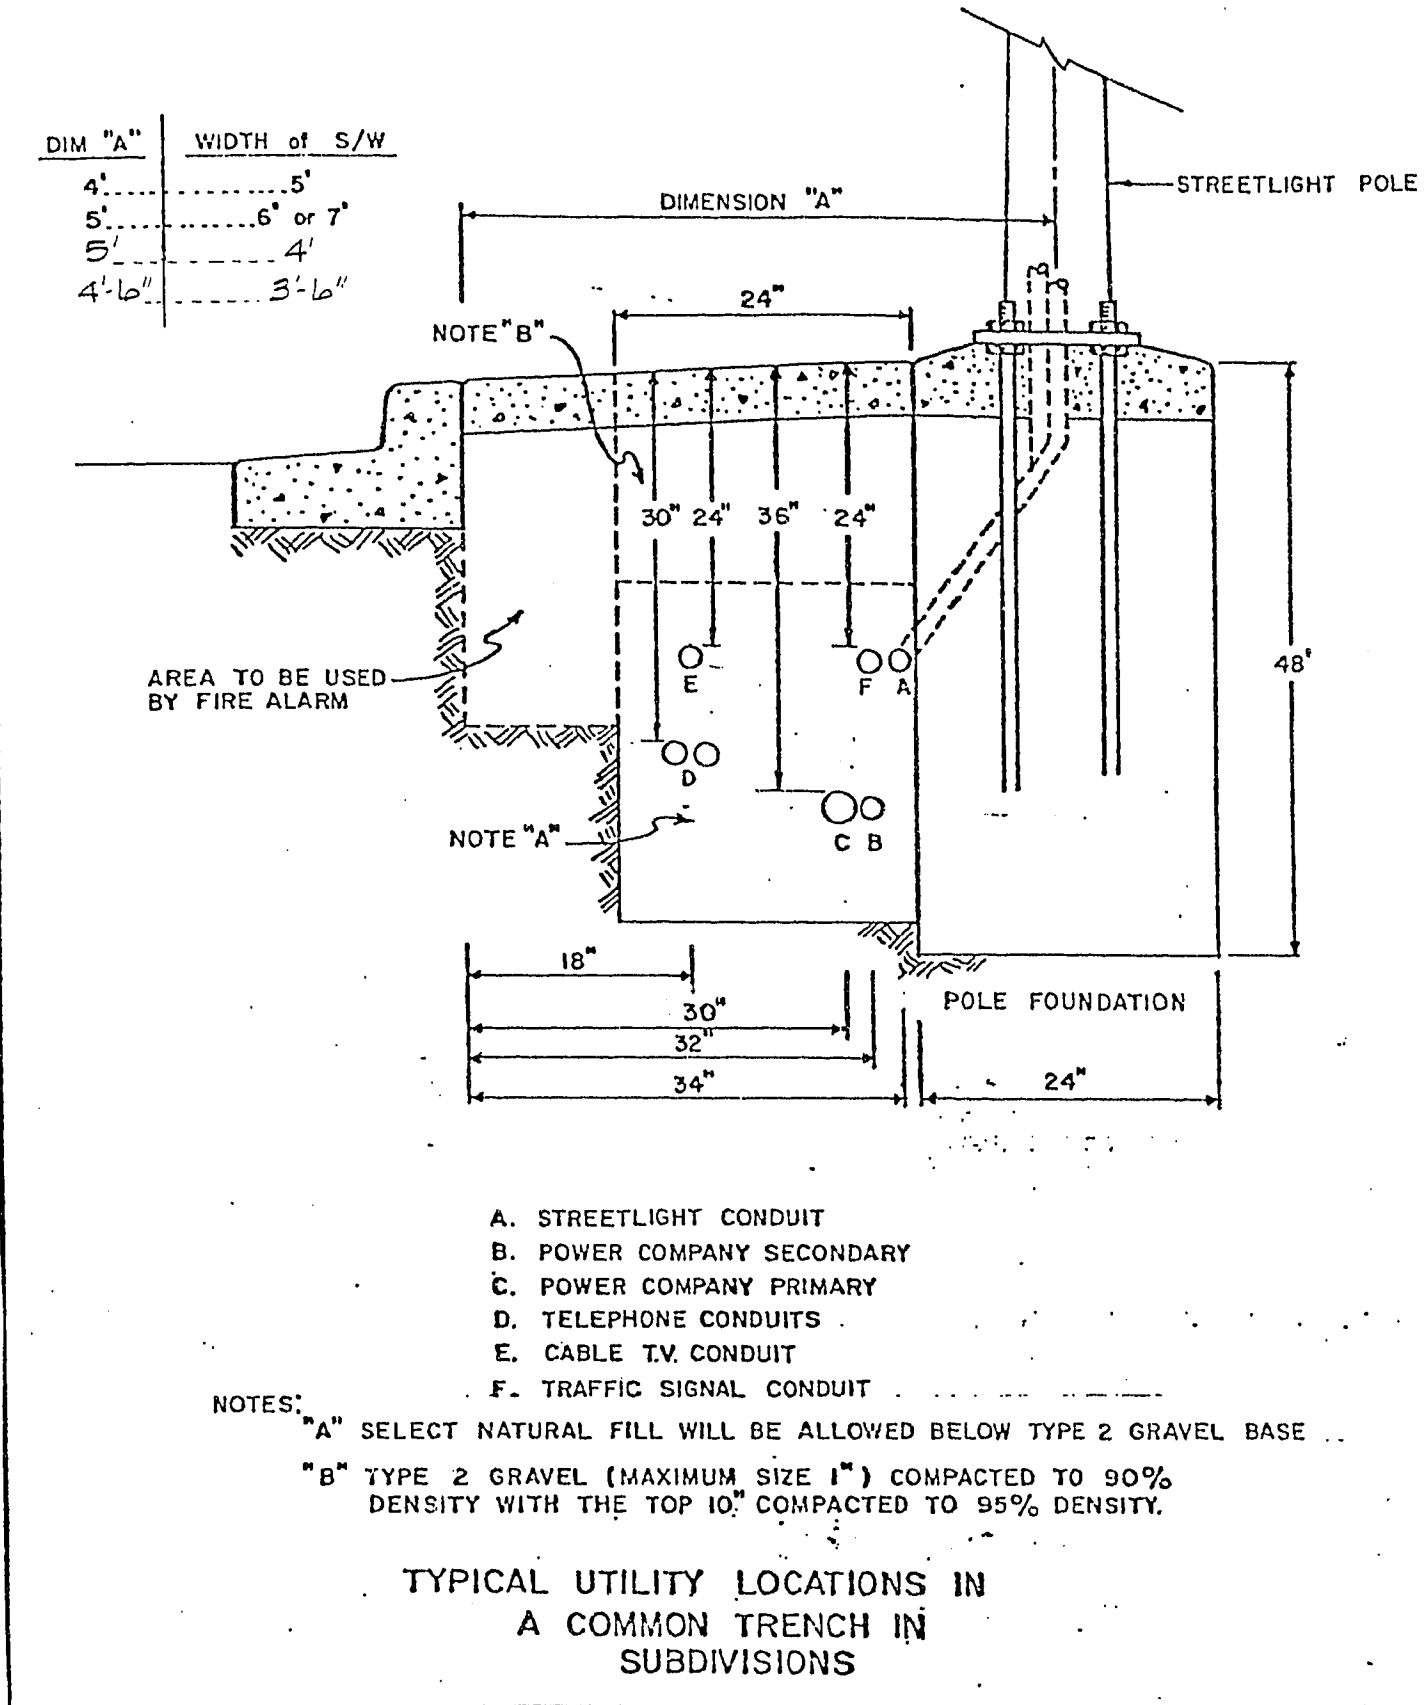


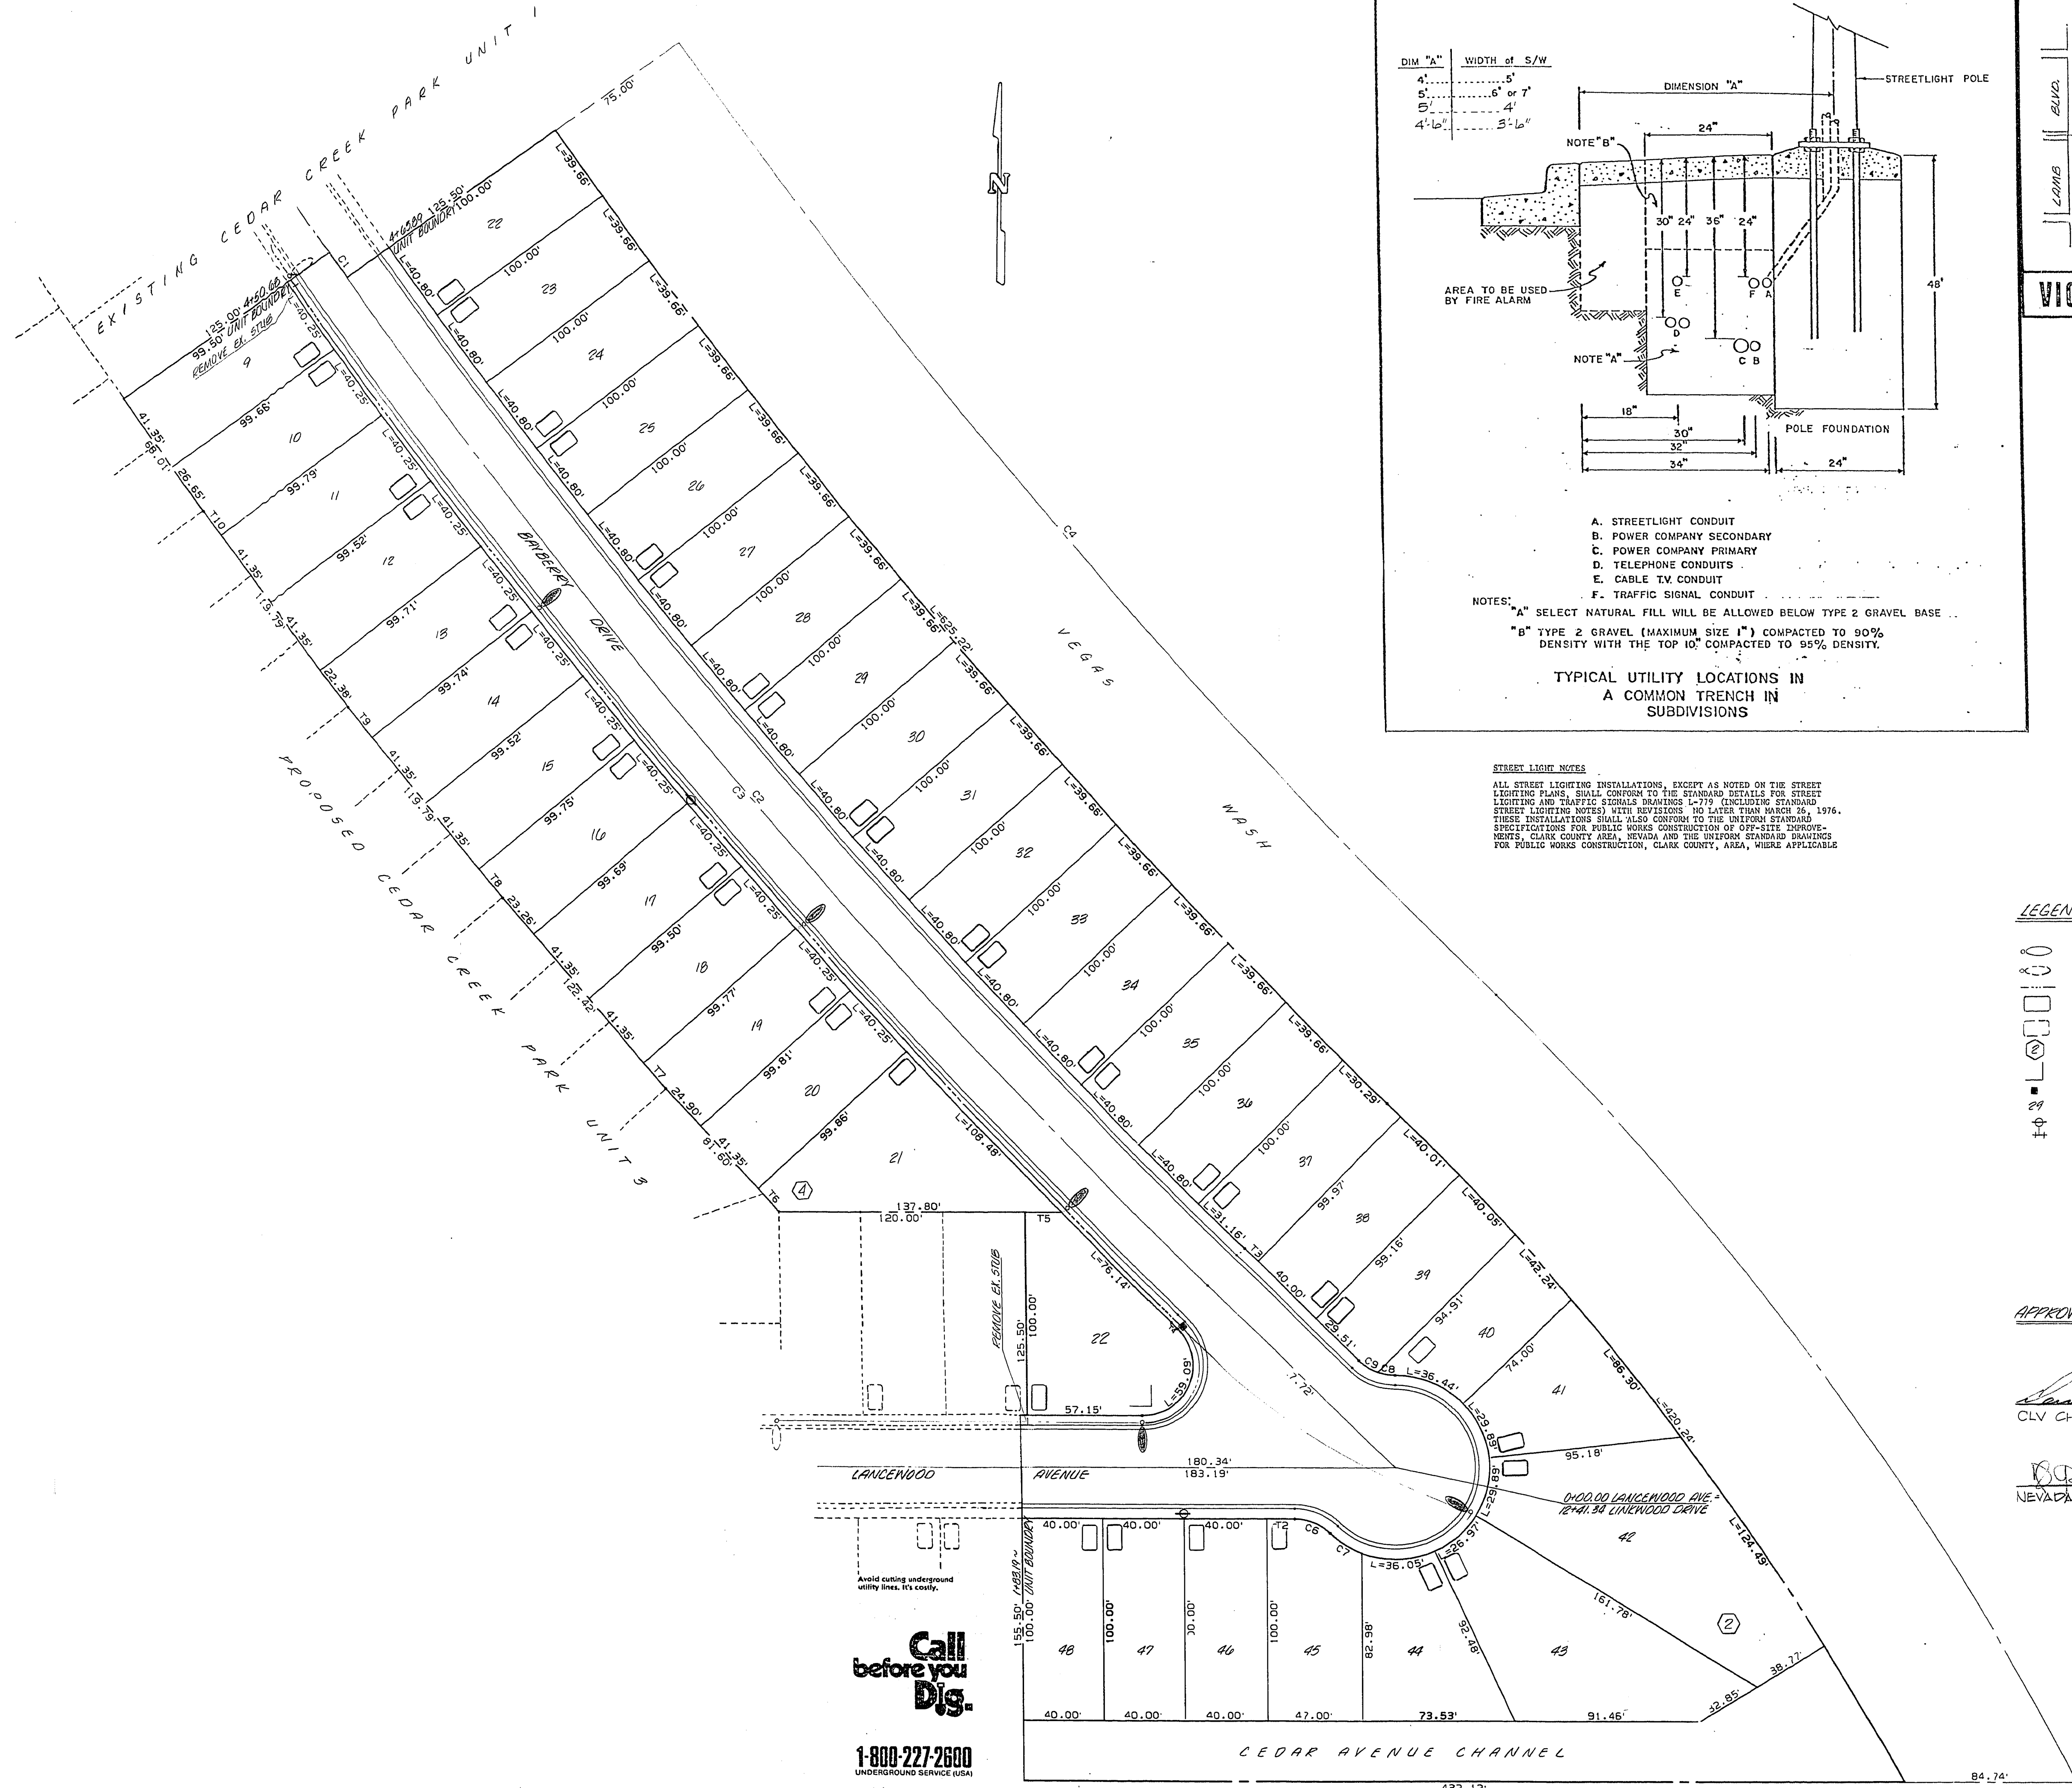

STREET LIGHT NOTES
ALL STREET LIGHTING INSTALLATIONS, EXCEPT AS NOTED ON THE STREET LIGHTING PLANS, SHALL CONFORM TO THE STANDARD DETAILS FOR STREET LIGHTING AND TRAFFIC SIGNALS DRAWINGS L-775 (INCLUDING STANDARD STREET LIGHTING NOTES) WITH REVISIONS, NO LATER THAN MARCH 16, 1976. THESE INSTALLATIONS SHALL ALSO CONFORM TO THE UNIFORM STANDARD SPECIFICATIONS FOR PUBLIC WORKS CONSTRUCTION OF OFF-SITE IMPROVEMENTS, CLARK COUNTY AREA, NEVADA AND THE UNIFORM STANDARD DRAWINGS FOR PUBLIC WORKS CONSTRUCTION, CLARK COUNTY, AREA, WHERE APPLICABLE.

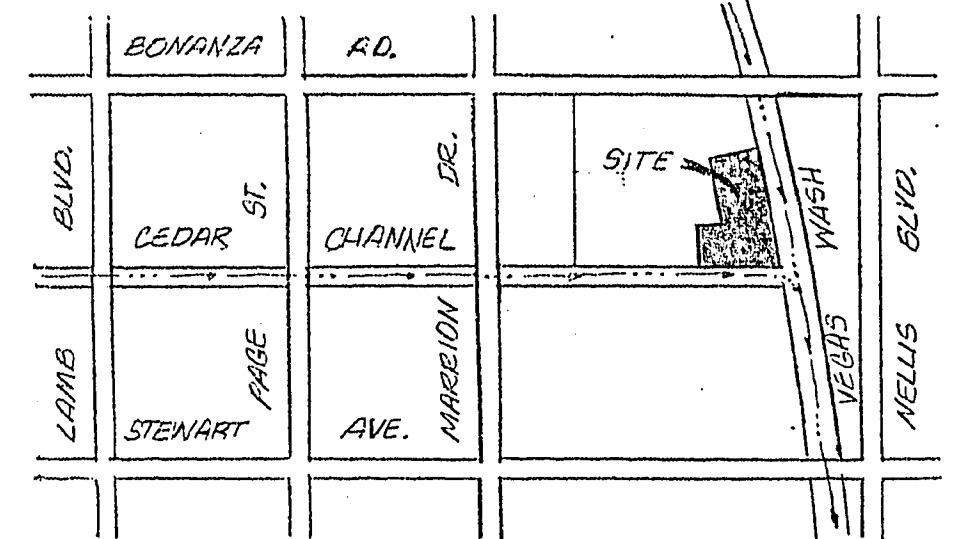

VICINITY MAP

LEGEND AND QUANTITIES ESTIMATE

	100 WATT HPS LUMINAIRE 11 GA POLE	5 EA.
	EXISTING STREET LIGHT	
	1 1/4\"/>	980 LF
	DRIVEWAY LOCATION	
	EXISTING DRIVEWAY	
	BLOCK NUMBER	
	6\"/>	1 EA
	3/8\"/>	1 EA
	LOT NUMBER	
	24\"/>	
	24\"/>	

APPROVALS

James R. [Signature] 11/21/83
CLV CHIEF, LAND DEV. & FLOOD CONTROL DATE
[Signature] 9-22-83
NEVADA POWER COMPANY DATE

MASTER STREET LIGHT
STREET SIGN AND DRIVEWAY PLAN
CEDAR CREEK PARK
UNIT 2

WO NO.	3032-2
BY	VEB
DATE	JUNE, 1983
SCALE	1"=40'

SHEET
6
OF 6 SHEETS

CONSULTING ENGINEERS • PLANNERS
2800 WEST SAHARA AVENUE BUILDING B
LAS VEGAS, NEVADA 89102 PHONE (702) 733-7550

Michael J. [Signature] 8/12/83

vtm nevada