

Call
before you
Dig.
1-800-277-2600
UNDERGROUND SERVICE DATA

BENCHMARK
BOLT & PLATE IN THE SW QUAD OF
SMOKE RANCH ROAD & TORREY PINES DRIVE
ELEVATION: 3290.35

La Riva Inc. 2-21-84
NEVADA POWER CO. DATE

LAS VEGAS VALLEY WATER DIST. DATE

P.L. Oster
C.L.V. SANITATION SUPERVISOR DATE

6-13-84
C.L.V. LAND DEVELOPMENT DATE

6-13-84
C.L.V. FIRE DEPARTMENT DATE

DATE

SHEET

12

OF 14 SHEETS

MASTER UTILITY PLAN

CHARLESTON HEIGHTS TRACT 51-J

WO NO 3311



BY SCD

DATE JAN. '88


SCALE 1"=20'

CONSULTING ENGINEERS • PLANNERS
2300 PASEO DEL PRADO BUILDING A SUITE 100
LAS VEGAS, NEVADA 89102 PHONE (702) 873-7550


nevada
vtn

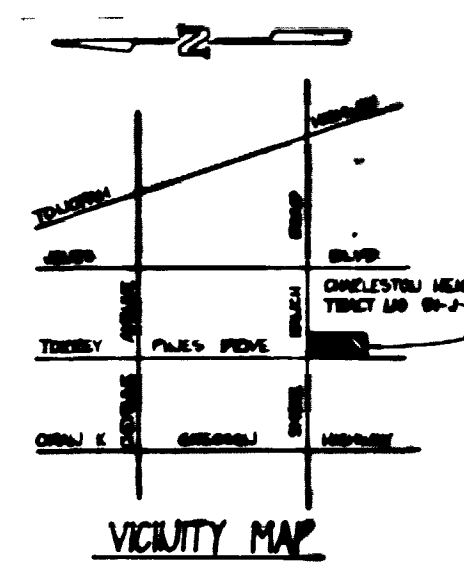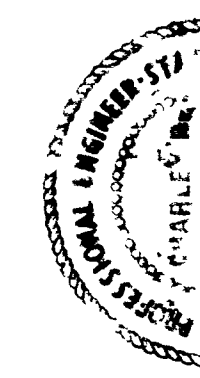

SEE SHEET NO. 13

 

STATION	ELEVATION	STATION	ELEVATION
1+00	3290.35	1+50	3290.35
1+25	3290.35	1+75	3290.35
1+50	3290.35	2+00	3290.35
1+75	3290.35	2+25	3290.35
2+00	3290.35	2+50	3290.35
2+25	3290.35	2+75	3290.35
2+50	3290.35	3+00	3290.35
2+75	3290.35	3+25	3290.35
3+00	3290.35	3+50	3290.35
3+25	3290.35	3+75	3290.35
3+50	3290.35	4+00	3290.35
3+75	3290.35	4+25	3290.35
4+00	3290.35	4+50	3290.35
4+25	3290.35	4+75	3290.35
4+50	3290.35	5+00	3290.35
4+75	3290.35	5+25	3290.35
5+00	3290.35	5+50	3290.35
5+25	3290.35	5+75	3290.35
5+50	3290.35	6+00	3290.35
5+75	3290.35	6+25	3290.35
6+00	3290.35	6+50	3290.35
6+25	3290.35	6+75	3290.35
6+50	3290.35	7+00	3290.35
6+75	3290.35	7+25	3290.35
7+00	3290.35	7+50	3290.35
7+25	3290.35	7+75	3290.35
7+50	3290.35	8+00	3290.35
7+75	3290.35	8+25	3290.35
8+00	3290.35	8+50	3290.35
8+25	3290.35	8+75	3290.35
8+50	3290.35	9+00	3290.35
8+75	3290.35	9+25	3290.35
9+00	3290.35	9+50	3290.35
9+25	3290.35	9+75	3290.35
9+50	3290.35	10+00	3290.35

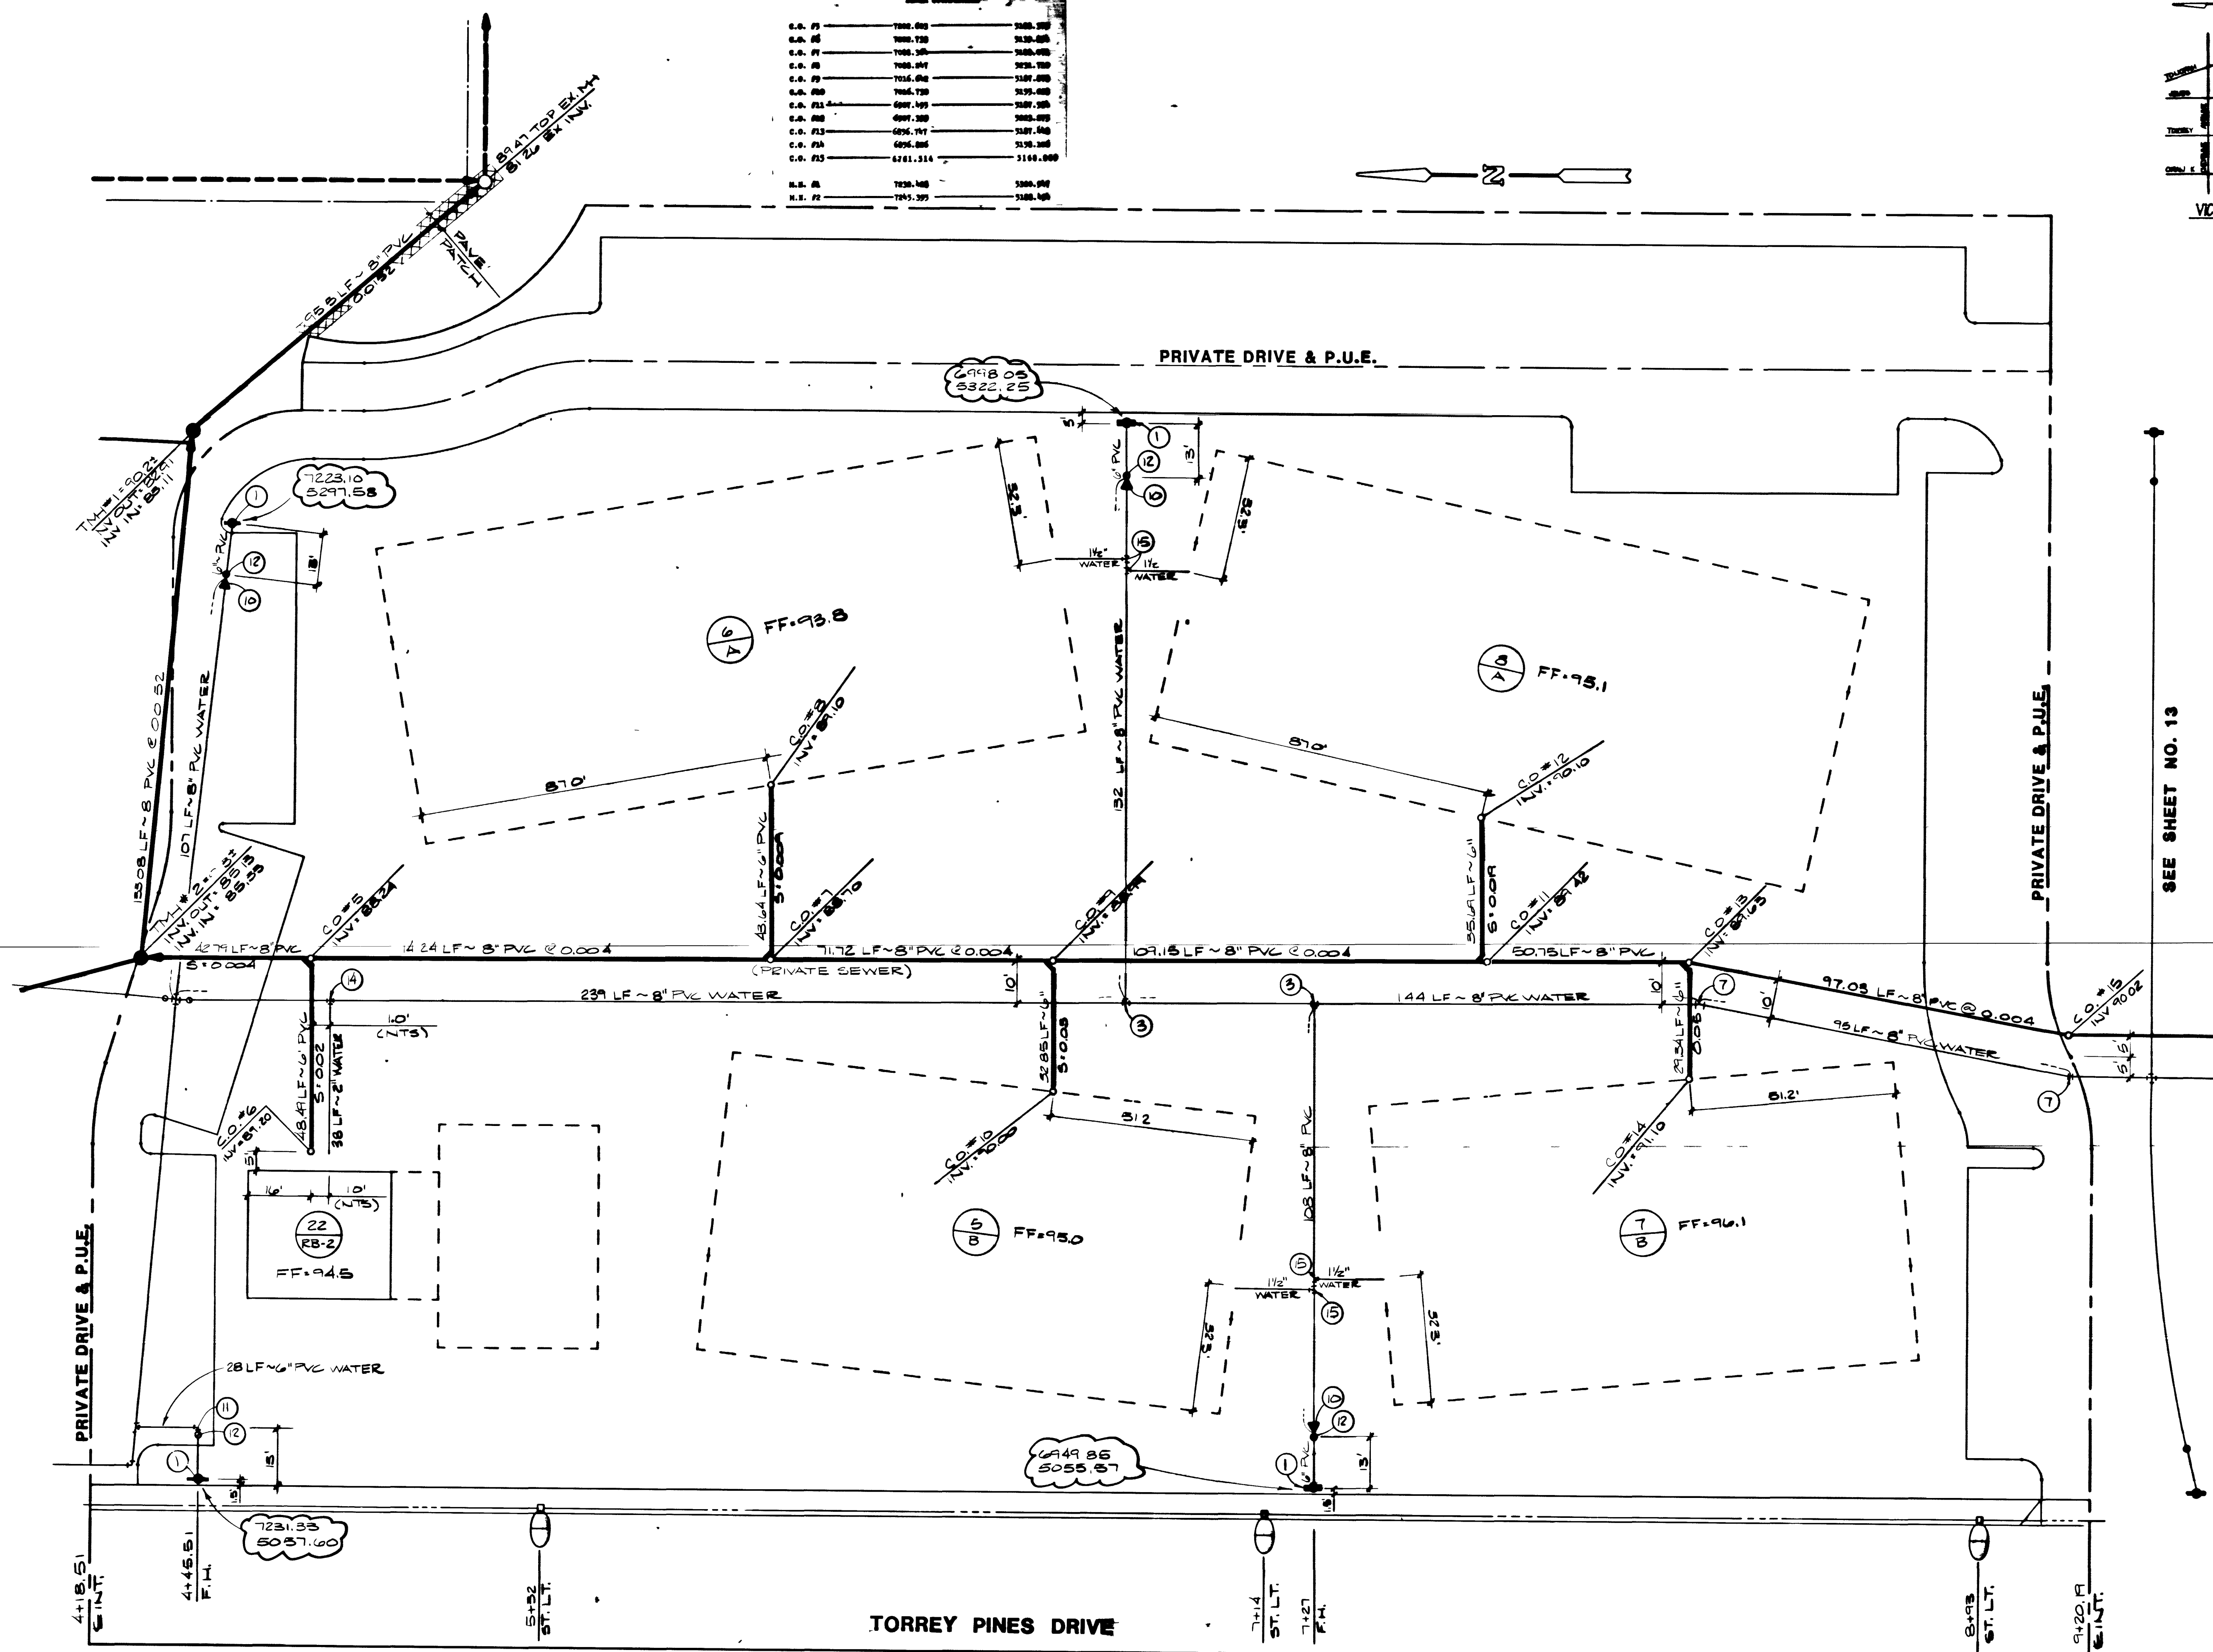

SEE SHEET NO. 11

3631

307Y-1040-51-J

