
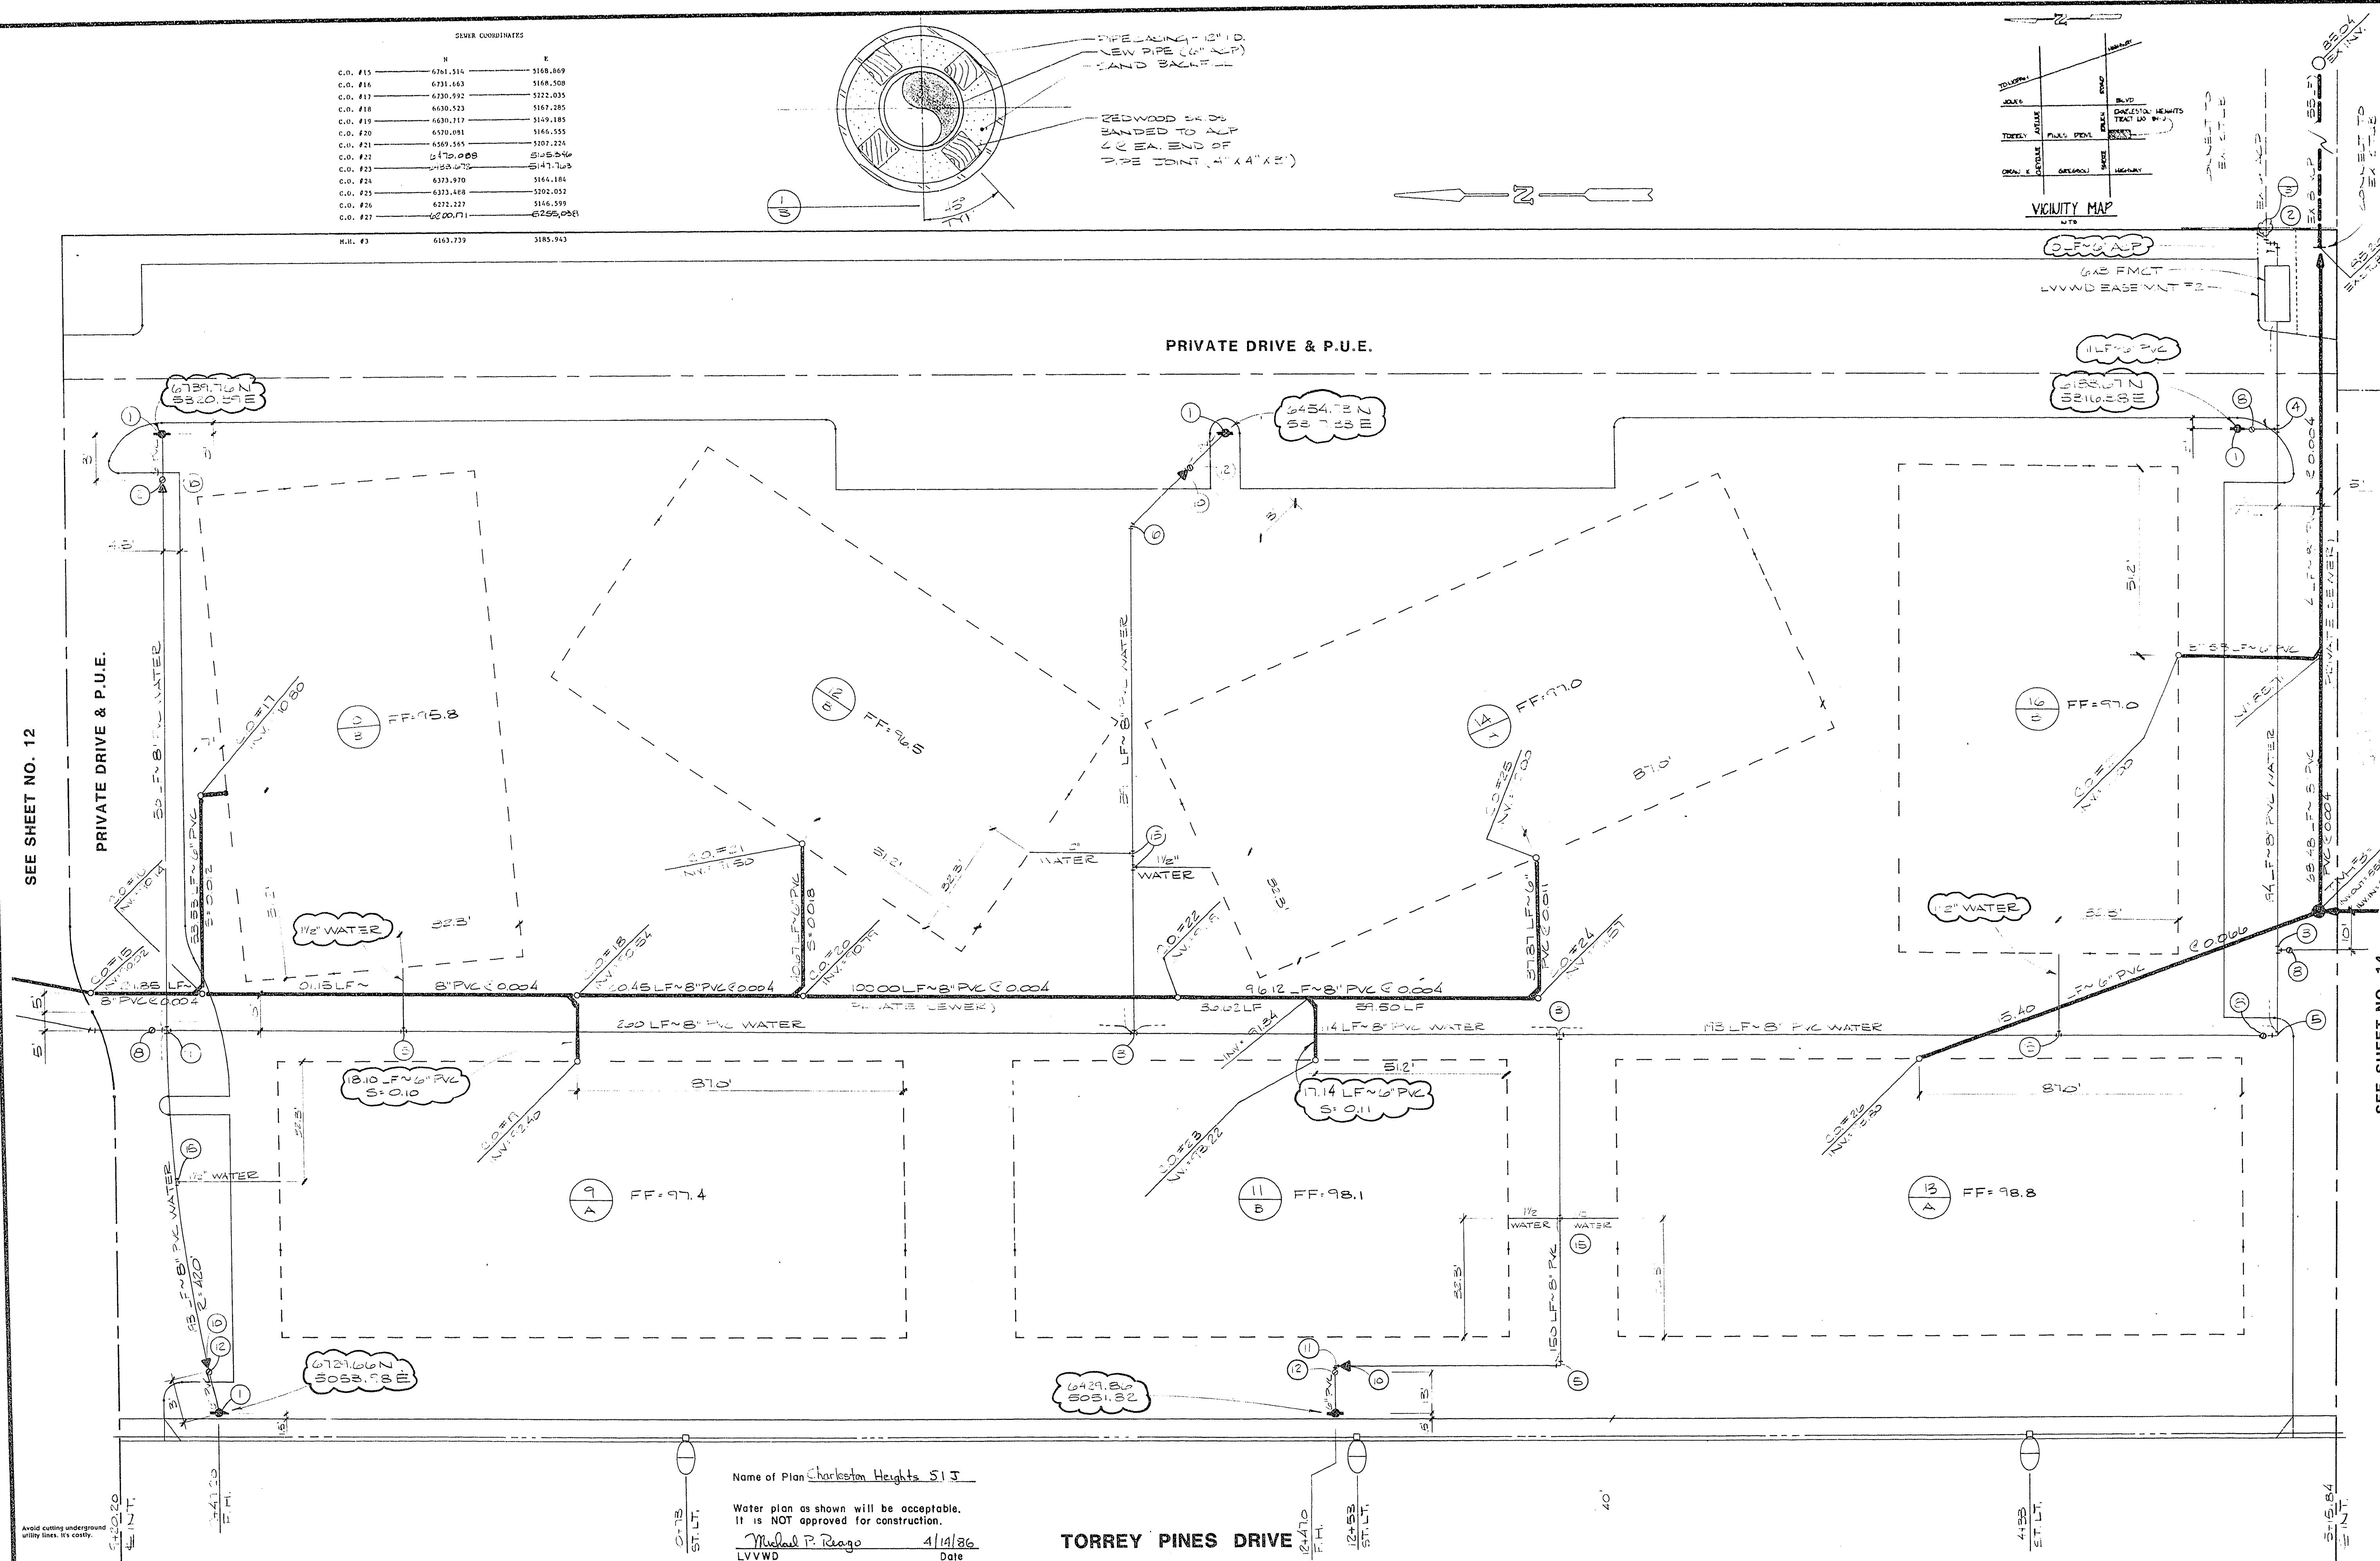
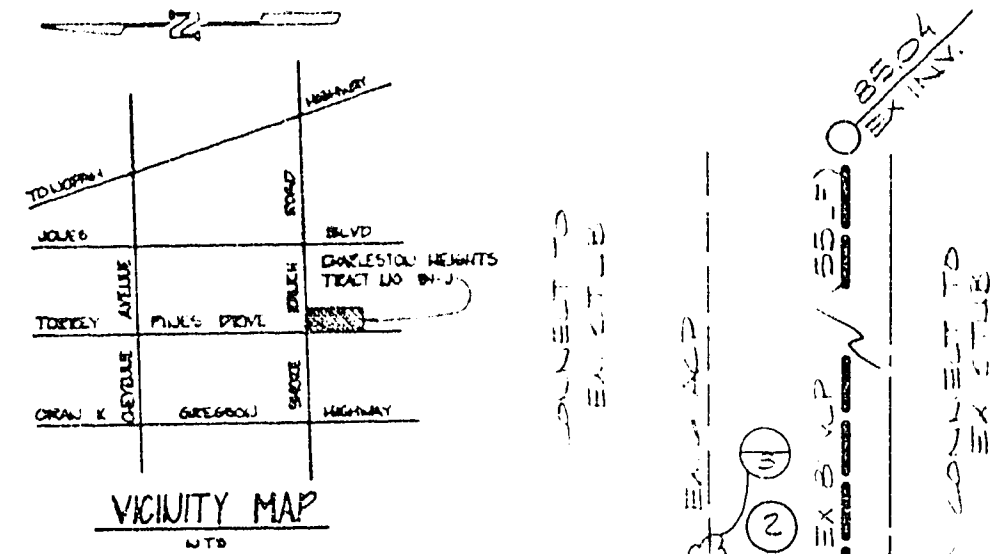


STAIR COORDINATES

C.O. #15	6731.143	5168.569
C.O. #16	6731.143	5168.569
C.O. #17	6730.992	5172.035
C.O. #18	6630.523	5167.285
C.O. #19	6630.517	5149.185
C.O. #20	6570.091	5146.555
C.O. #21	6569.945	5157.225
C.O. #22	6470.008	5147.109
C.O. #23	6470.008	5147.109
C.O. #24	6373.970	5144.184
C.O. #25	6373.408	5152.052
C.O. #26	6373.227	5146.599
C.O. #27	6200.711	5155.098

N.H. #3 6163.739 5185.943

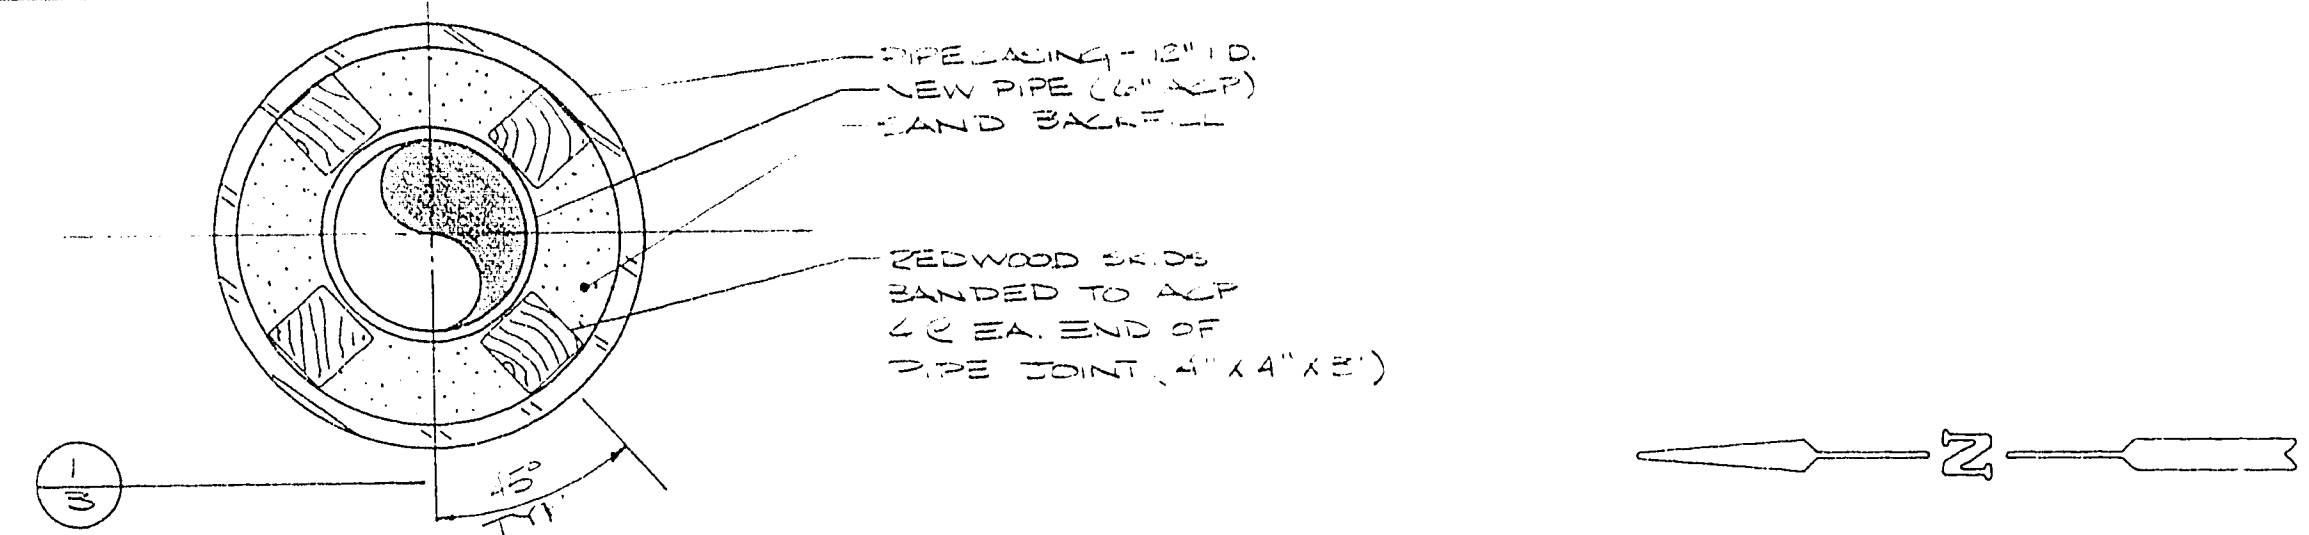

REVISION

REV	DATE	BY	REVISIONS PER C.V.
1	4-18-86	SCD	REVISED EXISTENT
2	4-18-86	SCD	REVISED EXISTENT
3	6-17-86	MAP	BUDG. NO. 6
4	7-28-86	SCD	ADDED 2 REVISIONS

PLANNERS

CONSULTING ENGINEERS • SUITE 100
2300 PASEO DEL PRADO BUILDING A
LAS VEGAS, NEVADA 89102 PHONE (702) 874-7550

Charley D. Johnson C/10/86

VTM nevada

SEE SHEET NO. 14

MASTER UTILITY PLAN

PROJECT

CHARLESTON HEIGHTS TRACT NO. 51-J

WO NO 3311

BY SCD

DATE JAN. '86

SCALE 1"=20'

SHEET

13

DATE OF 15 SHEETS

Call before you Dig.

BENCHMARK
BOLT & PLATE IN THE SW QUAD OF
SMOKE RANCH ROAD & TORREY PINES DRIVE.
ELEVATION :2290.25

1-800-227-2600
UNDERGROUND SERVICE (USA)

Name of Plan Charleston Heights S.I.J.

Water plan as shown will be acceptable.
It is NOT approved for construction.

Michael P. Reago 4/14/86 Date
LVVWD

TORREY PINES DRIVE

UNDEVELOPED

LAS VEGAS VALLEY WATER DIST. DATE 6-13-86 NEVADA POWER CO. DATE 6-13-86 C.L.V. SANITATION SUPERVISER DATE 6-13-86 C.L.V. LAND DEVELOPMENT DATE 6-13-86 C.L.V. FIRE DEPARTMENT

3074-1040-51-3