


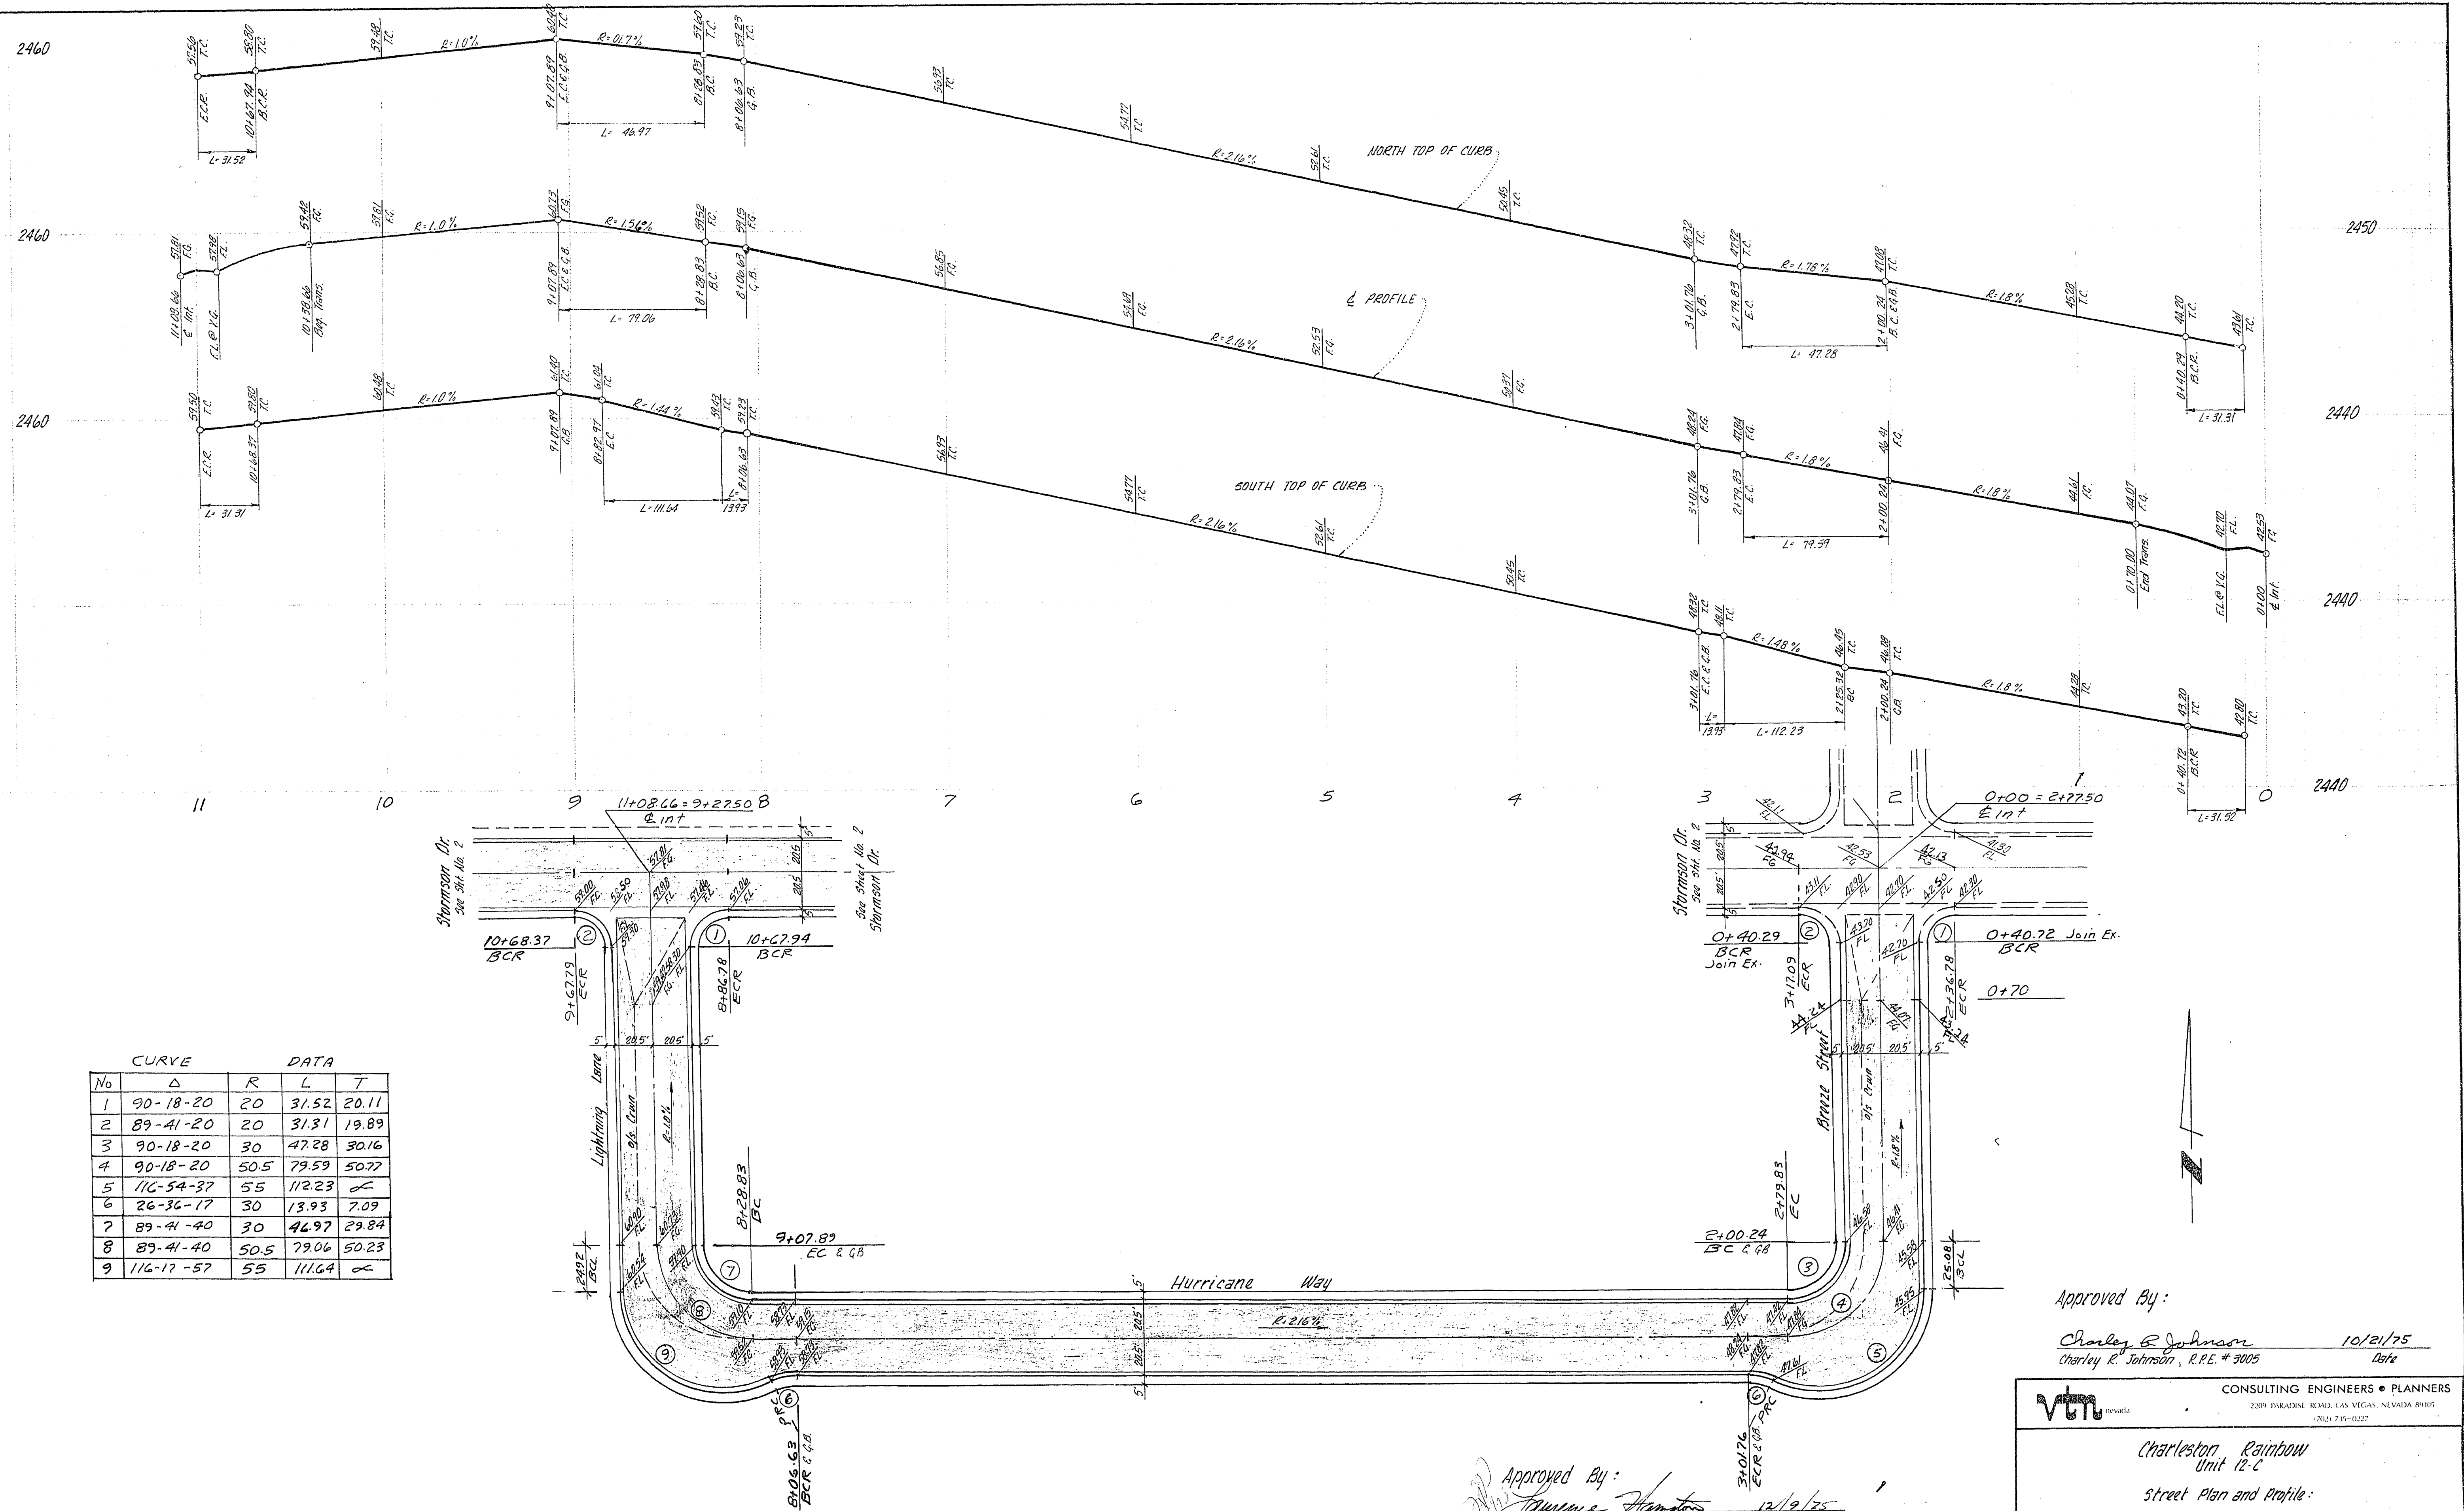

Approved By: Charley R. Johnson 10/21/75
 Charley R. Johnson, R.P.E. # 3005 Date

CONSULTING ENGINEERS • PLANNERS
 2201 PARADISE ROAD, LAS VEGAS, NEVADA 89105
 (702) 735-1127

Charleston Rainbow
 Unit 12-C
 Street Plan and Profile
 Breeze St., Hurricane Way, Lightning Lane

SCALE:	WD. NO. 1006-12C	DATE 10/21/75	SHEET	OF
HORIZ: 1" = 40'	DES. R.V.	REV.	3	7
VERT: 1" = 4'	CHK. C.R.J.	REV.		

Approved By: L. D. Decker 12-9-75
 Las Vegas City Engineer Date