

Ducharme Avenue
See Sheet 4

Aplin Avenue
See Sheet 7


No	Δ	R	Length	Tan
6	88-45-16	20	30.98	19.57
7	91-14-44	20	31.85	20.44

Robert D. Wilson 10-27-78
CITY ENGINEER DATE

Robert D. Wilson 10-27-78
FIELD OPERATIONS ENGINEER DATE

Ed E. Wilson 10-26-78
QUALITY CONTROL ENGINEER DATE

10-28-78
TRAFFIC ENGINEER DATE

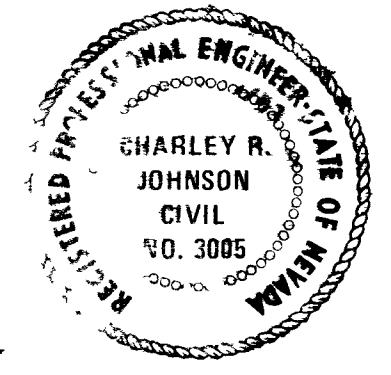

SUBMITTED BY
Charley R. Johnson Aug 15, 1978
CHARLEY R. JOHNSON, P.E. DATE
NEVADA CERTIFICATE NO. 3005



CONSULTING ENGINEERS • PLANNERS
2209 PARADISE ROAD LAS VEGAS NEVADA 89105
17021 735-0227

CHARLESTON RAINBOW UNIT 16D
STREET PLAN AND PROFILE
SCHERER STREET

SCALE: HORIZ 1"=40' VERT 1"=4'
WO NO 1066160 DATE 8/15/78 SHEET 6 OF 14
DES REV. CHK REV.

3828

107g-1055-16D

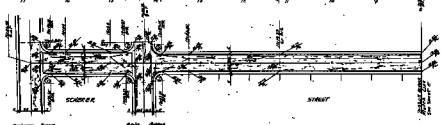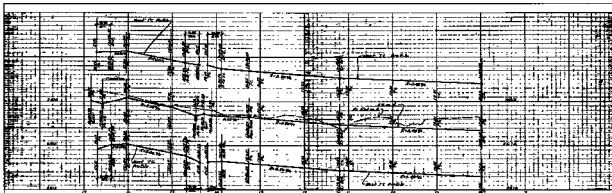

Continued from
Sheet No. 1

Sheet No. 2
of 2

NO.	DATE	BY	REVISION
1	10-1-22	W. S. W.	PLAN
2	10-1-22	W. S. W.	PROF.

W. S. W.
W. S. W.
W. S. W.
W. S. W.

APPROVED
W. S. W.
10-1-22

UNIVERSITY OF MICHIGAN
ENGINEERING DEPARTMENT
ANN ARBOR, MICHIGAN

**CHARLESTON RAINBOW UNIT AND
STREET PLAN AND PROFILE
SCHMIDT STREET**

DATE	DESIGNED BY	CHECKED BY
10-1-22	W. S. W.	G. W.