
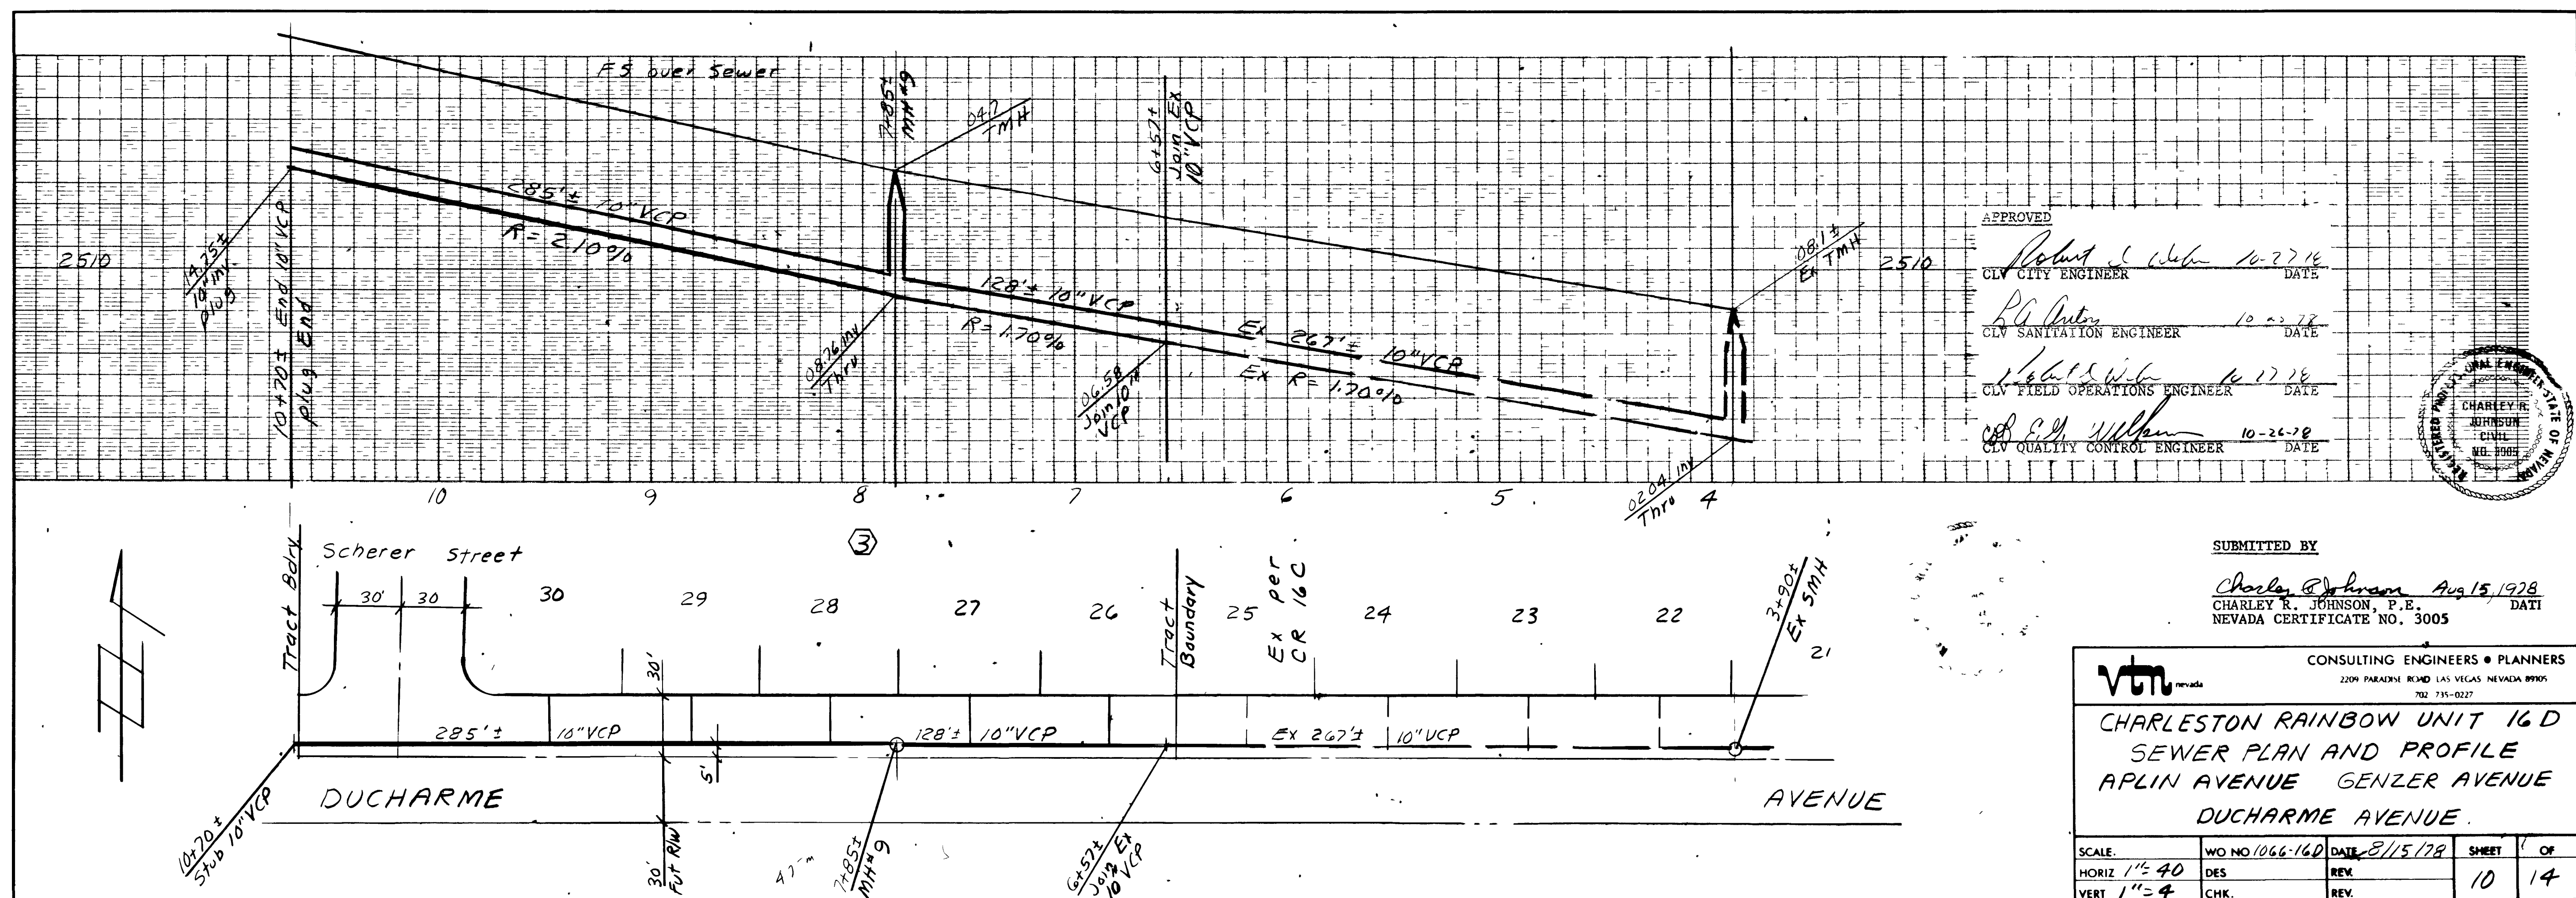


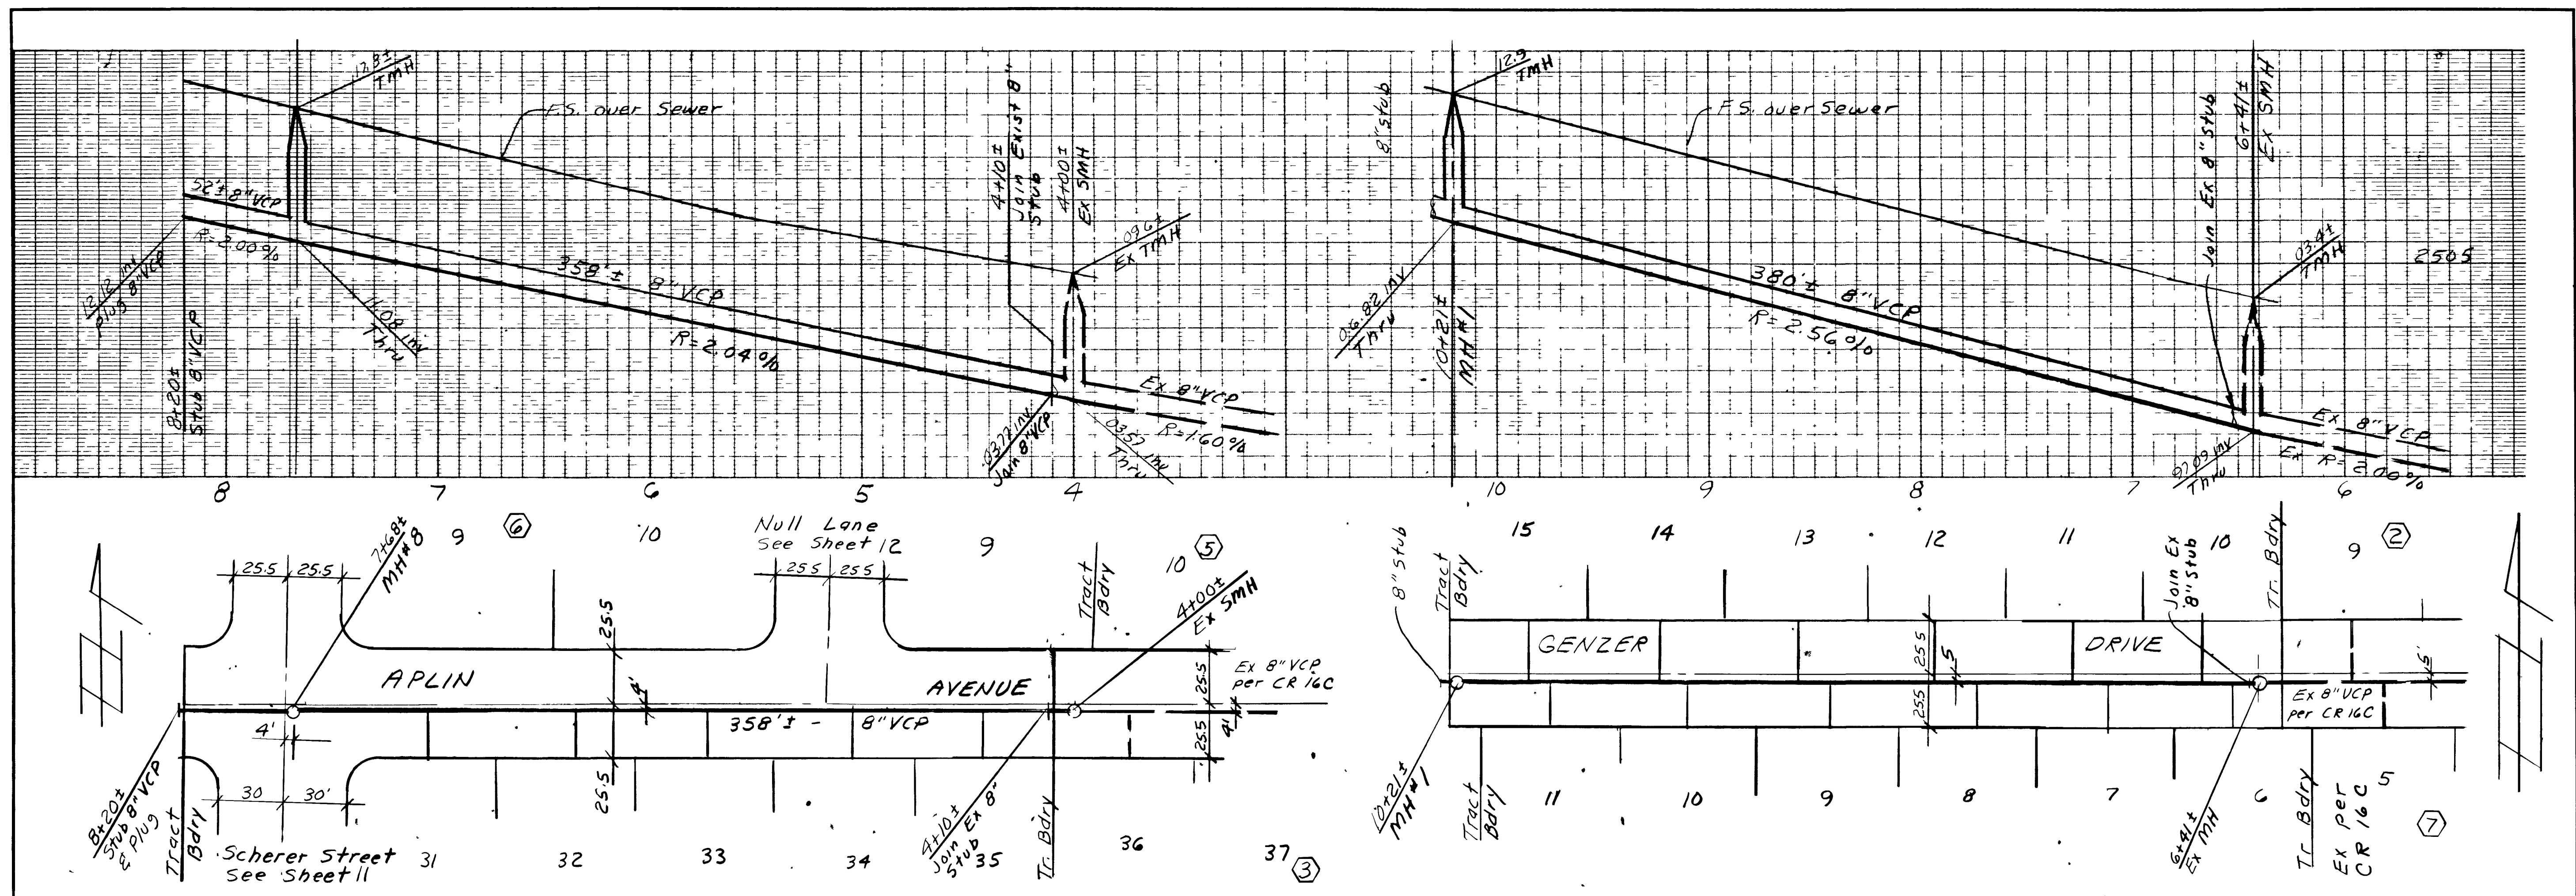


APPROVED

Robert S. White 10-27-16
CLV CITY ENGINEER DATE

R. G. Gentry 10-23-16
CLV SANITATION ENGINEER DATE

Robert S. White 10-27-16
CLV FIELD OPERATIONS ENGINEER DATE

Robert S. White 10-26-16
CLV QUALITY CONTROL ENGINEER DATE

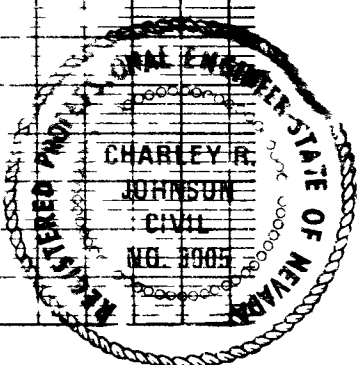

SUBMITTED BY

Charley R. Johnson Aug 15, 1978
CHARLEY R. JOHNSON, P.E. DATE
NEVADA CERTIFICATE NO. 3005

vti CONSULTING ENGINEERS & PLANNERS			
2201 PARADISE ROAD LAS VEGAS, NEVADA 89102			
702-735-0227			
CHARLESTON RAINBOW UNIT 16D			
SEWER PLAN AND PROFILE			
APLIN AVENUE GENZER AVENUE			
DUCHARME AVENUE			
SCALE:	WO NO 1066-16D	DATE 8/15/78	SHEET 10 OF 14
HORIZ 1"=40'	DES	REV	
VERT 1"=4'	CHK	REV	

