
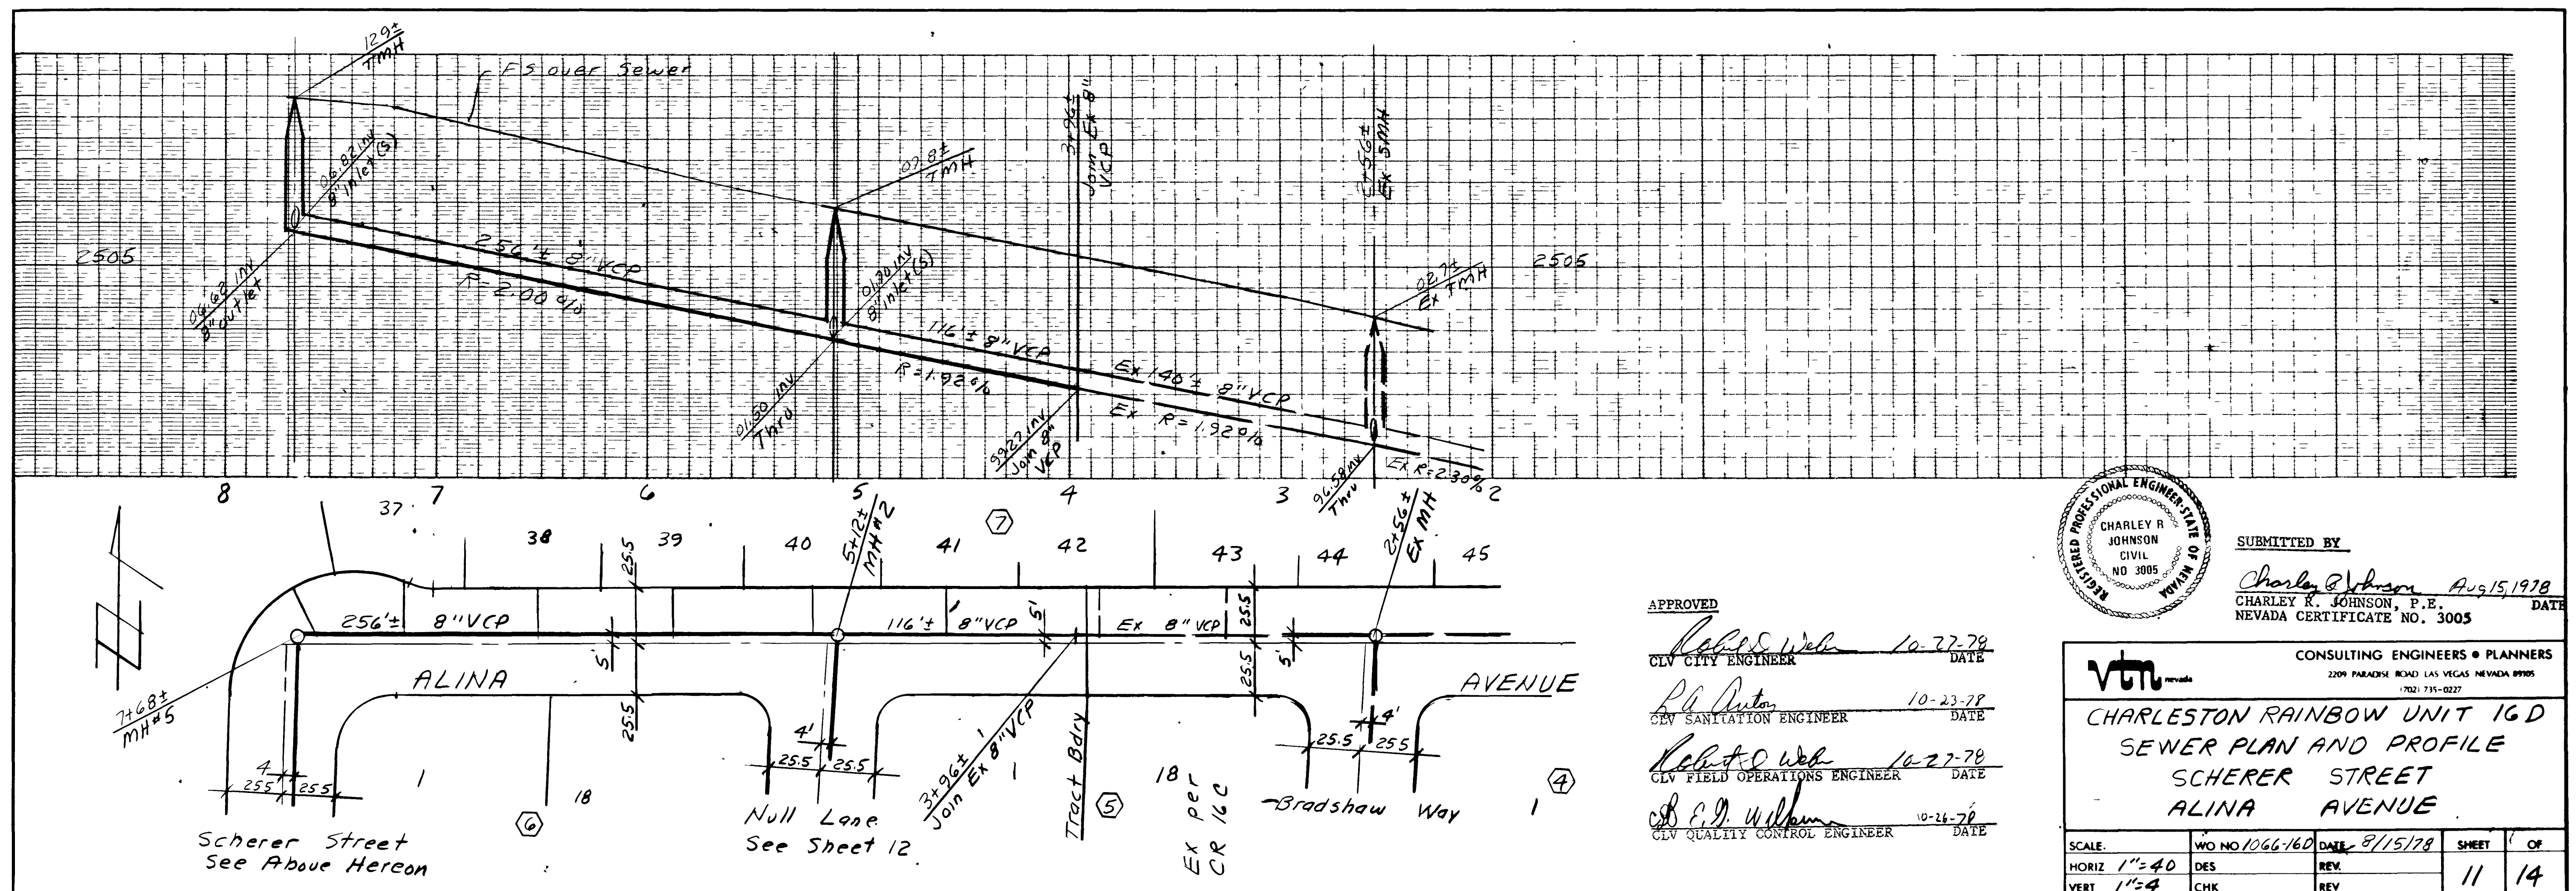


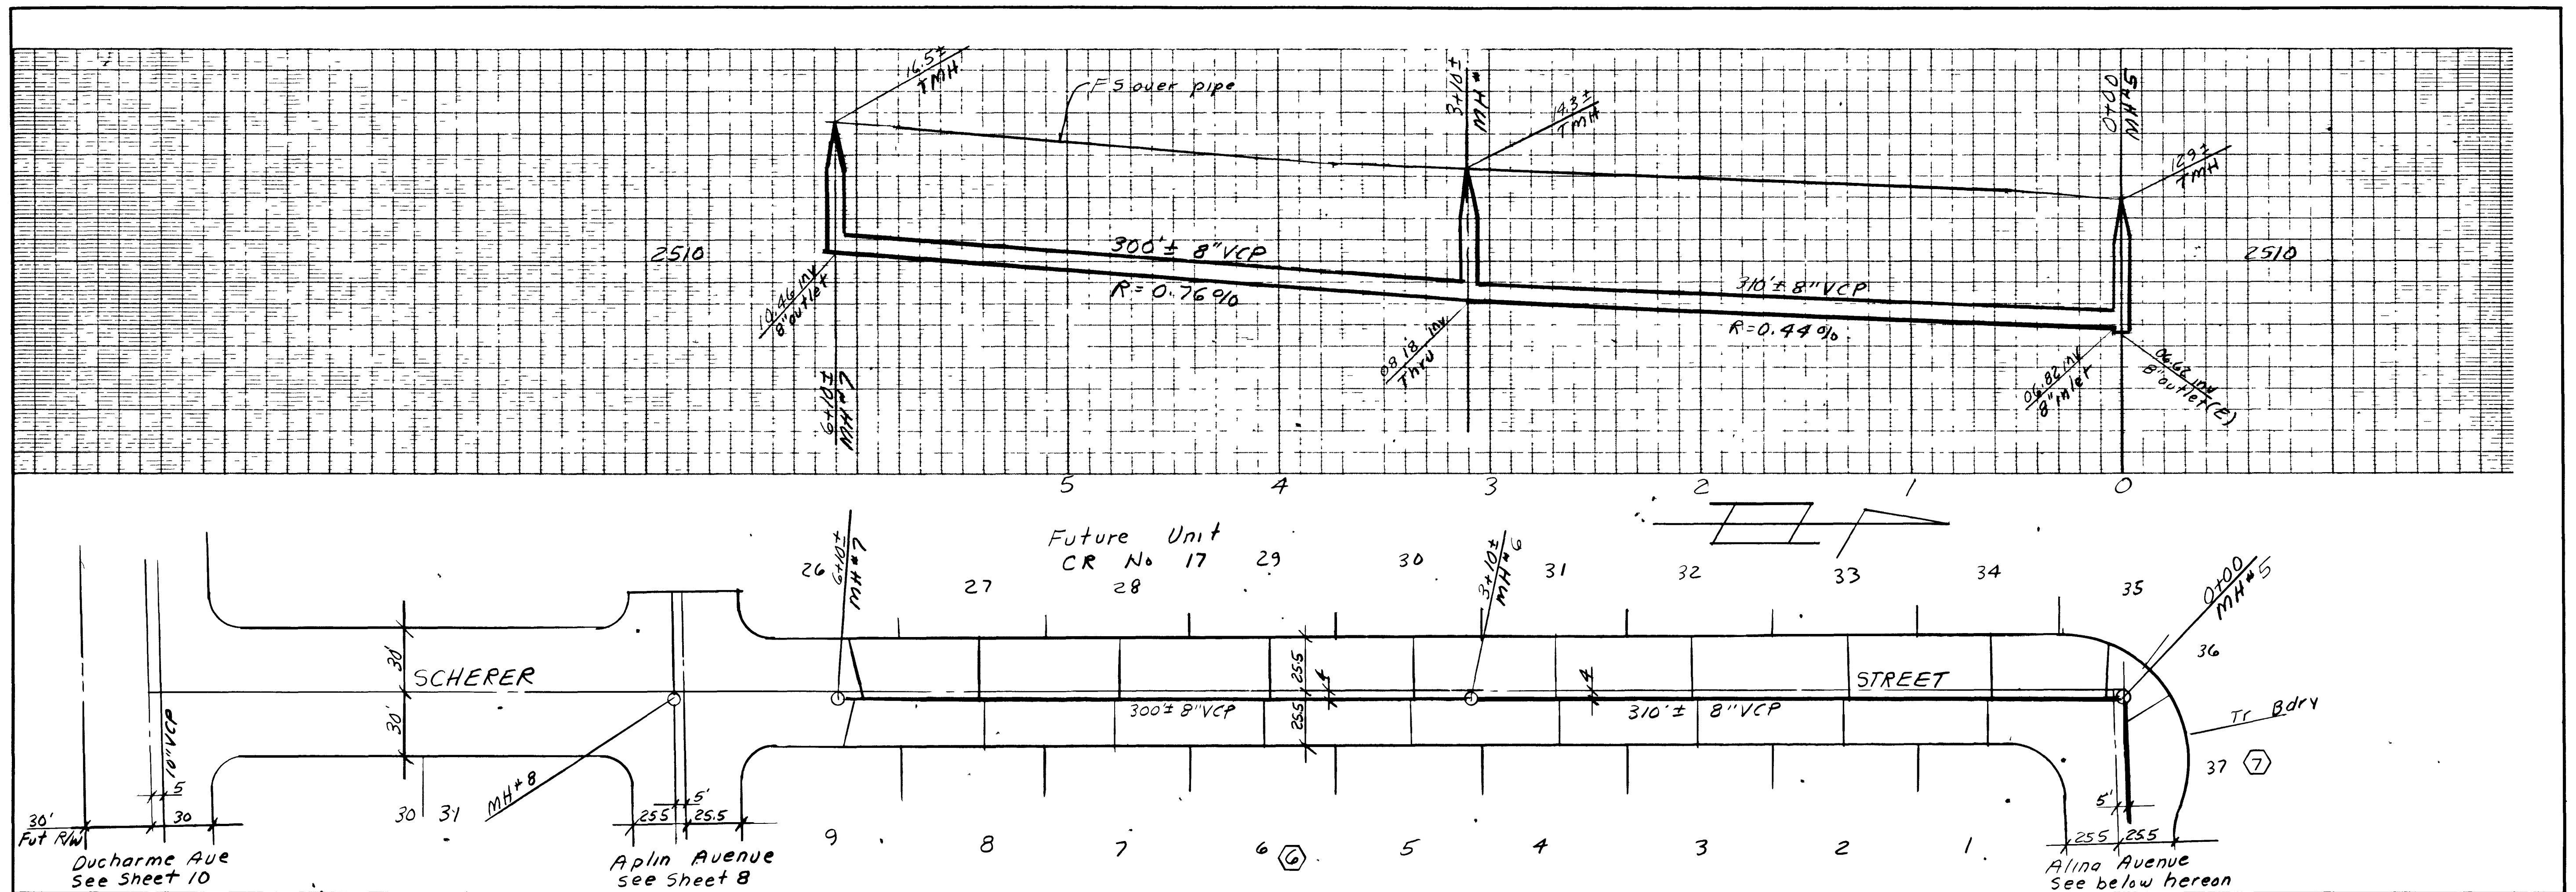


APPROVED

Robert Webb 10-22-78
CLV CITY ENGINEER DATE

Robert Webb 10-23-78
CLV SANITATION ENGINEER DATE

Robert Webb 10-27-78
CLV FIELD OPERATIONS ENGINEER DATE

Robert Webb 10-26-78
CLV QUALITY CONTROL ENGINEER DATE

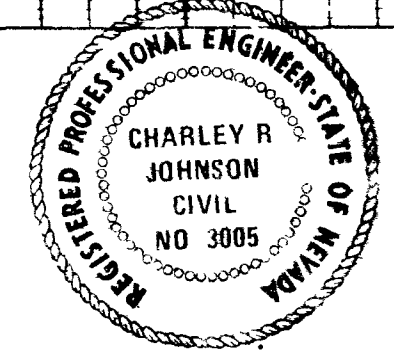

SUBMITTED BY

Charley R. Johnson AUG 15, 1978
CHARLEY R. JOHNSON, P.E. DATE
NEVADA CERTIFICATE NO. 3005

CHARLESTON RAINBOW UNIT 16D SEWER PLAN AND PROFILE SCHERER STREET ALINA AVENUE			
SCALE:	WO NO 1066-160	DATE 8/15/78	SHEET 11 OF 14
HORIZ 1"=40'	DES	REV	
VERT 1"=4'	CHK	REV	

