
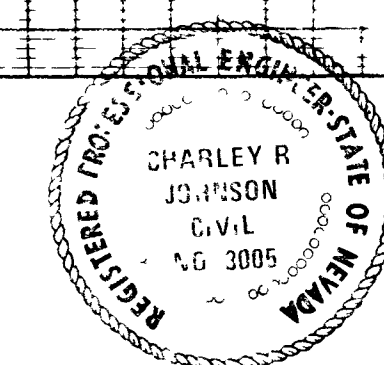
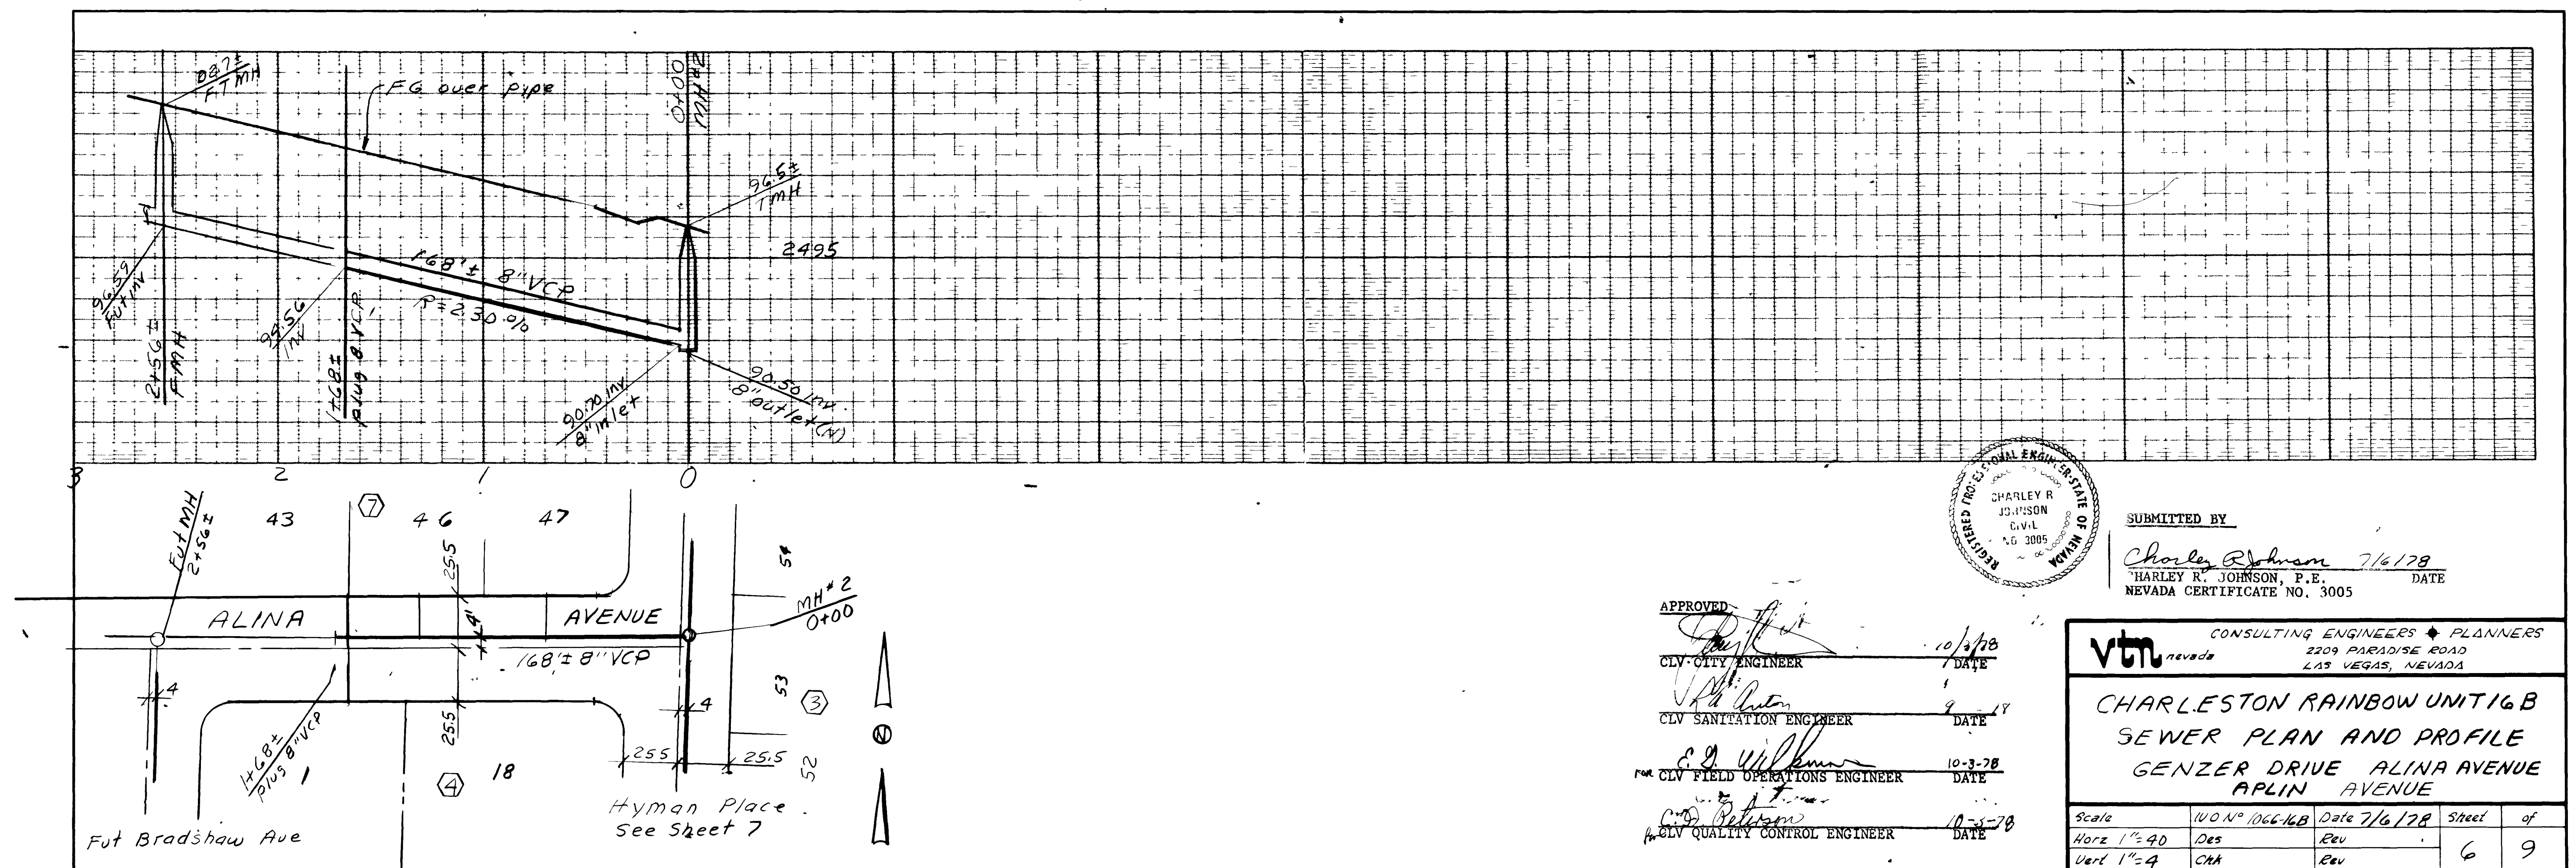


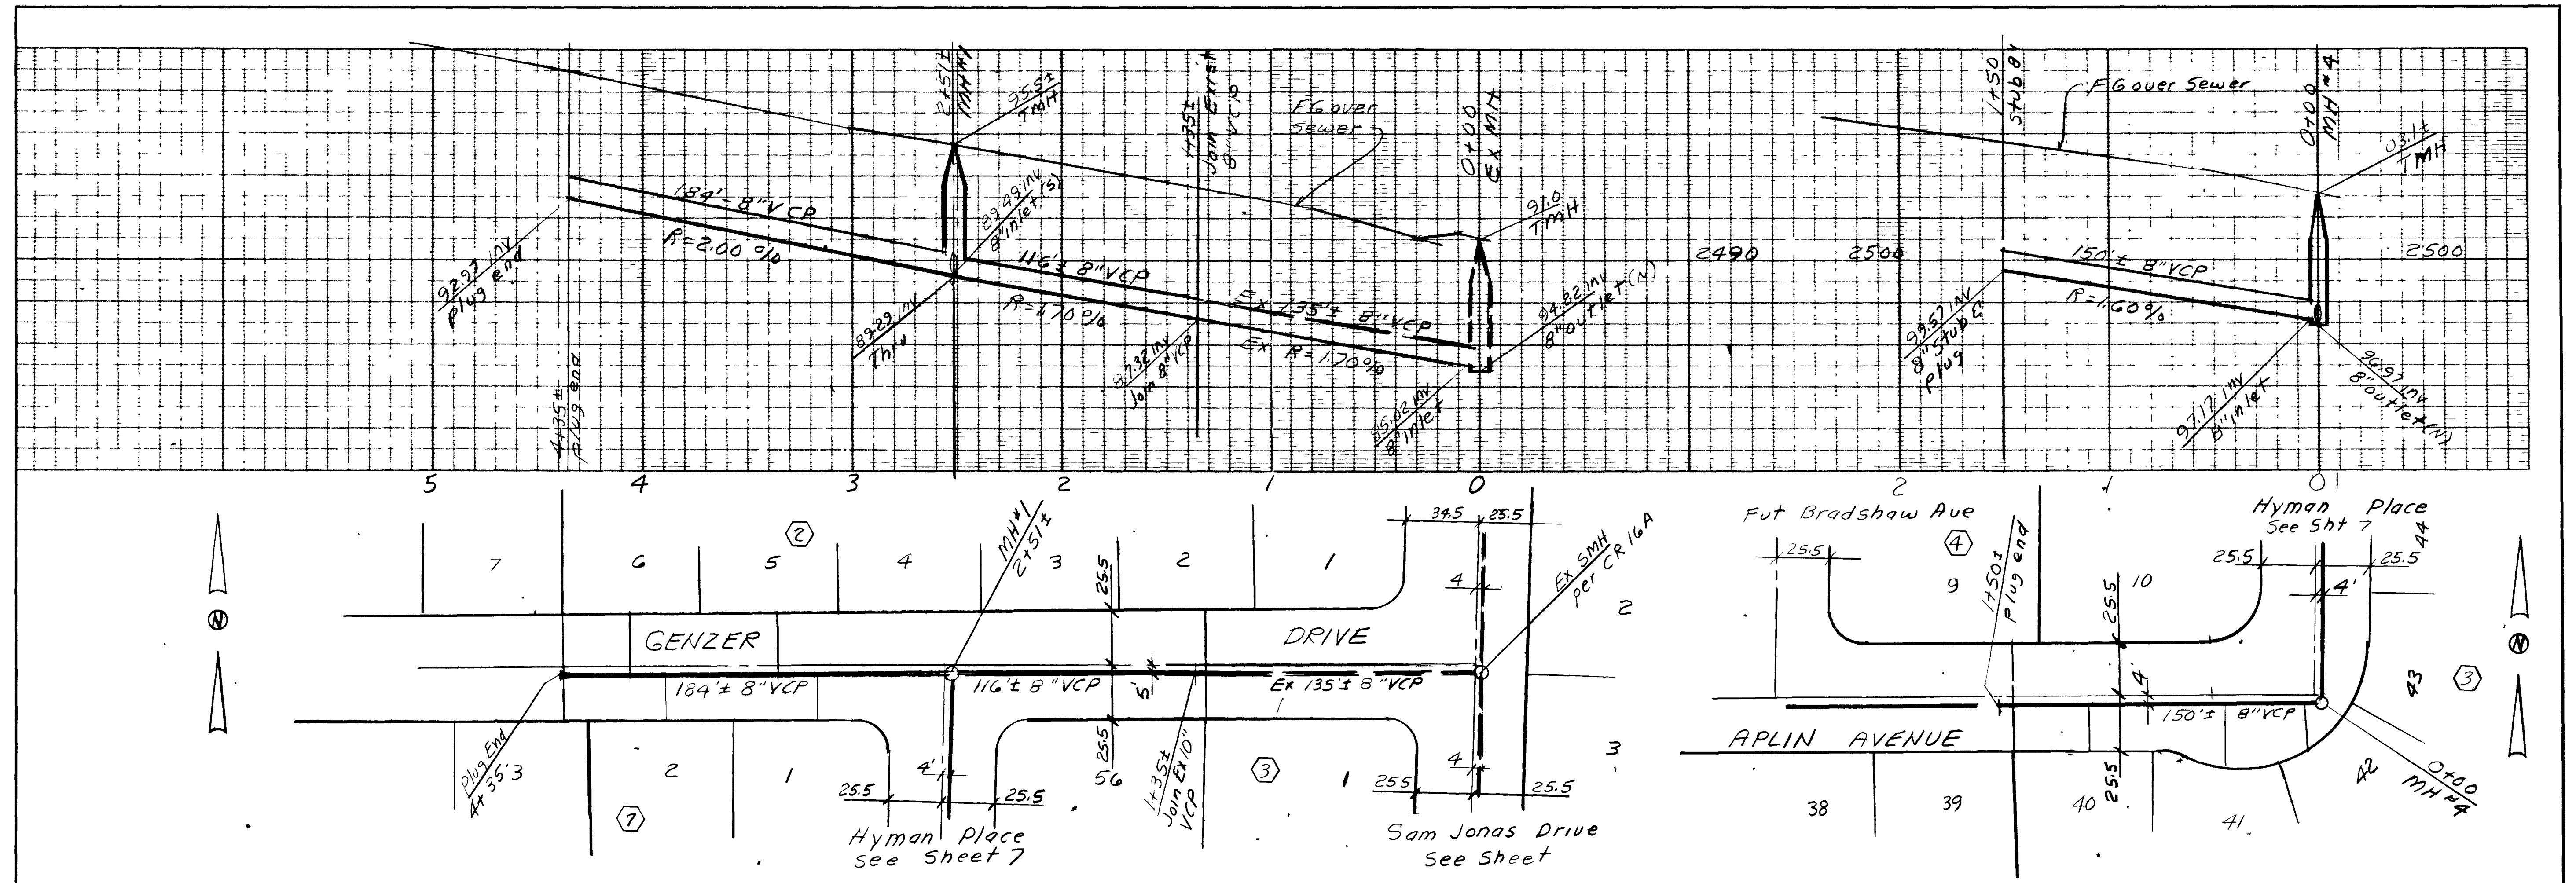

SUBMITTED BY
Charley R. Johnson 7/6/78
 HARLEY R. JOHNSON, P.E.
 NEVADA CERTIFICATE NO. 3005

APPROVED
[Signature] 10/3/78
 CLV CITY ENGINEER DATE
[Signature] DATE
 CLV SANITATION ENGINEER
[Signature] 10-3-78
 CLV FIELD OPERATIONS ENGINEER DATE
[Signature] 10-3-78
 CLV QUALITY CONTROL ENGINEER DATE

vtm CONSULTING ENGINEERS & PLANNERS			
2209 PARADISE ROAD LAS VEGAS, NEVADA			
CHARLESTON RAINBOW UNIT 16B SEWER PLAN AND PROFILE GENZER DRIVE ALINA AVENUE APLIN AVENUE			
Scale	1/4" = 1'-0"	Date	7/6/78
Horz	1" = 40'	Des	Rev
Vert	1" = 4'	CHK	Rev
		Sheet	6
		of	9

3842

307Y-1055-16B

