

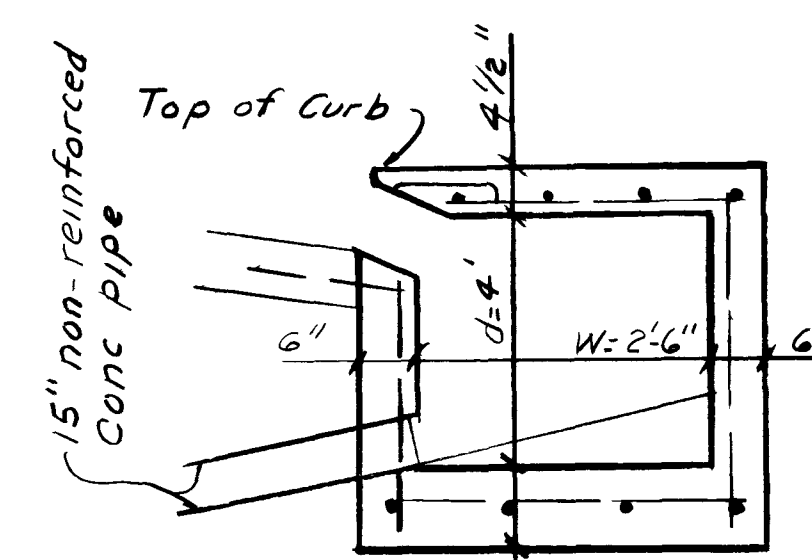
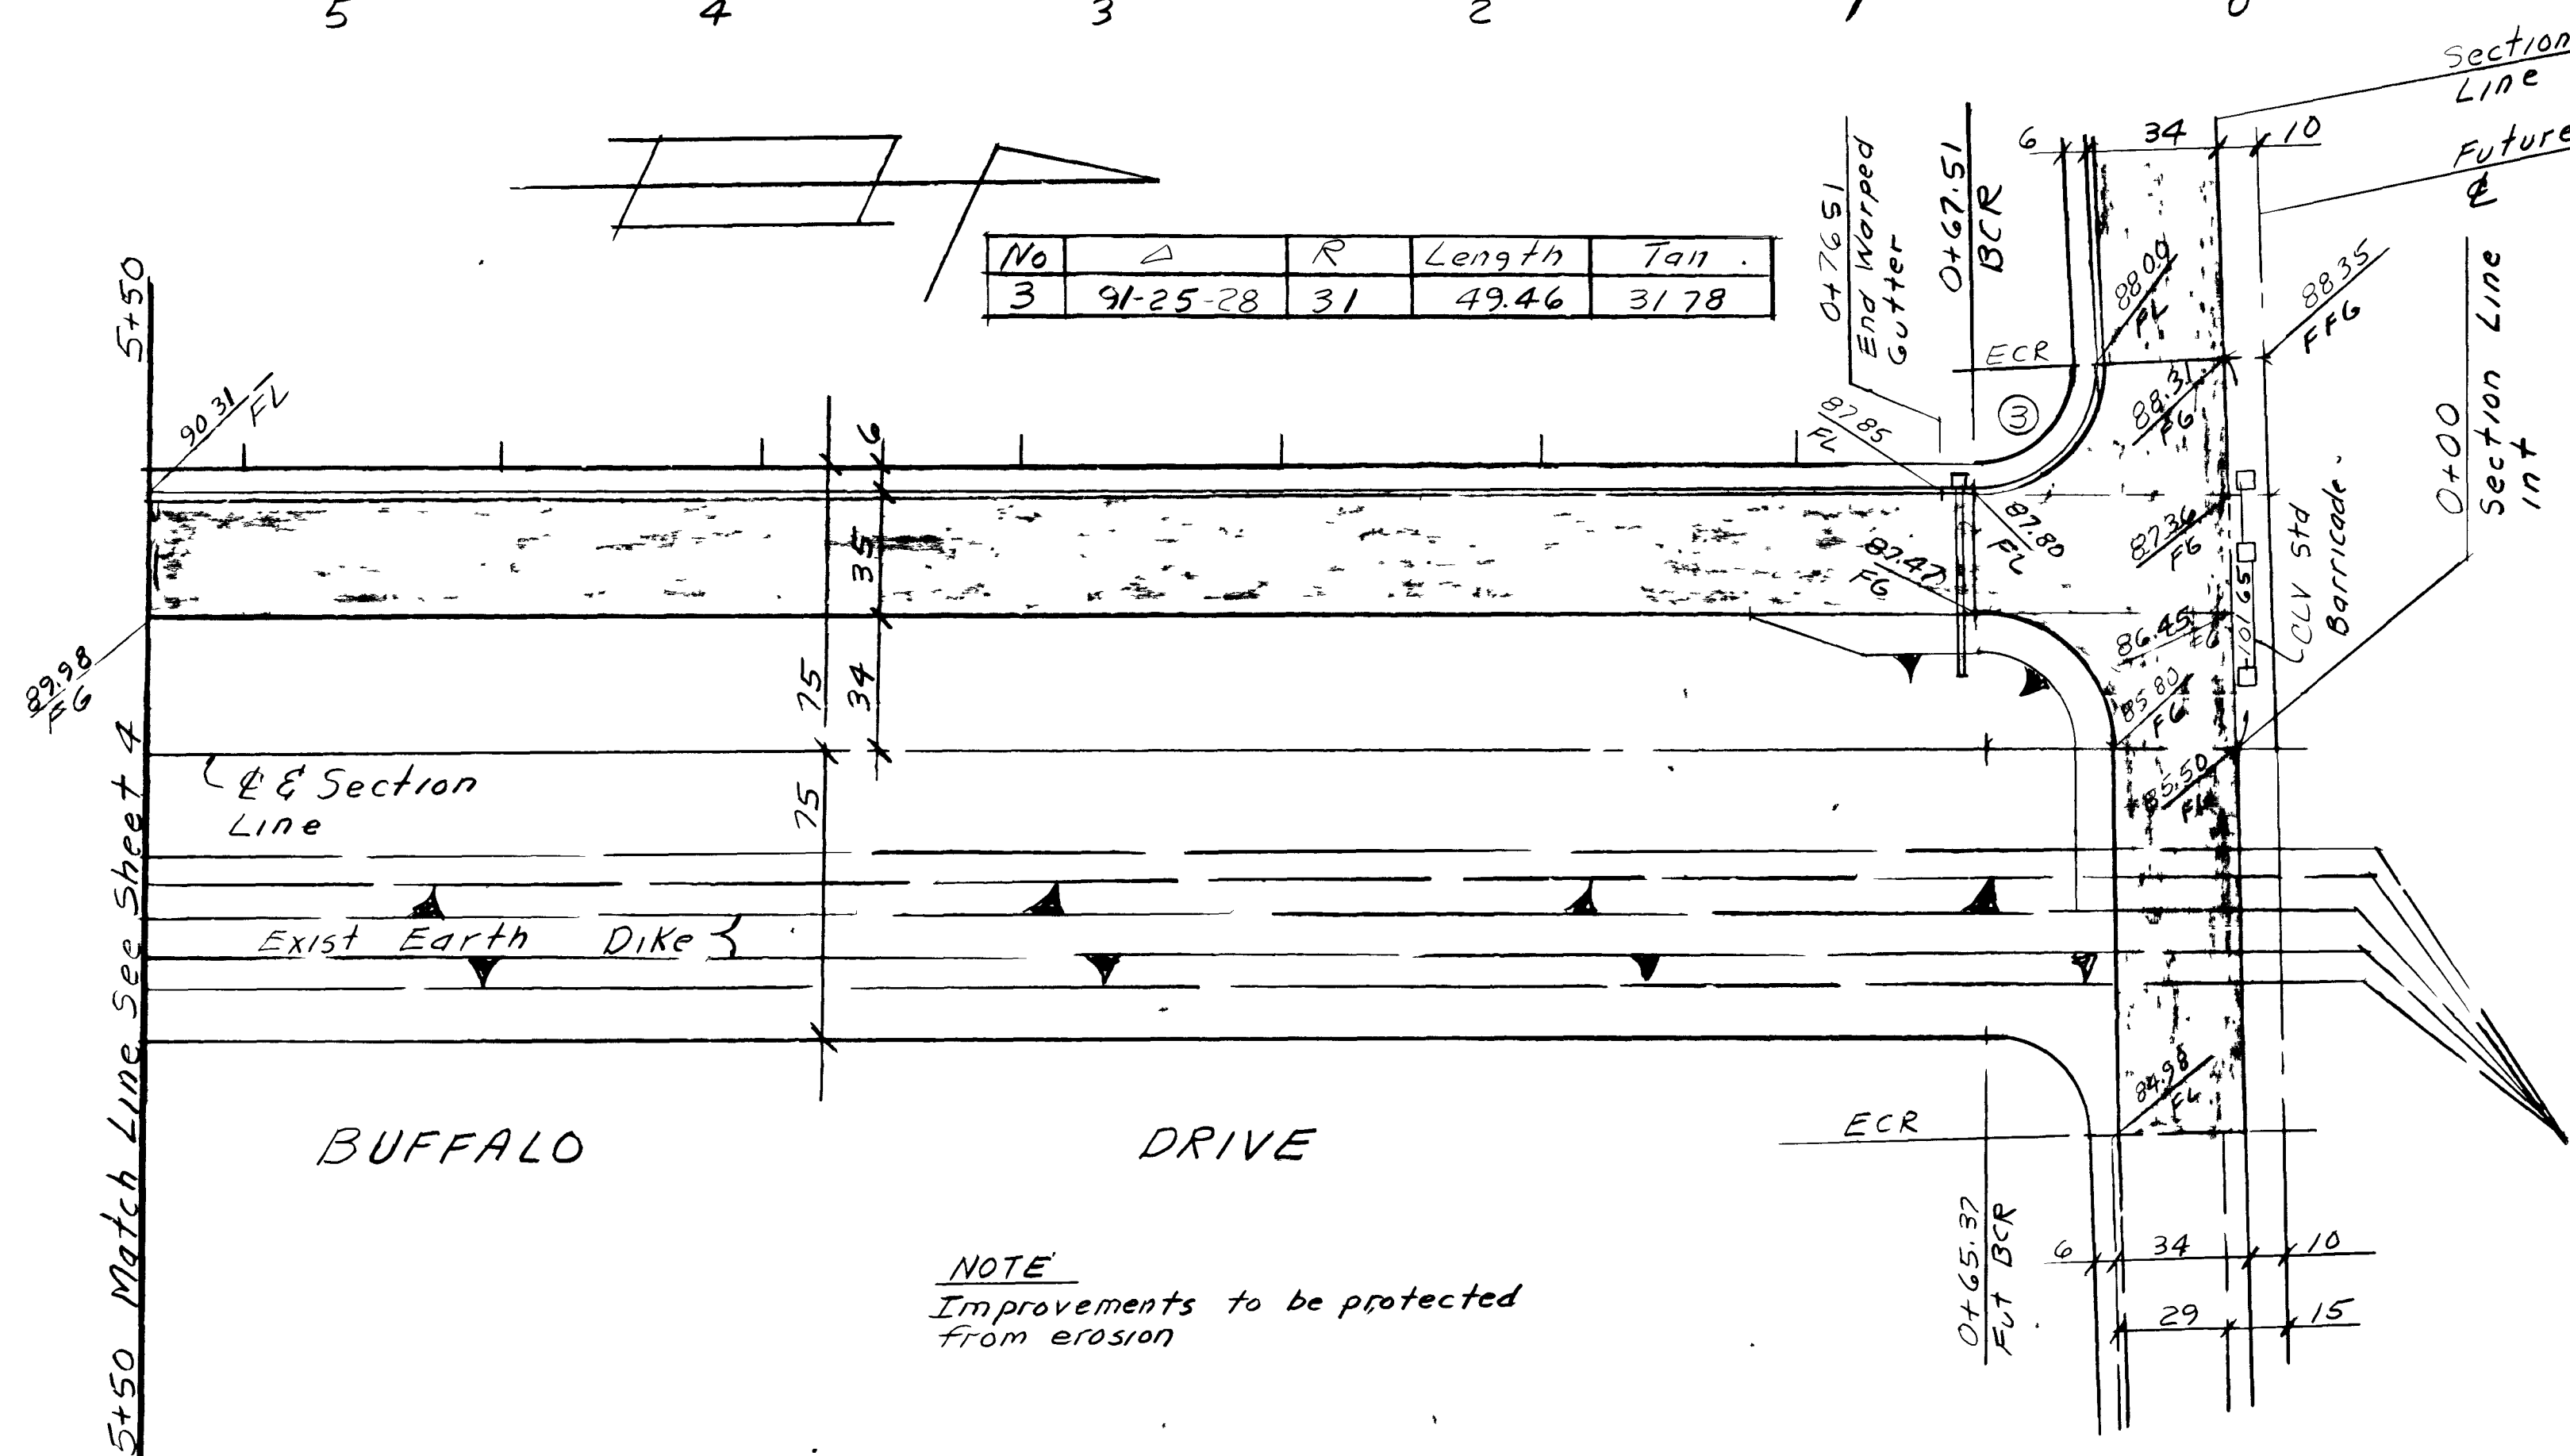


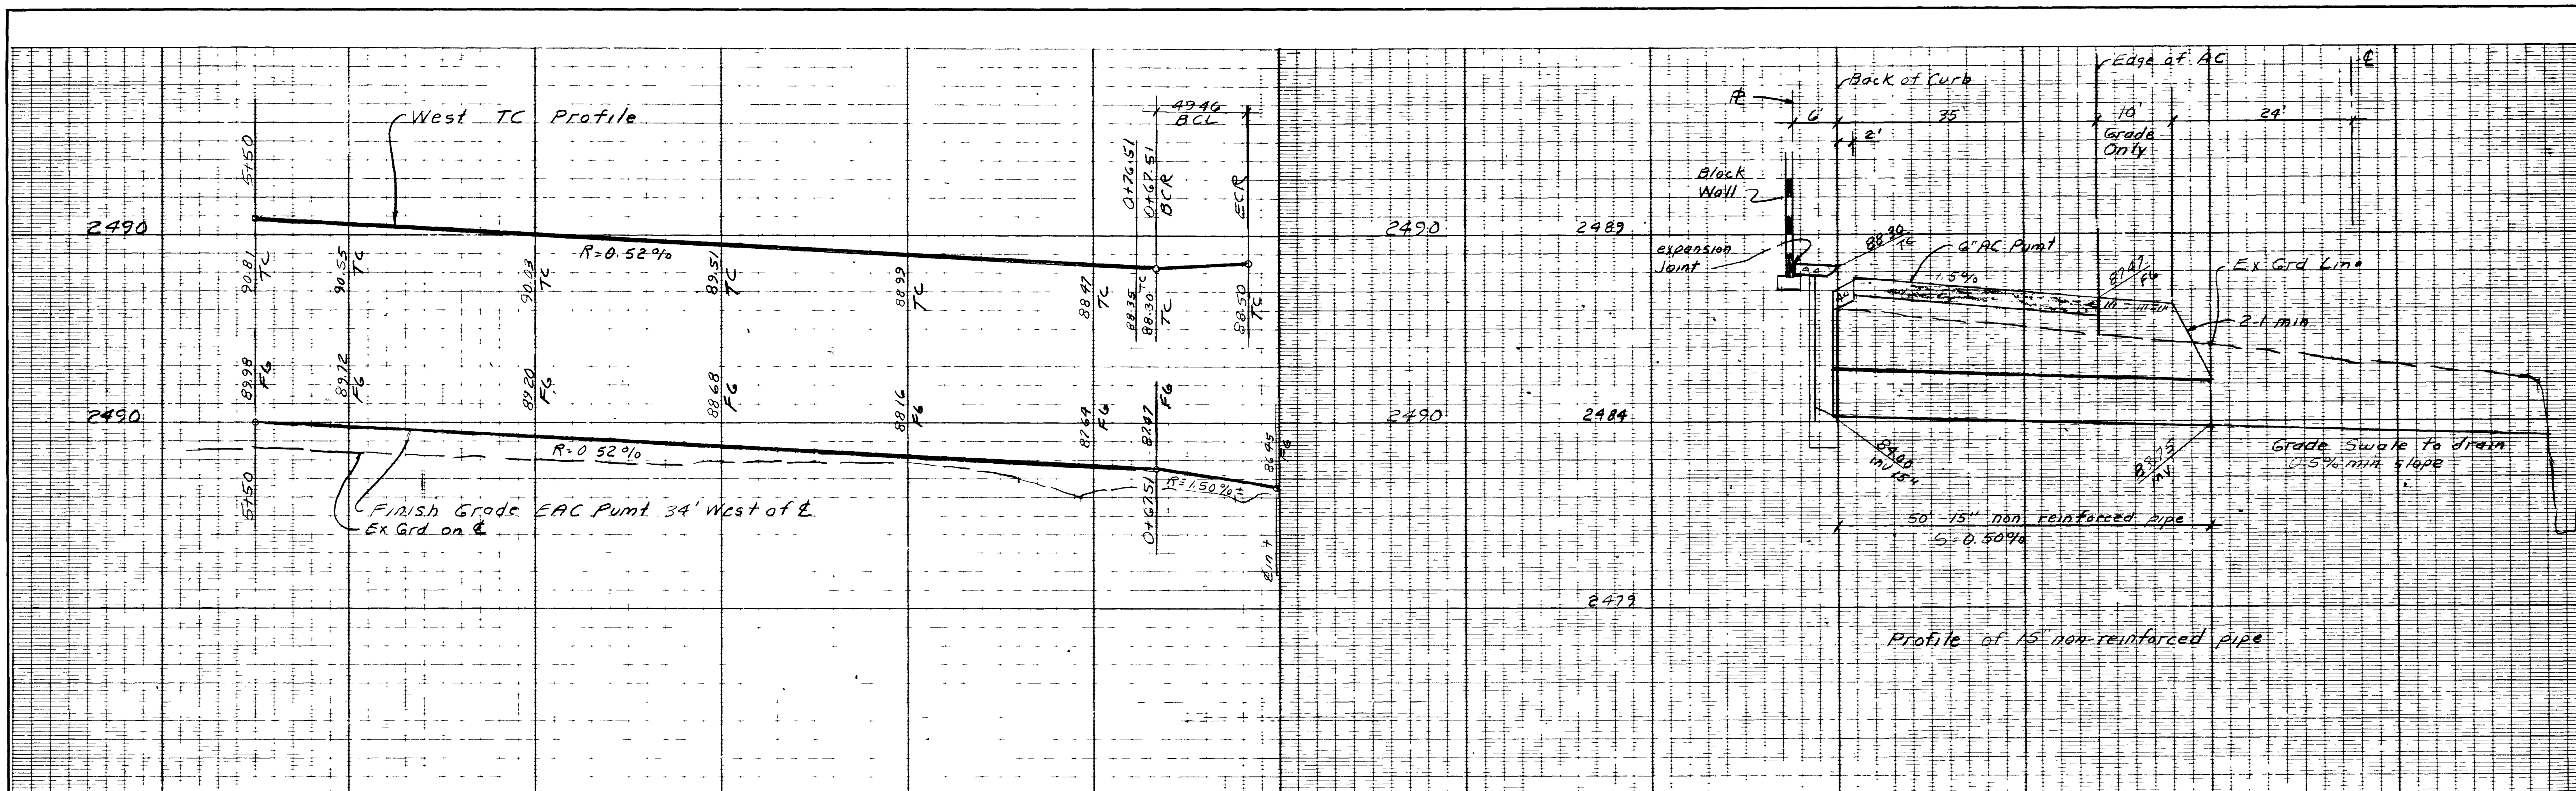


TYPE "A" INLET
Construct Type "A" drop inlet per Std. Drawing No 57 page 20 of Uniform Std. Drawings for Public Works Const. Clark County Nevada Latest Edition L=3' d=4'

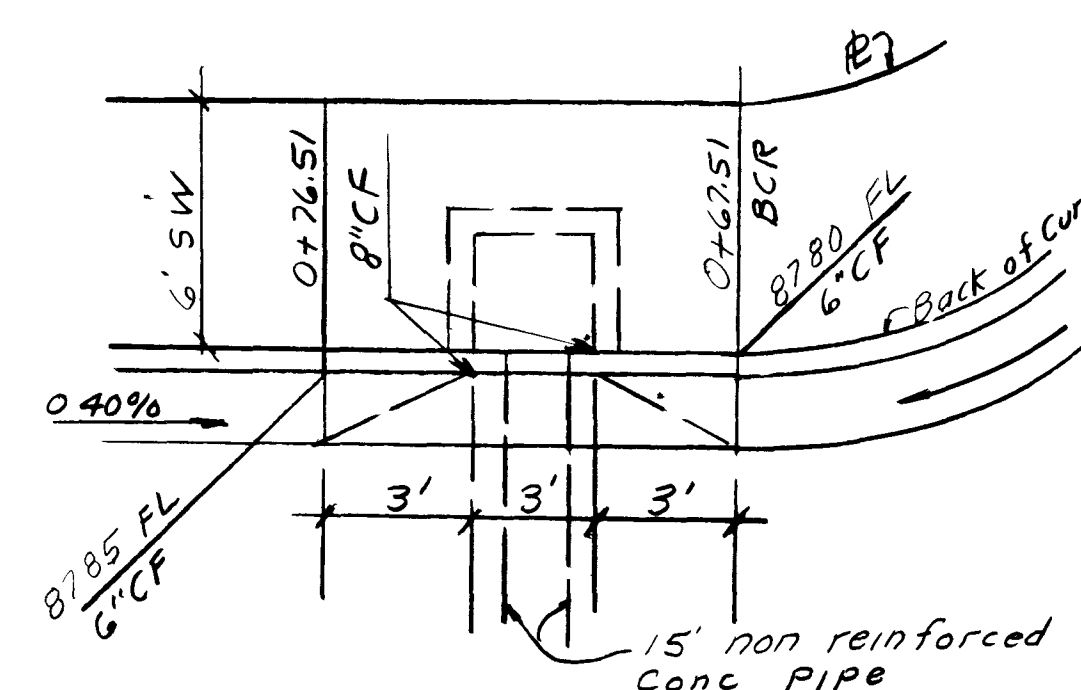

TYPE "A" DROP INLET
Warp Gutter to provide 8" curb face at inlet. See Drop inlet detail above hereon

APPROVED
CLV CITY ENGINEER
CLV FIELD OPERATIONS ENGINEER
CLV TRAFFIC ENGINEER
CLV QUALITY CONTROL ENGINEER


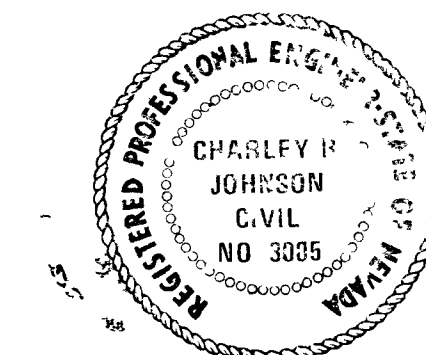


SUBMITTED BY
Charley R. Johnson
CHARLEY R. JOHNSON, P.E.
NEVADA CERTIFICATE NO. 3005


VTN CONSULTING ENGINEERS • PLANNERS
2101 PARADISE ROAD LAS VEGAS, NEVADA 89105
(702) 735-0227

CHARLESTON RAINBOW UNIT 16A
STREET PLAN AND PROFILE
BUFFALO DRIVE

SCALE	WO NO 1066-16A	DATE 6/19/78	SHEET	OF
HORIZ 1"=40'	DES	REV	3	12
VERT 1"=4'	CHK	REV		

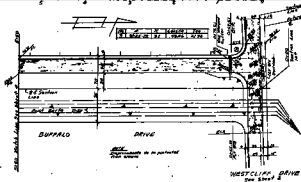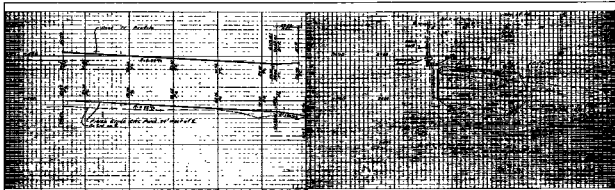

TYPE X - SIDEWALK
Construct Type X sidewalk per S.D. Standard 14.27 (see also S.D. Standard 14.28) for Public Works District. Check County Board for all details.

 

TYPE X - SIDEWALK
Very similar to Type X, but with a different curb profile. See S.D. Standard 14.27 for details.



CHARLESTON RAINBOW LIGHT P.L.B. STREET PLAN AND PROFILE BUFFALO DRIVE			
DATE	SCALE	BY	NO.
1954	1" = 100'	J. H. H.	10