
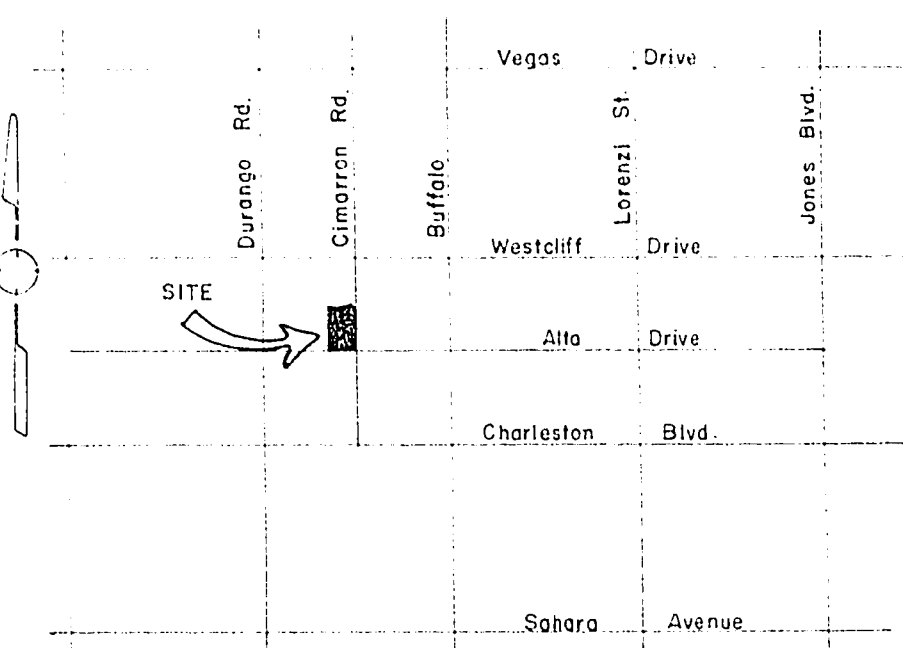


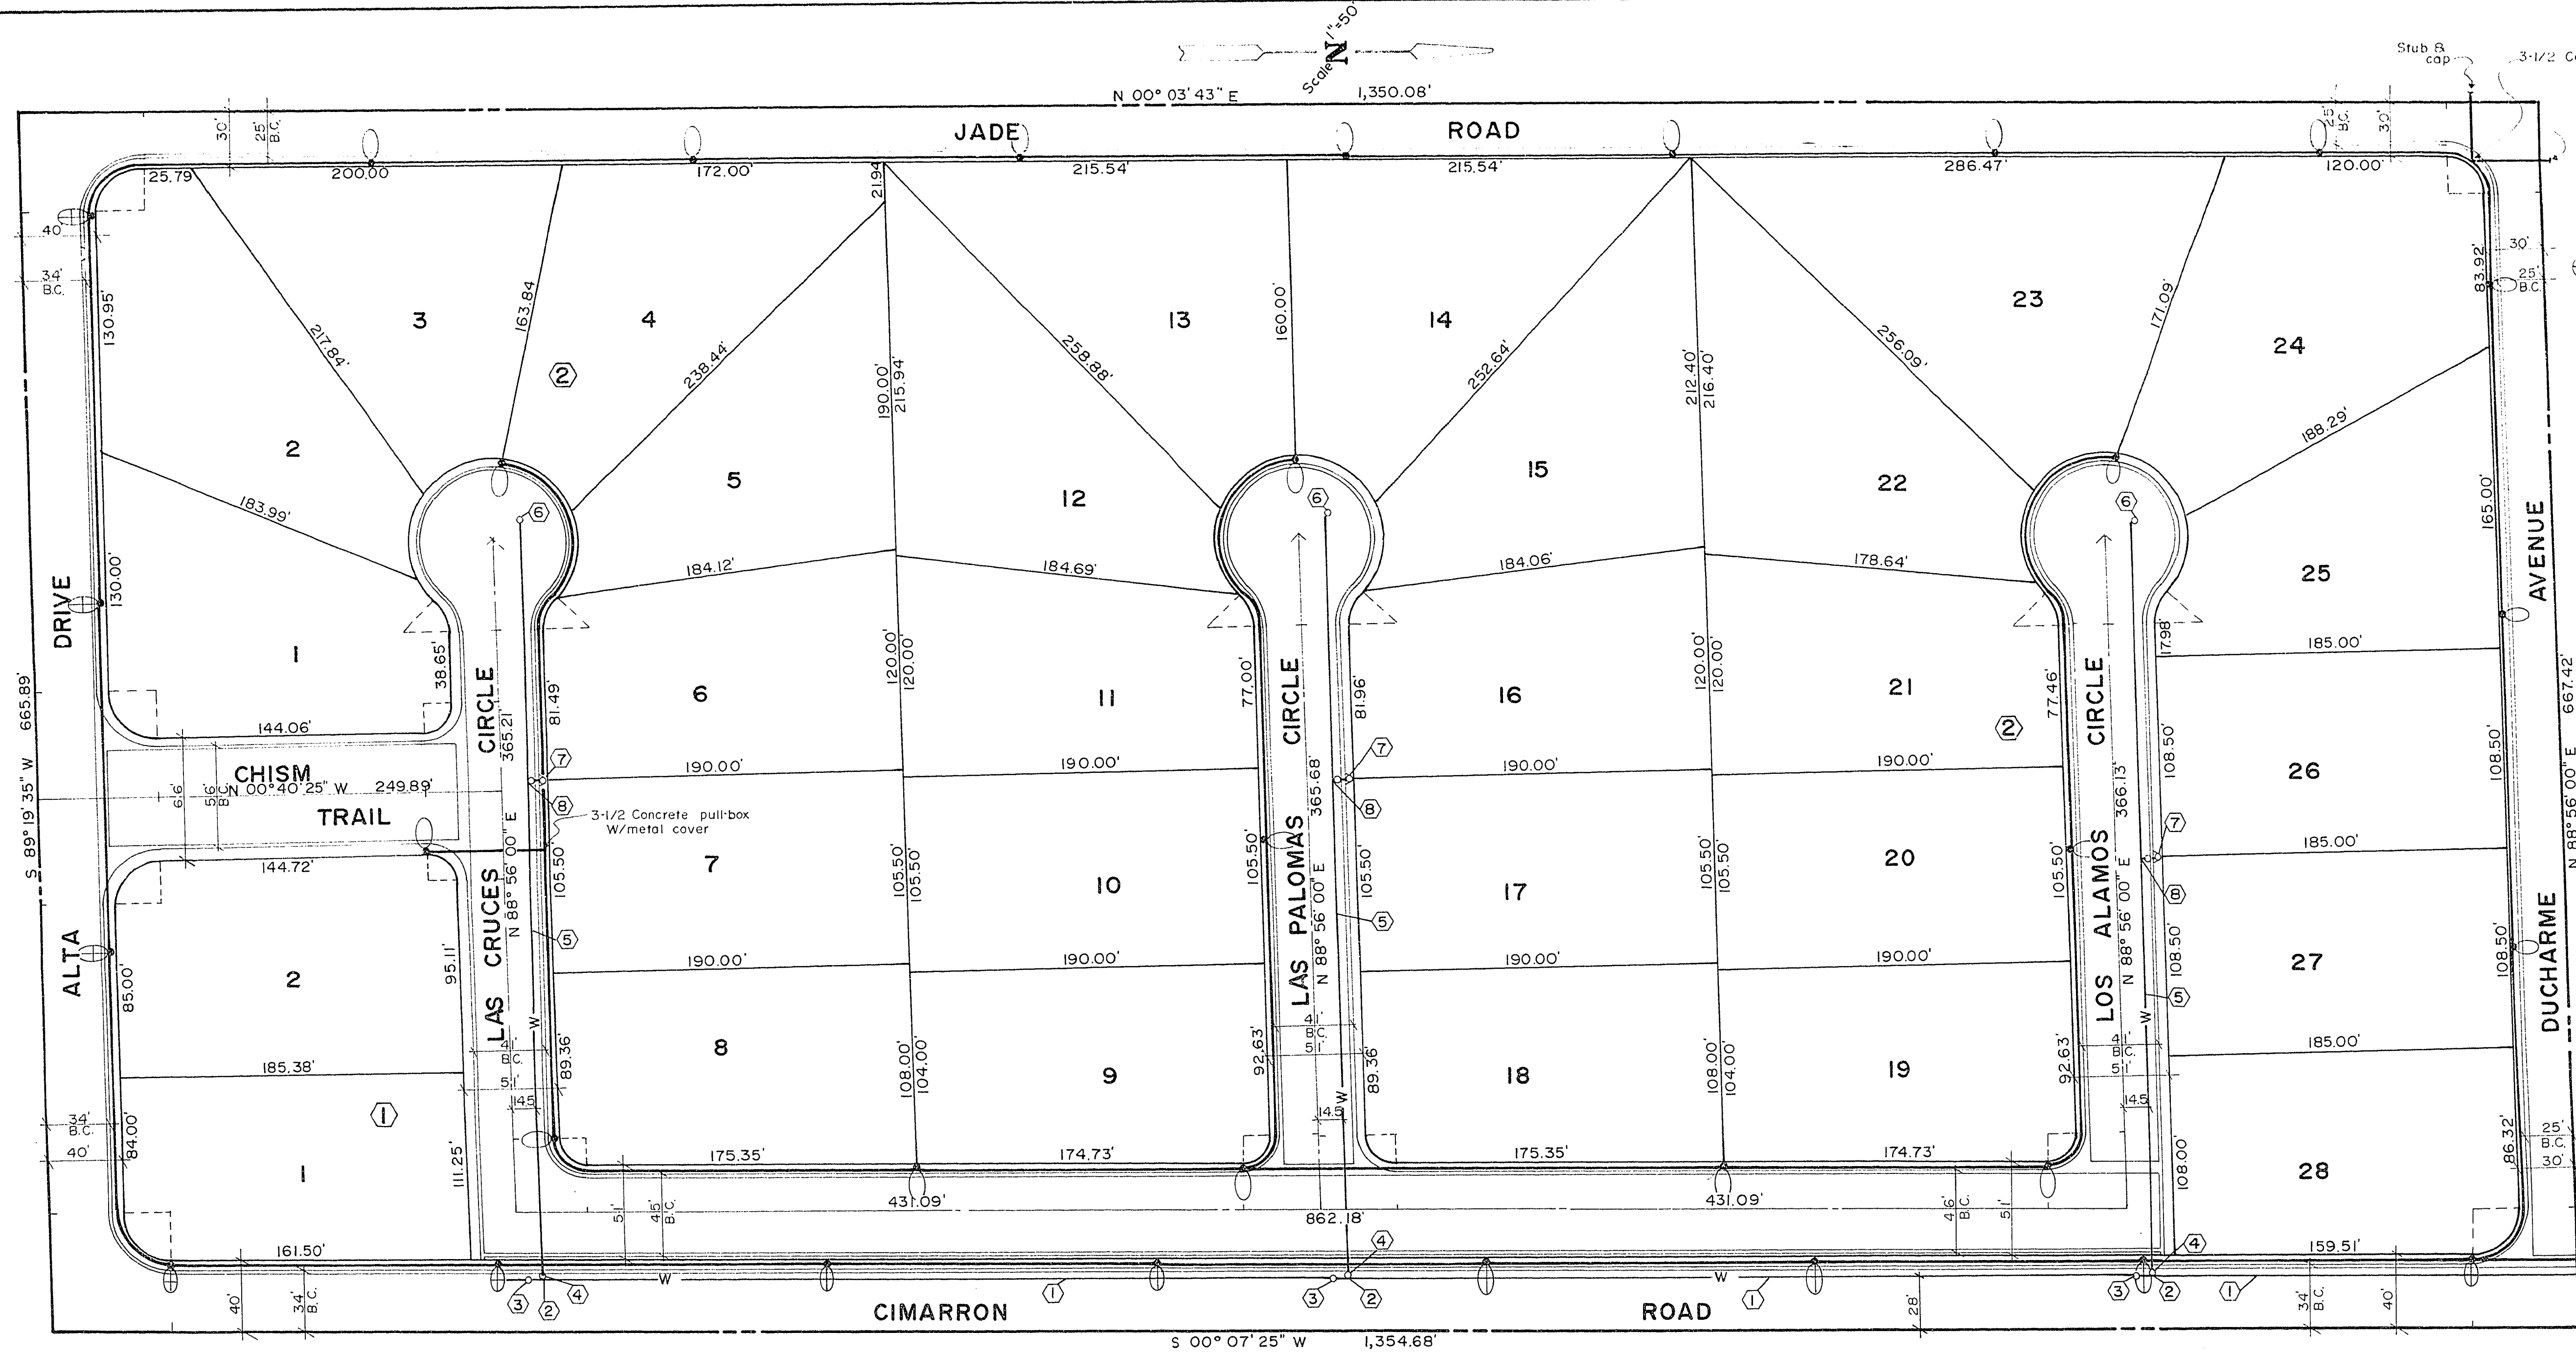

VICINITY MAP
no scale

APPROVALS

Nevada Power Company approves the plan of service to the street light system. This plan not be deemed in conflict to the placement of the light poles which may be in conflict with Nevada Power Company's prior rights and/or facilities.

11-17-78
(Date)

by Michael B. Sullivan

NEVADA POWER COMPANY

Name of Plan: CARRON RANCH ESTATES

When plan as shown will be acceptable. It is NOT approved for construction.

11-17-78

LVVWD Date

WATER LEGEND & QUANTITIES

8" A.C.P. Water line	1,100 L.F.
8"x8"x6" Tee	3 Ea.
8" Gate valve	3 Ea.
6" Gate valve	3 Ea.
6" A.C.P. Water line	1,230 L.F.
2" Blowoff	3 Ea.
Fire hydrant and valve	3 Ea.
6" Tee	3 Ea.

LEGEND

STREET LIGHT	32 Ea.
STREET LIGHT CONDUIT	6,025 L.F.
Block number	
Lot number	

WATER NOTES

- All work to conform to Las Vegas Valley Water District Standard Plates.
- All work, except as modified hereon or by Note No. 1 shall be done in accordance with the most current draft or edition of Uniform Standard Specifications for Public Works Construction Offsites Improvements Clark County.
- Notice to be given Engineering Department of the Las Vegas Valley Water District 48 hours prior to actual construction.
- Service saddles or tapped collars will be required on all services, double collars are not permitted.
- All lines to be pressure tested to 200 psi.
- All valve boxes shall have concrete collars at surface of paved areas.
- Deflection angle shall not exceed 2 1/2 degrees per 13 foot section of pipe for pipe sizes smaller than 14 inches and shall not exceed 2 degrees for pipe sizes between 14 and 16 inches.
- All meters shall be located outside of driveways.

STREET LIGHT NOTE

All street lighting installations, except as noted on the street lighting plans shall conform to the Standard Details for Street Lighting and Traffic Signals Drawings 1-779 (including standard street lighting notes) with revisions no later than March 26, 1976. These installations shall also conform to the Uniform Standard Specifications for Public Works Construction of Off-site Improvements, Clark County Area, Nevada and the Uniform Standard Drawings for Public Works Construction, Clark County Area were applicable.

A. D. Foster

FIRE DEPT. NOTES

- All work shall be done in strict accordance with Clark County Specifications.
- All work shall be done in strict accordance with Clark County Fire Department "Hydrant Specifications," "Hydrant Installation Specifications" and "Water Resolutions and Requirements".
- On any new home or building construction, accessible Fire Hydrants installed before actual construction commences and said FireHydrants shall be in good working order with adequate water supply.
- Painting of curb or stripping of asphalt areas and protection of hydrants from physical injury, per Clark County Fire Department Hydrant installations shall be completed before approval of the Hydrants by the Clark County Fire Department.
- No fire hydrant shall be located within fifteen feet of a driveway, six feet of a power pole, light standard or other obstruction.... for wall, fence and planter locations, drawing 44.0 "B" shall be used.

REVISION NO.	DESCRIPTION	BY	DATE	APPROVAL
REVISIONS				
CIMARRON RANCH ESTATES				
WATER AND STREET LIGHT PLAN				
APPROVED		J. R. THOMSON LAS VEGAS NEVADA		
SCALE (H)	1"=50'	SCALE (V)		
DES.	JR	11-3-78	8	
DR.	JR	11-3-78	8	
CHK.				