


William H. Harris *Sept 18*
for CITY ENGINEER DATE
Robert S. Weber *10-3-78*
C.L.V. FIELD OPERATIONS ENGR. DATE
E. J. Webb *10-30-78*
C.L.V. QUALITY CONTROL ENGR DATE

SCALE: 1"=30'

MATCH LINE - SEE SHEET 5

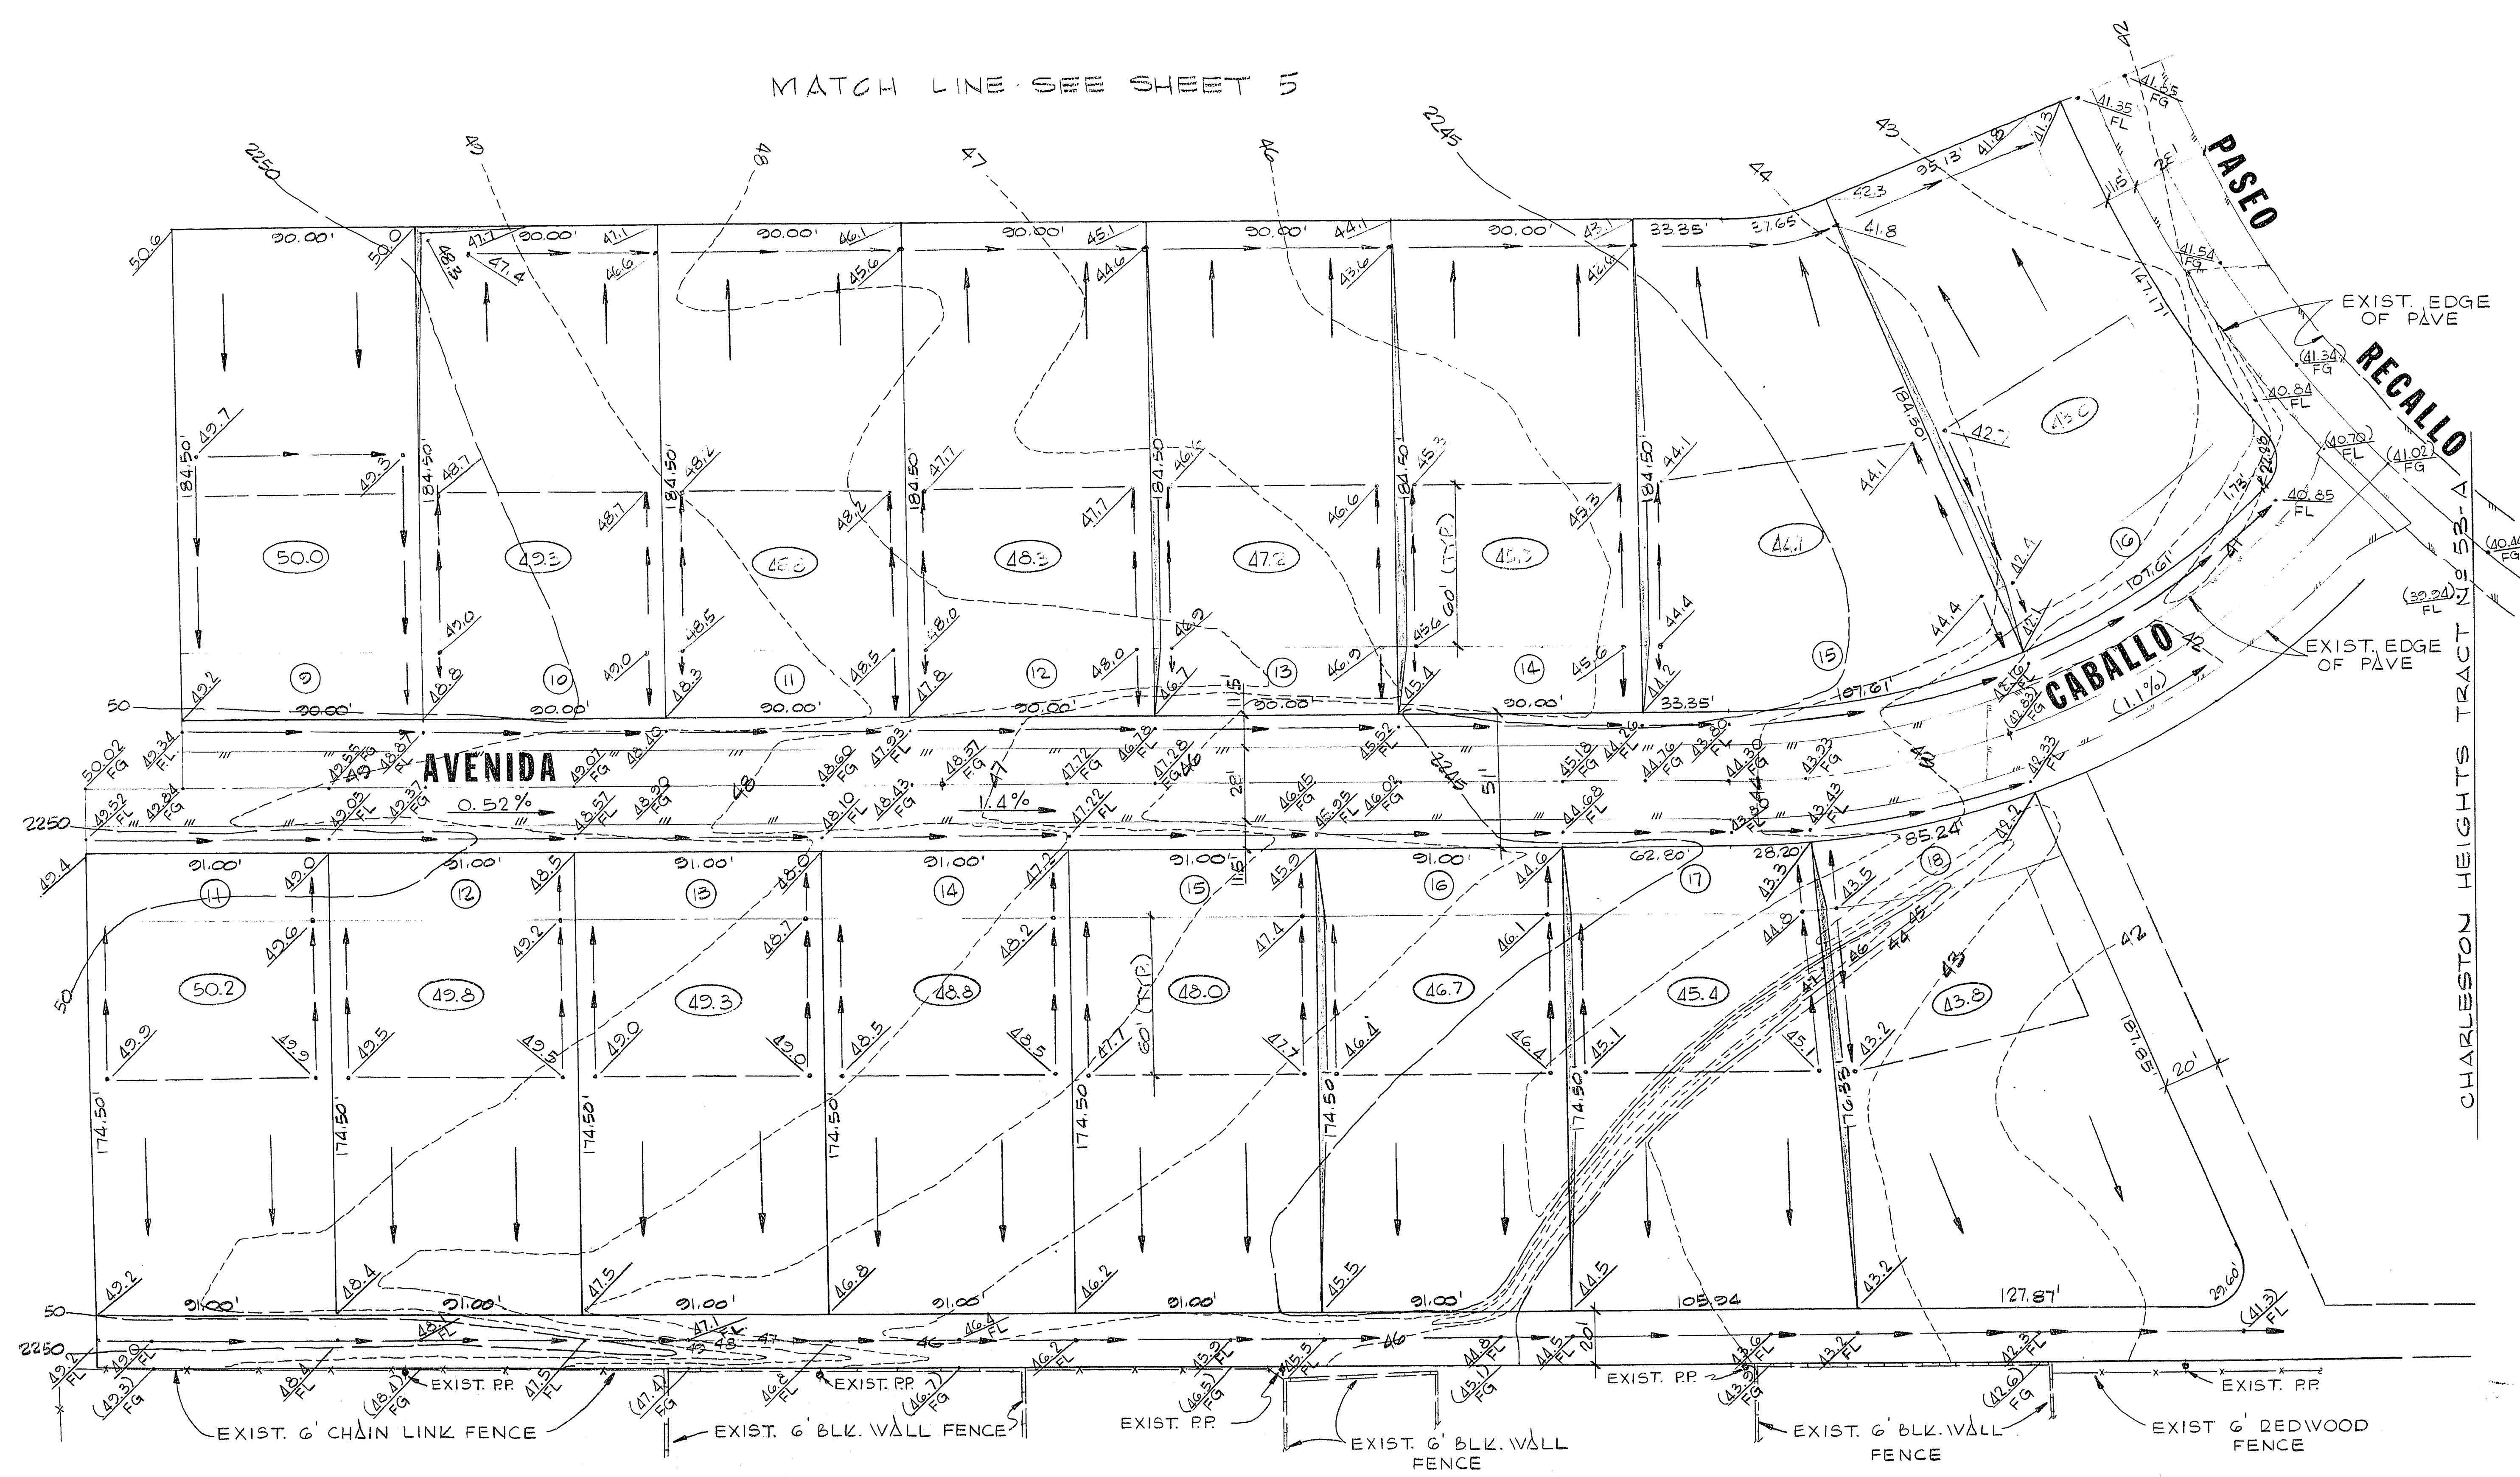

G. C. WALLACE
Consulting Engineers, Inc.
1100 East Sahara Ave. • Las Vegas, Nevada 89104 • 732-3330

BECKER & SONS
CHARLESTON HEIGHTS — TRACT NO. 53-B
GRADING PLAN III

SHEET
3
OF 8 SHEETS

(GRADING) 107g.1040.50B

MATCH LINE - SEE SHEET 2

345.110

10/77 DIETERICH-POST 2112B .003 FILM