

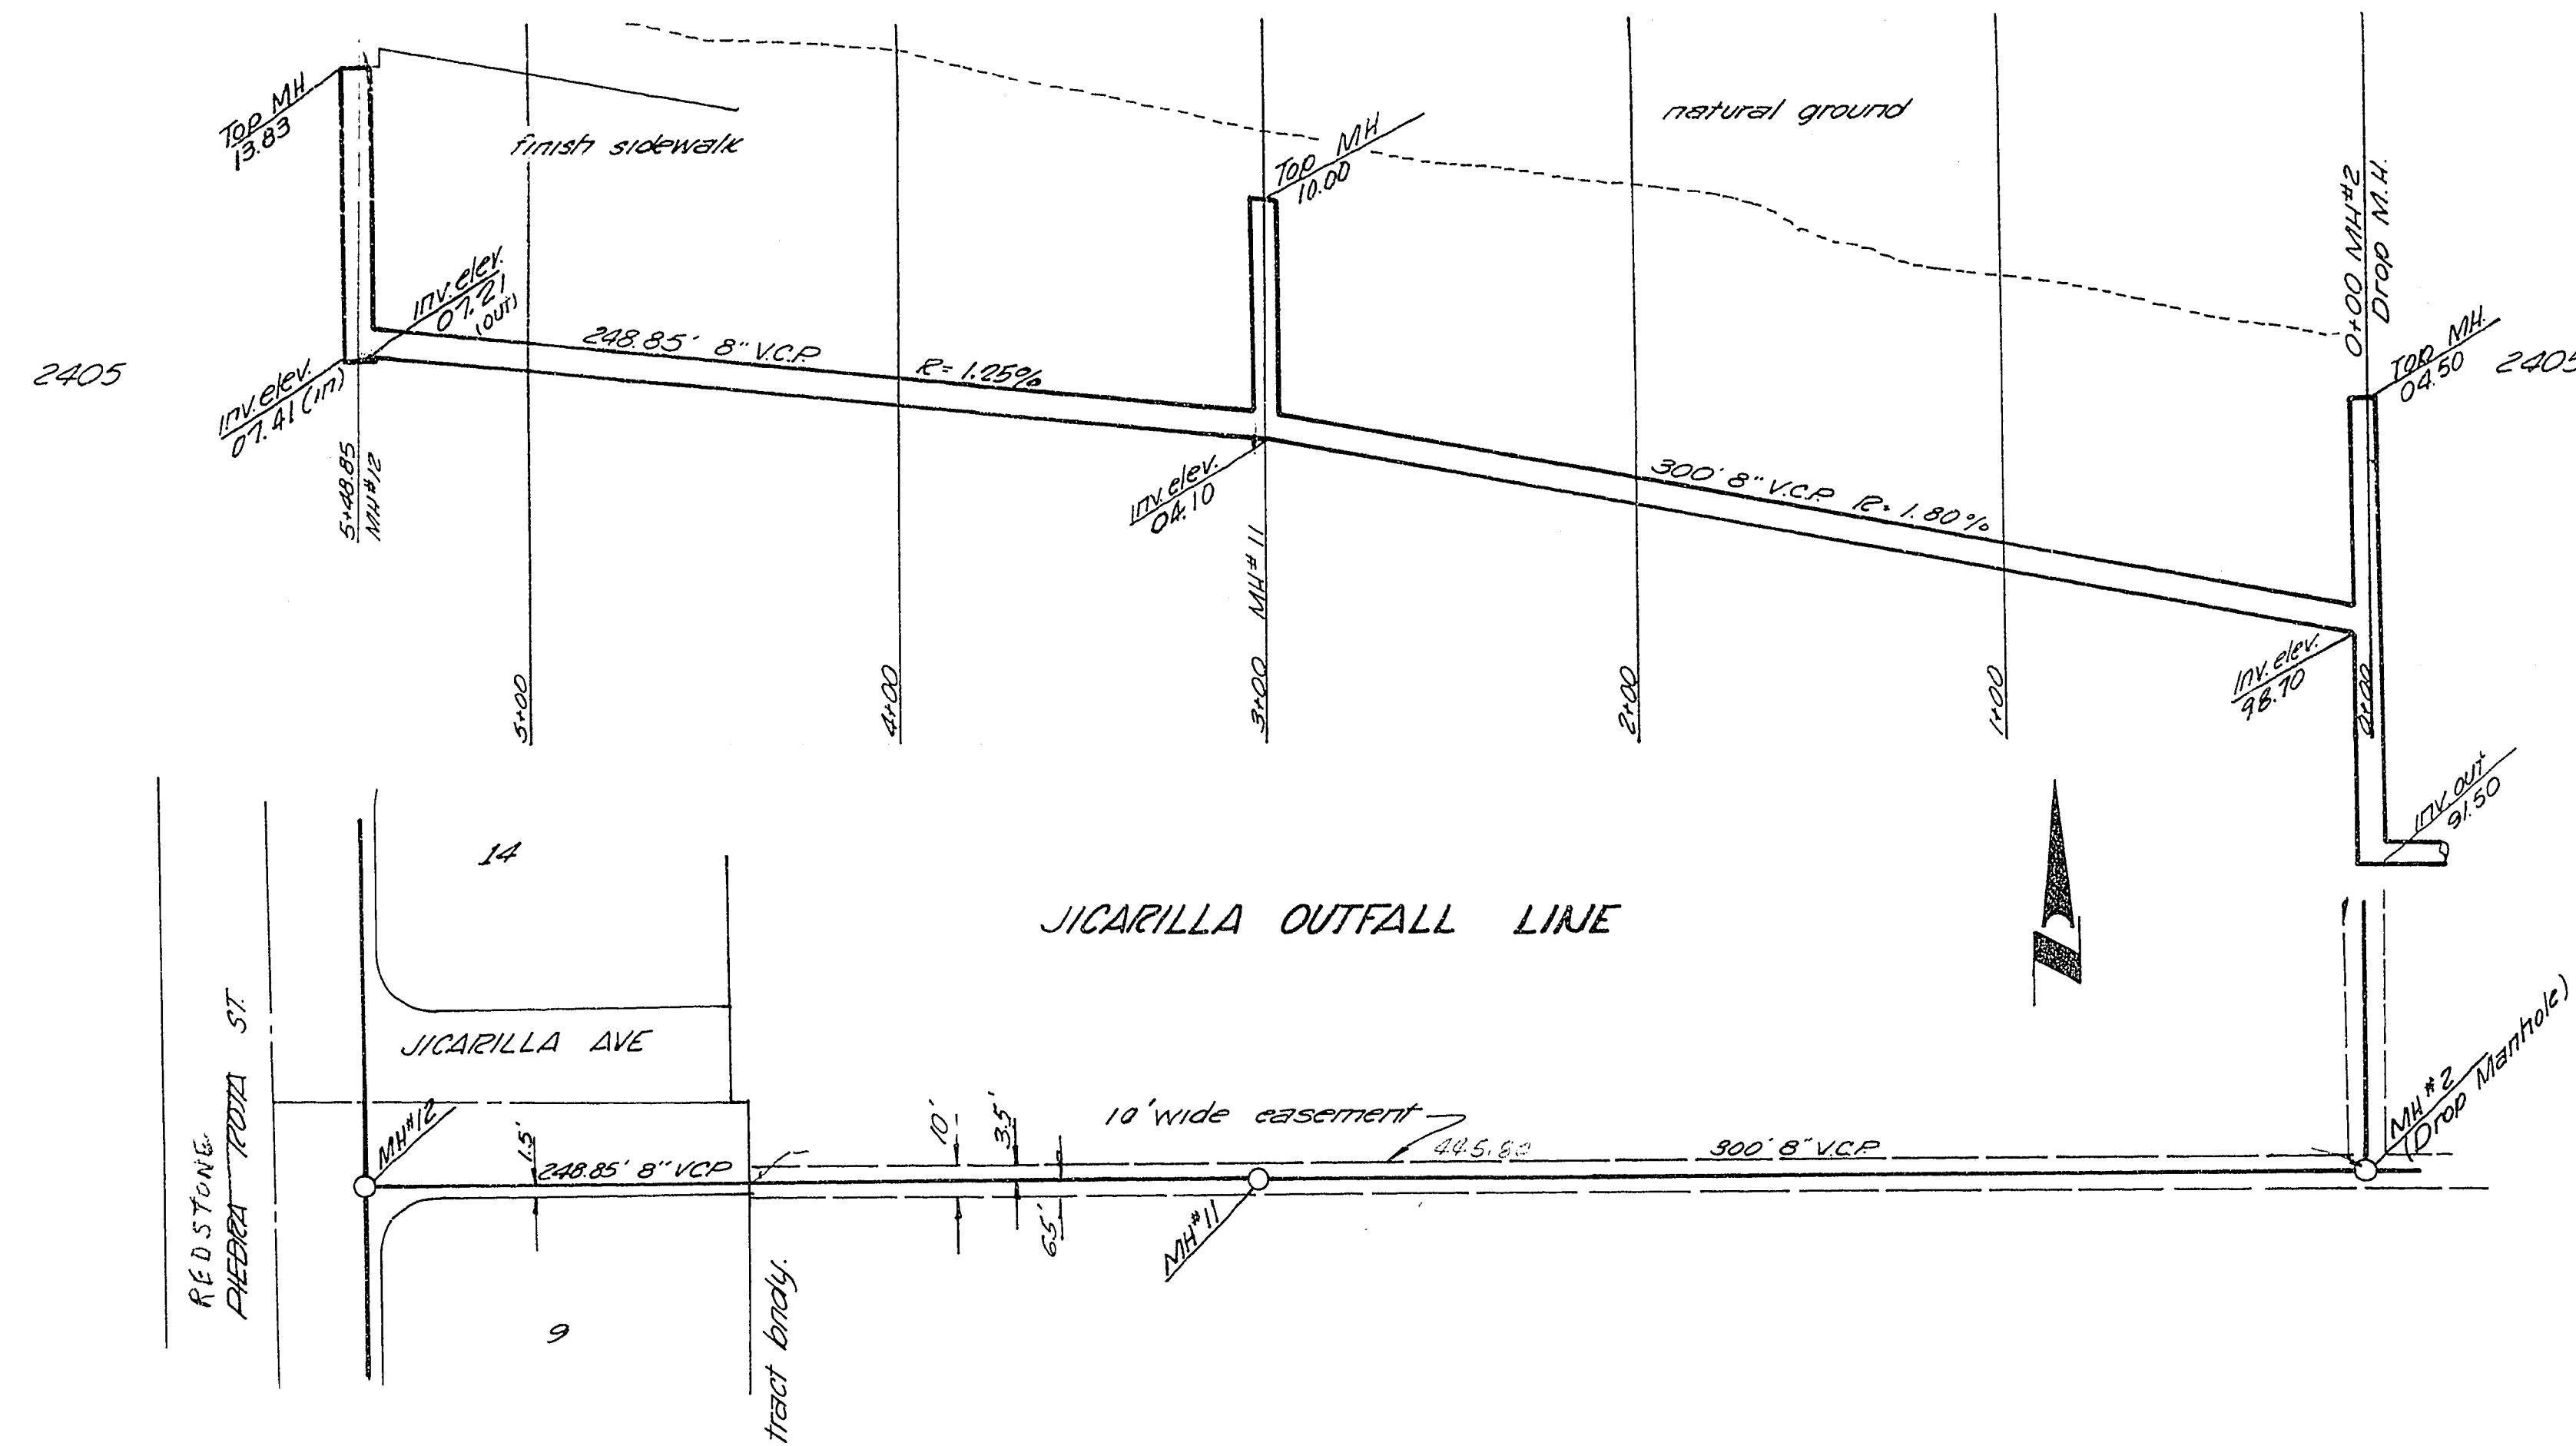


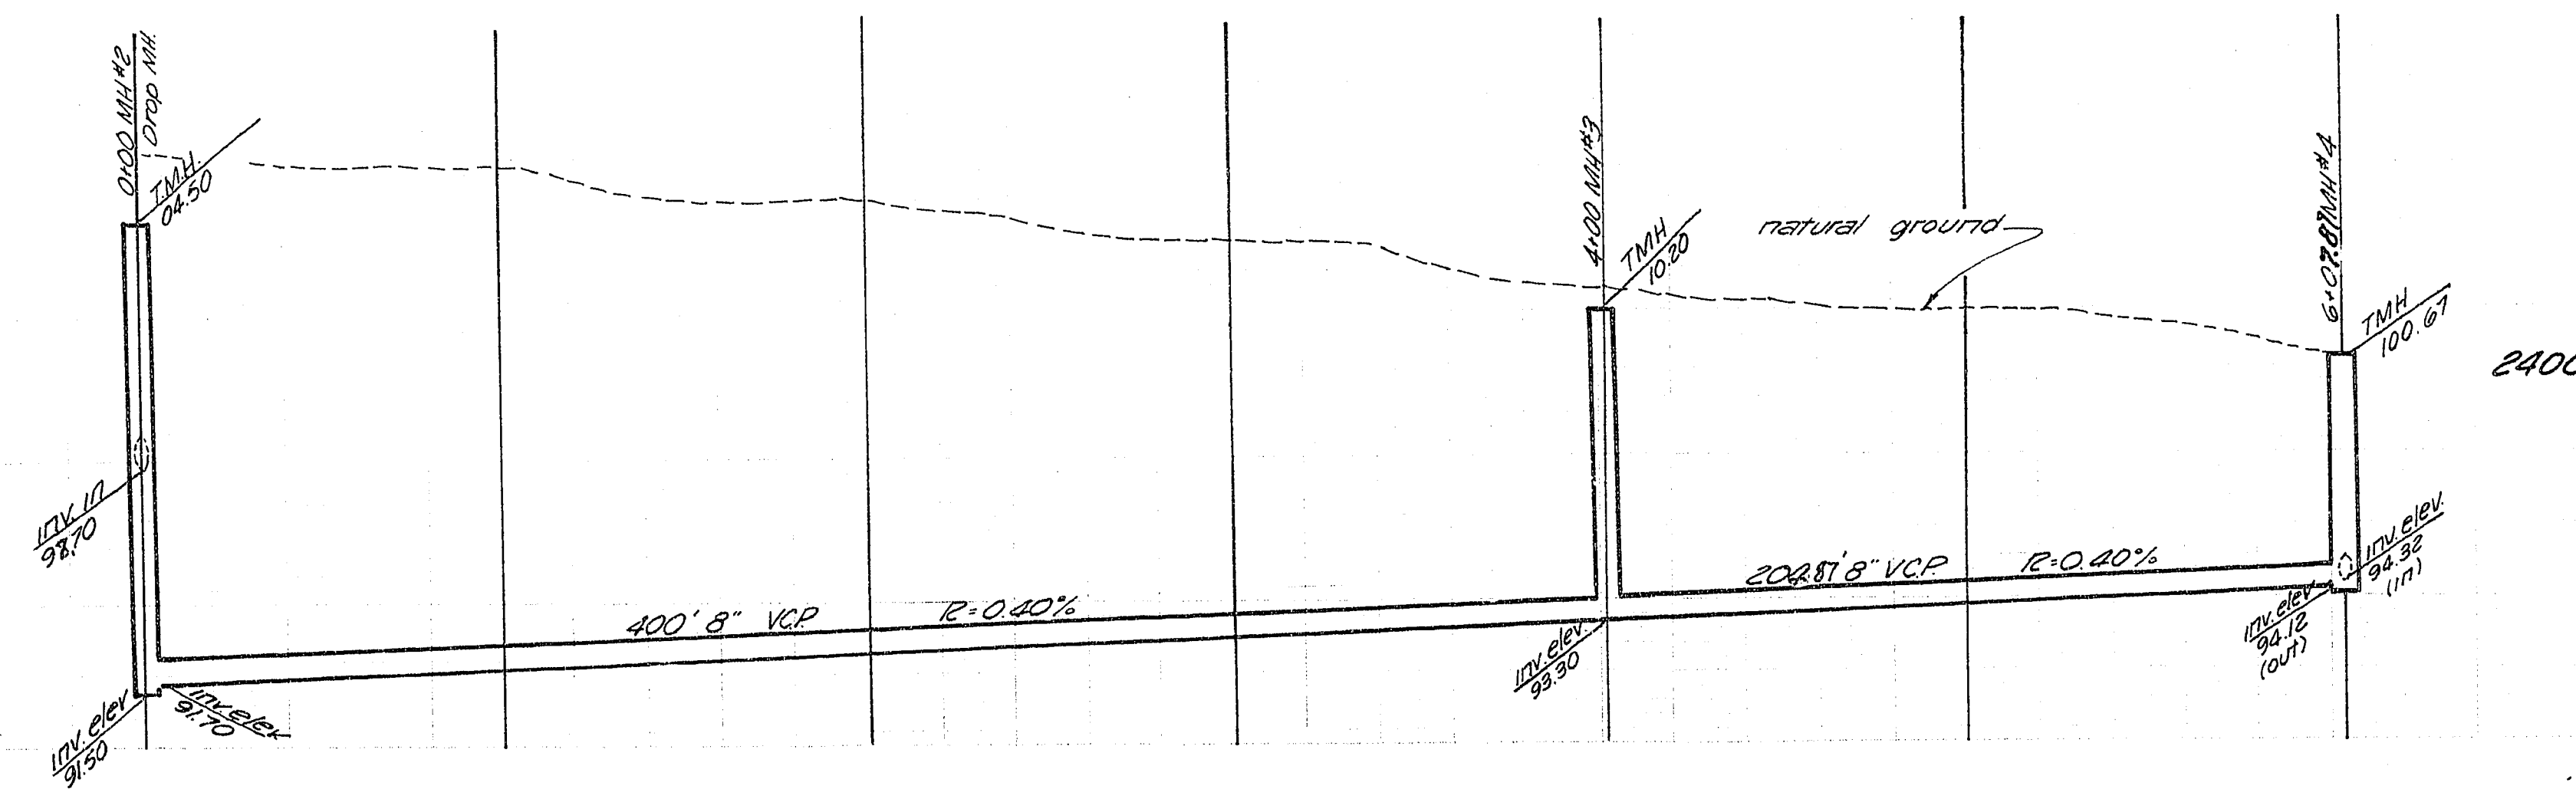


SCALE
Vertical 1" = 4'
Horizontal 1" = 40'

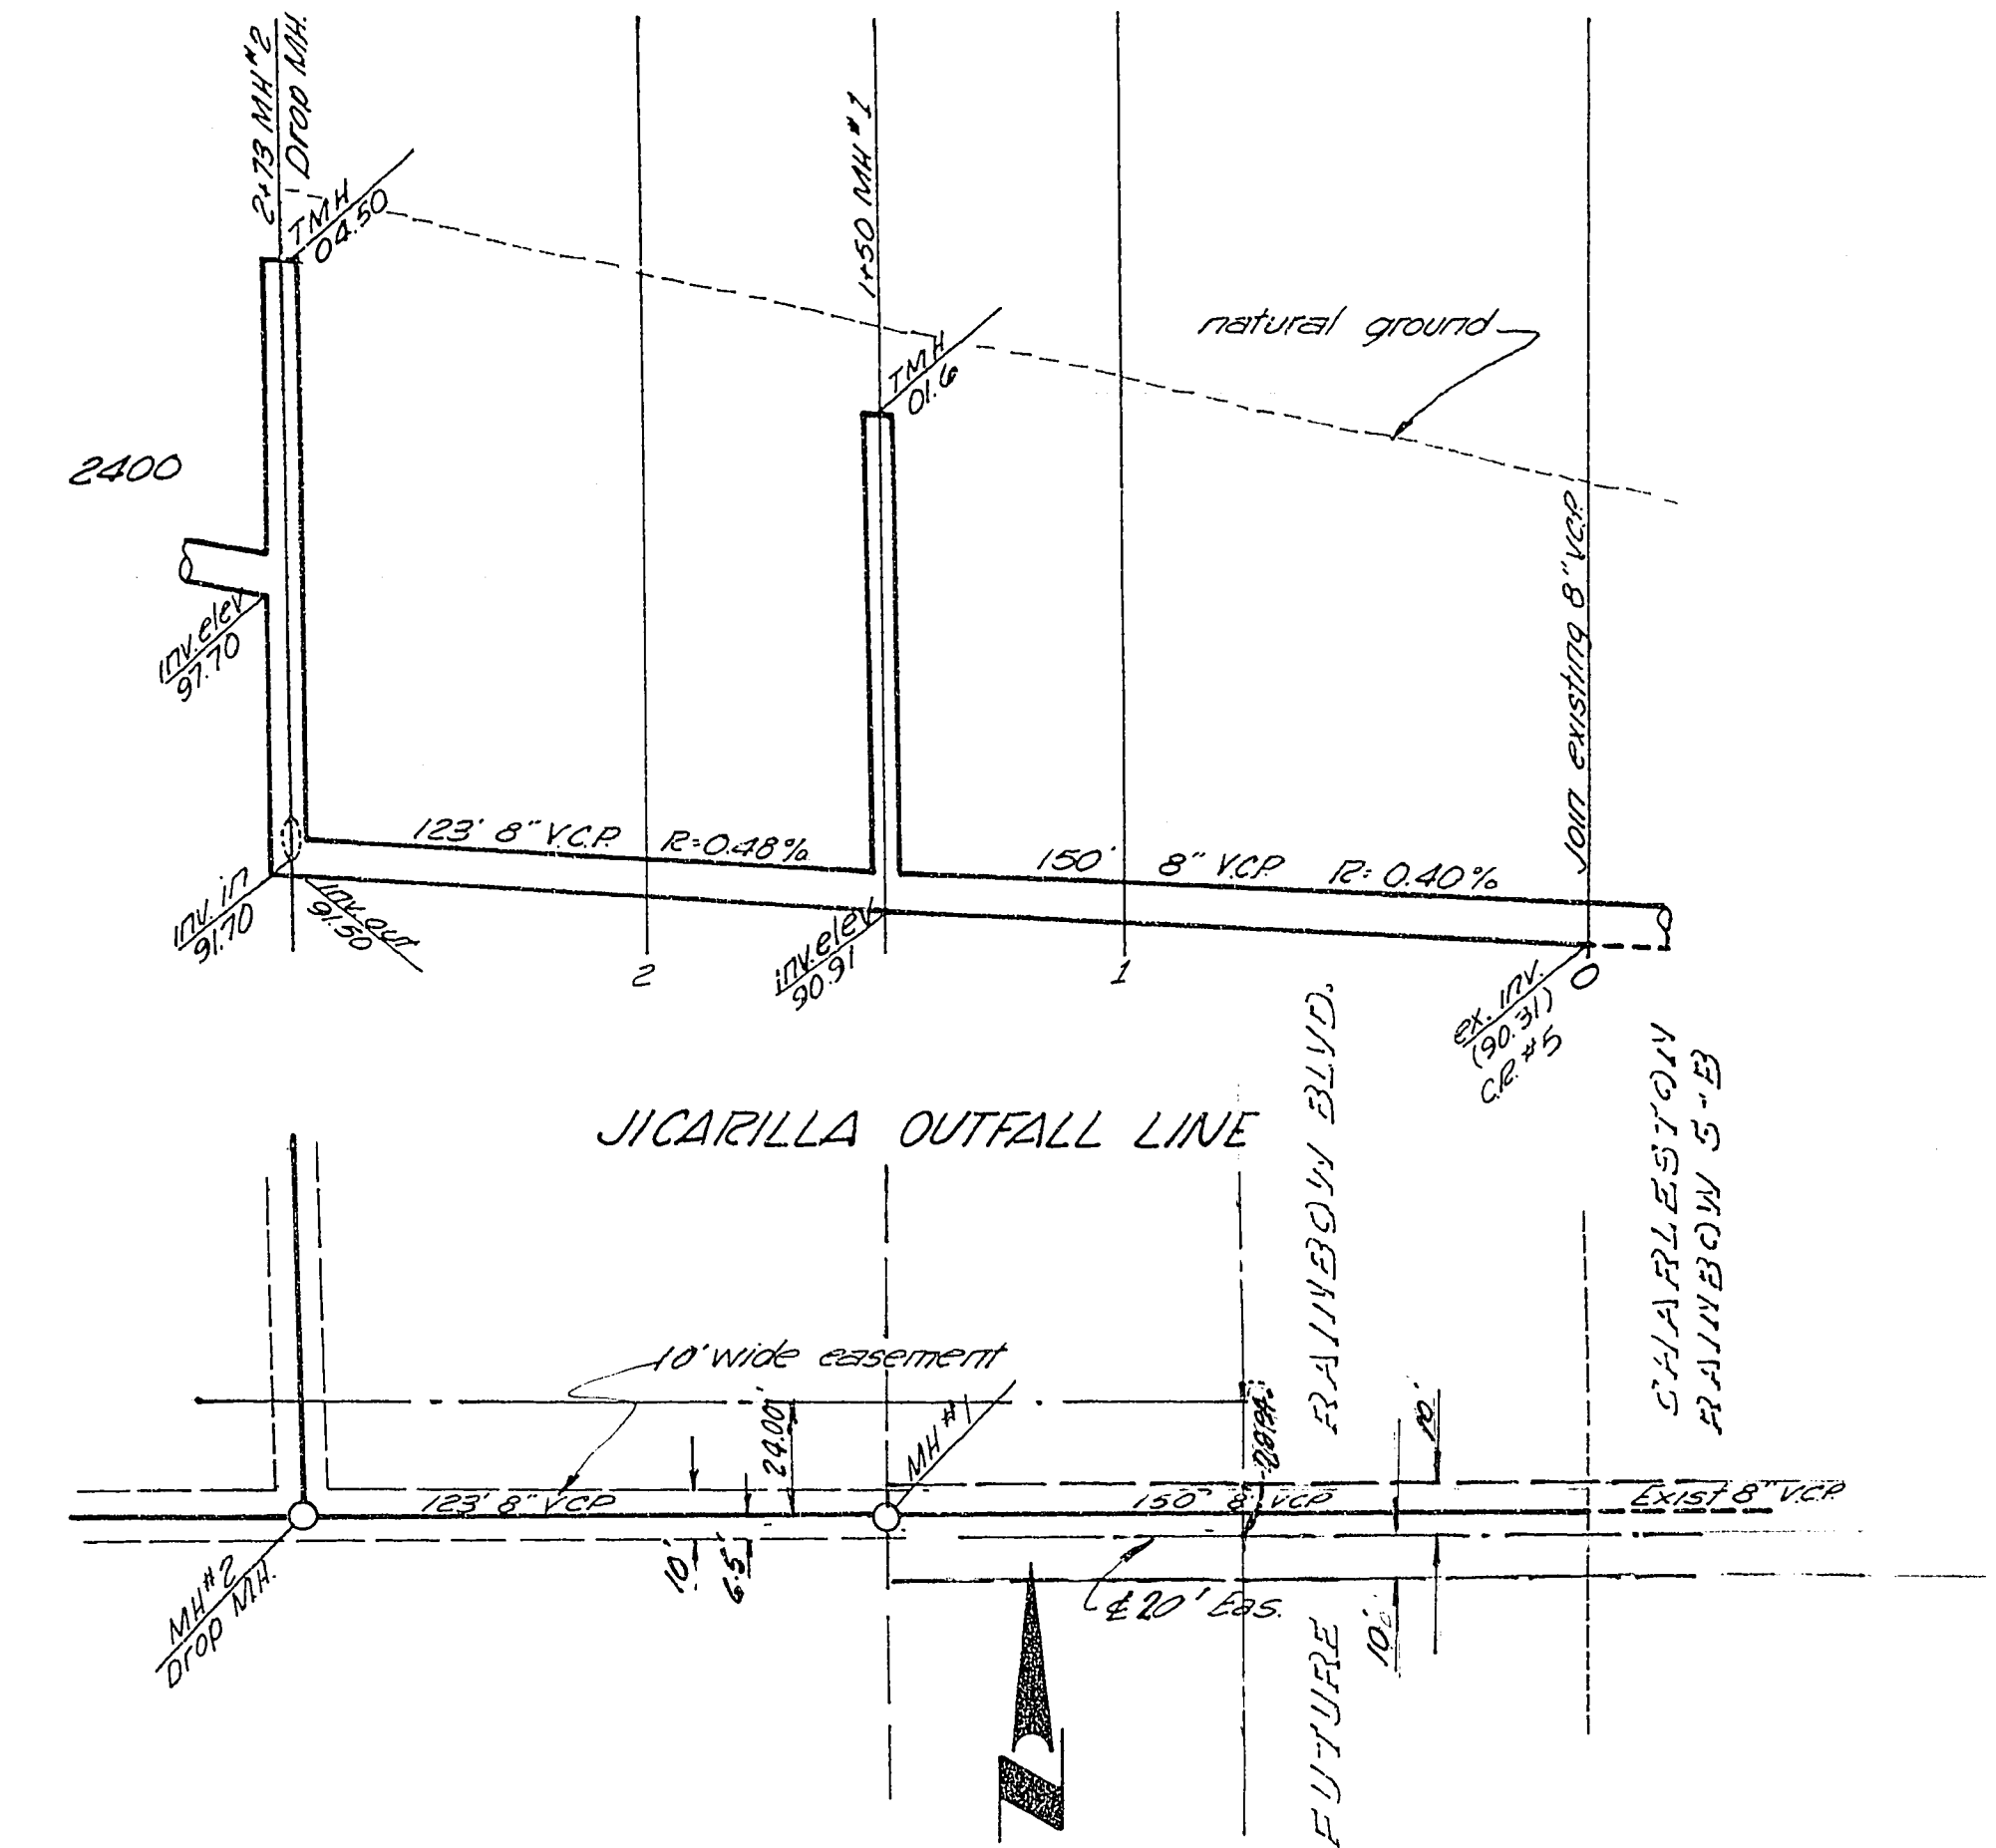

SCALE
Vertical 1" = 4'
Horizontal 1" = 40'

LA BARRANCA OUTFALL LINE

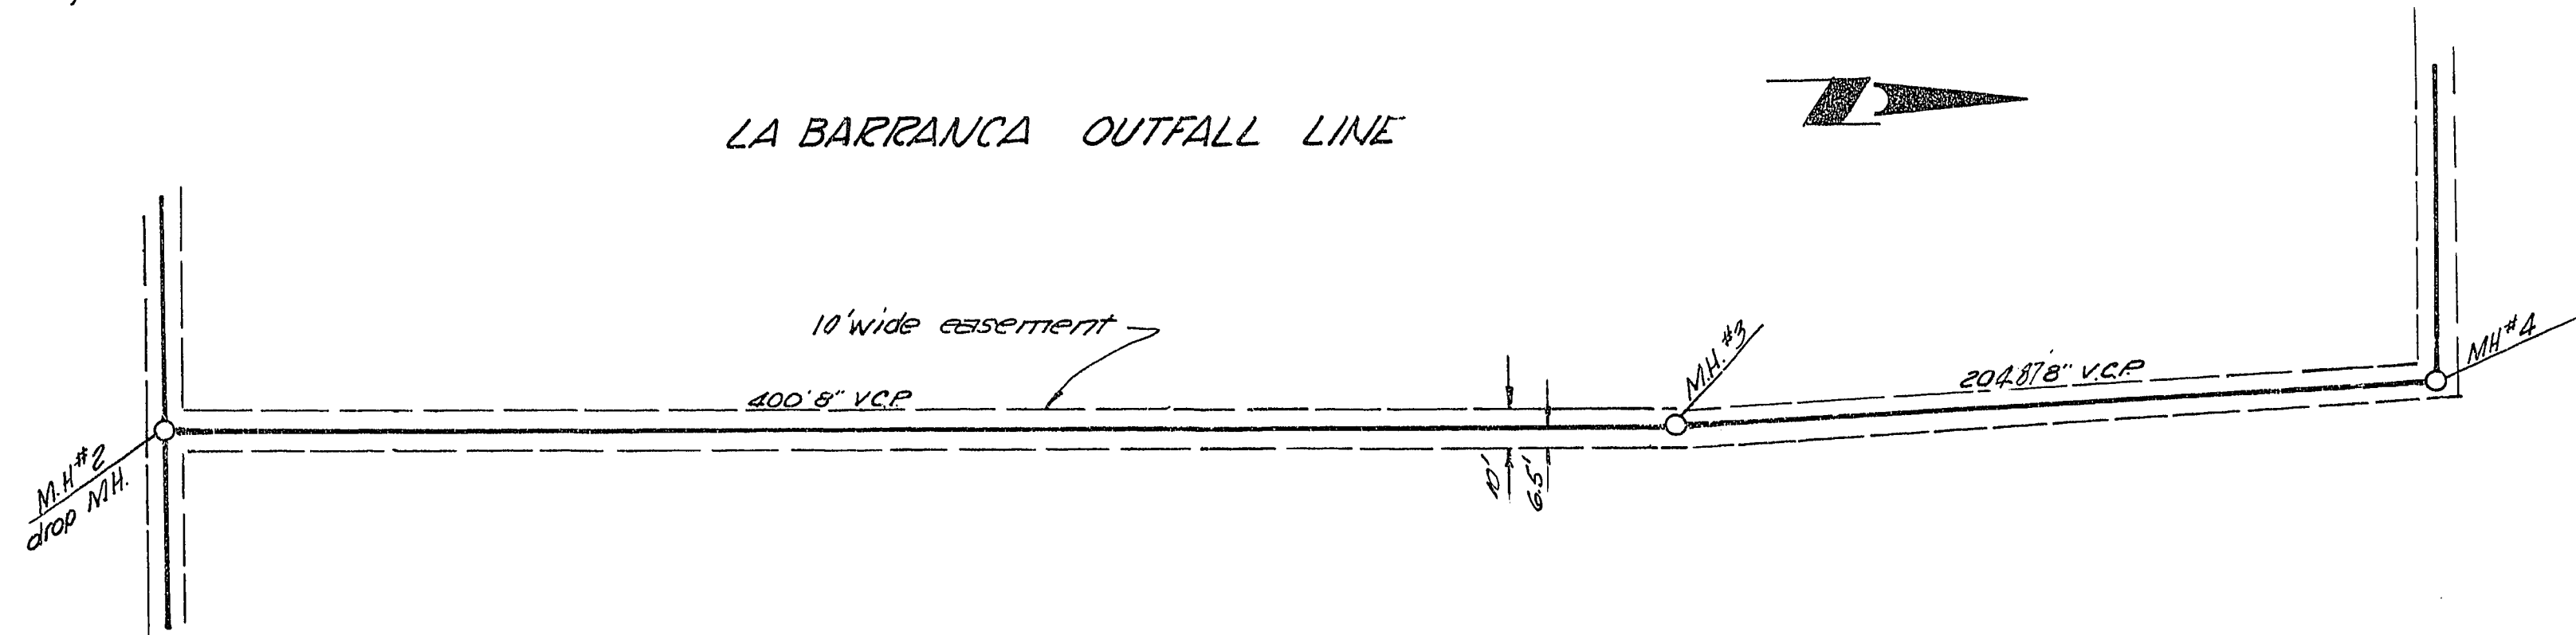

APPROVED BY

Supt. of Sanitation

Las Vegas City Engineer

J. D. ...
Field Engineer, City of Las Vegas

SUBMITTED BY

Victor G. Kremerbauer
Victor G. Kremerbauer Nev. R.C.E. 1511

7-2-68
date

VOORHEIS-TRINDLE CO. OF NEVADA 2209 PARADISE ROAD LAS VEGAS, NEVADA	
CHARLESTON RAINBOW UNIT 6-A	17
SEWER PLAN AND PROFILE OUTFALL LINES	of 17

NOTE: Inverts & Grades Revised 9-4-68 Rp