
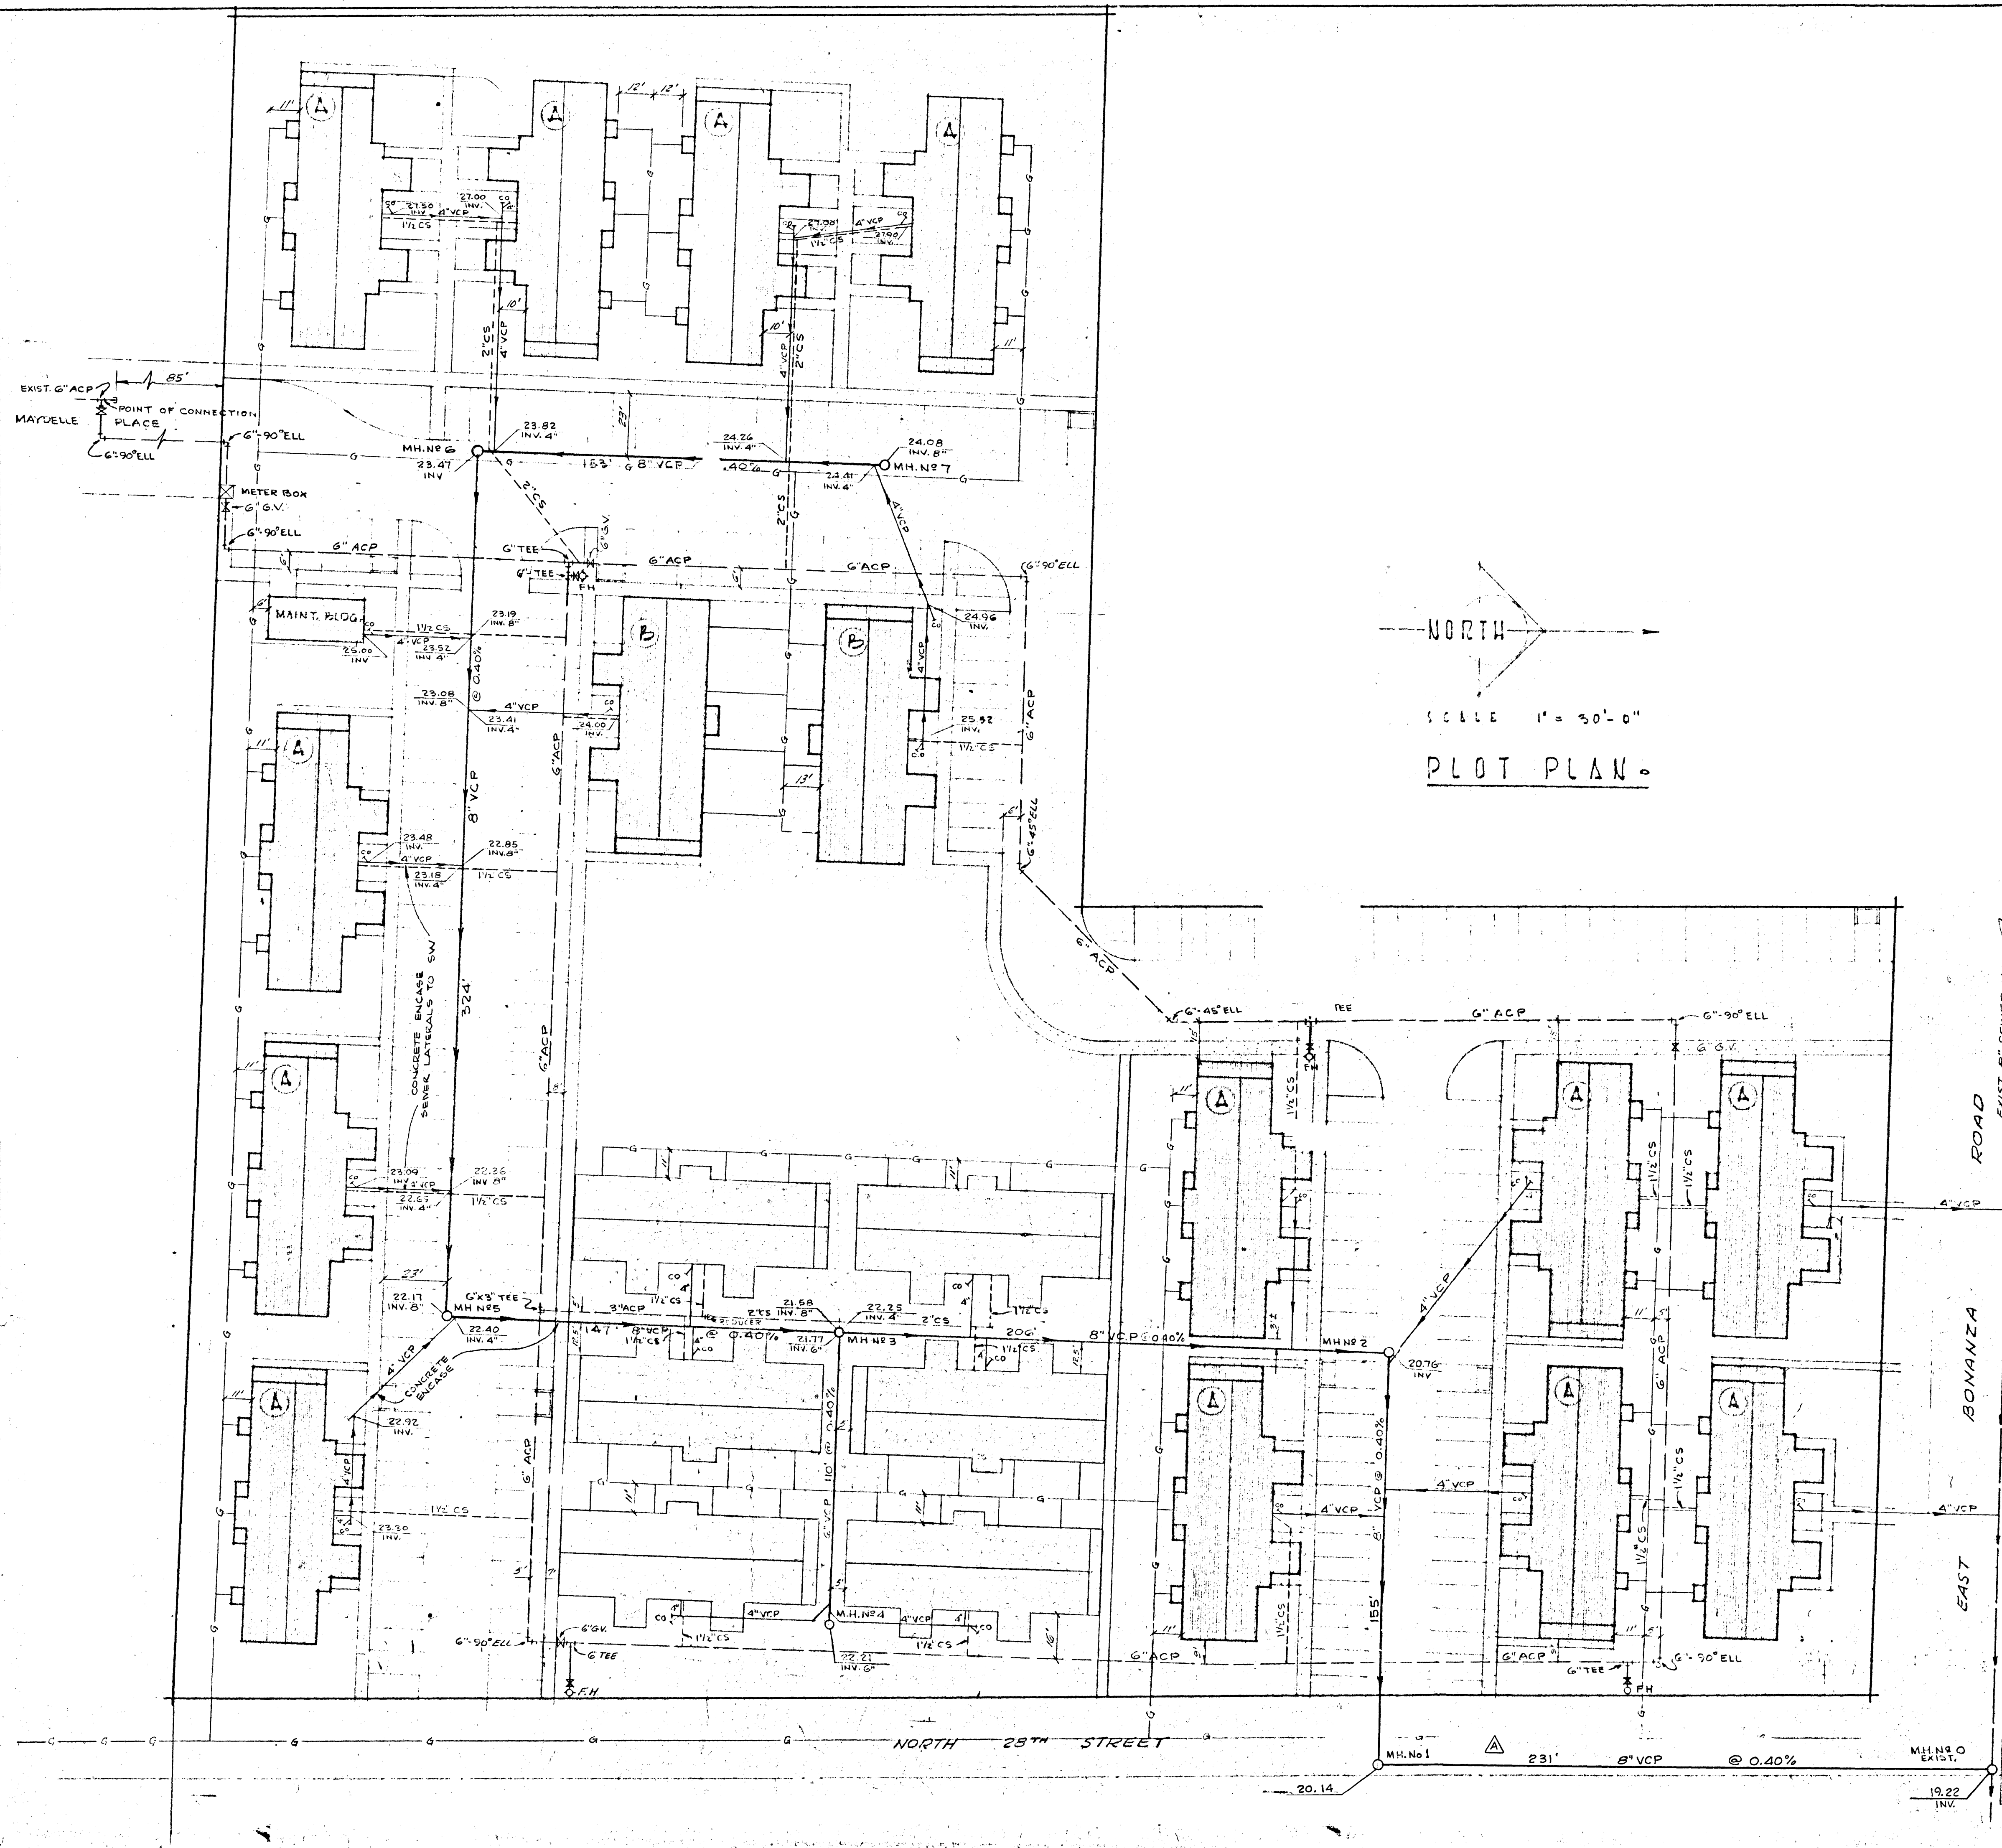


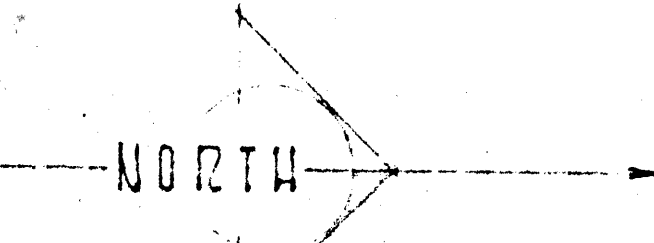


 NORTH
 SCALE 1" = 30'-0"
 PLOT PLAN

SIGNATURE BLOCK-DATE

W.B. Lehling	8/1/63
C.W. Williams	3/10/64

SEWER QUANTITIES

ON SITE	OFF SITE
8" VCP 960 - Lin. ft.	8" VCP 241 - Lin. ft.
6" VCP 110 - Lin. ft.	MANHOLE 1 - Each
4" VCP 1165 - Lin. ft.	4" VCP 91 - Lin. ft.
MANHOLE 6 - Each	
CLEANOUT 25 - Each	
CONC. ENCASEMENT 129 - Lin. ft.	

WATER DISTRIBUTION QUANTITIES

ON SITE	OFF SITE
6" ACP 1783 - Lin. ft.	6" ACP 100 - Lin. ft.
3" ACP 65 - Lin. ft.	6" TAPTEE & VALVE 1 - Each
2" C.S. 370 - Lin. ft.	6" - 90° ELL 1 - Each
1 1/2" C.S. 689 - Lin. ft.	
R.H. ASSEMBLY 4 - Each	
6" Valve 4 - Each	
Plus Misc. Fittings, etc.	
6" Meter & Box 1 - Each	

NOTE: The above quantities were converted to building lines.

- LEGEND**
- Sewer line
 - Water line
 - Clean out
 - Manhole
 - Fire Hydrant
 - Copper Service (Size as shown)
 - Sewer Invert
 - Gate Valve
 - Gas Distribution System to be installed by local utility company to meet applicable requirements. Each unit to be metered at bldg.

Note: Sewer services to have 30" cover & 1% min. slope except as shown.

REVISED - M.H. No. 1 - LOCATION - JUL-RH - 7/31/63

PLUMBING PLOT PLAN


JULIUS GABRIELE A.I.A.
 AND ASSOCIATES
ARCHITECTS & ENGINEERS
 1420 LAS VEGAS BOULEVARD SOUTH
 LAS VEGAS, NEVADA DU 4-2052

APPROVED - *R.L. Kraemer* OPE 1343

REvised - 2-5-64 - RLR

DRAWN - C.F.D.	JOB NUMBER	SHEET NO.
DO NOT SCALE DRAWINGS	62-35	26
CHECKED - C.F.D.	DATE 13 Dec 62	OF 32

DRAWINGS AND SPECIFICATIONS - AS INSTRUMENTS OF SERVICE - ARE THE PROPERTY OF THE ARCHITECT WHETHER THE WORK FOR WHICH THEY ARE MADE BE EXECUTED OR NOT AND ARE NOT TO BE USED ON OTHER WORK EXCEPT BY AGREEMENT WITH THE ARCHITECT.

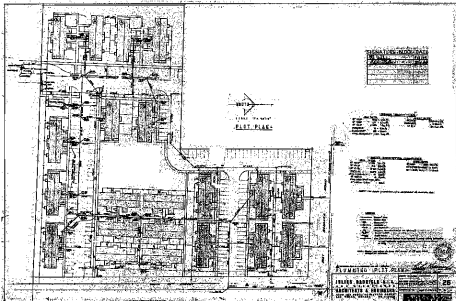

NO.	DESCRIPTION	DATE
1		
2		
3		
4		
5		

NO.	DESCRIPTION	DATE
1		
2		
3		

NO.	DESCRIPTION	DATE
1		
2		
3		

PLANNED FLOOR PLAN

JAMES HARRIS & SONS
ARCHITECTS & ENGINEERS
217 BROADWAY, NEW YORK

NO.	25
DATE	1910