



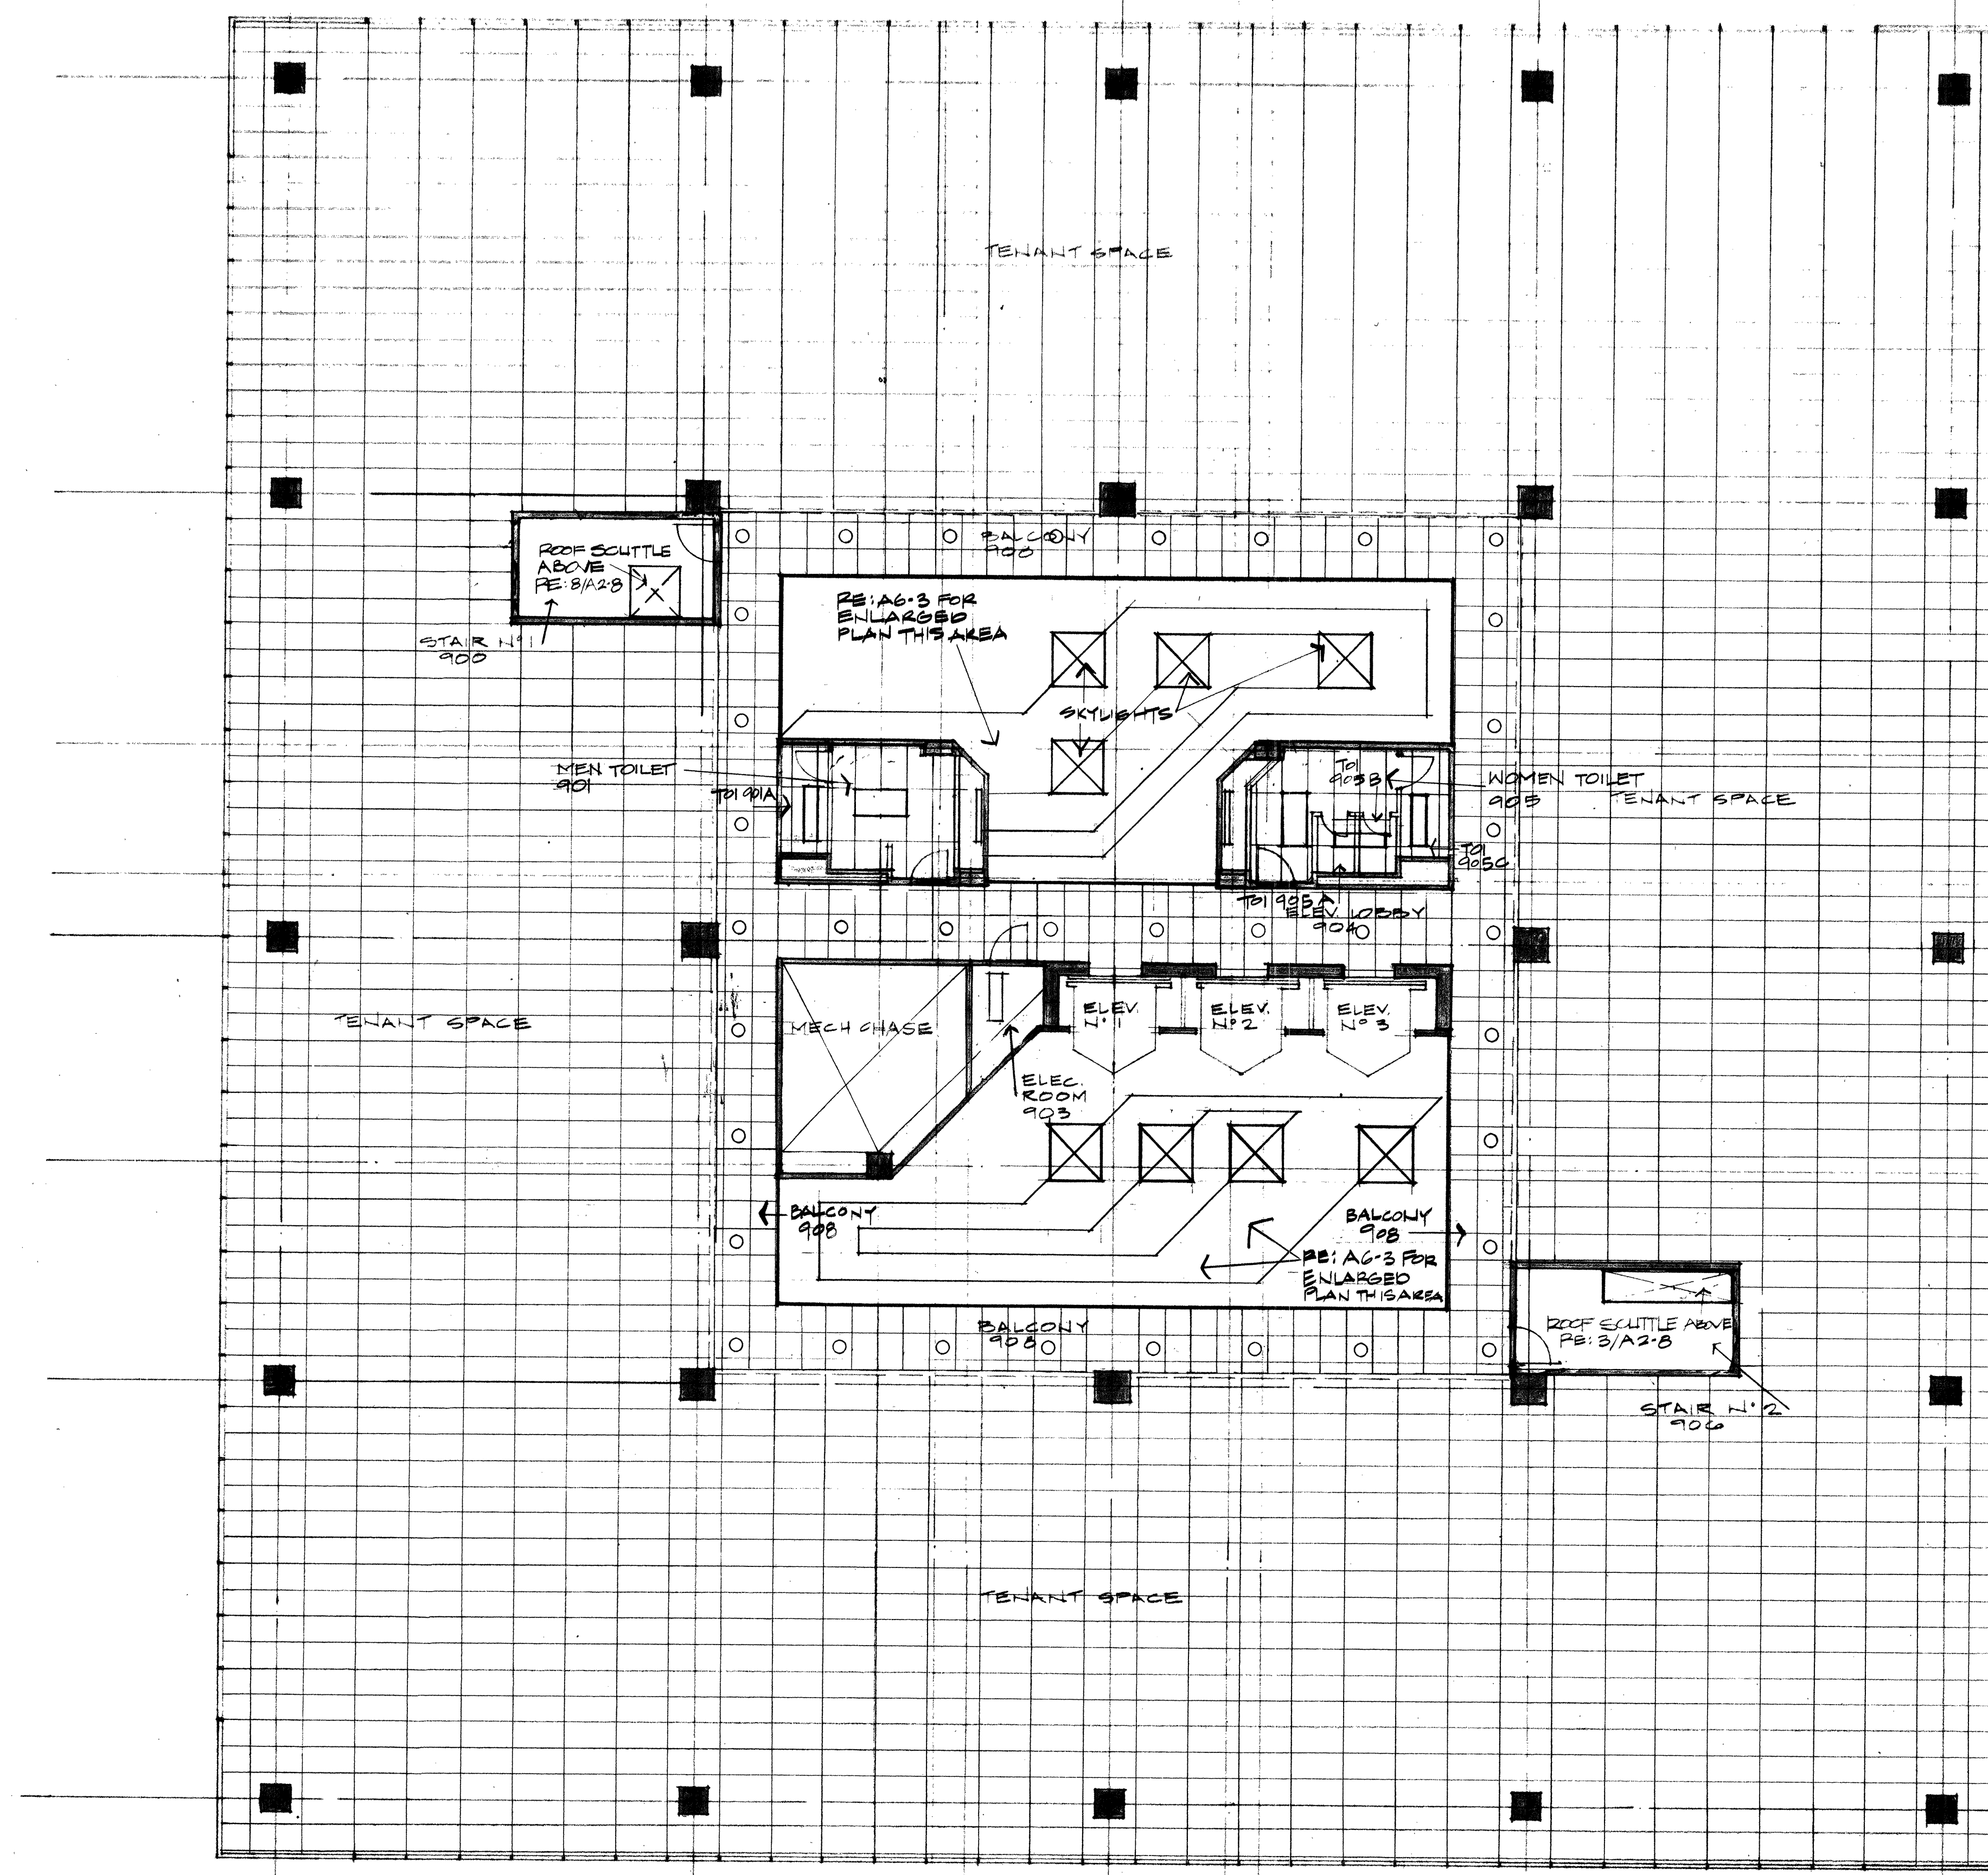

1 REFLECTED CEILING PLAN
9TH FLOOR PLAN
SCALE: 1/8"=1'-0"

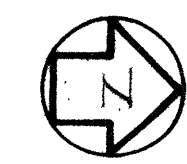

RE: SHT A2-9 FOR LEGEND & NOTES

333 RANCHO ROAD
LAS VEGAS
MEL POWERS INVESTMENT BUILDER

PROJECT
NUMBER

79-24

DATE
5-1-80

SHEET

A2-12

OF 19