


Submitted by: [Signature] Date 5/10/63
 Moote, Kempa & Galloway

Approved by: [Signature] Date 4-17-64
 City Engineer

Approved by: [Signature] Date 4-17-64
 Field Engineer

BENCH MARK Spike in power pole #27188 approx. 200' N. of
 W 1/4 corner on W. side of Decatur Ave. **ELEVATION 2203.81**

ULLOM DRIVE

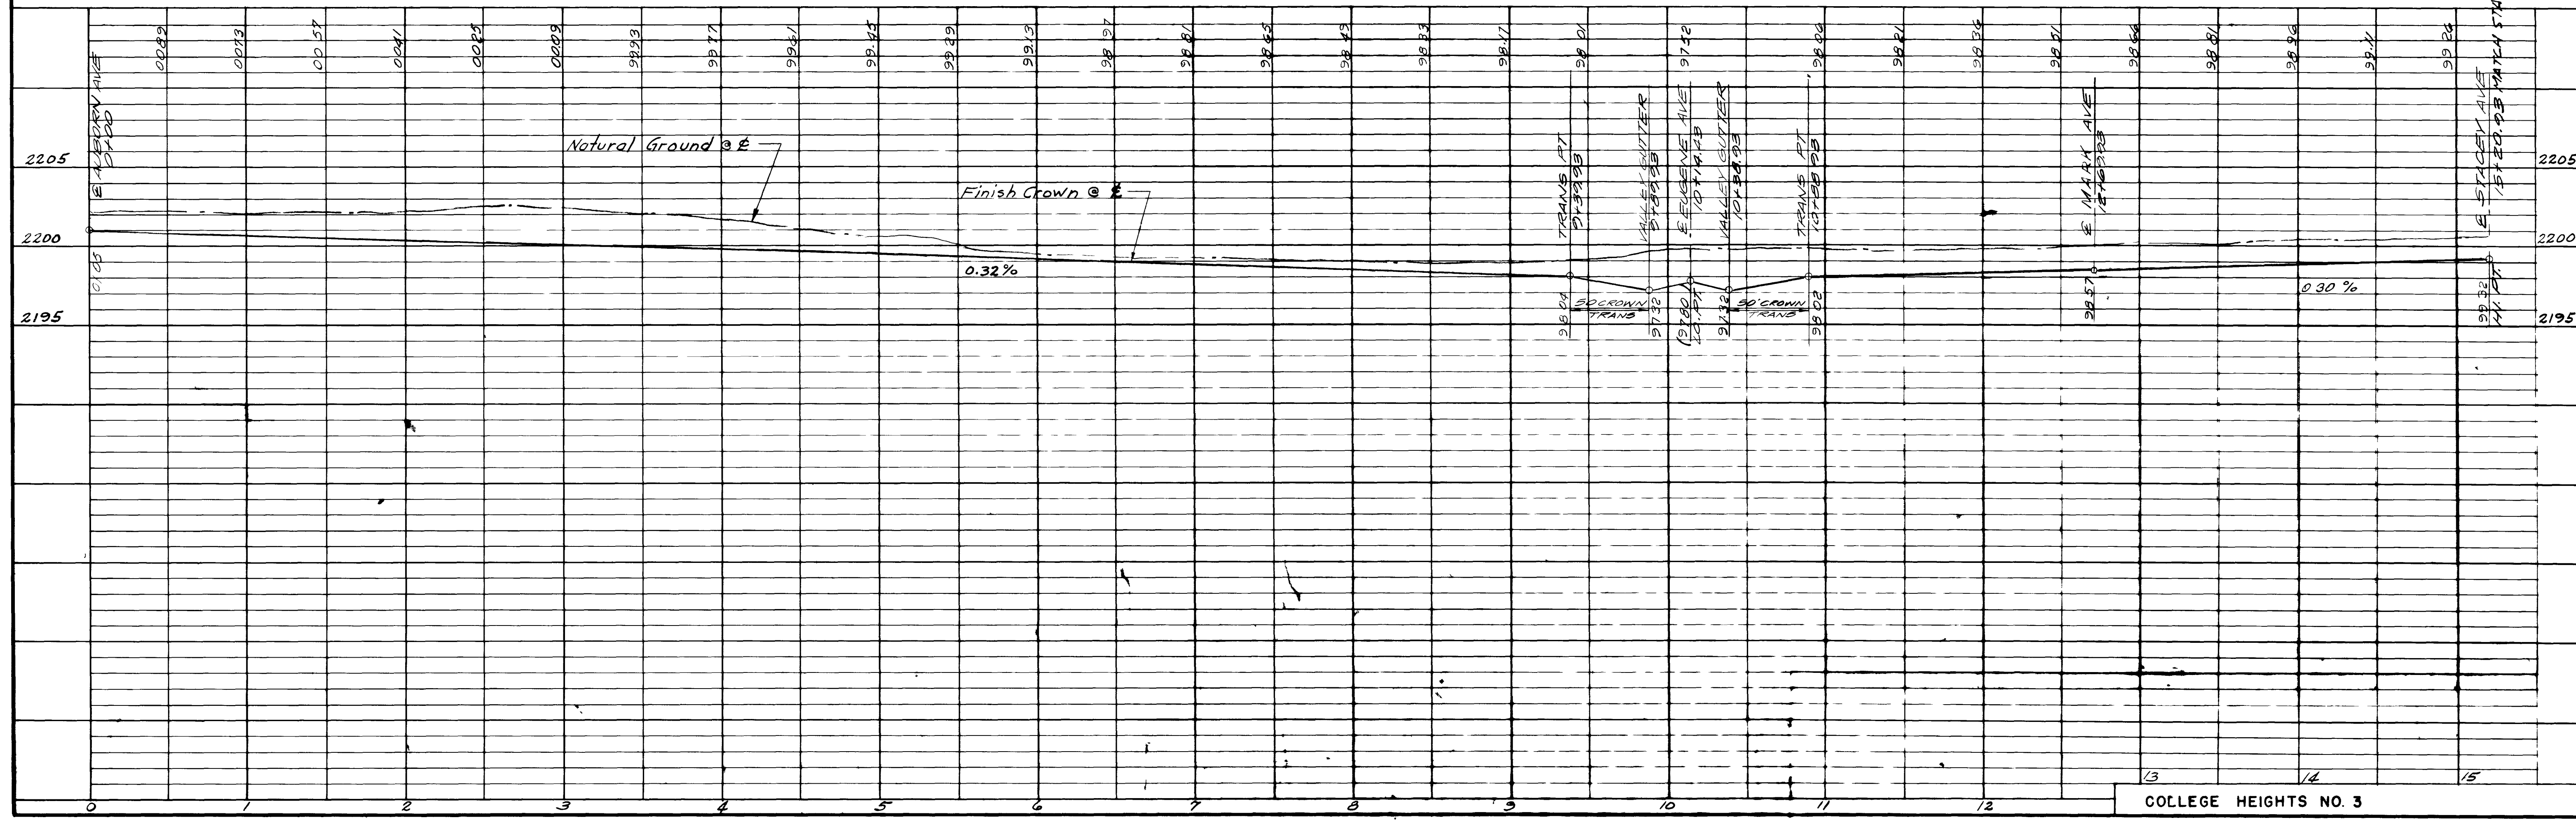

COLLEGE HEIGHTS NO. 3
 PART OF THE N1/2 OF SECTION 19, T.20S., R.6E., M.D.B.M.,
 CITY OF LAS VEGAS CLARK COUNTY, NEVADA

PREPARED FOR: FIRST WESTERN & LOAN

PAYING PLAN AND PROFILE

DATE: 5-3-63
 DRN. PLAN.
 CHD. G.V.
 APPD. RMG

REVISION: 1"=80'
 V SCALE: 1"=15'
 H SCALE: 1"=100'

JOB NO.: LV-1851A

OF 40

