


SHEET NO	DRAWING NO	DESCRIPTION
1	G1	COVER SHEET
2	G2	LWWD GENERAL NOTES, LEGEND AND AGENCY APPROVALS
3	G3	CITY OF LAS VEGAS GENERAL NOTES - I
4	G4	CITY OF LAS VEGAS GENERAL NOTES - II
5	G5	ABBREVIATION LIST
6	SV1	RIGHT-OF-WAY PLAN
7	C1	VILLA RIDGE DRIVE AND HIGHLAND FALLS DRIVE SITE PLAN
8	C2	SUGARVIEW AVENUE AND SPRING SHADOW ROAD SITE PLAN
9	CD1	VALVE VAULT DETAILS
10	CD2	RETAINING WALL DETAIL AND SECTIONS
11	E1	ELECTRICAL ABBREVIATIONS, SYMBOLS, LEGEND AND GENERAL NOTES
12	E2	VILLA RIDGE DRIVE AND HIGHLAND FALLS DRIVE ELECTRICAL PLAN
13	E3	SUGARVIEW AVENUE AND SPRING SHADOW ROAD ELECTRICAL PLAN
14	ED1	ELECTRICAL DETAILS I
15	ED2	ELECTRICAL DETAILS II
16	ED3	NV ENERGY - VILLA RIDGE POWER DESIGN
17	ED4	NV ENERGY - SPRING SHADOW POWER DESIGN
18	ED5	CENTURYLINK - VILLA RIDGE SERVICE DESIGN
19	ED6	CENTURYLINK - SPRING SHADOW SERVICE DESIGN
20	i1	INSTRUMENTATION ABBREVIATIONS, SYMBOLS, LEGEND AND GENERAL NOTES
21	iD1	INSTRUMENTATION DETAILS I
22	iD2	INSTRUMENTATION DETAILS II

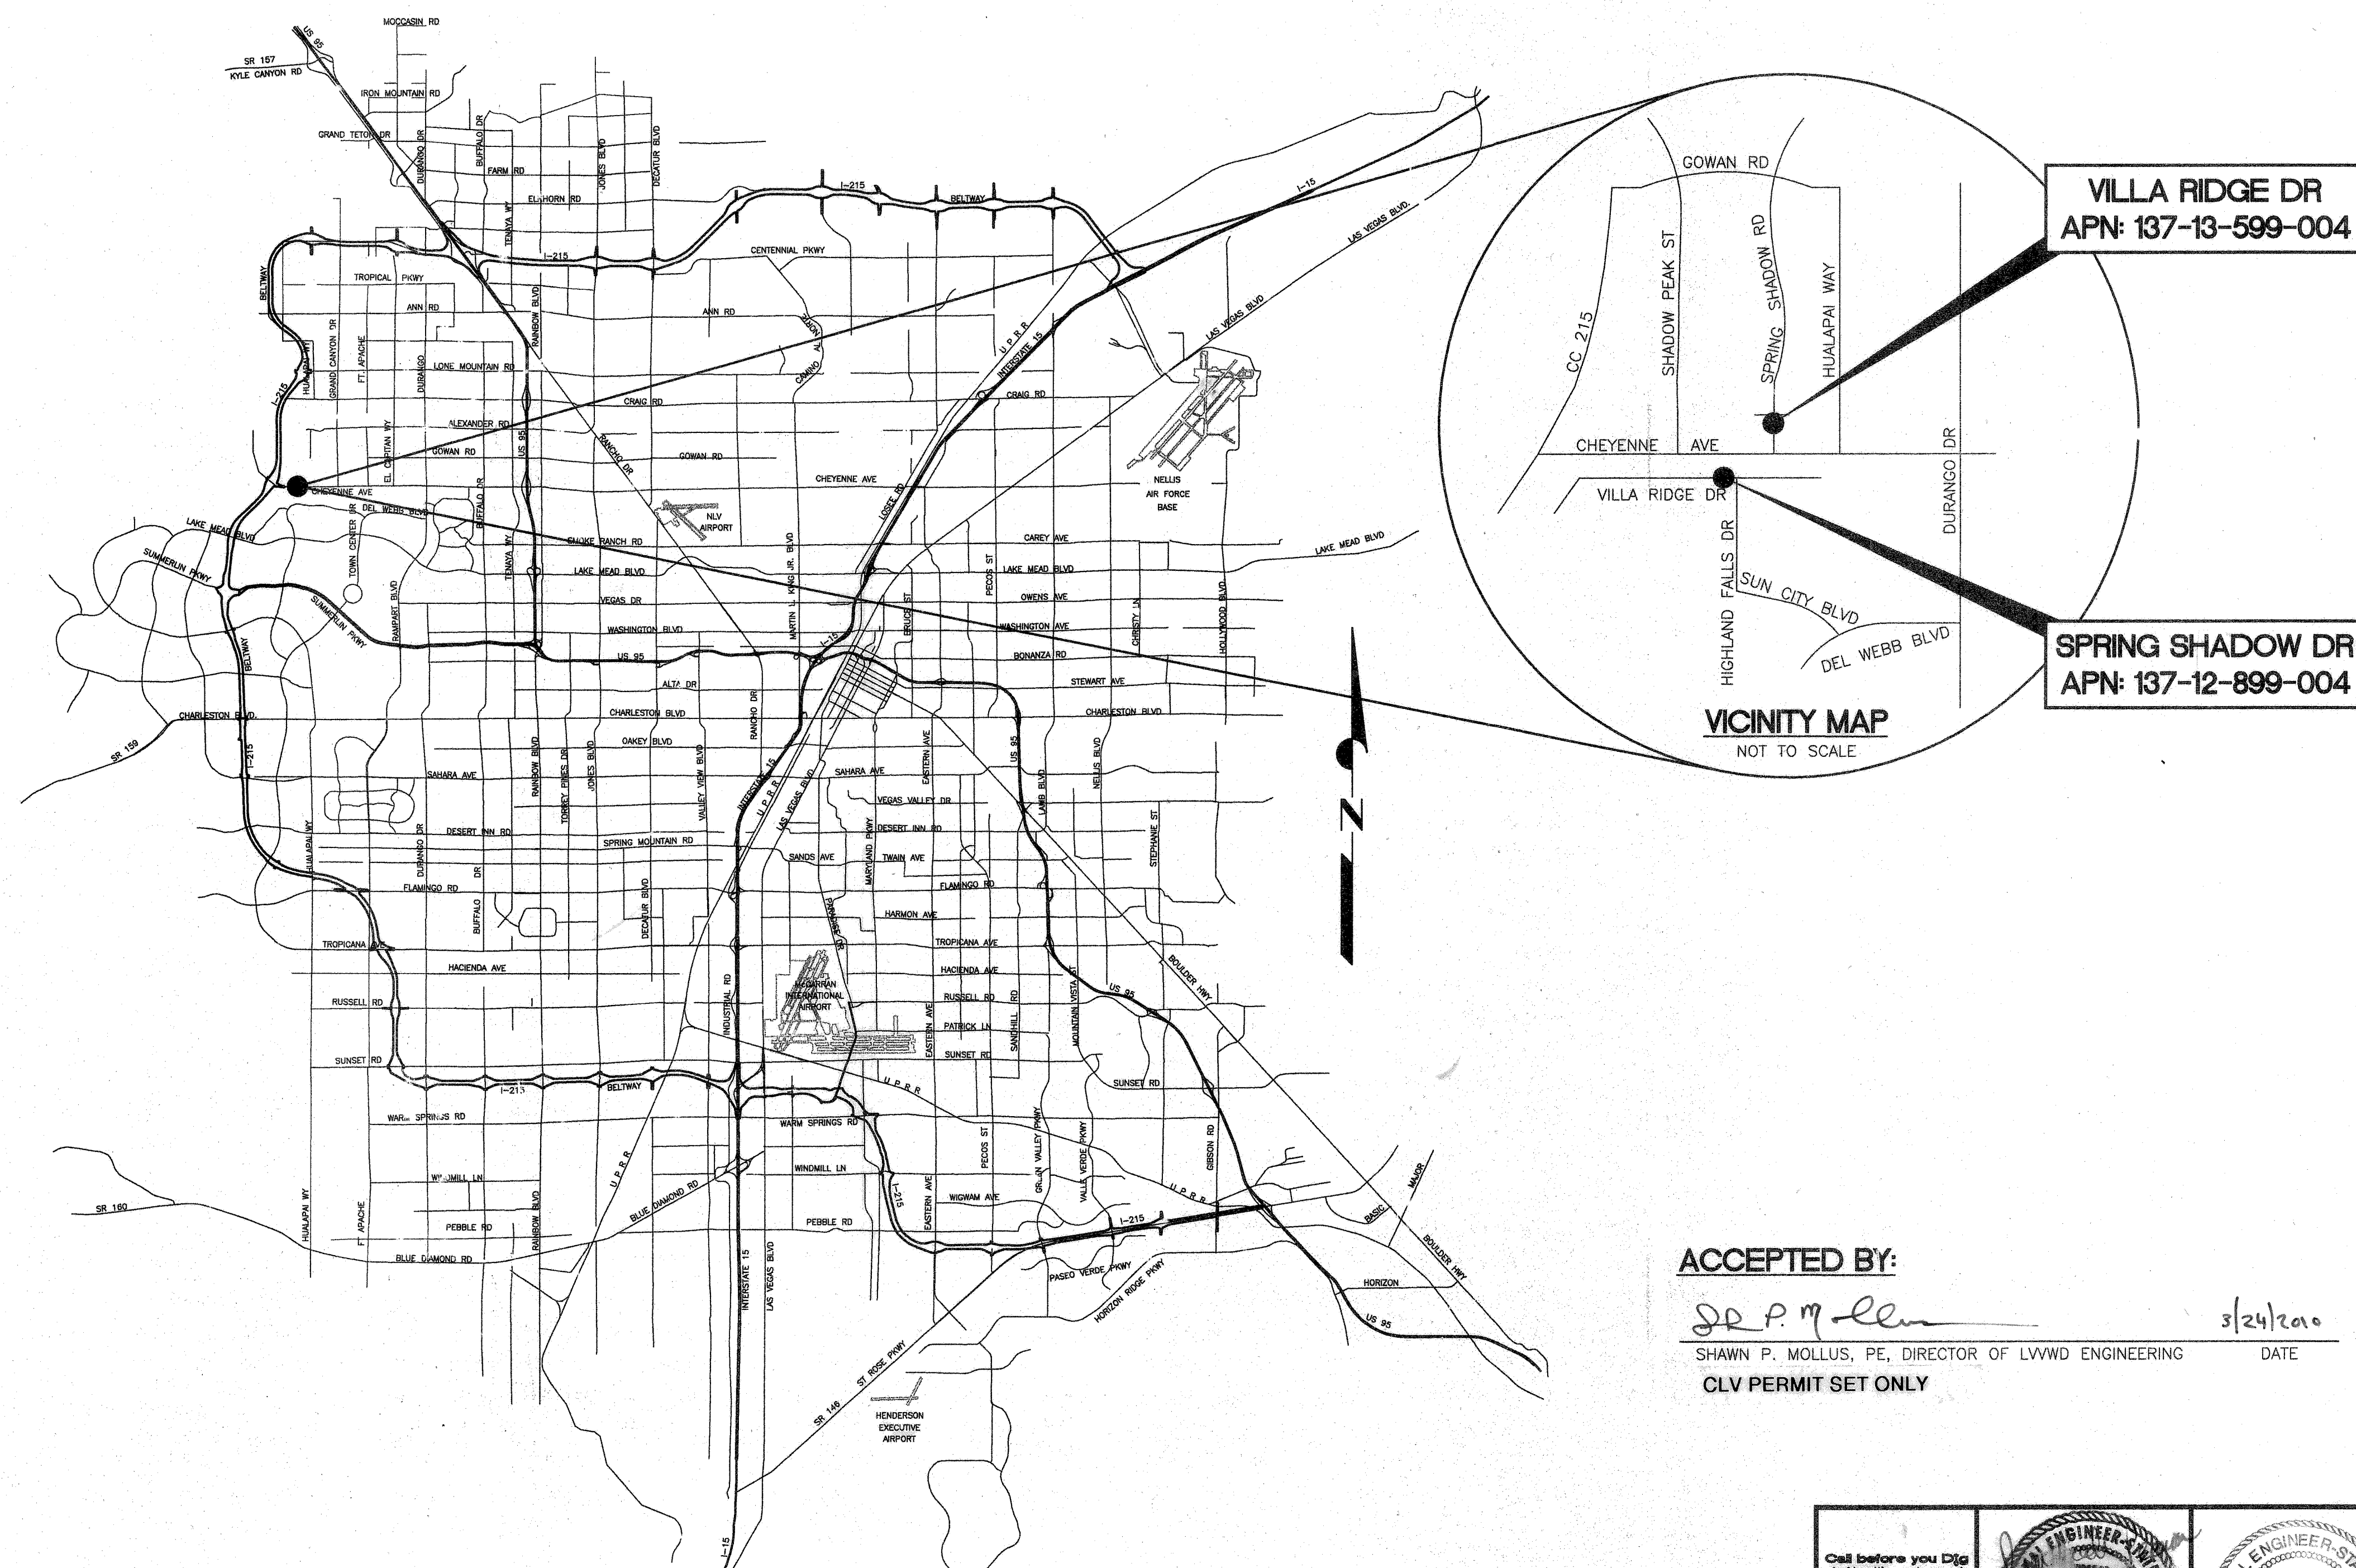

SHAWN P. MOLLUS, PE, DIRECTOR OF LWWD ENGINEERING
CLV PERMIT SET ONLY

CHEYENNE 2975 ZONE MOTOR OPERATED VALVES

COVER SHEET

SCALE
NO SCALE

BAR REPRESENTS
ONE AND ONE-HALF

DRAWN BY:	04/11/08
CHECKED BY:	04/11/08
RECOMMENDED BY:	
RYAN PEARSON	DATE
ACCEPTED BY:	
PETER J. JAUCH	DATE


CONTRACT NUMBER

DRAWING NUMBER G1
SHEET 1 OF 22

LOCATION MAP
NOT TO SCALE

CAUTION TO CONTRACTOR:

THE CONTRACTOR SHALL BE RESPONSIBLE TO INVESTIGATE AND VERIFY THE ACTUAL LOCATION AND DEPTH OF ALL EXISTING UNDERGROUND FACILITIES AT LEAST 48 HOURS IN ADVANCE OF THE PERFORMANCE OF ANY WORK.

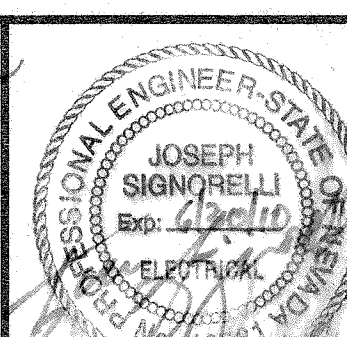

Avoid overhead power line contact. It's costly.

Call
before you
OVERHEAD
1-702-227-2921

RESPONSIBLE FOR DRAWINGS G1-G5, SV1, C1, C2, CD1, CD2 7	
H#36700	CLV DW

RESPONSIBLE FOR
DRAWINGS E1-E3,
ED1, ED2, i1, iD1, iD

1258/4