


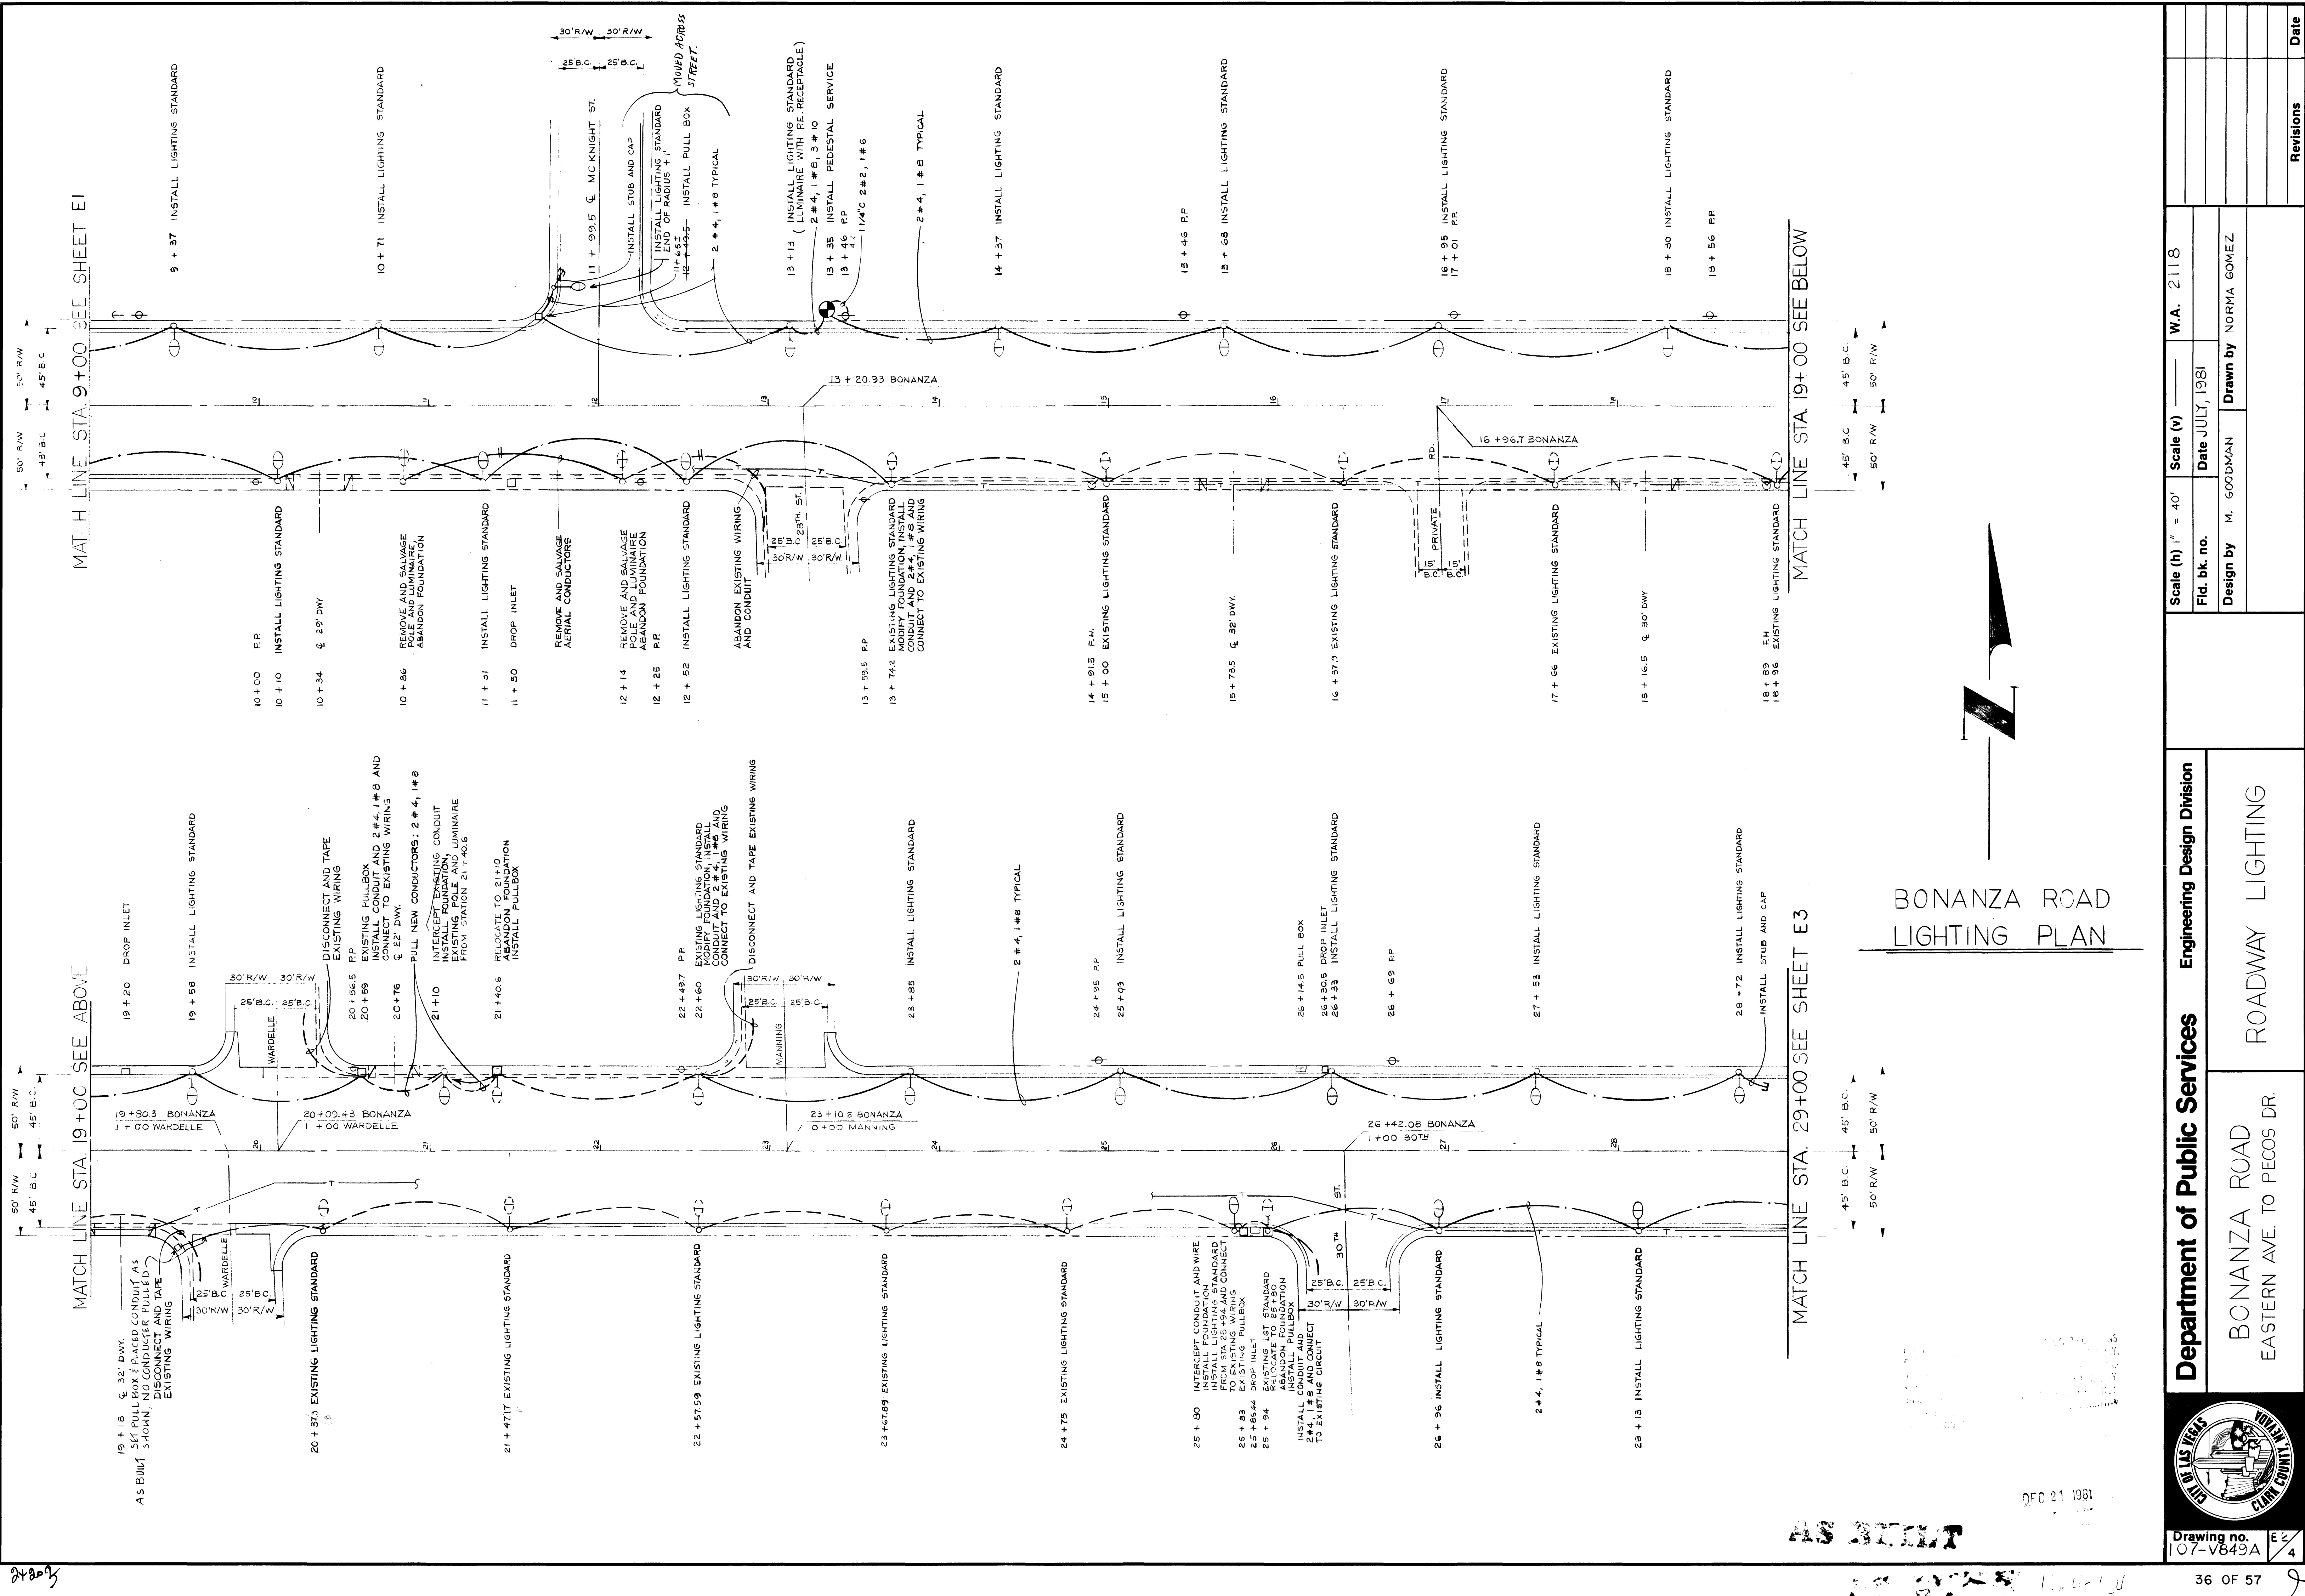

BONANZA ROAD
LIGHTING PLAN

 Drawing no. 107-V849A	Department of Public Services		Engineering Design Division		Scale (h) 1" = 40'		Scale (v) _____		W.A. 2118				
	BONANZA ROAD EASTERN AVE. TO PECOS DR.		ROADWAY LIGHTING		Fid. bk. no.		Date JULY, 1981		Drawn by NORMA GOMEZ				
					Design by M. GOODMAN								
										Revisions		Date	

36 OF 57

8

Drawing no. 107-V849A E2/4