



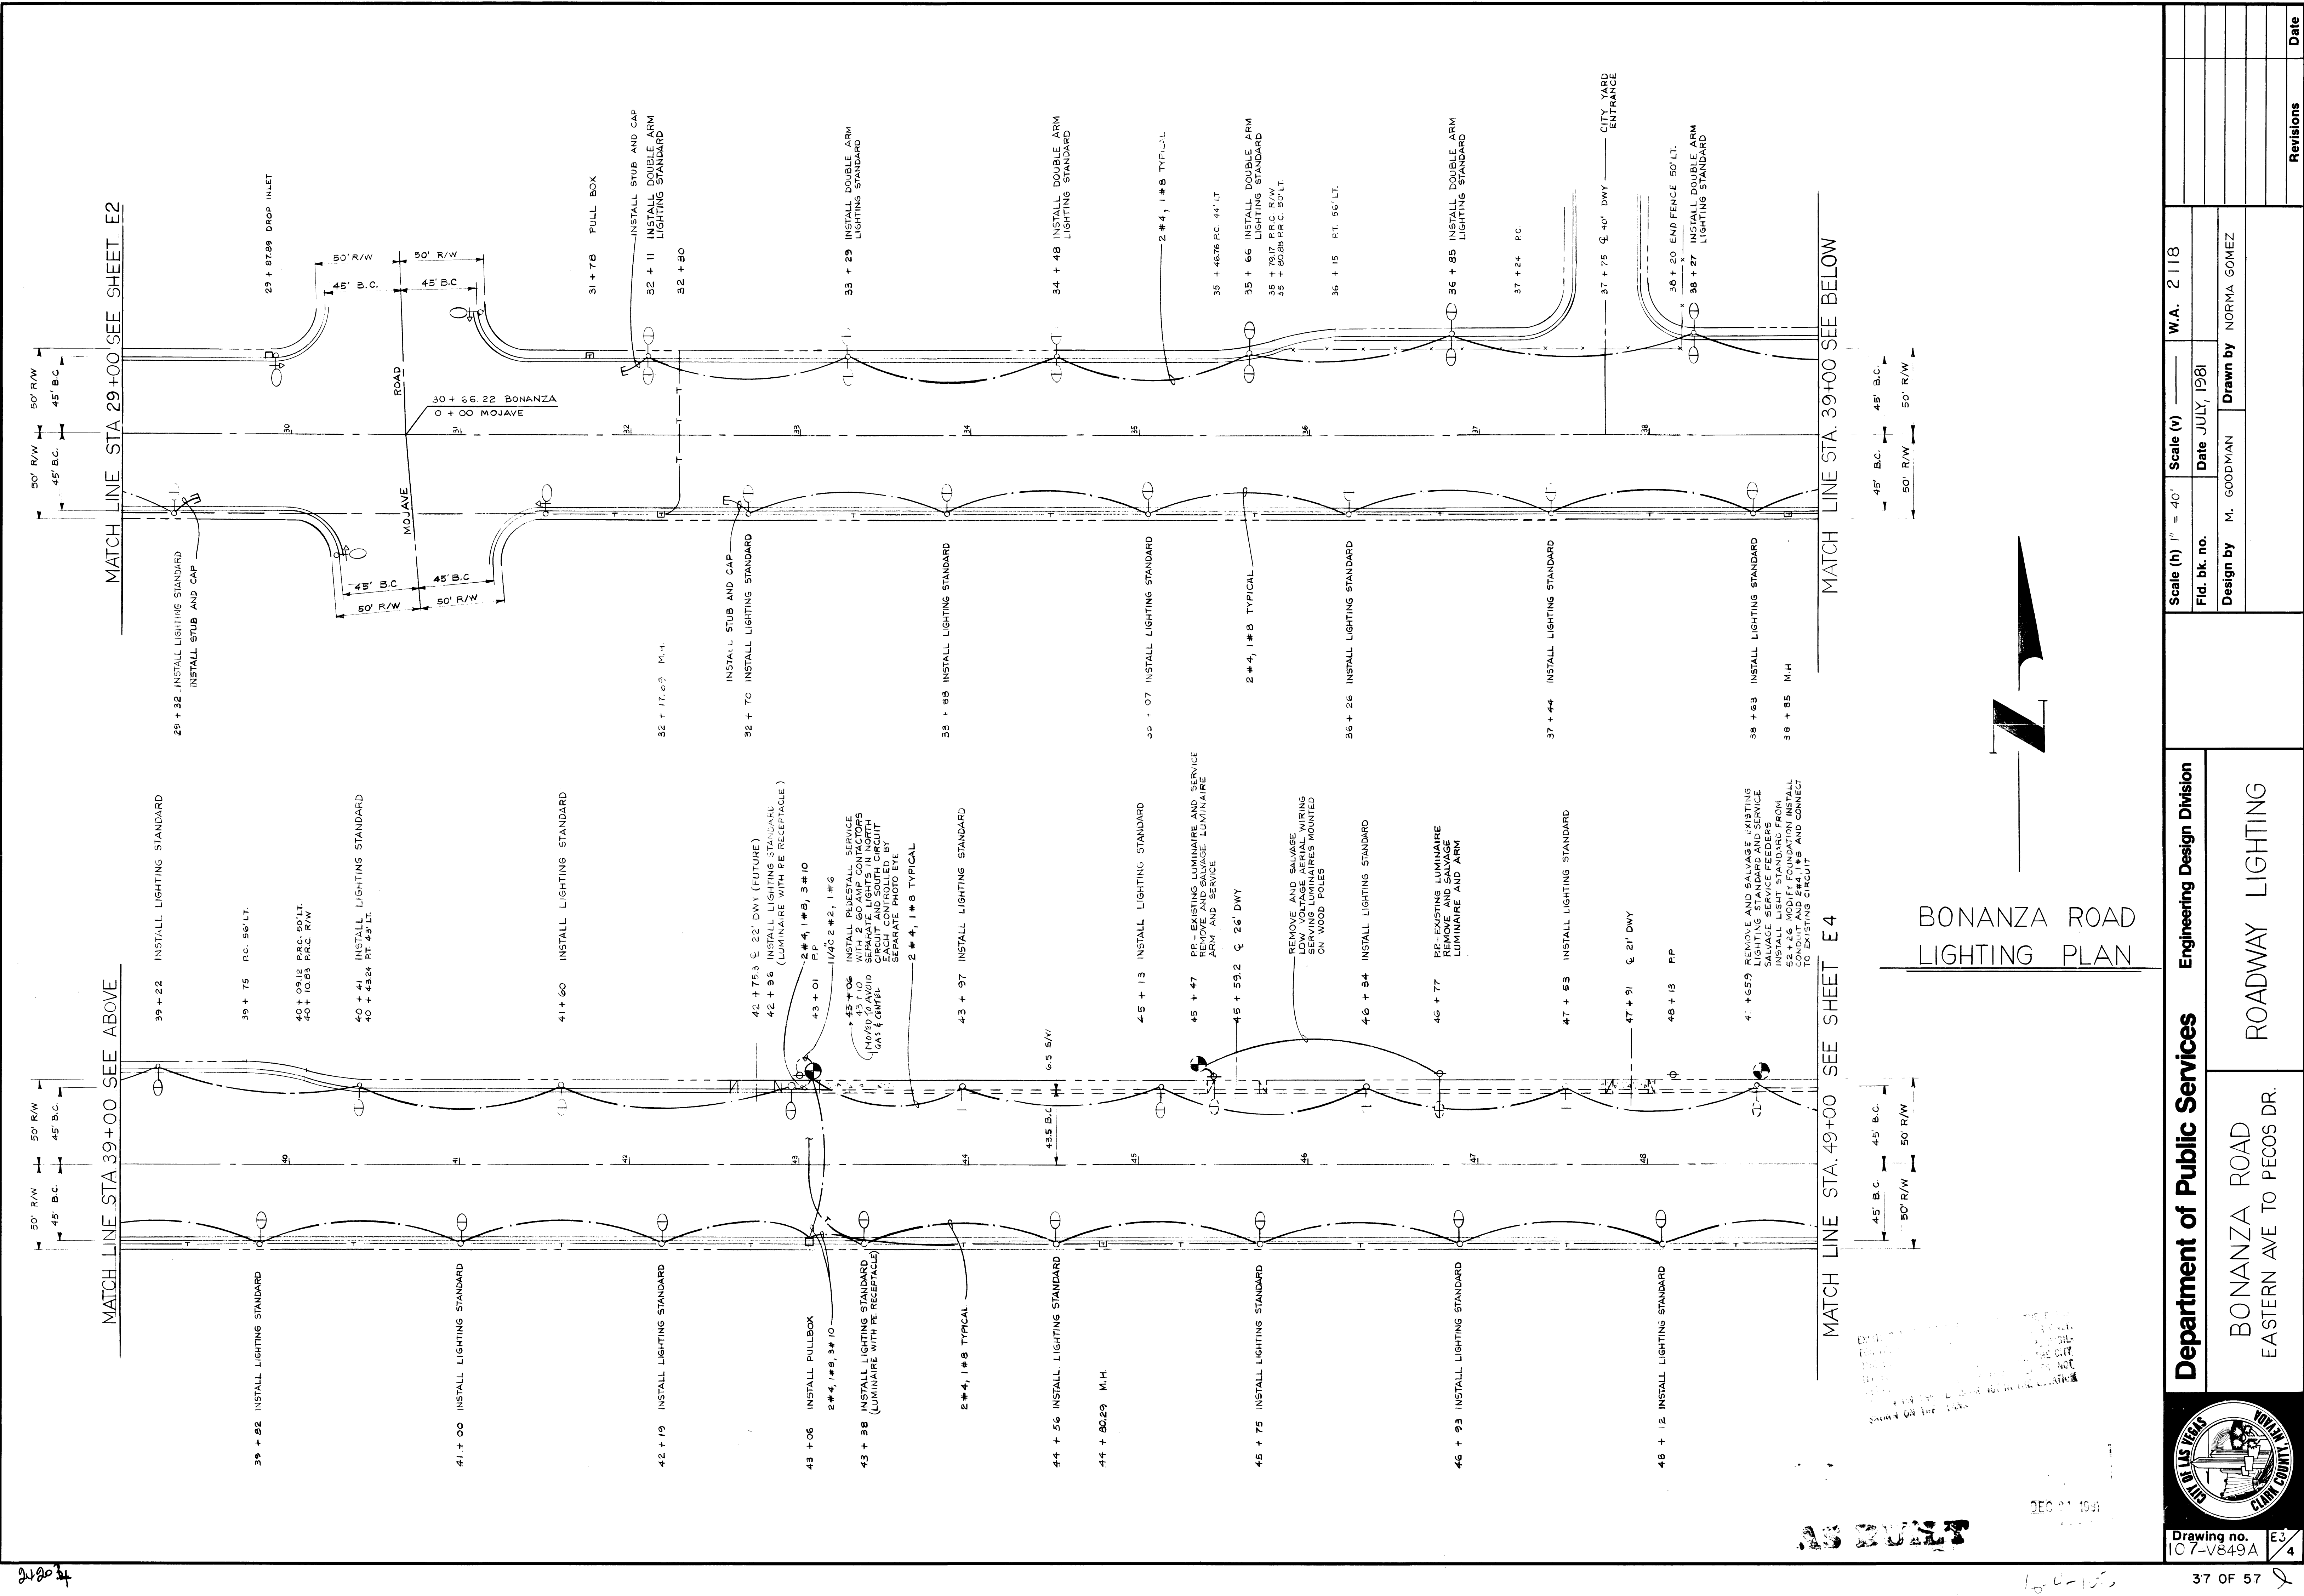

BONANZA ROAD
LIGHTING PLAN

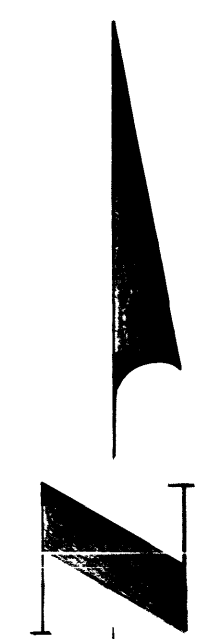



Drawing no.
107-V849A

Department of Public Services

Engineering Design Division

BONANZA ROAD
EASTERN AVE TO PECOS DR.

ROADWAY LIGHTING

Scale (h) 1" = 40'

Scale (v) —

W.A. 2118

Fld. bk. no.

Date JULY, 1981

Design by M. GOODMAN

Drawn by NORMA GOMEZ

Revisions

Date

107-V849A

DEC 21 1981

37 OF 57