



**FLOOR PLAN**

SCALE: 1/8" = 1'-0"

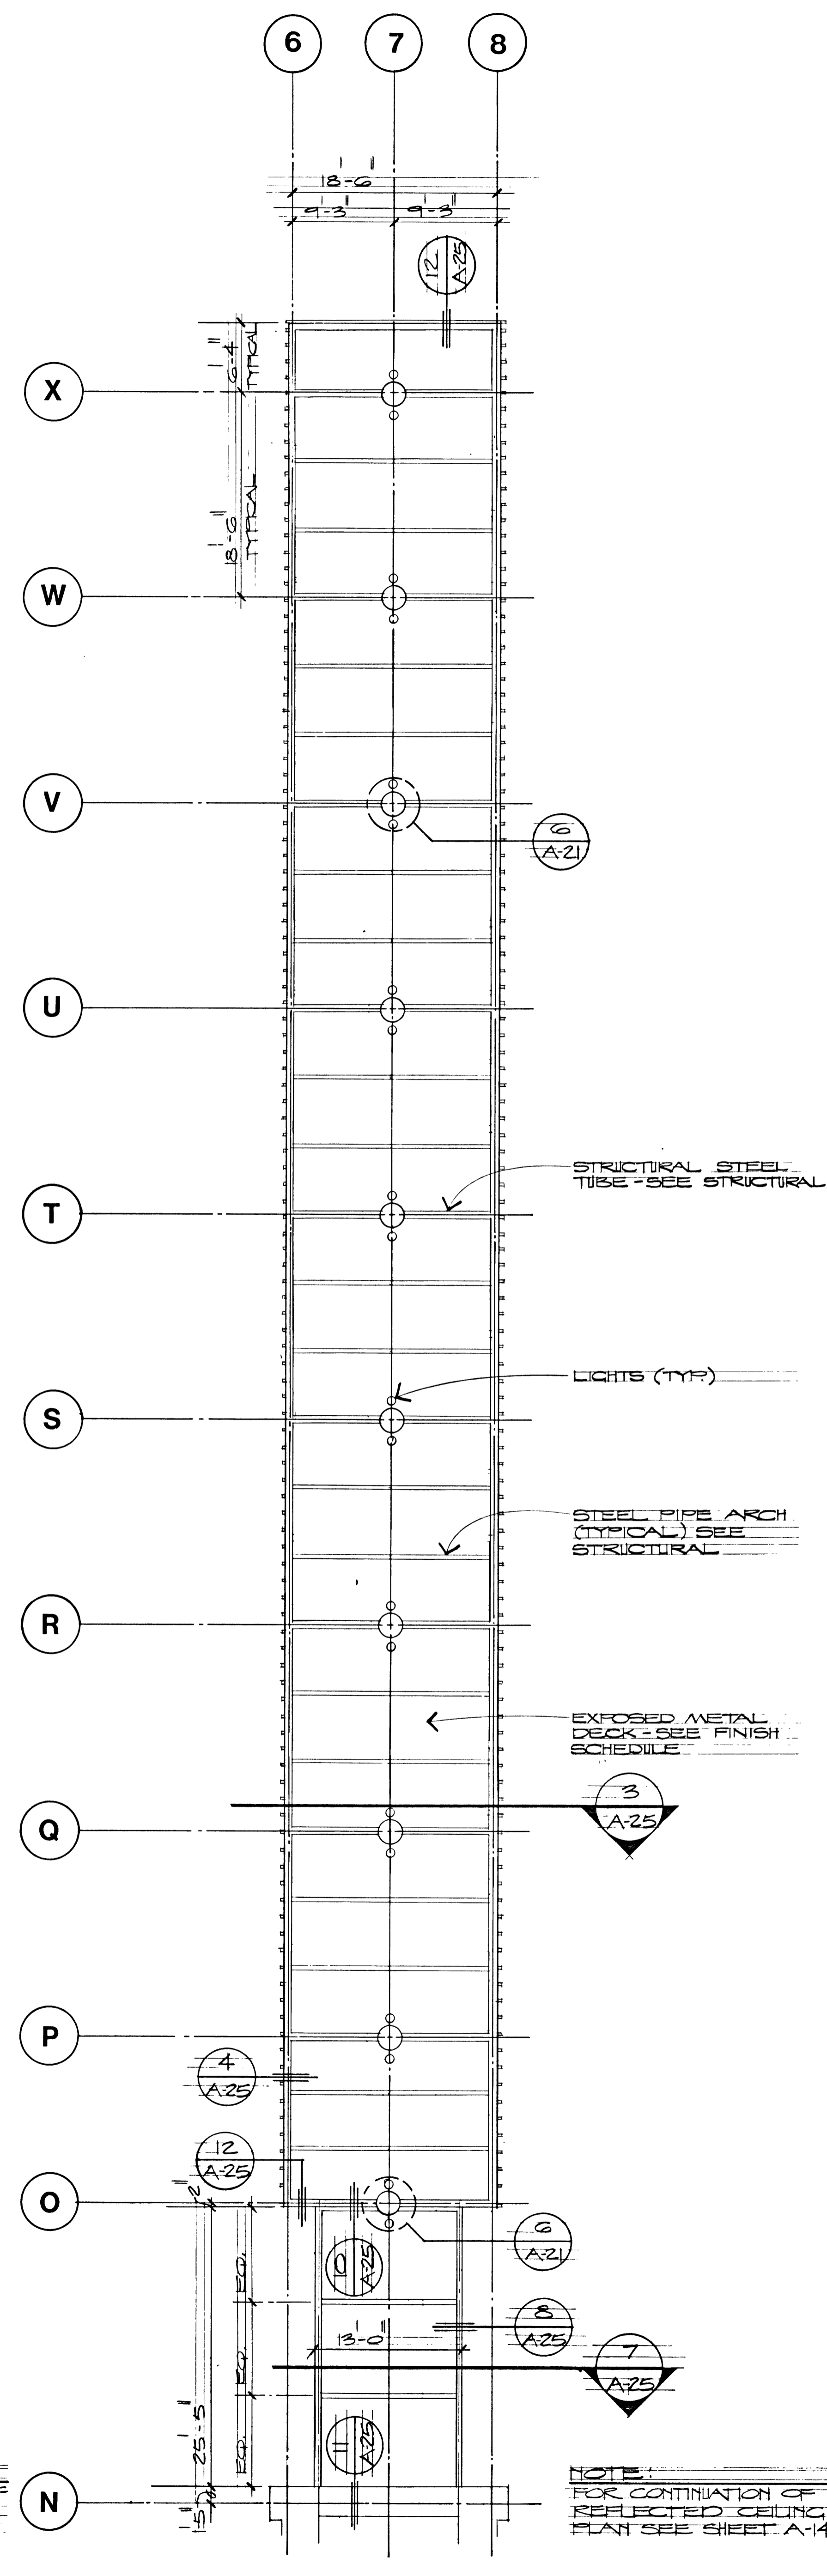

**REFLECTED CEILING PLAN**


SCALE: 1/8" = 1'-0"

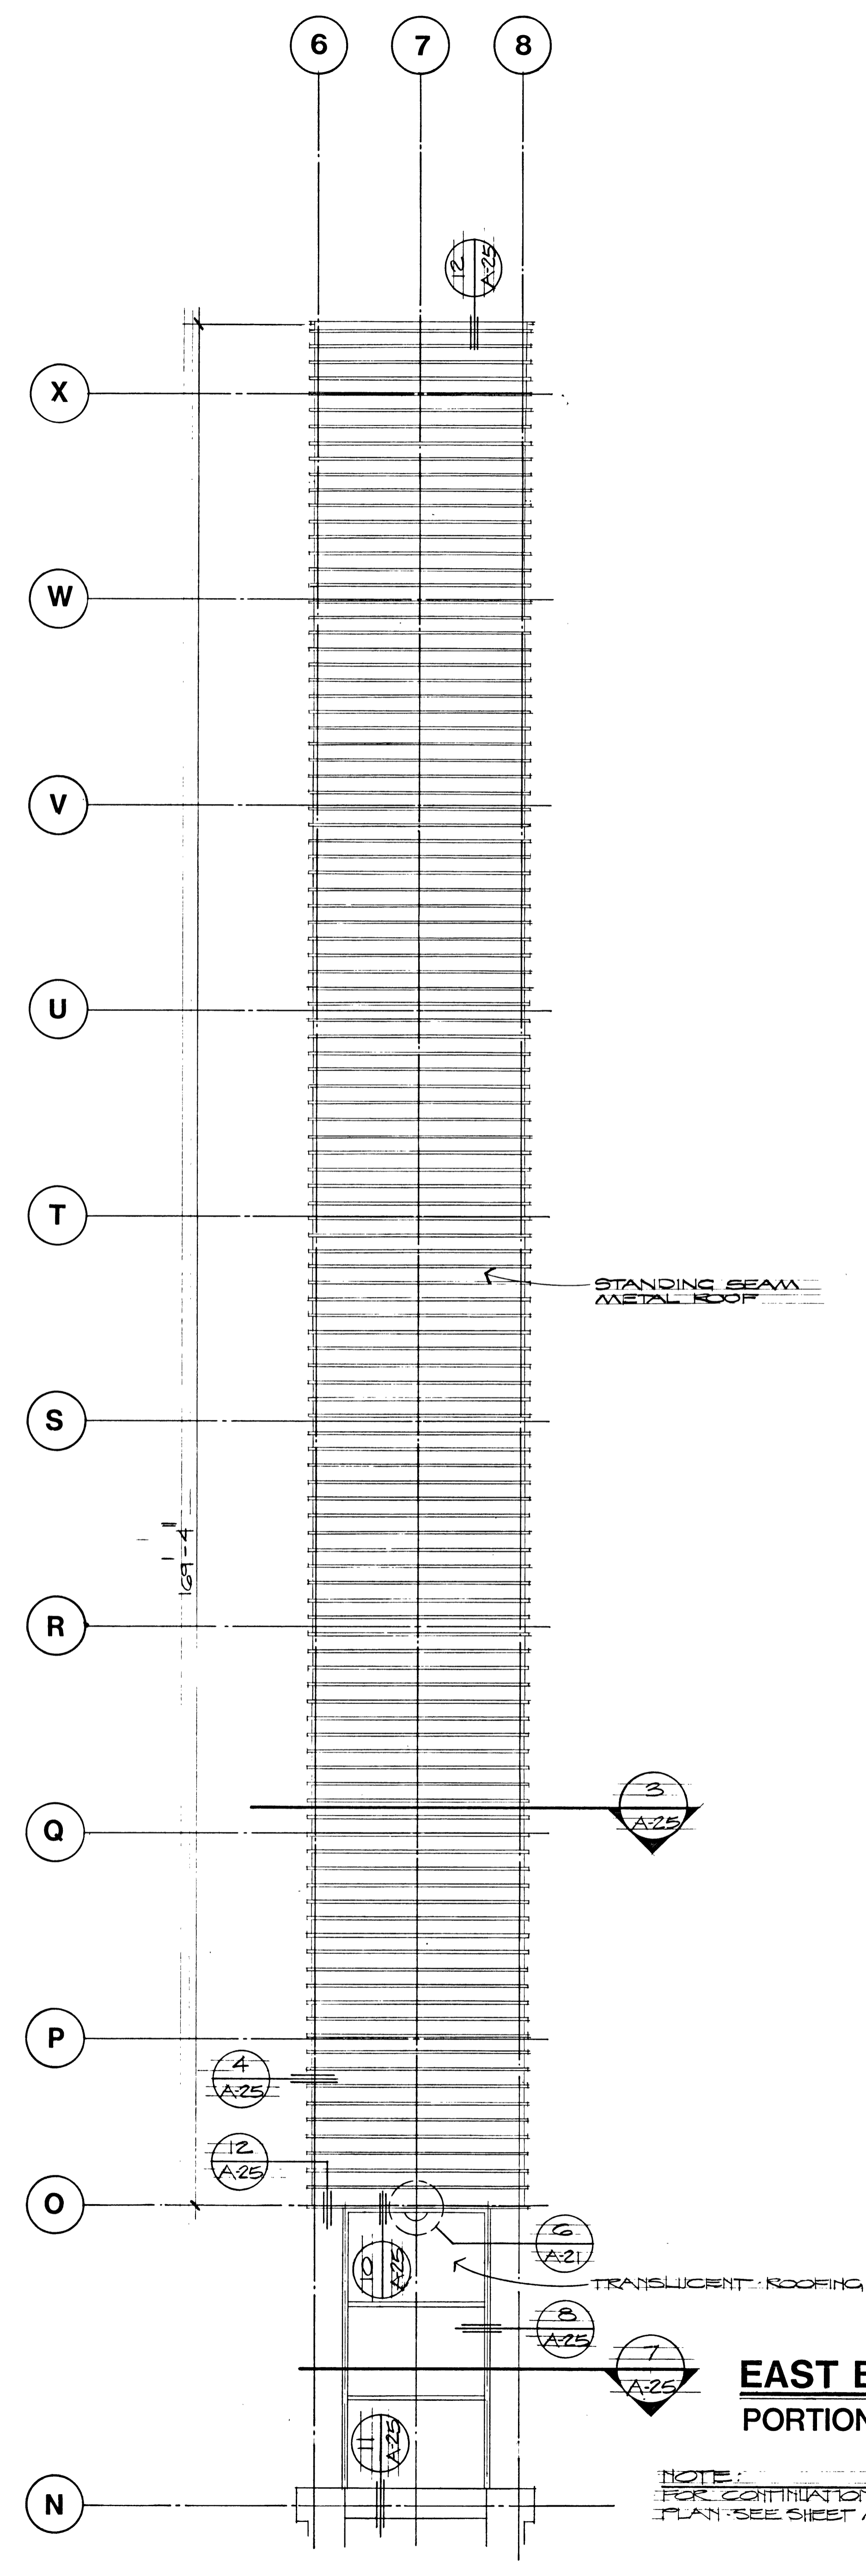

**ROOF PLAN**

SCALE: 1/8" = 1'-0"

**EAST BOARDING PLATFORM  
PORTION OF ALTERNATE "C"**

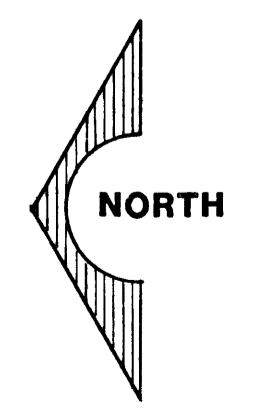

**1 DEDUCTIVE BID ITEM #1 (II)**  
 - SEE CML DRAWINGS  
 FOR DETAILED DESCRIPTION  
 SEE SPECIFICATIONS

DATE: 10-1-2015	DRAWN: AL LJA	CHECKED: BEK	JOB NO.: 1502-151
<b>DOBUSKY KITTRELL GARLOCK</b> Architects aia			
1502-151 City of Las Vegas Transportation Downtown Las Vegas, Nevada			
Center Las Vegas, Nevada			
SHEET <b>A-15</b> OF 24 OF 65			
FILE NUMBER: 1590-21			
Toll-free Post - 1-800 TELETYPE DRAFTING FLAK			