


LEGEND

	RECESSED FLUORESCENT FIXTURE
	LINEAR FLUORESCENT FIXTURE
	RECESSED INCANDESCENT FIXTURE
	SUPPLY AIR DIFFUSER
	RETURN AIR GRILLE
	24' x 24' SECTIONAL RETURN AIR GRILLE
	LINEAR AIR DIFFUSER
	SIDE OR OVERHEAD COOLING GRILLE AS NOTED PER FLOOR PLANS
	METAL LINEAR FAN CEILING
	CEILING FAN

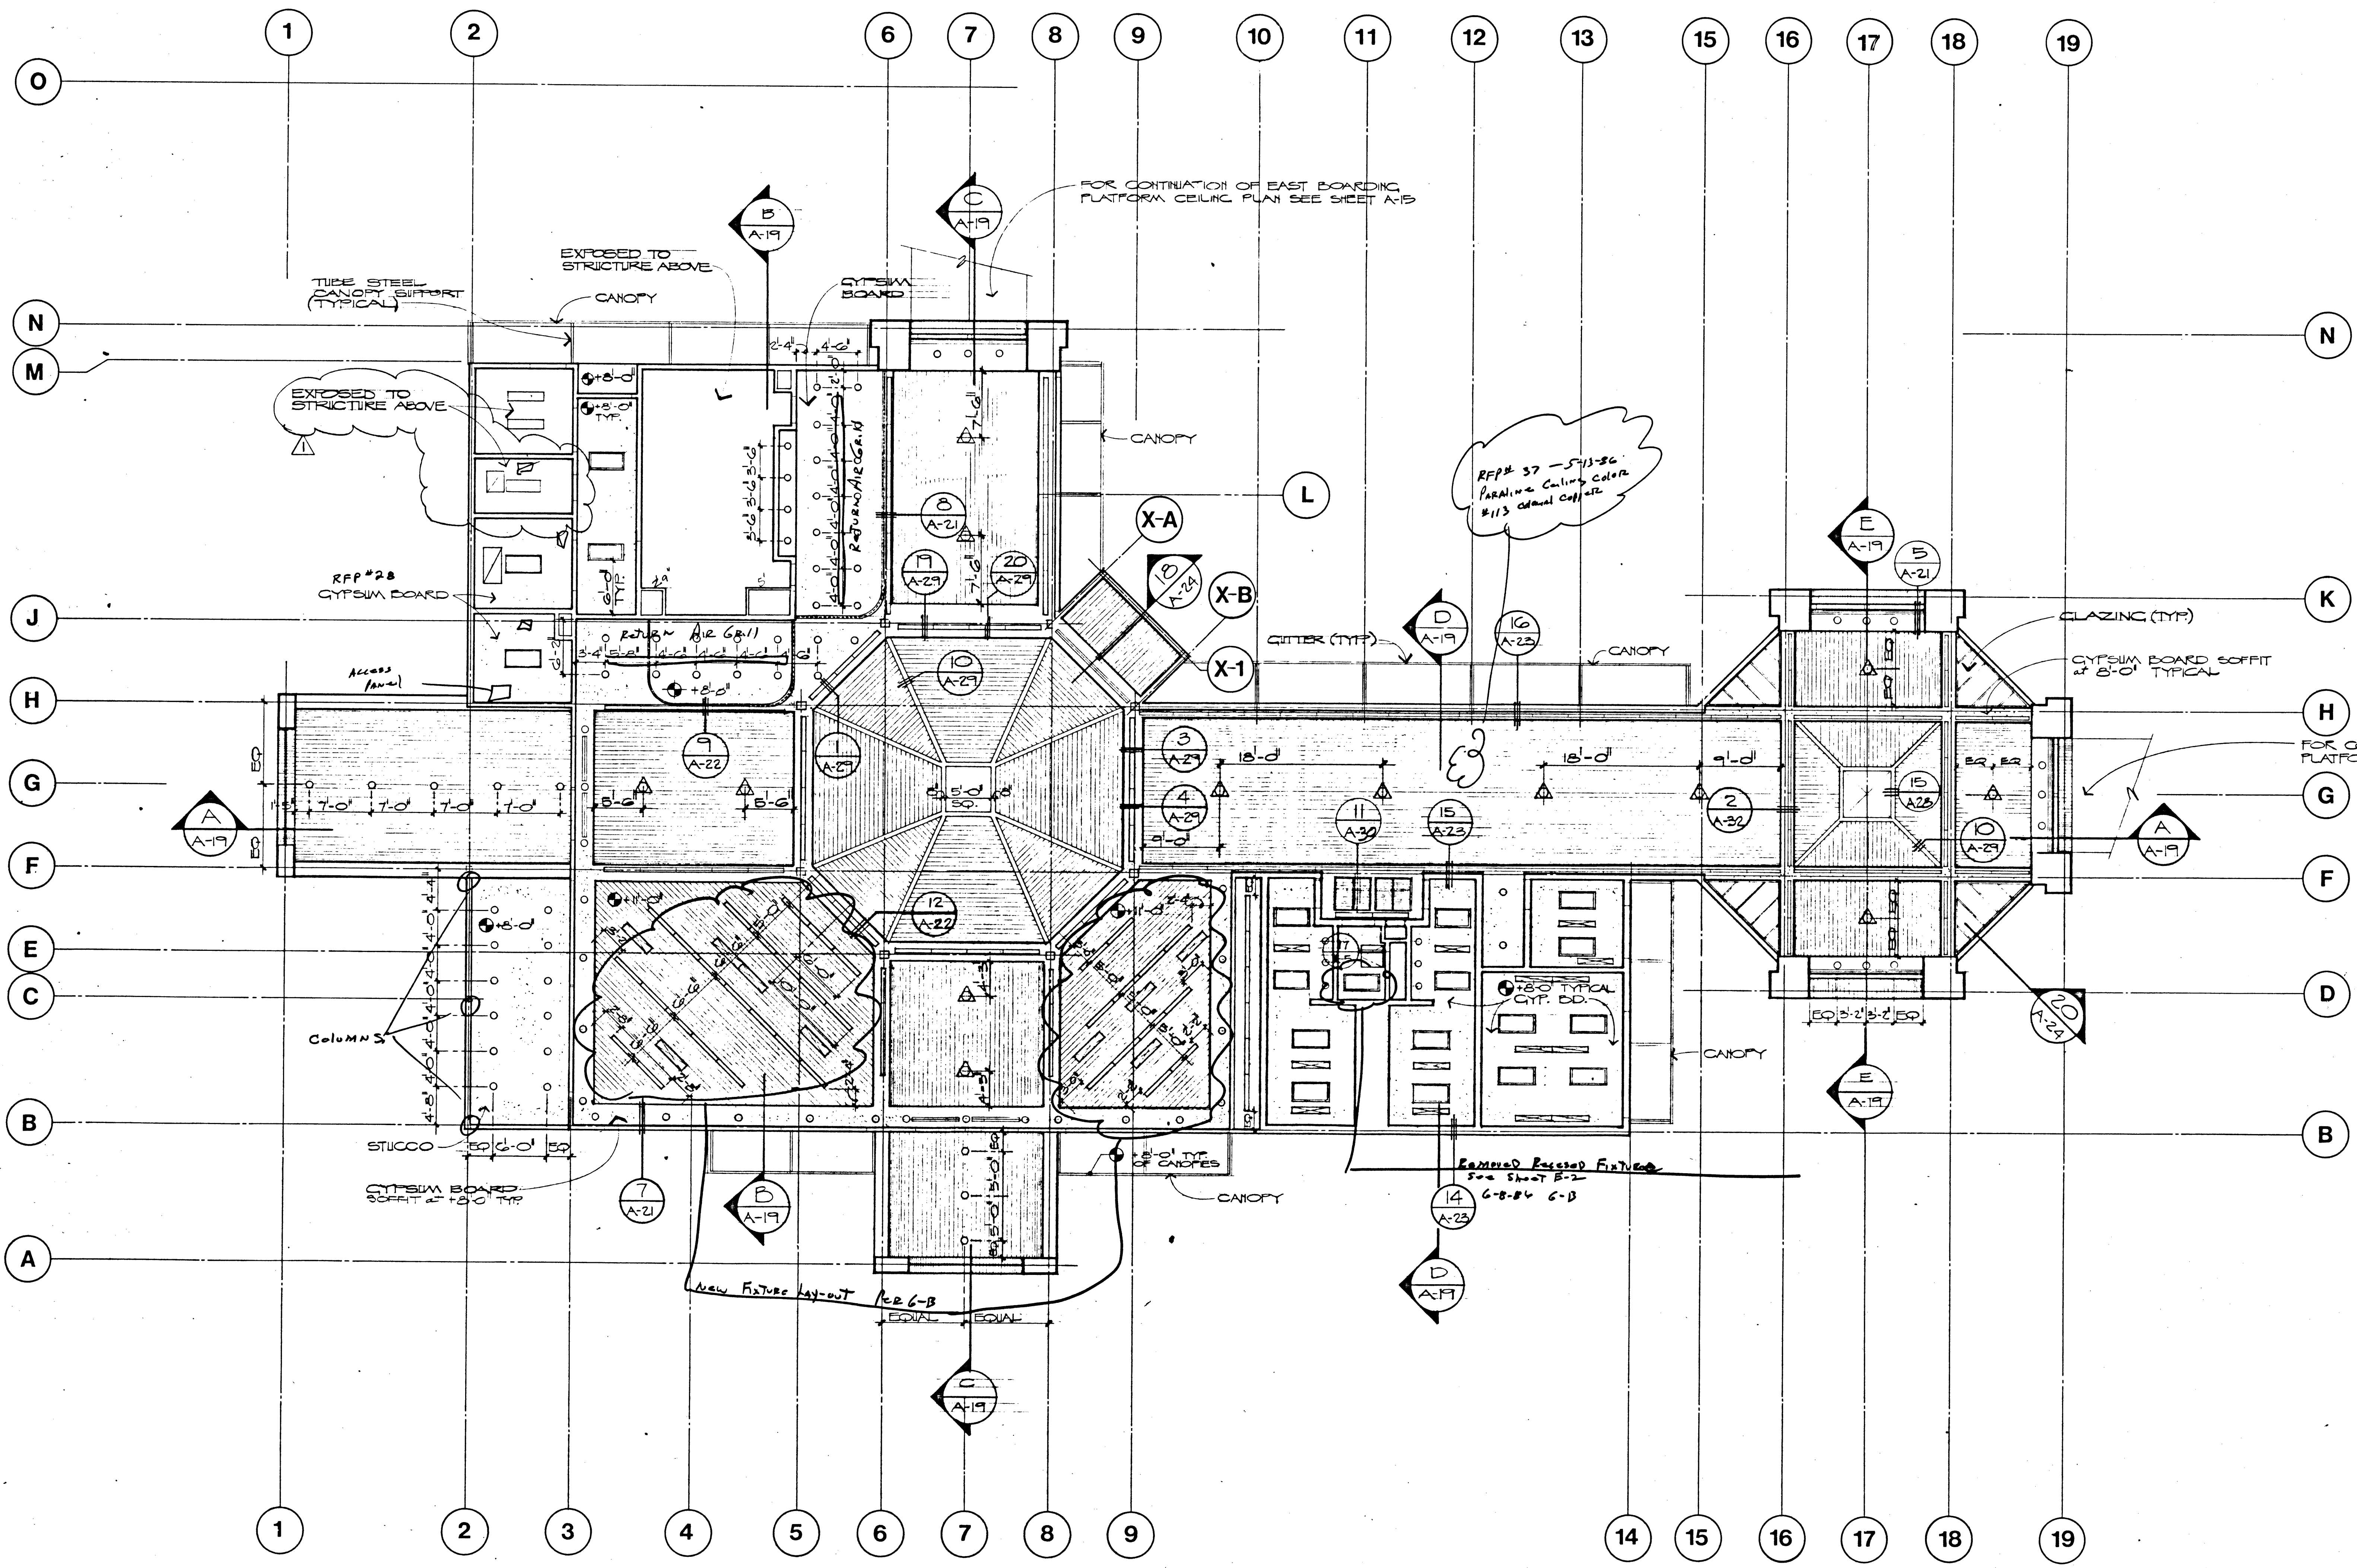

- GENERAL NOTES**
1. IT IS THE INTENT OF THE CEILING PLAN TO ALIGN ITEMS WITHIN THE CEILING SYSTEM AS SHOWN OR DIMENSIONED. CONTRACTOR SHALL COORDINATE LOCATION PER THIS PLAN.
 2. ITEMS NOT SHOWN SHALL BE ALIGNED WITHIN THE CEILING SYSTEMS RELATIVE TO EACH MATERIAL; i.e., SPRINKLER HEADS SHALL BE CENTERED WITHIN A LINEAR CEILING PAN OR CENTERED WITHIN TWO CEILING PANS. HVAC DIFFUSERS SHALL BE PLACED AND ALIGNED WITHIN THE MODULE OF THE CEILING SYSTEM. SEE SHEET A-21 FOR TYPICAL CEILING DETAILS.
 3. SEE SHEET A-32 FOR UPPER SOFFIT AND HIGH SOFFIT PLANS.

REFLECTED CEILING PLAN
SCALE: 1/8" = 1'-0"

A-15-25 ISSUED FOR ADDENDUM #1

DATE	12-15-25
DRAWN	...
CHECKED	...
JOB NO.	...

DOBUSKY KITTLELL GARLOCK
Architects
388 CAMBRIDGE ST. LAS VEGAS, NEVADA 89108 (702) 953-0443

City of Las Vegas
Downtown Transportation Center
Las Vegas, Nevada

SHEET	A-14
OF	23 OF 65
FILE NUMBER	550-21