



ROOF PLAN

SCALE: 1/8" = 1'-0"

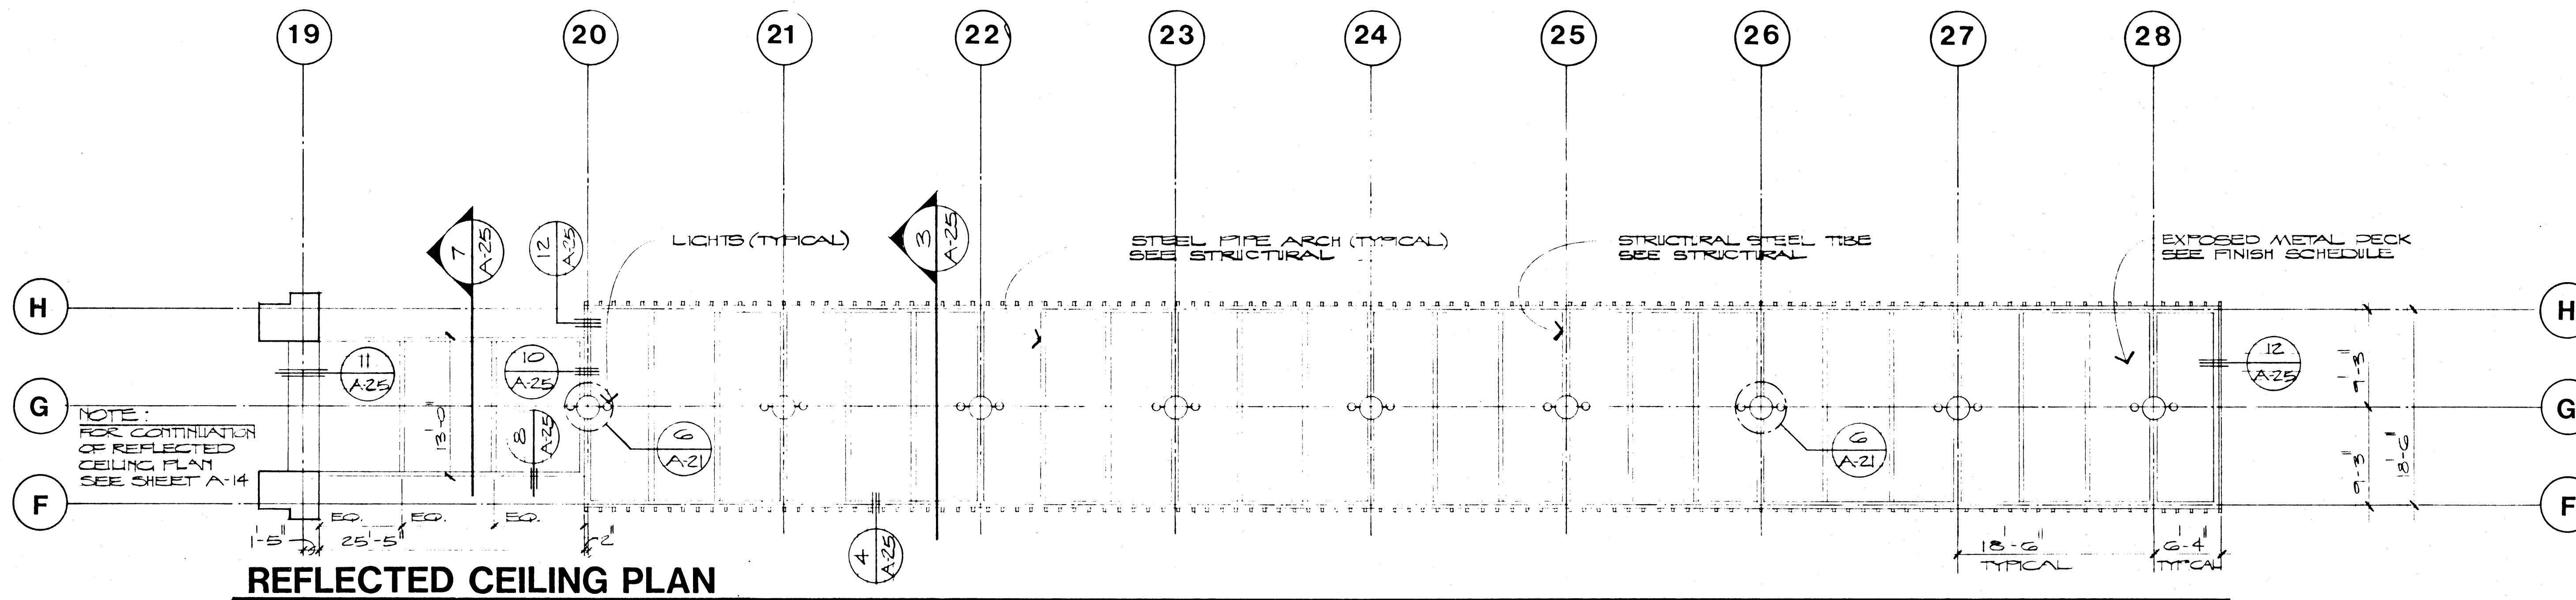

REFLECTED CEILING PLAN


SCALE: 1/8" = 1'-0"

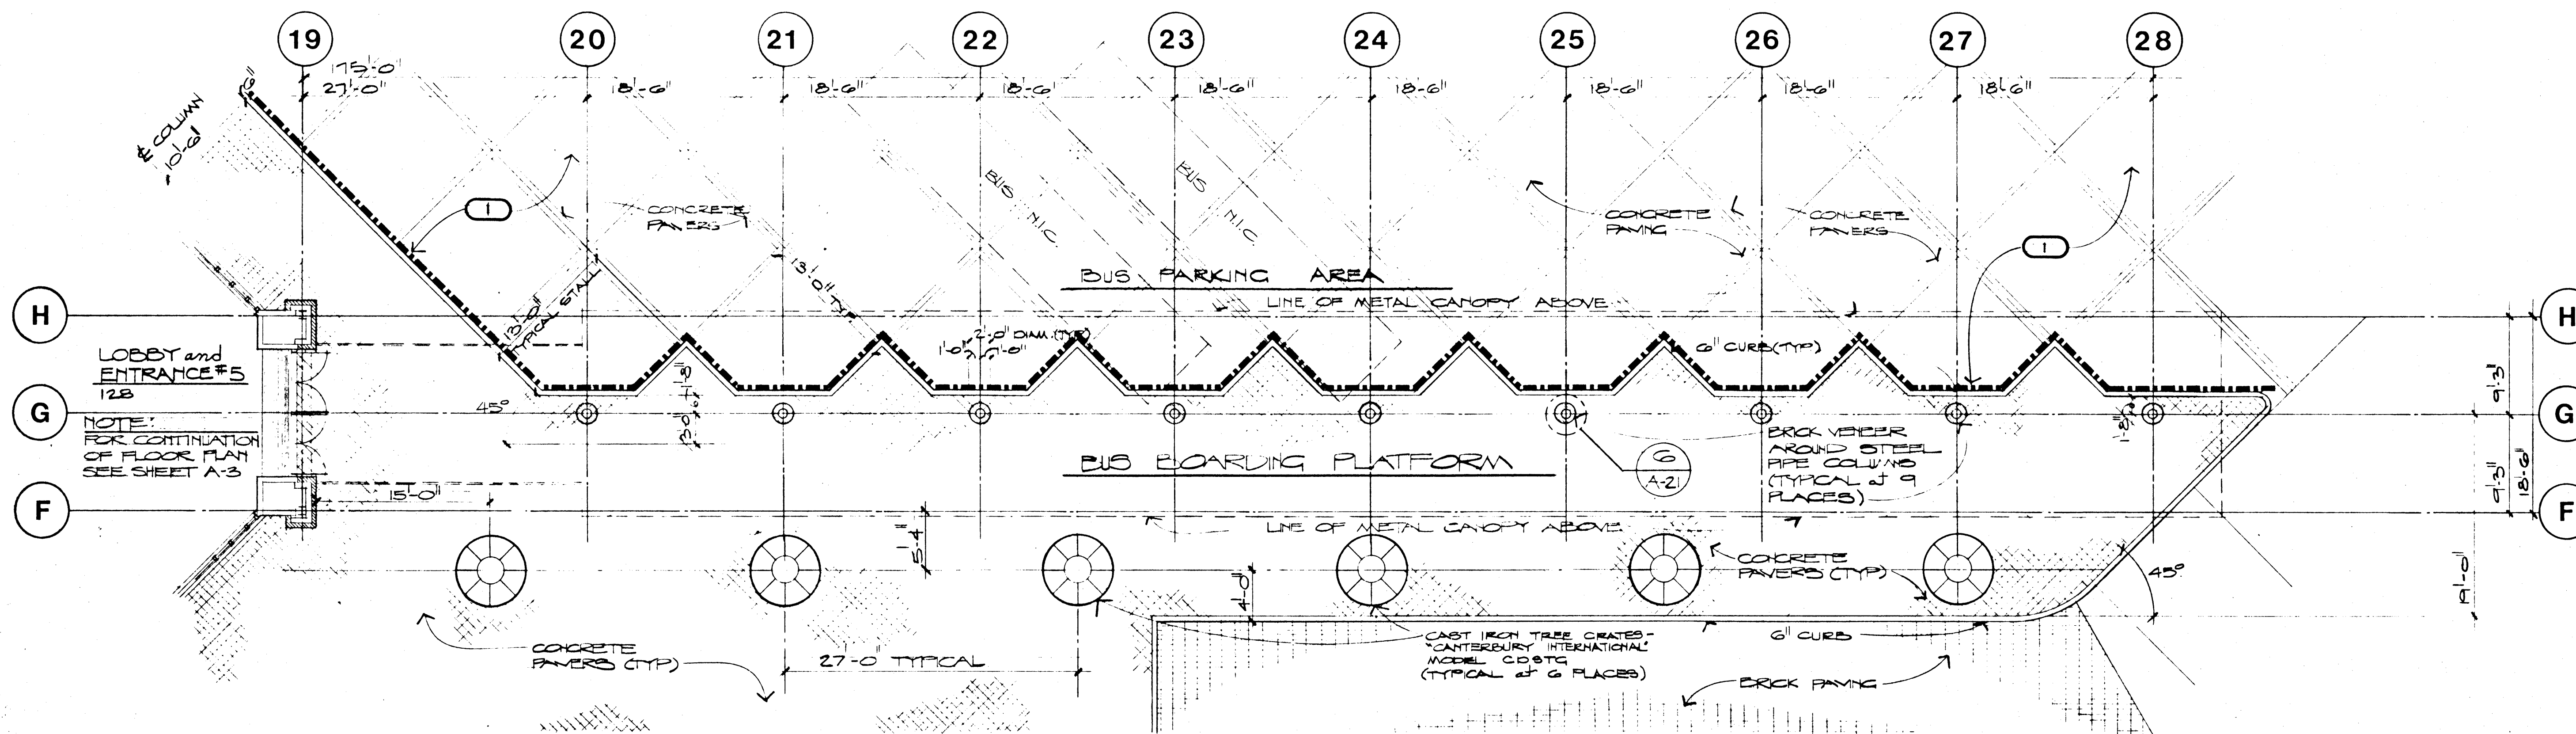

FLOOR PLAN

SCALE: 1/8" = 1'-0"

SOUTH BOARDING PLATFORM

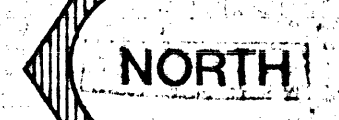

1 DEDUCTIVE BID ITEM # 1 (II)
 --- SEE CML DRAWINGS
 FOR DETAILED DESCRIPTION
 SEE SPECIFICATIONS.

DATE	10/20/05
DRAWN	JLS
CHECKED	JLS
JOB NO.	25000000

DOBUSKY KITTRELL GARLOCK aka
 Architects
 333 CLARIDGE ST. LAS VEGAS, NEVADA 89109 (702) 733-0428

City of Las Vegas
 Downtown Transportation Center
 Las Vegas, Nevada

SHEET
A-16
 25 OF 65

FILE NUMBER 590-21