




WALL SECTION
SCALE 3/4" : 1'-0"
17
A-24

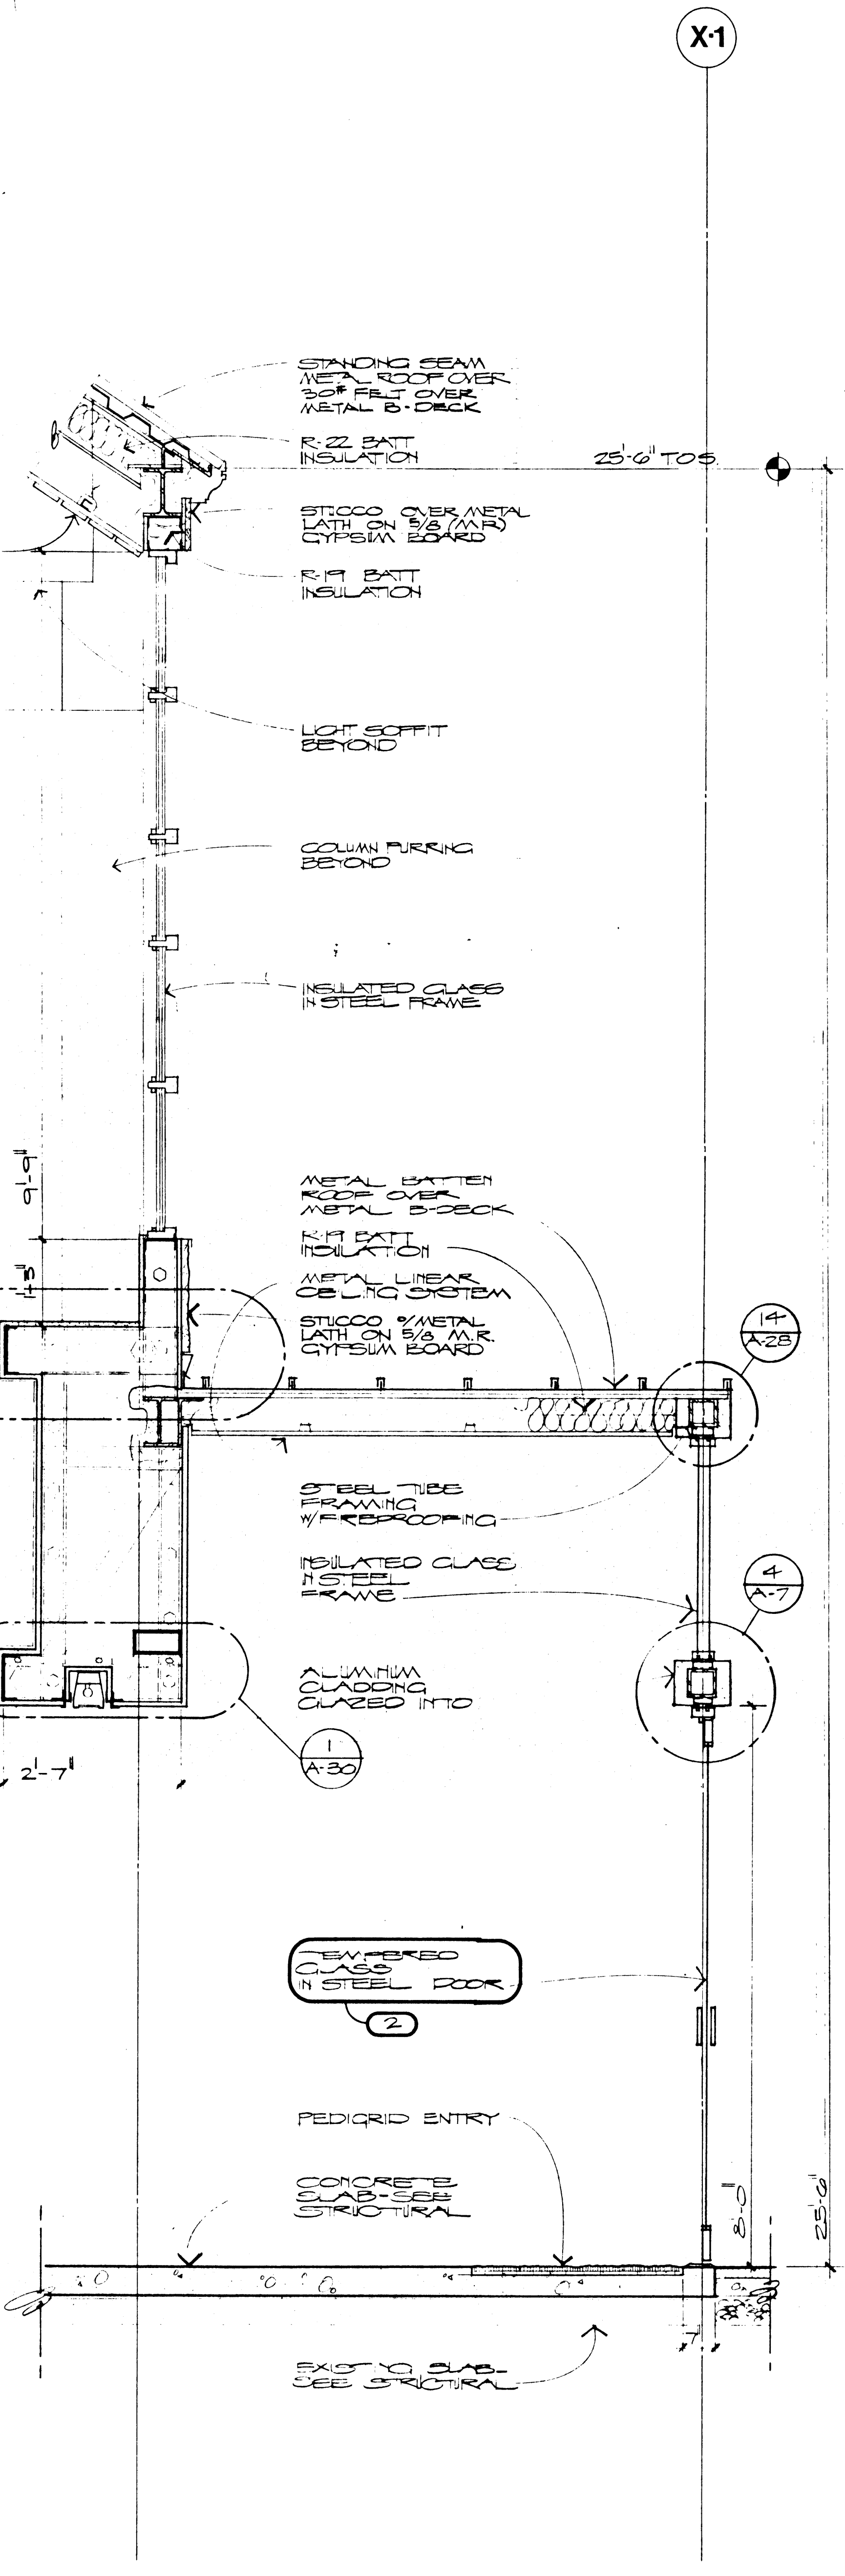

WALL SECTION
SCALE 3/4" : 1'-0"
18
A-24

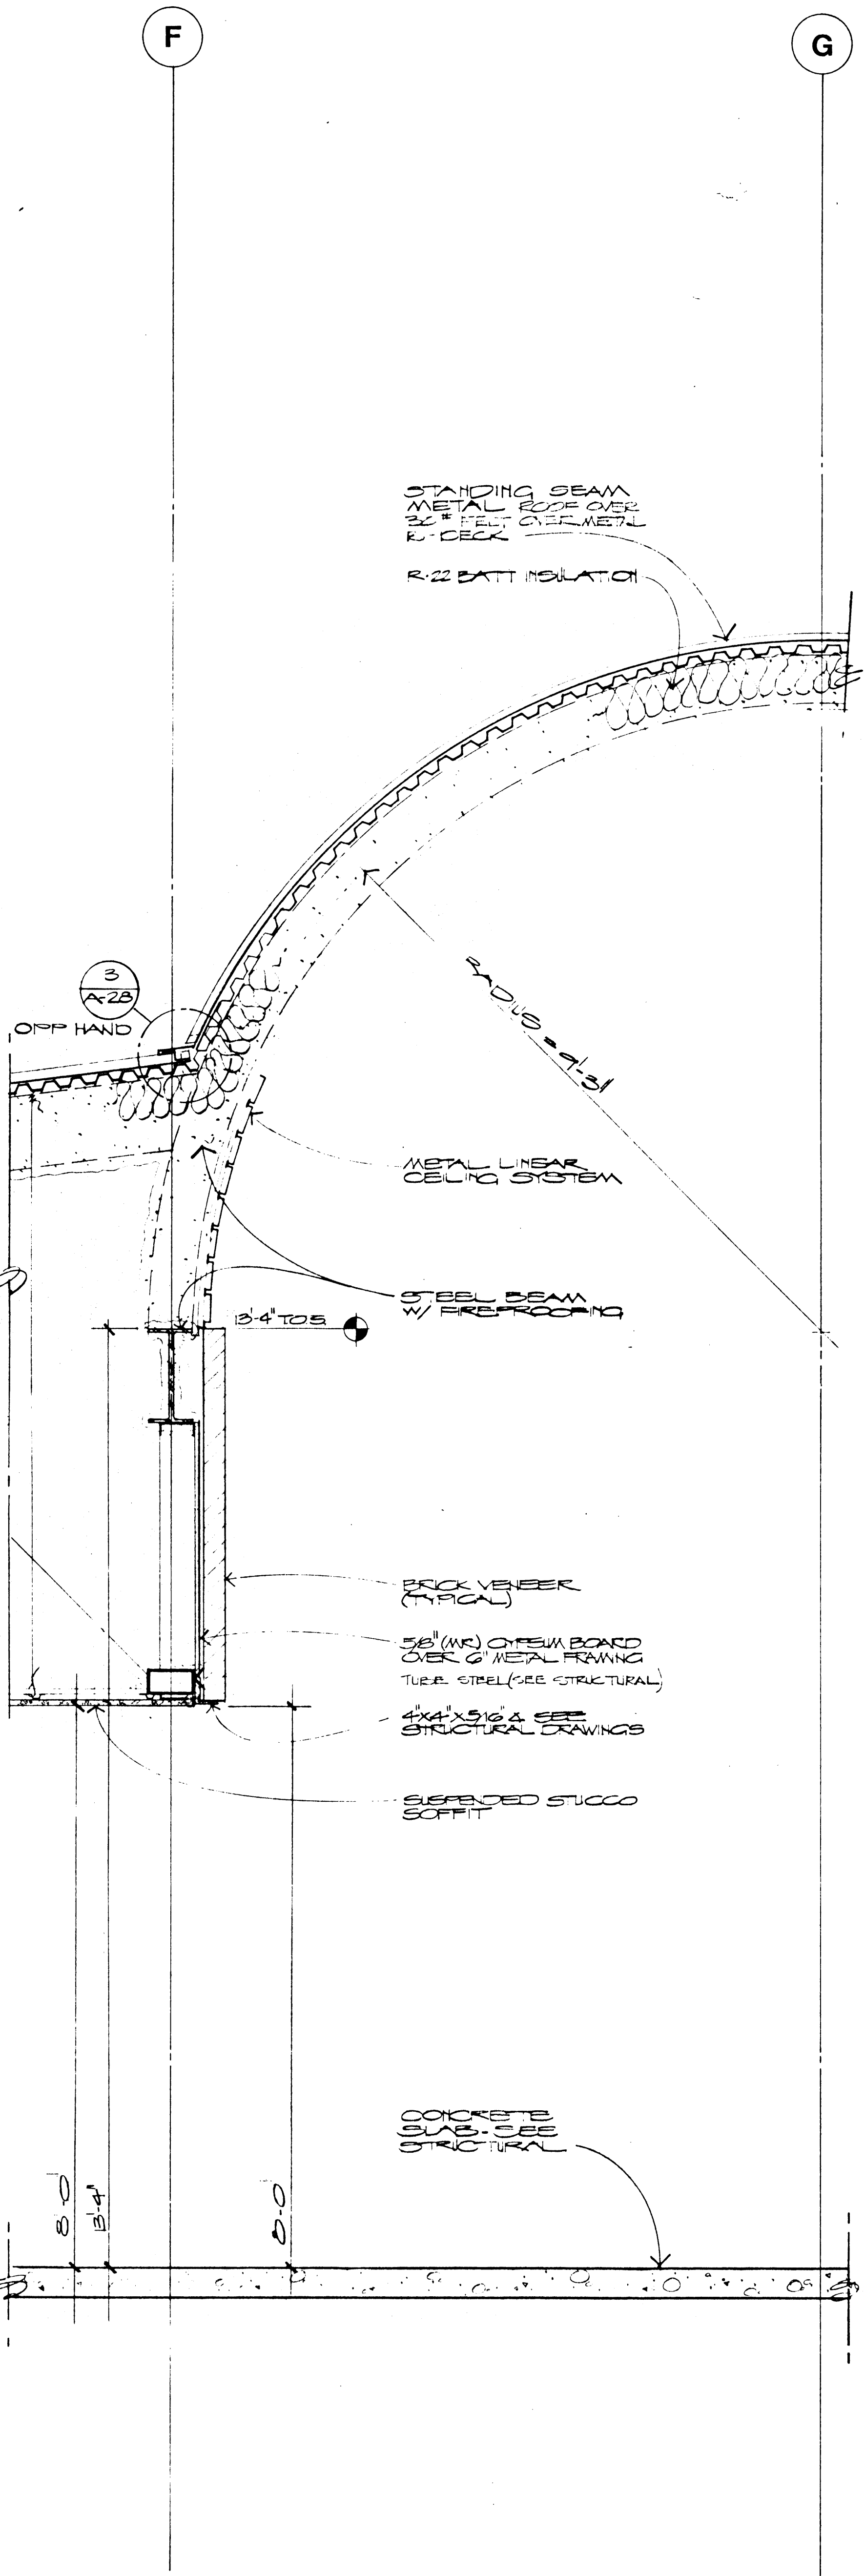

WALL SECTION
SCALE 3/4" : 1'-0"
19
A-24

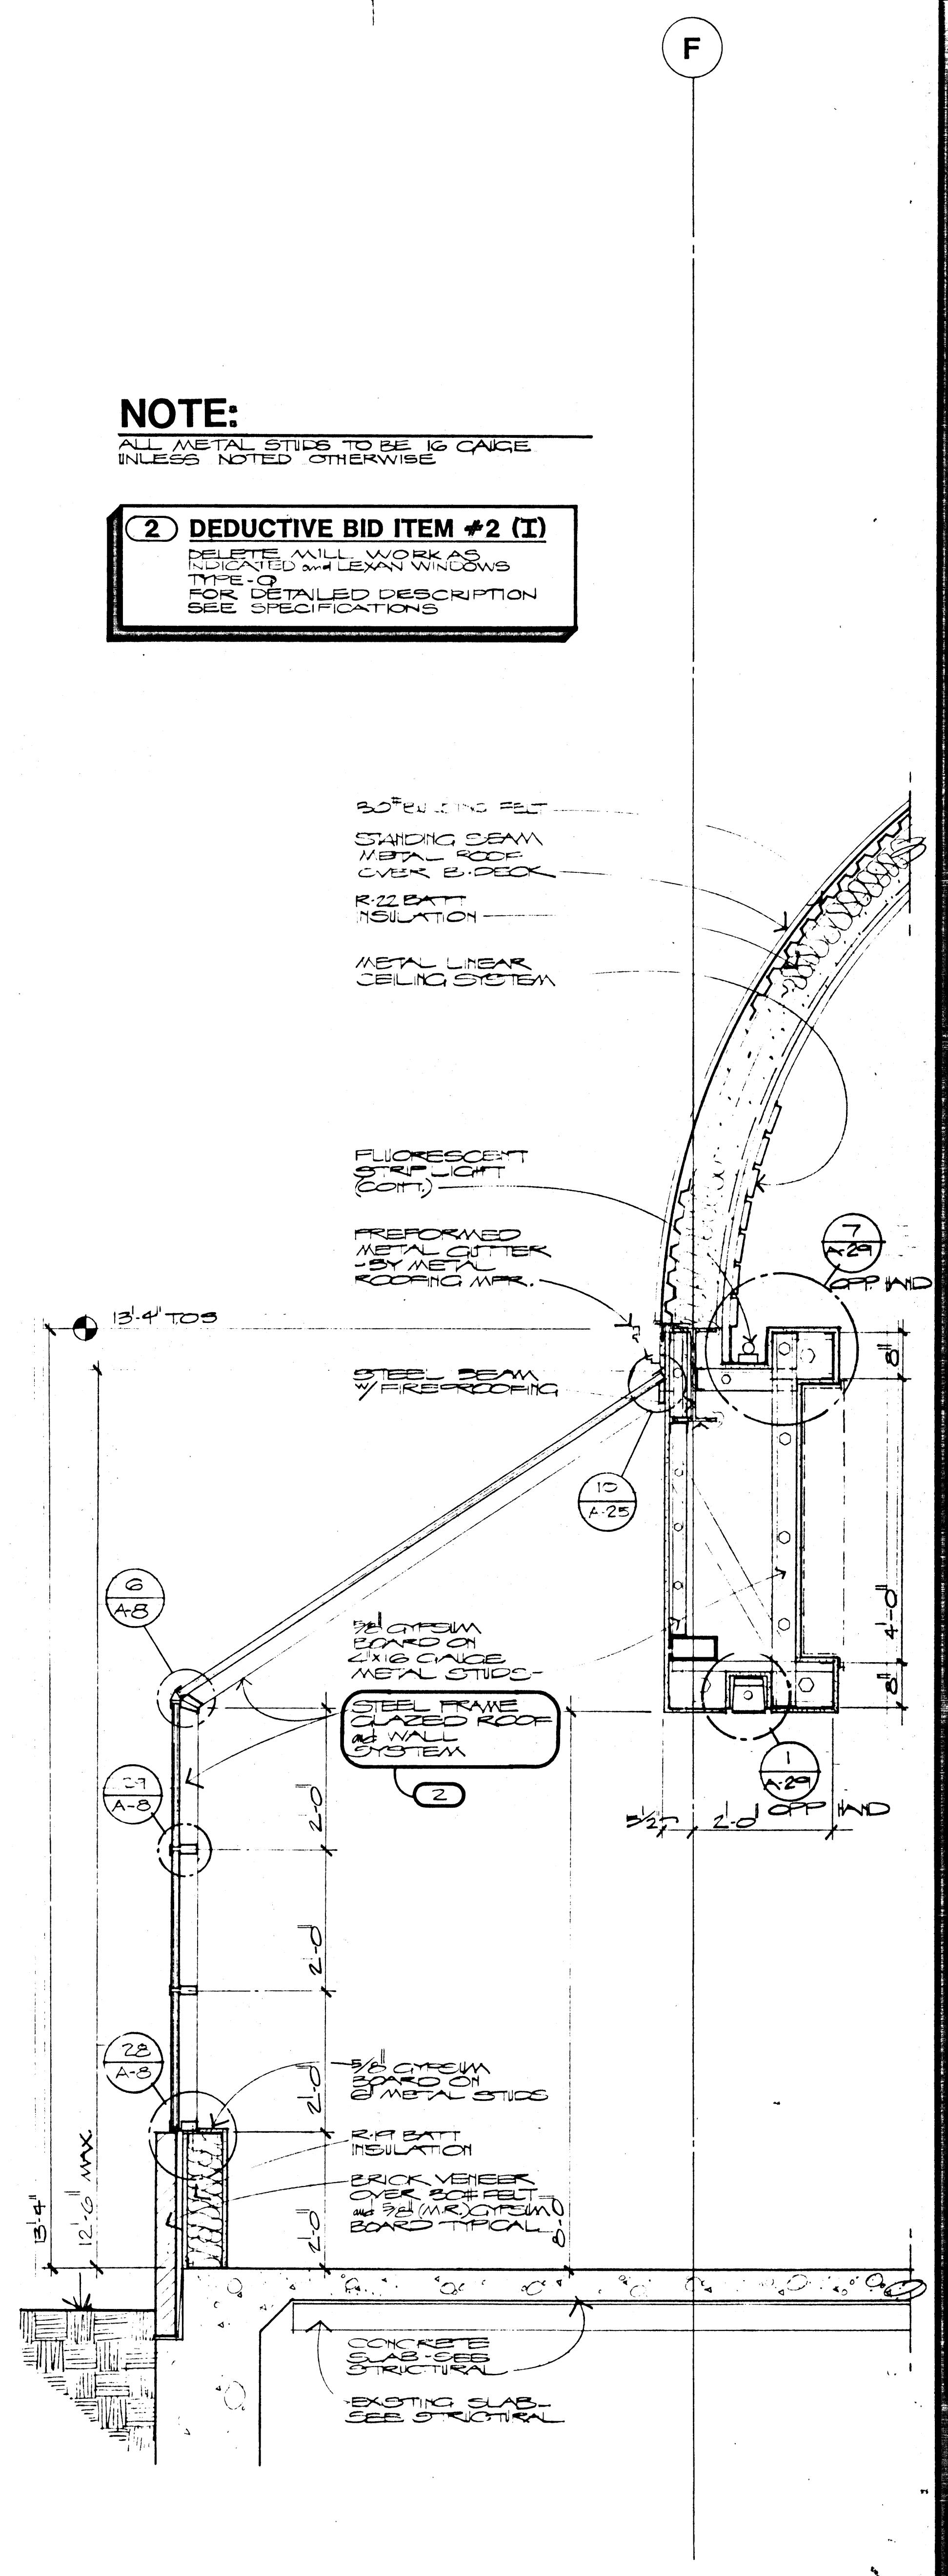

WALL SECTION
SCALE 3/4" : 1'-0"
20
A-24

NOTE:
ALL METAL STUDS TO BE 16 GAUGE UNLESS NOTED OTHERWISE

(2) DEDUCTIVE BID ITEM #2 (1)
DELETE MILL WORK AS INDICATED WITH LEAN WINDOWS TYPE-G FOR DETAILED DESCRIPTION SEE SPECIFICATIONS

DATE	REVISION
DESIGNED BY	CHECKED BY
DRAWN BY	DATE
PROJECT NO.	SCALE
DATE	BY

DOBUSKY KITRELL GARLOCK Architects

City of Las Vegas Transportation Center
Las Vegas, Nevada

A-24
33 OF 65
FILE NUMBER 590-23