
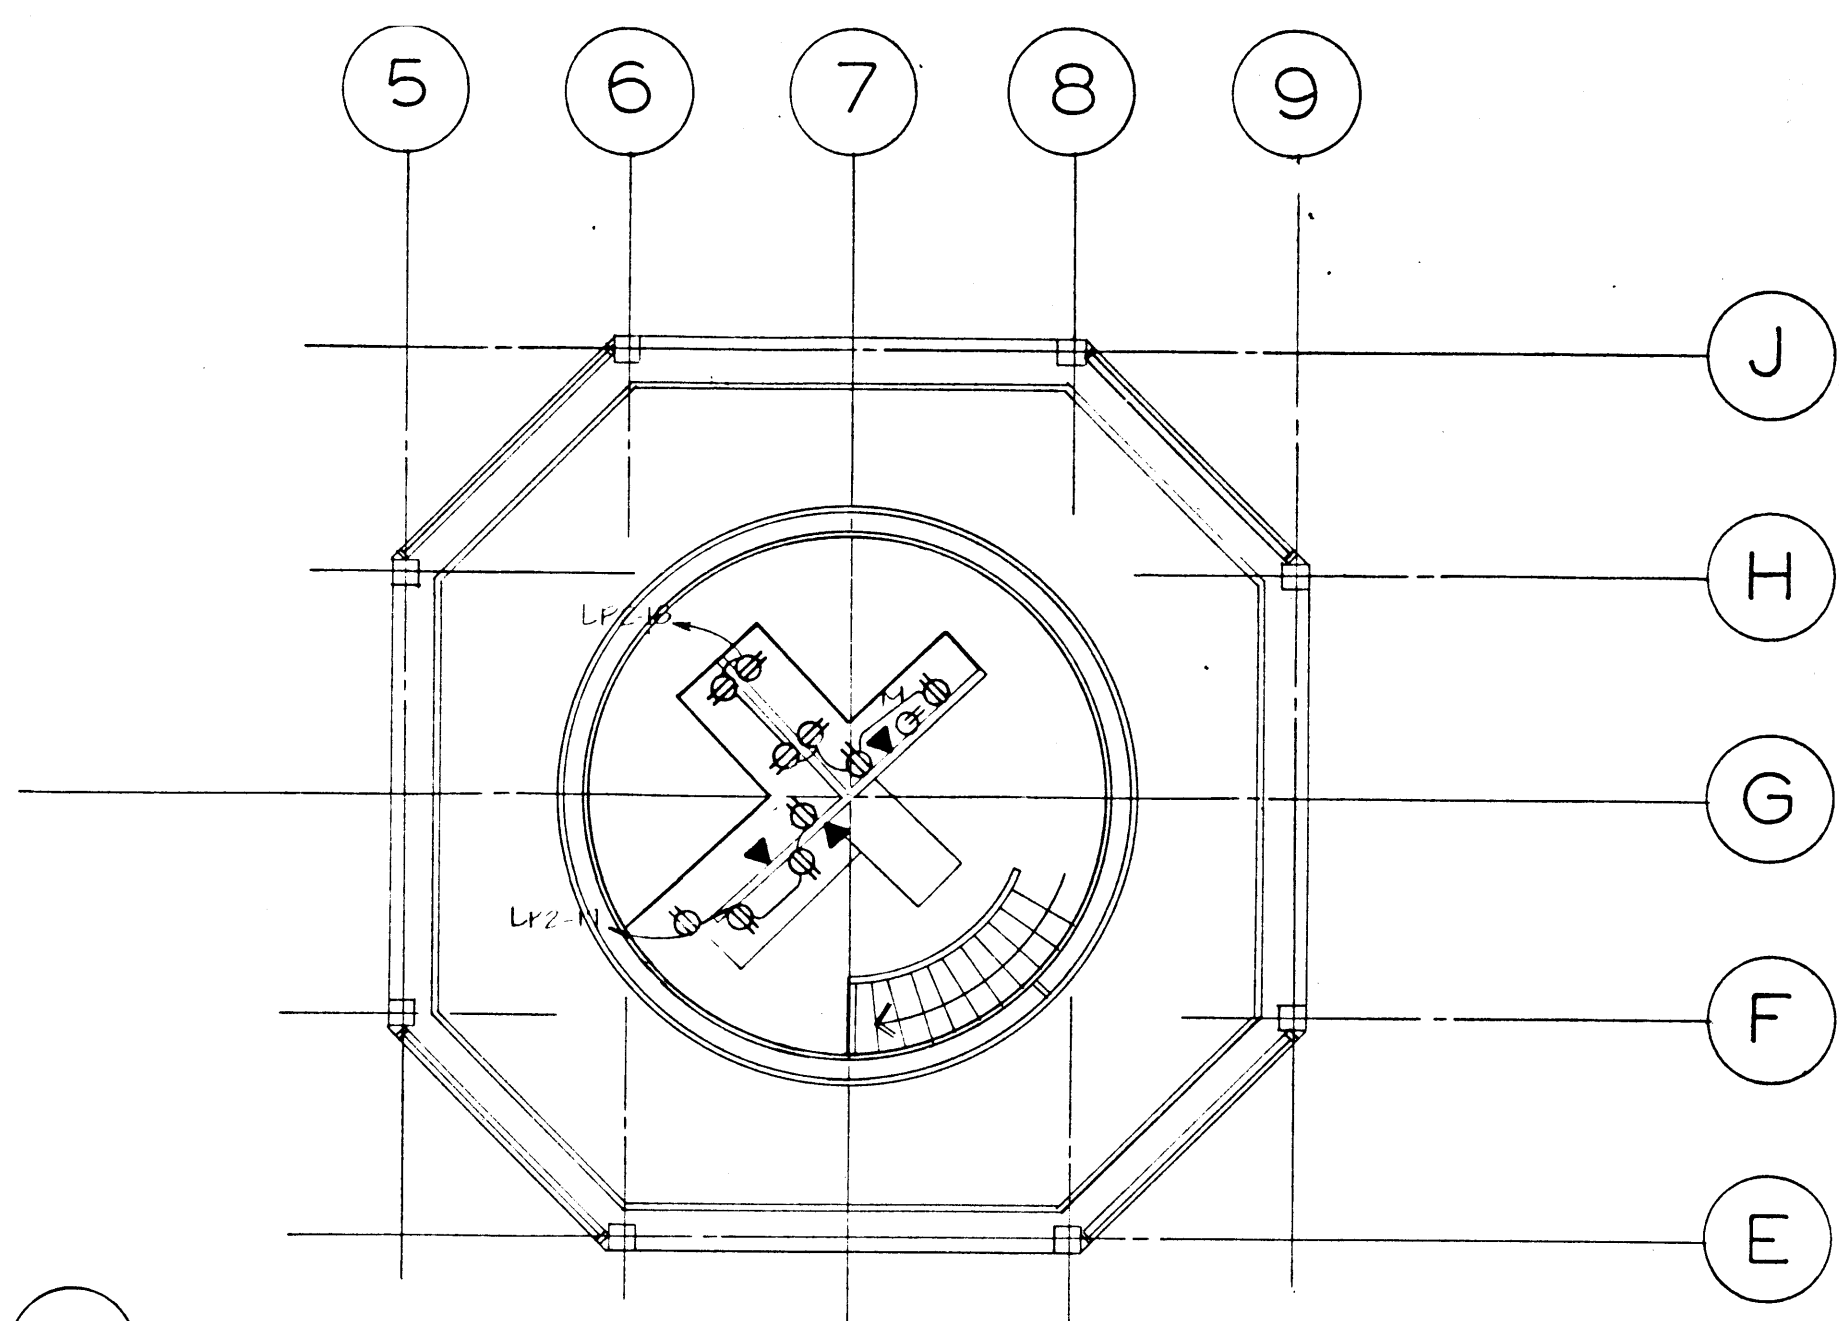


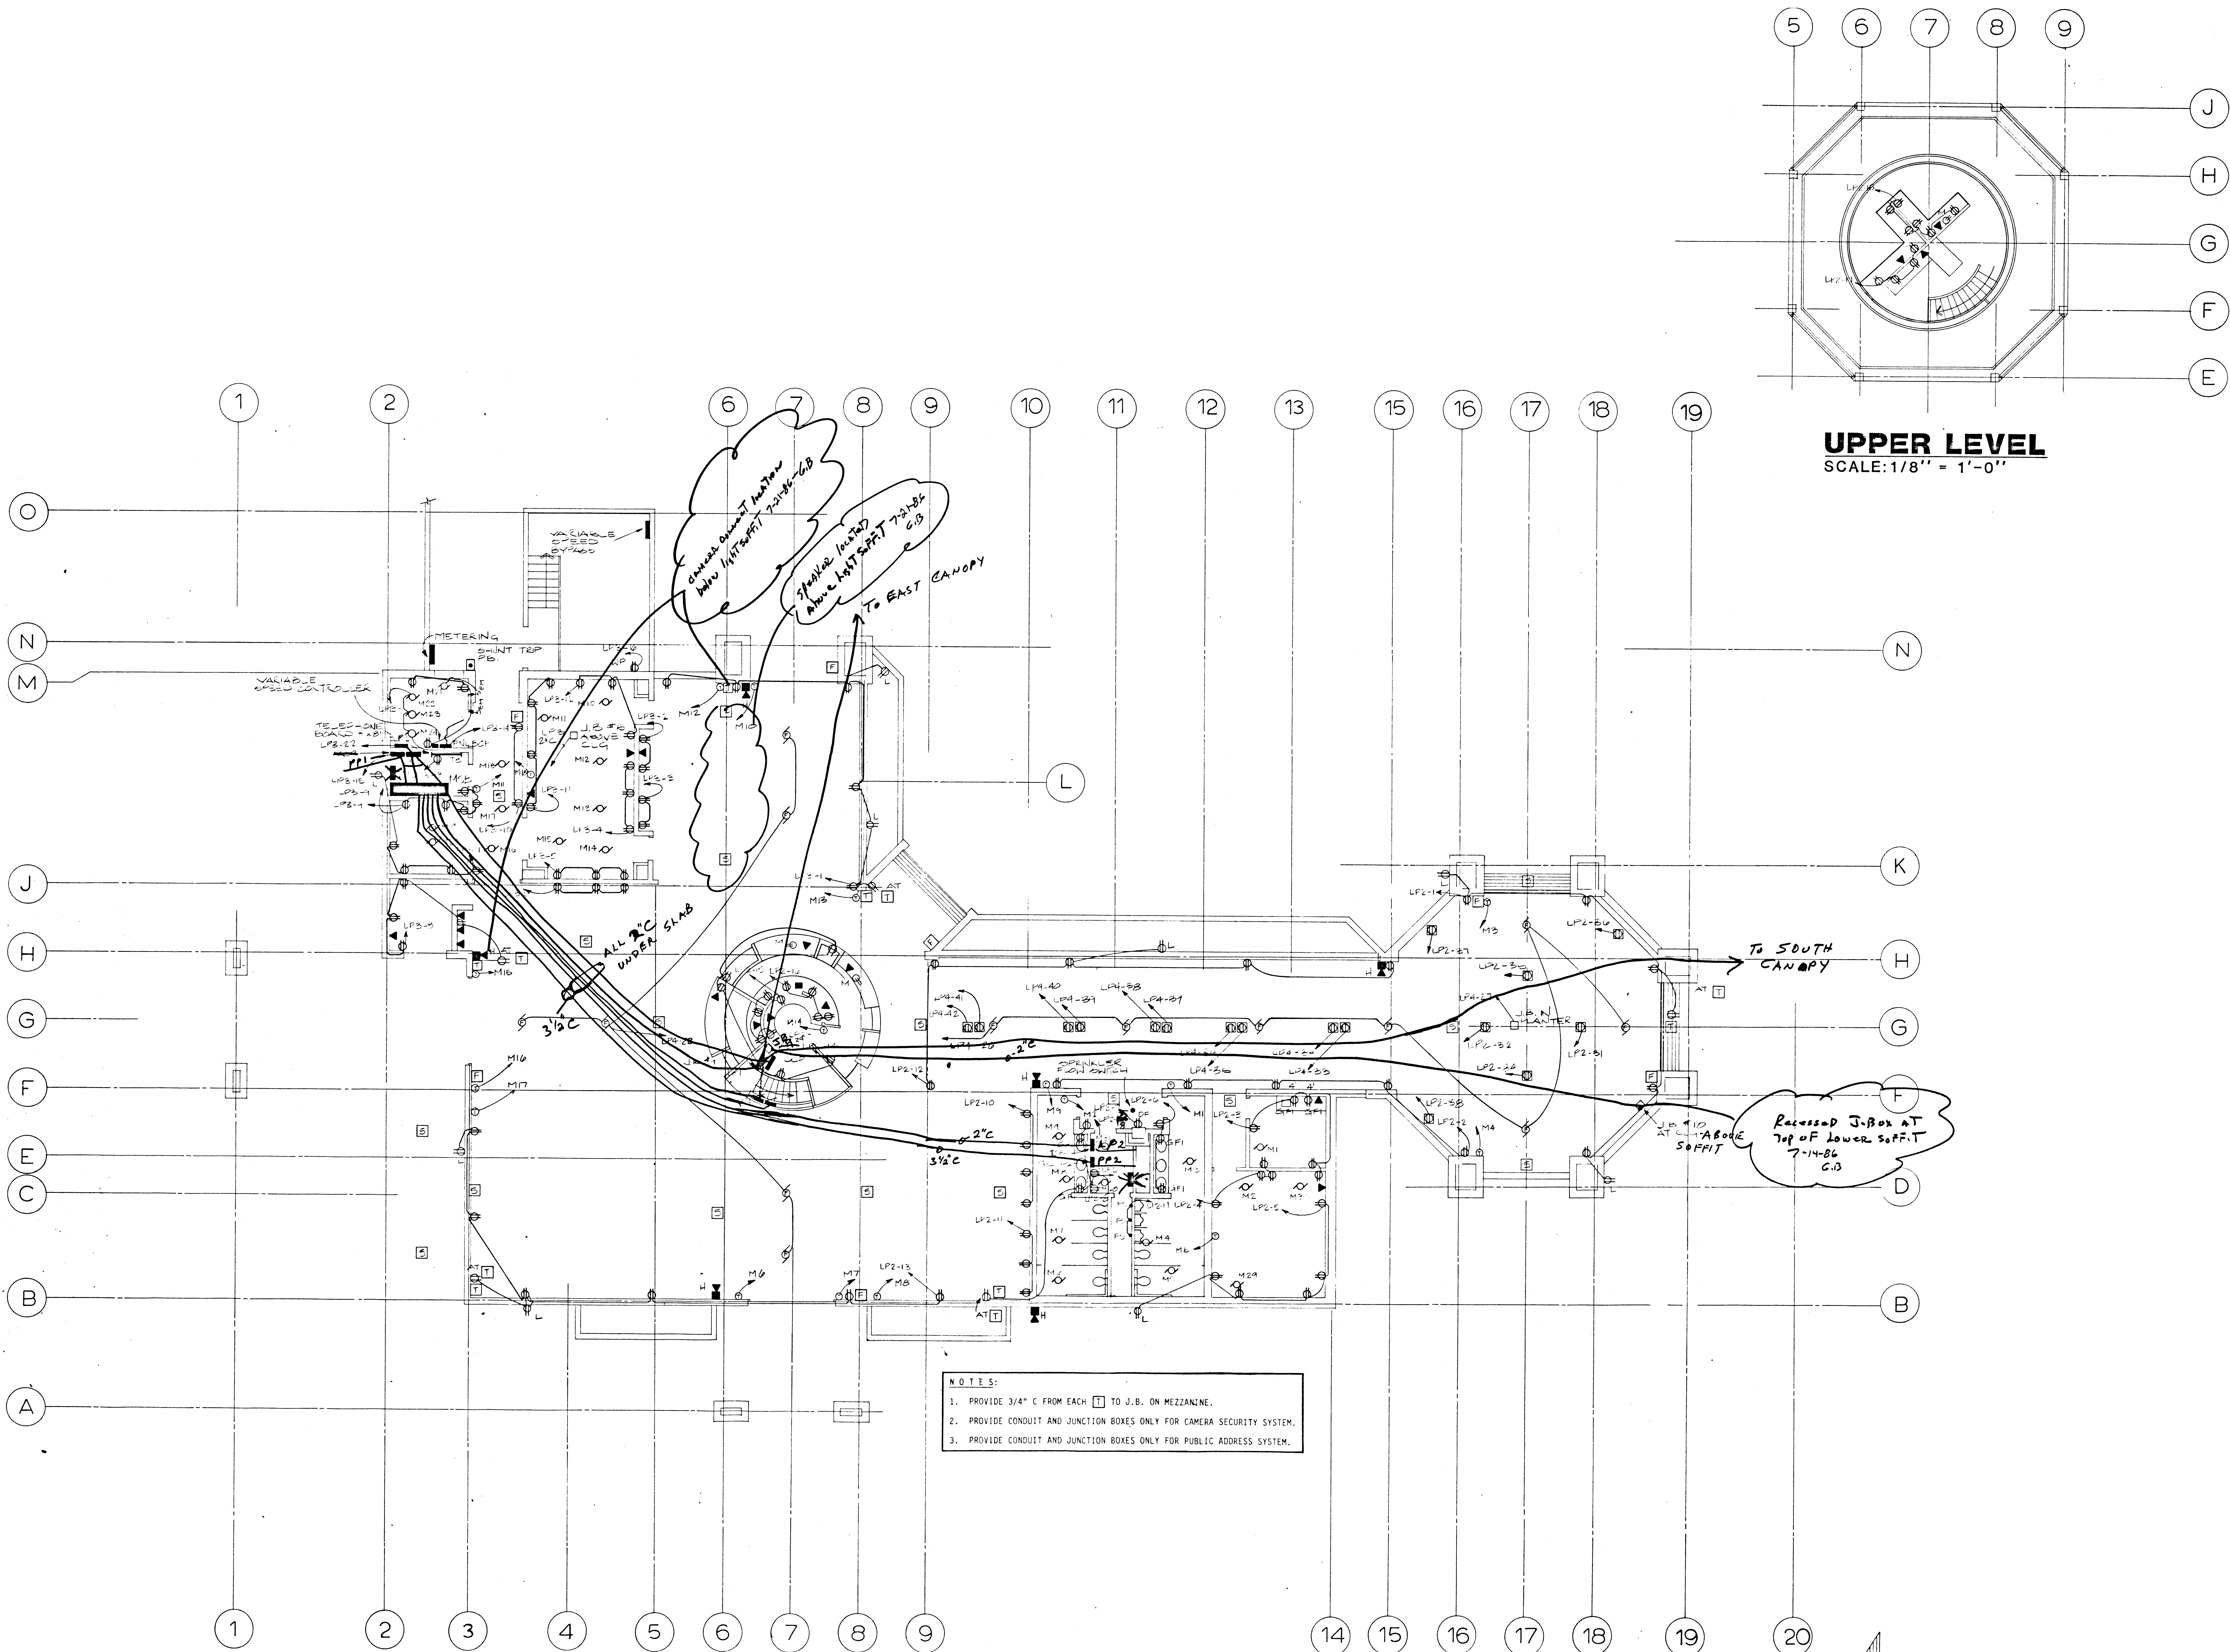

UPPER LEVEL
SCALE: 1/8" = 1'-0"

- NOTES:**
1. PROVIDE 3/4" C FROM EACH T TO J.B. ON MEZZANINE.
 2. PROVIDE CONDUIT AND JUNCTION BOXES ONLY FOR CAMERA SECURITY SYSTEM.
 3. PROVIDE CONDUIT AND JUNCTION BOXES ONLY FOR PUBLIC ADDRESS SYSTEM.

INTERIOR POWER, TELEPHONE & FIRE ALARM PLAN
SCALE: 1/8" = 1'-0"

DUNHAM ASSOCIATES INC.
CONSULTING ENGINEERS
1817 LAMAR BLVD.
LAS VEGAS, NEVADA 89102

DOBROUSKY KITTELL GARLOCK
aia
Architects
3833 CAMBRIDGE ST. LAS VEGAS, NEVADA 89108
(702) 733-9439

City of Las Vegas
Downtown Transportation Center
Las Vegas, Nevada

SHEET
E-3
DATE
10/24/87
FILE NUMBER
100-21