
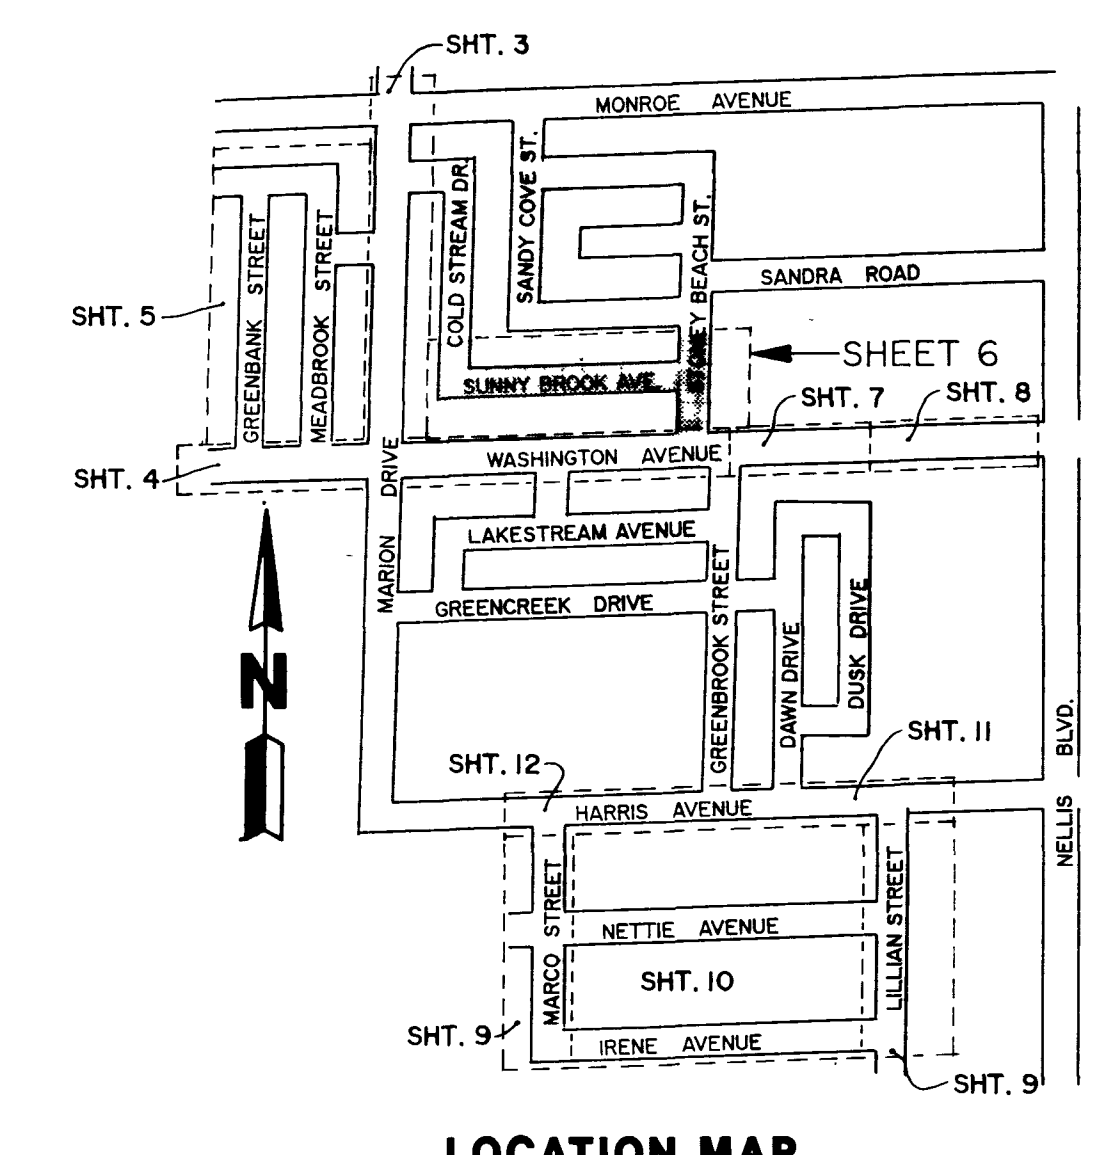
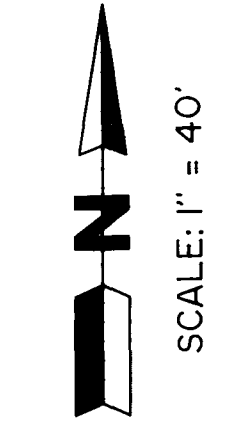



6+25 LIMITS OF CONSTRUCTION

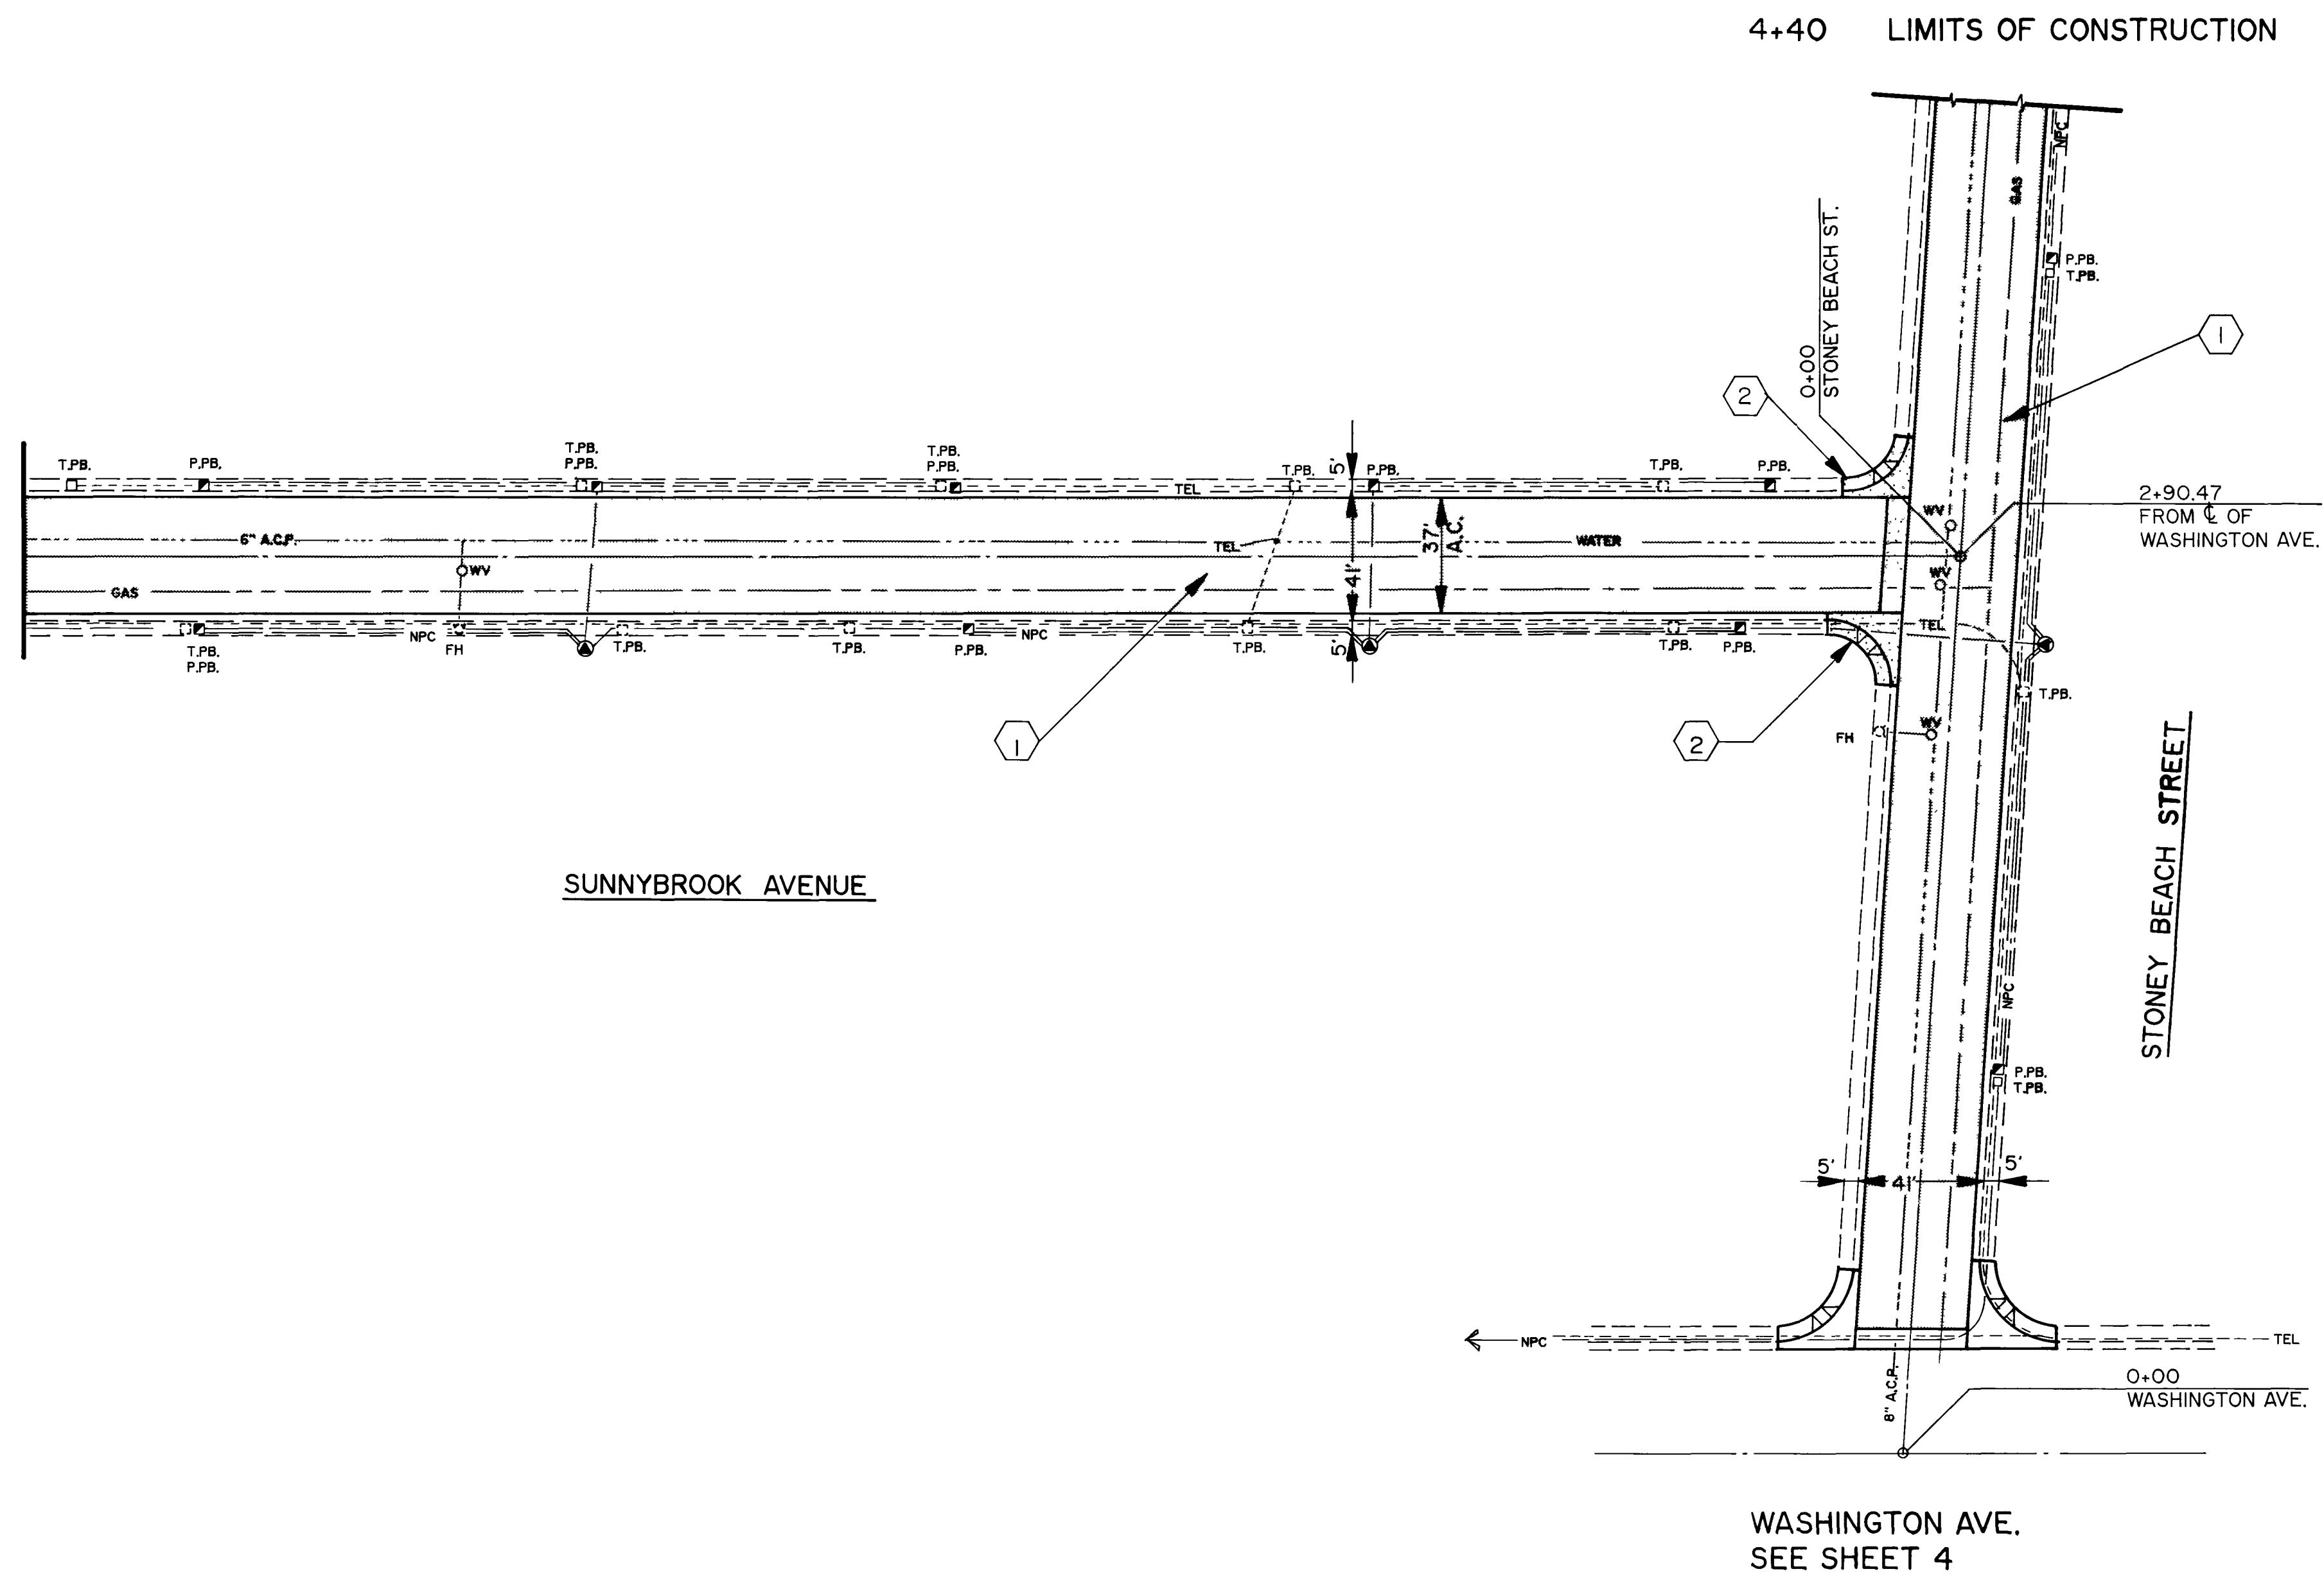

WATER DISTRICT PLAN NUMBER  
O.S. 545

Revisions	Date


Scale (H) 1" = 40'	Scale (V) 1" = 40'	W.A.
Fid. bk. no.	Date 31/7/89	
Design by D. ANDERSON	Drawn by G. GAGNON	
Approved by	Date	

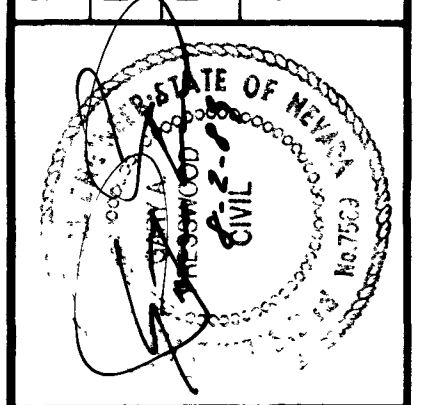


**Department of Public Works**  
**1988 1989 STREET REHABILITATION PROJECT**  
**WASHINGTON AVENUE AND MARION DRIVE**



Drawing no. 6/14

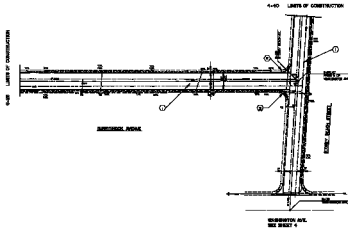

MECHANICAL PLAN  
6-88

 

Department of Public Works 1988 1989 STREET REHABILITATION PROJECT MECHANICAL ASSESSMENT AND SERVICE DRIVE	
PROJECT NO. 1-88 SHEET NO. 1-60 DATE 1-1-88 DRAWN BY J. J. JONES CHECKED BY J. J. JONES IN CHARGE J. J. JONES	
PROJECT NO. 1-88 SHEET NO. 1-60 DATE 1-1-88 DRAWN BY J. J. JONES CHECKED BY J. J. JONES IN CHARGE J. J. JONES	