


COBALT DATA CENTER

U.S. Standard Units
(Inch-Pound Units)
ALL UNITS IN FEET UNLESS
OTHERWISE NOTED

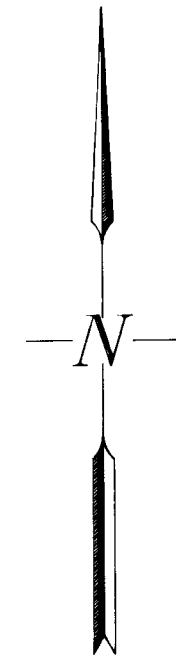

GENERATOR ENCLOSURE

7710 W. CHEYENNE BLVD.
LAS VEGAS NEVADA 89129
PARCEL #: 138-09-821-010

CURRENT ZONING: C1 (LIMITED COMMERCIAL DISTRICT)



**HORROCKS
ENGINEERS**
2785 South Rainbow Blvd.
Las Vegas, Nevada, 89146
(702) 498-6309

REV	DATE	BY	DESCRIPTION

APPROVALS

David M. Bowers 9-6-12
DAVID M. BOWERS (P.E.#16736, P.T.O.E.) DATE
CITY OF LAS VEGAS-CITY ENGINEER

APPROVAL OF THESE PLANS IS LIMITED TO THOSE IMPROVEMENTS CONSTRUCTED IN THE DEDICATED RIGHT-OF-WAY AND/OR DEDICATED EASEMENTS. THIS APPROVAL DOES NOT AUTHORIZE THE CONSTRUCTION OF ANY IMPROVEMENTS THAT DEVIATE FROM ADOPTED STANDARDS AND/OR SPECIFICATIONS, EXCEPT THOSE SPECIFICALLY LISTED UNDER "DEVIATIONS FROM STANDARD". THE ENGINEER SHALL RESOLVE ANY DEVIATIONS OTHER THAN THOSE LISTED IN "DEVIATIONS FROM STANDARDS" IN FAVOR OF THE UNIFORM STANDARD DRAWINGS AND SPECIFICATIONS, CLARK COUNTY AREA, NEVADA.

Doug Rankin 9-6-12
DOUG RANKIN (AICP) DATE
PLANNING MANAGER
THIS PLAN MEETS THE APPLICABLE STANDARDS OF THE PLANNING DEPARTMENT.

Scott Rasmussen 9/5/12
CITY OF LAS VEGAS FIRE MARSHALL Dept. DATE
APPROVAL BY THE FIRE DEPARTMENT HAVING JURISDICTION IS REQUIRED PRIOR TO OBTAINING FINAL APPROVAL FROM THE LVVWD.

N/A
LAS VEGAS VALLEY WATER DISTRICT DATE

N/A
NEVADA POWER COMPANY DATE
NEVADA POWER COMPANY ACKNOWLEDGES THAT WE HAVE RECEIVED YOUR PLANS AND WILL PROVIDE SERVICE TO ALL ELECTRICAL NEEDS ASSOCIATED WITH THIS PROJECT. NEVADA POWER COMPANY RESERVES THE RIGHT TO ADDRESS ANY EXISTING OR FUTURE CONFLICTS ONCE THE FINAL DESIGN IS COMPLETED. THE NEW SERVICE AND RESOLUTION OF ANY CONFLICTS WILL BE ACCOMPLISHED PURSUANT TO THE NEVADA PUBLIC UTILITY COMMISSION'S RULES AND REGULATIONS.


N/A
EMBARQ DATE
"THE AFFIXED EMBARQ APPROVAL DOES NOT ASSUME OR GUARANTEE LIABILITY FOR KNOWN OR UNKNOWN CONFLICTS WITH EXISTING OR PROPOSED IMPROVEMENTS. RESOLUTION OF ANY CONFLICT WILL BE ACCOMPLISHED PURSUANT TO LOCAL ORDINANCES, NEVADA REVISED STATUTES AND/OR PUBLIC UTILITY COMMISSION RULES AND REGULATIONS."

N/A
SOUTHWEST GAS CORP. DATE


N/A
COX COMMUNICATIONS, LAS VEGAS INC. DATE

INDEX OF DRAWINGS		
SHEET NO.	NO. OF SHTS	DESCRIPTION
C0	1	TITLE SHEET / INDEX OF DRAWINGS
C1	1	UTILITY PLAN
C2	1	DRAINAGE PLAN

NOTE:
ALL WORK WITHIN PRIVATE BUSINESS PARK.

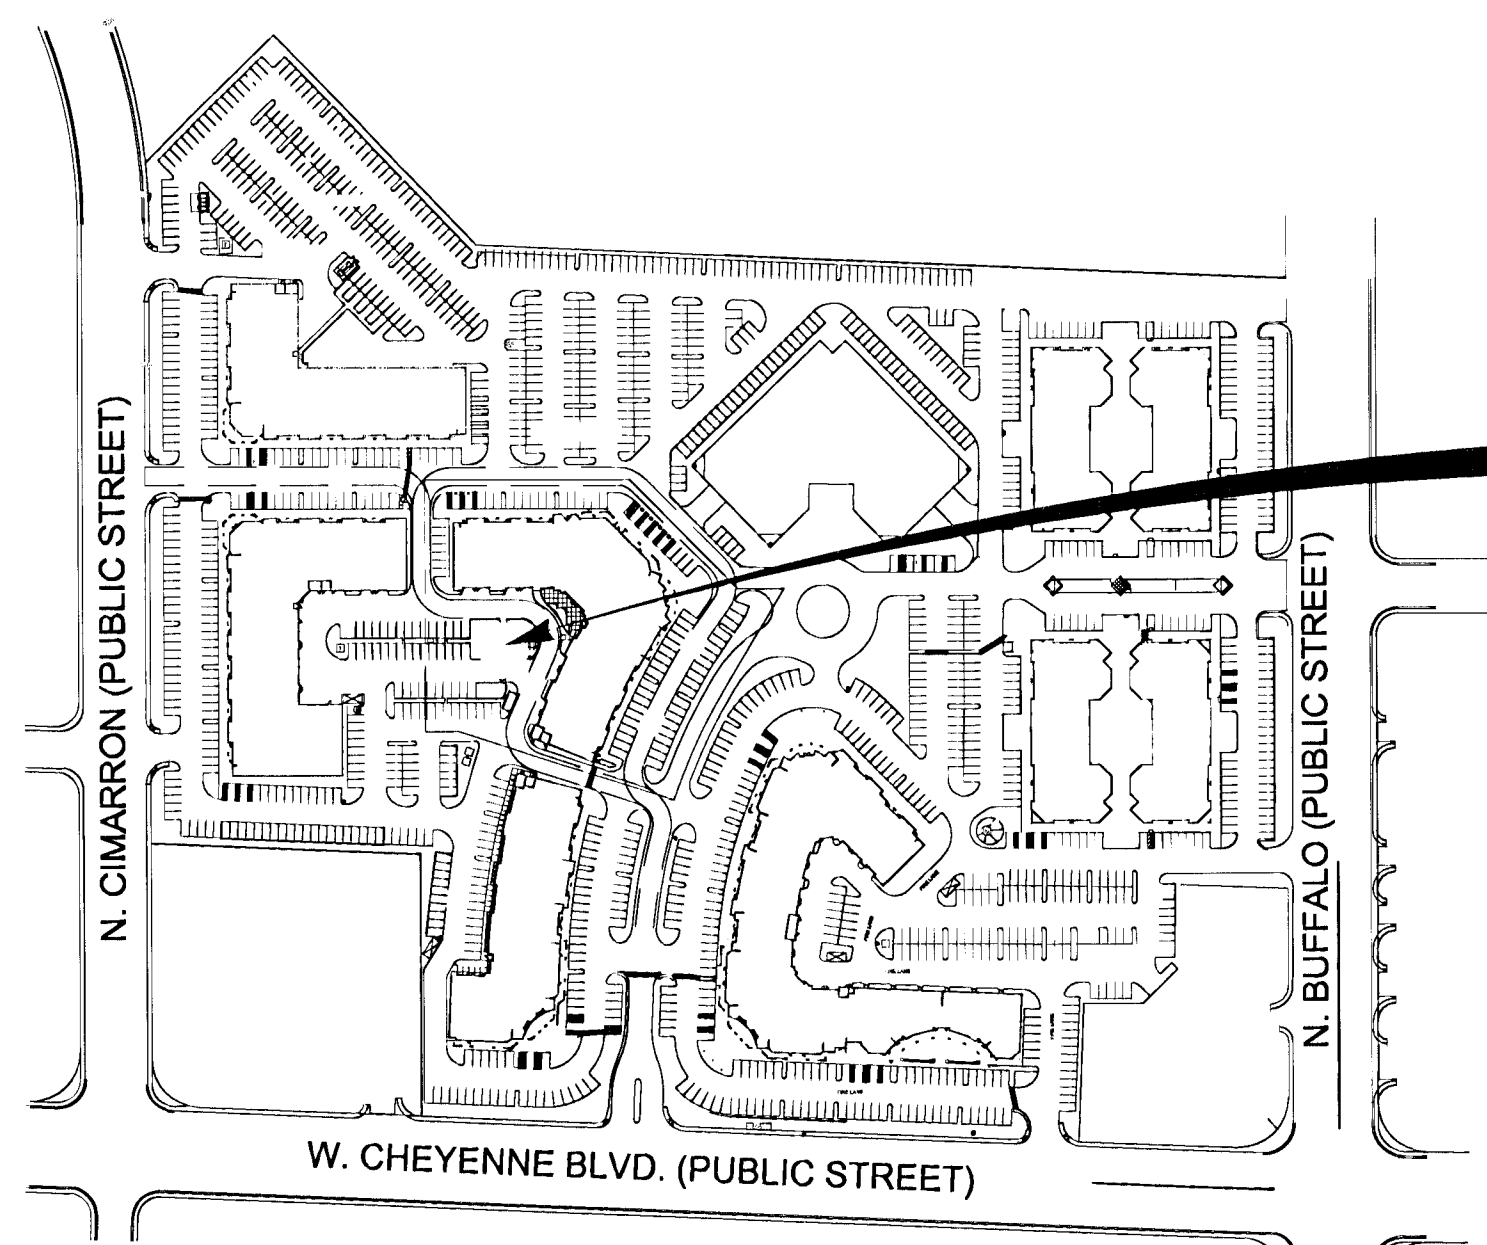

PROJECT SITE

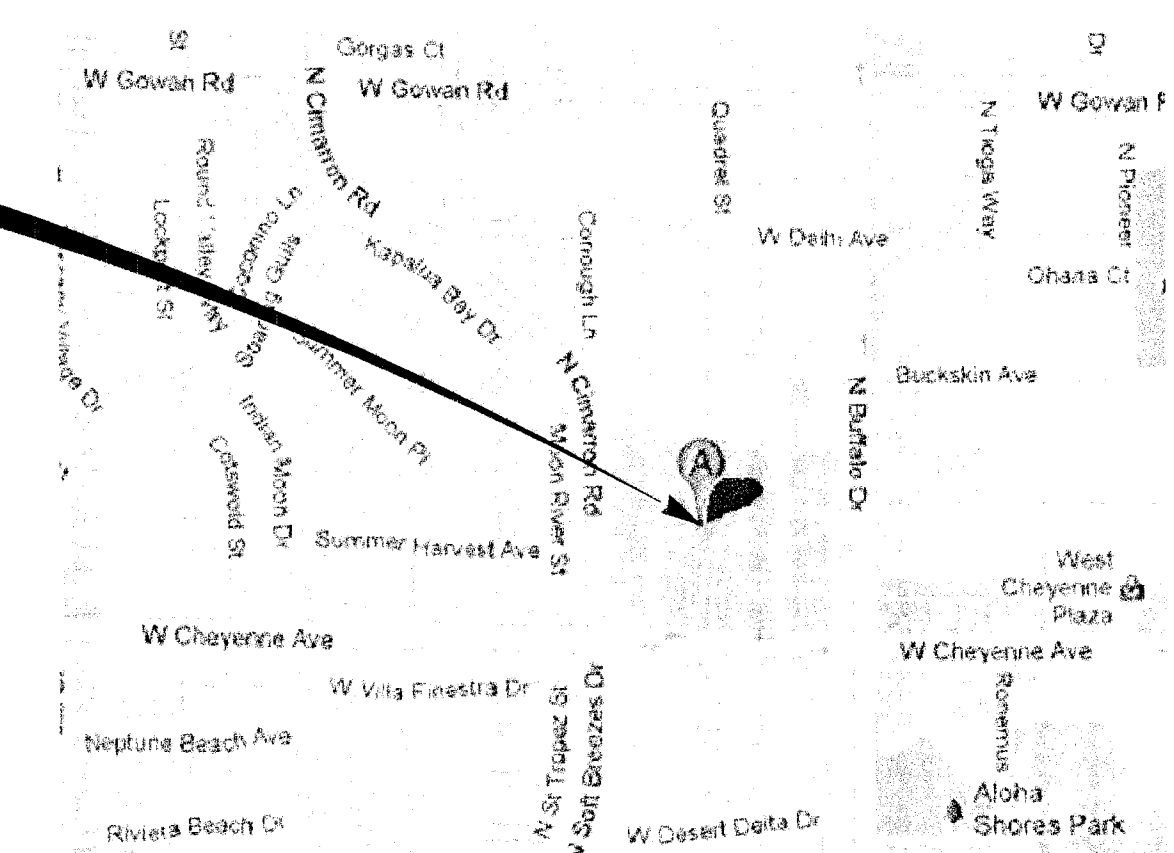

COVER SHEET
COBALT DATA CENTER

DESIGNED	DATE	7/27/12
BS	DATE	7/27/12
DRAWN	DATE	7/27/12
SM	DATE	7/27/12
CHECKED	DATE	7/27/12
SAD	DATE	7/27/12

WARNING
IF THIS BAR DOES NOT MEASURE 2" THEN DRAWING IS NOT TO SCALE

SCALE	HORIZONTAL	VERTICAL
NONE	NONE	NONE

SHEET NAME
C0

1855

H#46616
R#107V5882