
 


12/27/17 G:\14078 CIMARRON PEDESTRIAN BRIDGE\H48938\SHEET SET\DWG\H48938-05-SM00.DWG

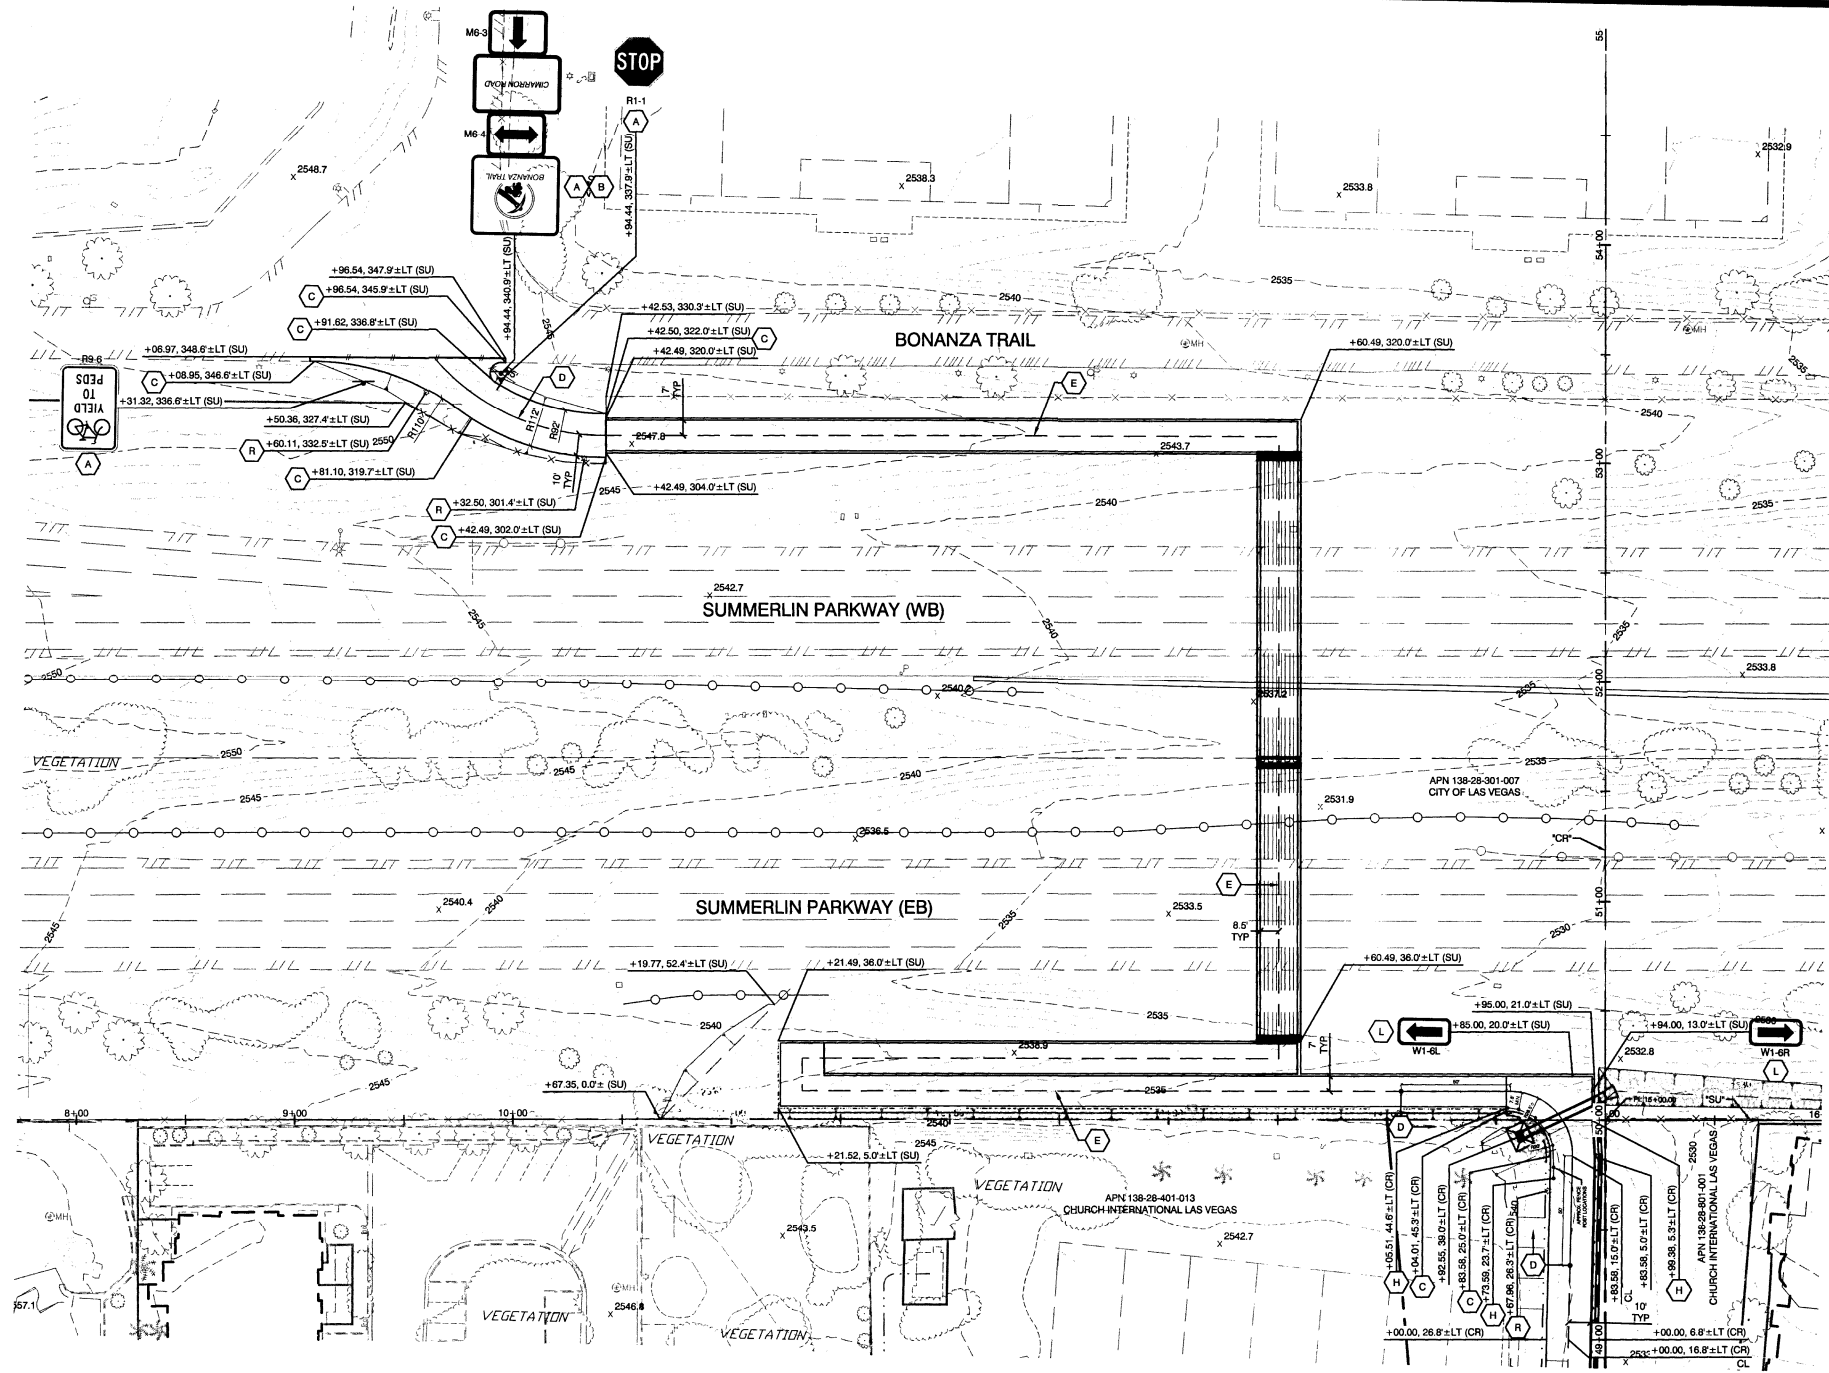

FOR CONTINUATION  
SEE SHEET SM-02



CALL BEFORE CONSTRUCTION		
BEFORE YOU DIG	USA NORTH	811 OR 800-227-2600
BEFORE YOU UNDERGROUND	F.A.S.T.	702-452-5300
	CLARK COUNTY TRAFFIC OPERATIONS	702-455-7511
	CITY OF LAS VEGAS T.E.F.O.	702-229-6611
BEFORE YOU OVERHEAD	NV ENERGY	702-227-2929

**STRIPING, SIGNAGE AND CONST. NOTES**

- A PROVIDE AND INSTALL POST-MOUNTED TRAFFIC SIGN PER USD 248.1
- B USE SYMBOLLOGY THAT MATCHES EXISTING BONANZA TRAIL SIGNAGE PER DETAIL 1 ON SHEET TY-02
- C HORIZONTAL CURVE TRANSITION
- D INSTALL 4" SOLID YELLOW CENTER LINE (POLYUREA) PER USD 255.4
- E INSTALL 4" DASHED YELLOW CENTER LINE (POLYUREA) PER USD 255.4
- F INSTALL REMOVABLE BOLLARD (SEE SHEET TY-02, DETAIL 2)
- G REPLACE EXISTING STREETLIGHT FIXTURE HEAD WITH 1400 LED-EQUVALENT LUMINAIRE PER SPECIAL PROVISION SECTION E2.03.03.
- H INSTALL POST AND CABLE FENCE PER DETAIL 1 ON SHEET TY-03. ENSURE FULL ENCLOSURE BETWEEN EXISTING TRAIL WALL AND PROPOSED RAMP RAIL. ENSURE FENCE IS NOT INSTALLED OVER UTILITY BOXES.
- I PROVIDE AND INSTALL END OF ROAD BARRIER SIGN PER DETAIL THIS SHEET.
- J PROVIDE AND INSTALL TRAFFIC SIGN ON EXISTING STREETLIGHT.
- K REINSTALL EX TRAFFIC SIGN PANELS
- L PROVIDE AND INSTALL WALL-MOUNTED TRAFFIC SIGN
- M INSTALL 6" SOLID WHITE STORAGE LANE LINE (POLYUREA) PER USD 246.7
- N INSTALL 6" WHITE SKIP LINE (POLYUREA) PER USD 244.9
- O INSTALL 24" WHITE CHEVRON AT 25' O.C. SPACING (POLYUREA)
- P INSTALL WHITE PAINTED DIRECTIONAL ARROW (POLYUREA)
- Q REMOVE EXISTING STRIPING
- R AREA LUMINAIRE TO BE INSTALLED BY CONTRACTOR. CONSTRUCT PER SHEET E2.01 & E3.01.

PREPARED BY <b>CITY OF LAS VEGAS</b> DEPARTMENT OF PUBLIC WORKS CAPITAL PROJECT MGMT							
PREPARED FOR <b>CITY OF LAS VEGAS</b> H# 48938		DESIGNED BY: MAS BID# 17-48938		DRAWN BY: MAS		CHECKED BY: AP	
DATE: JANUARY 2018 SUBMITTAL STAGE: <b>100% FINAL</b>							
<b>CIMARRON PEDESTRIAN BRIDGE AT SUMMERLIN PARKWAY</b> <b>SIGNAGE/MARKING/CURVE DATA PLAN</b> <b>SUMMERLIN PARKWAY</b>							
SHEET <b>SM-01</b> 16 OF 86 DRAWING NO. <b>676-22</b>							
FEDERAL PROJECT NUMBER: CM-0003(160)							