




**A** RAMP TO BRIDGE CONNECTION  
E0.03 NTS

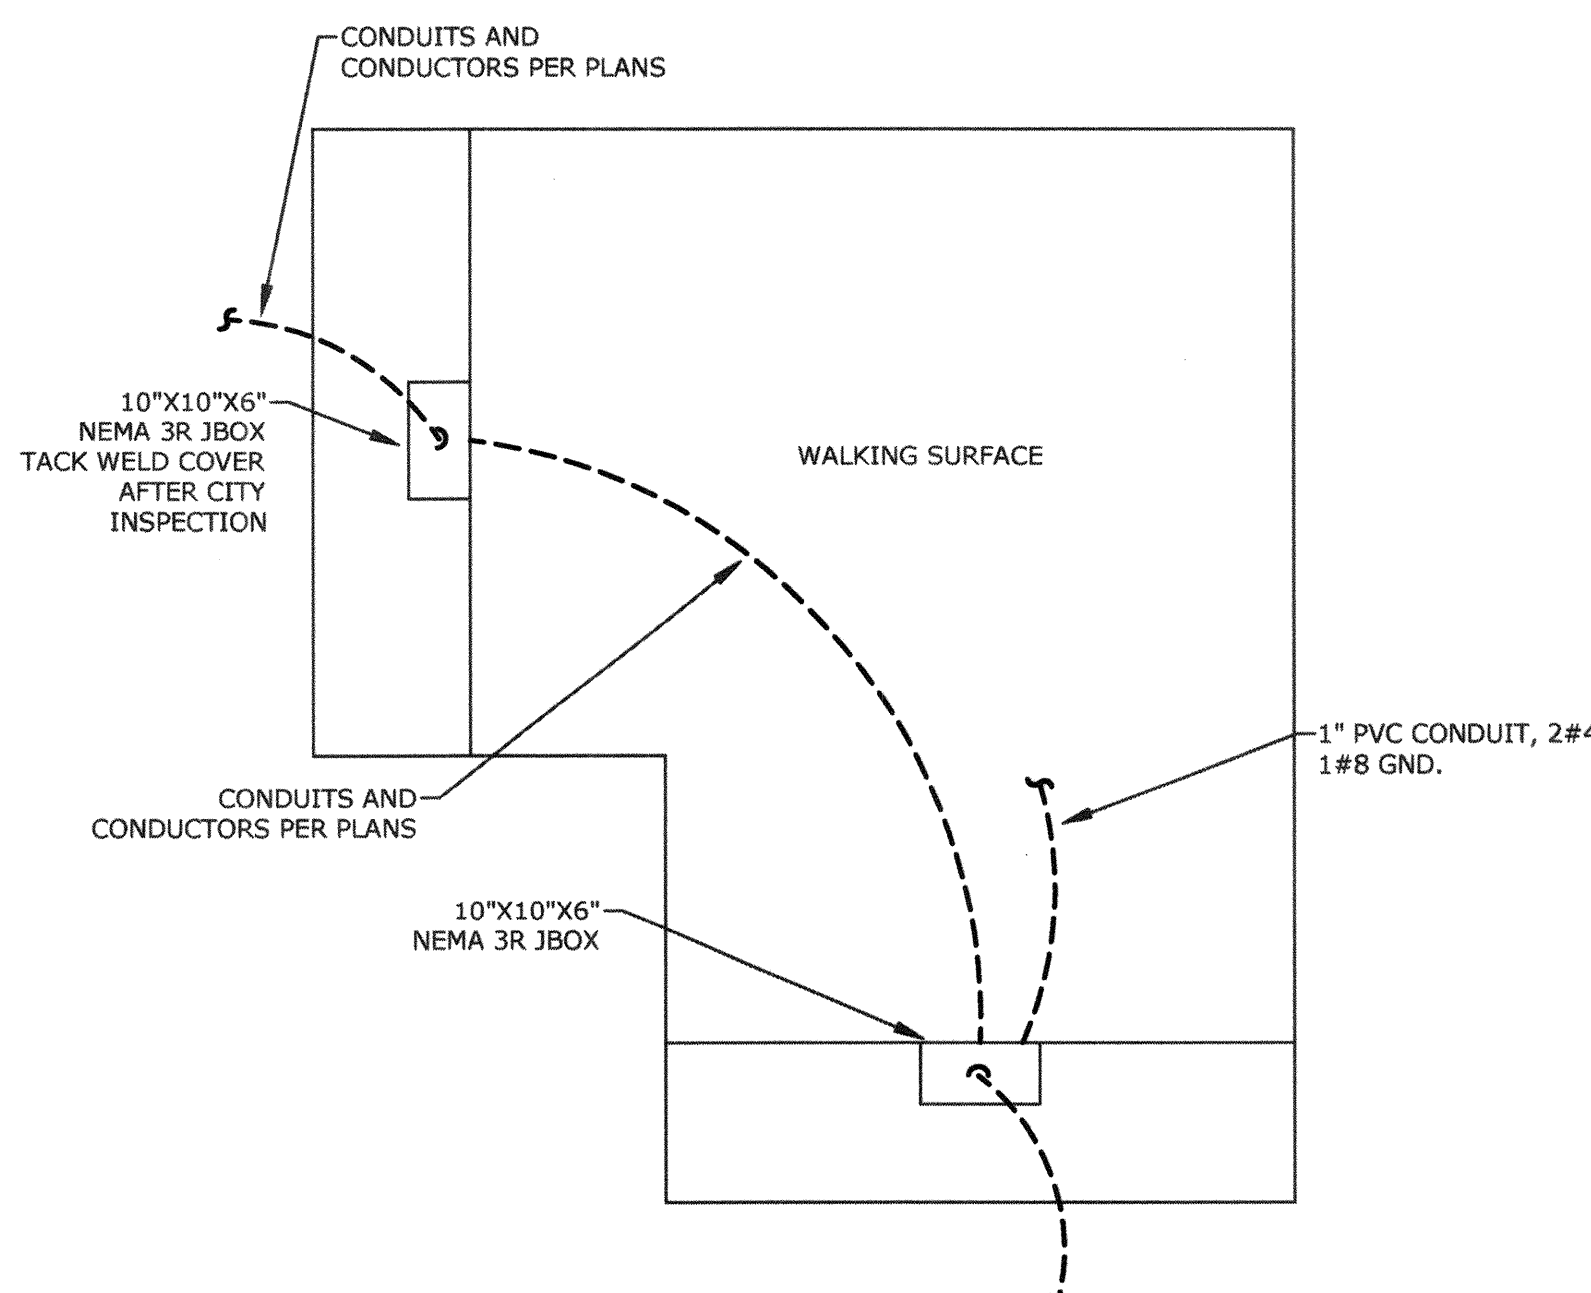


**B** RAMP TO BRIDGE CONNECTION  
E0.03 NTS

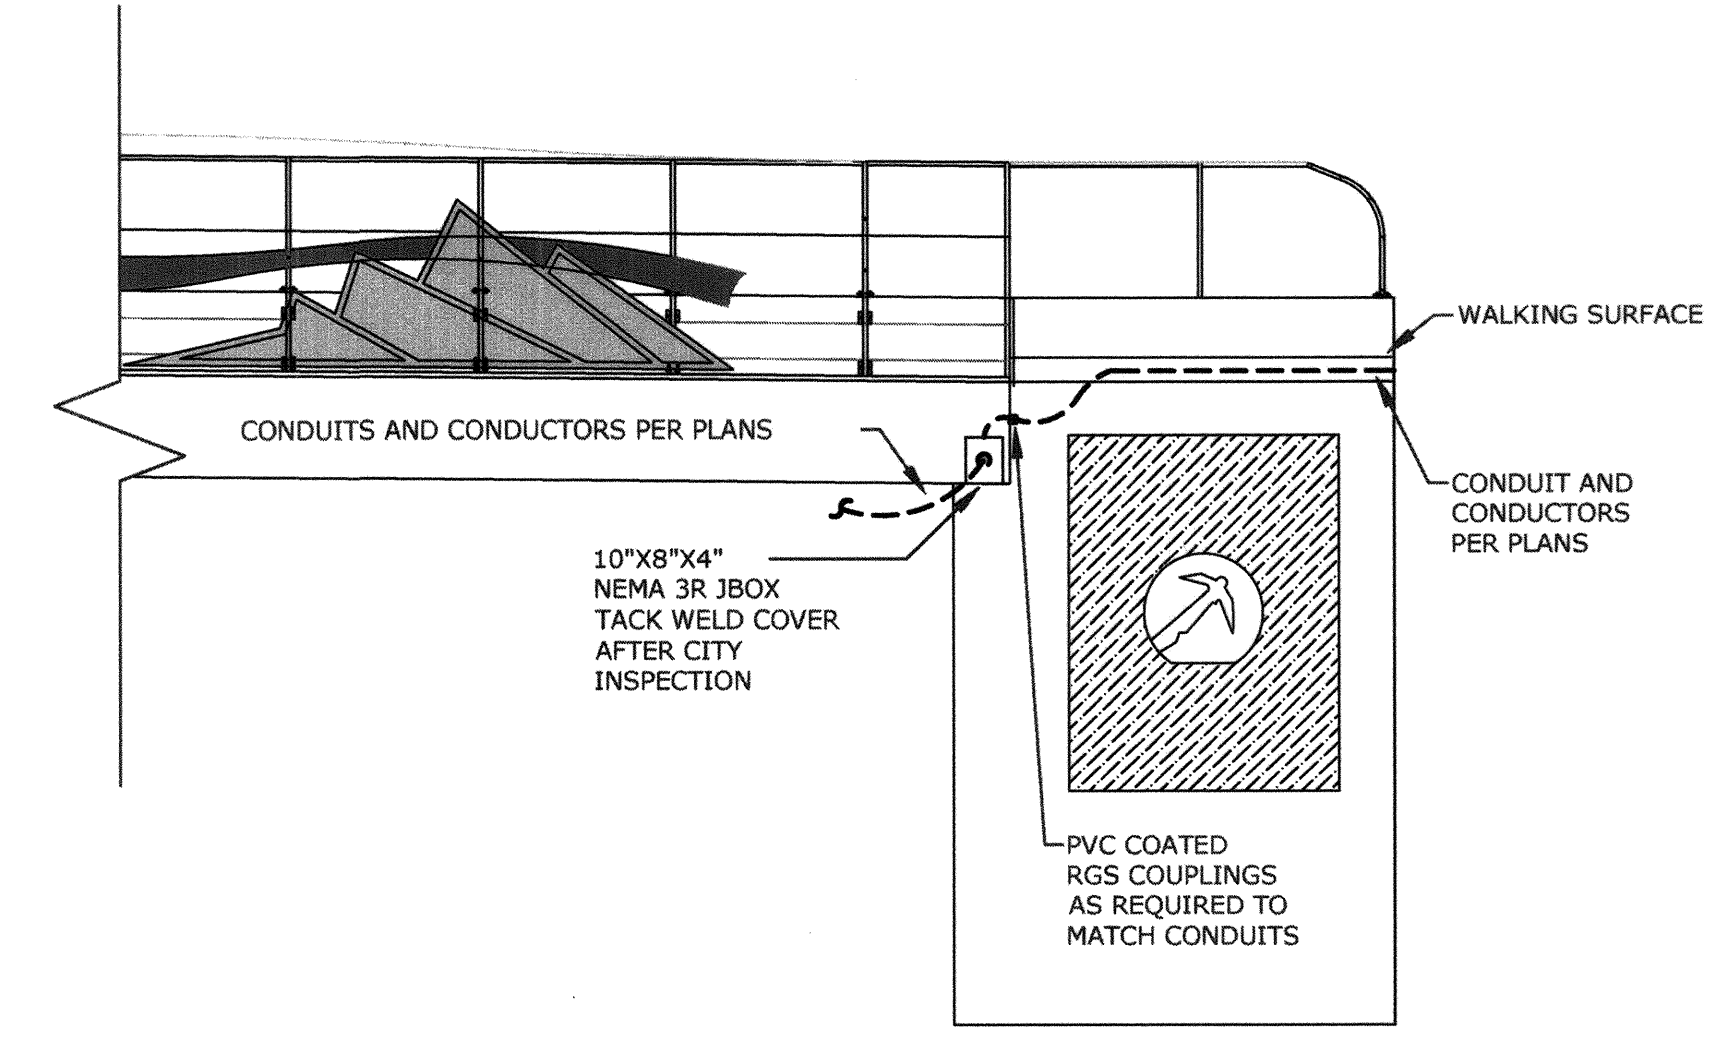

**C** RAMP TO BRIDGE CONNECTION SECTION  
E0.03 NTS

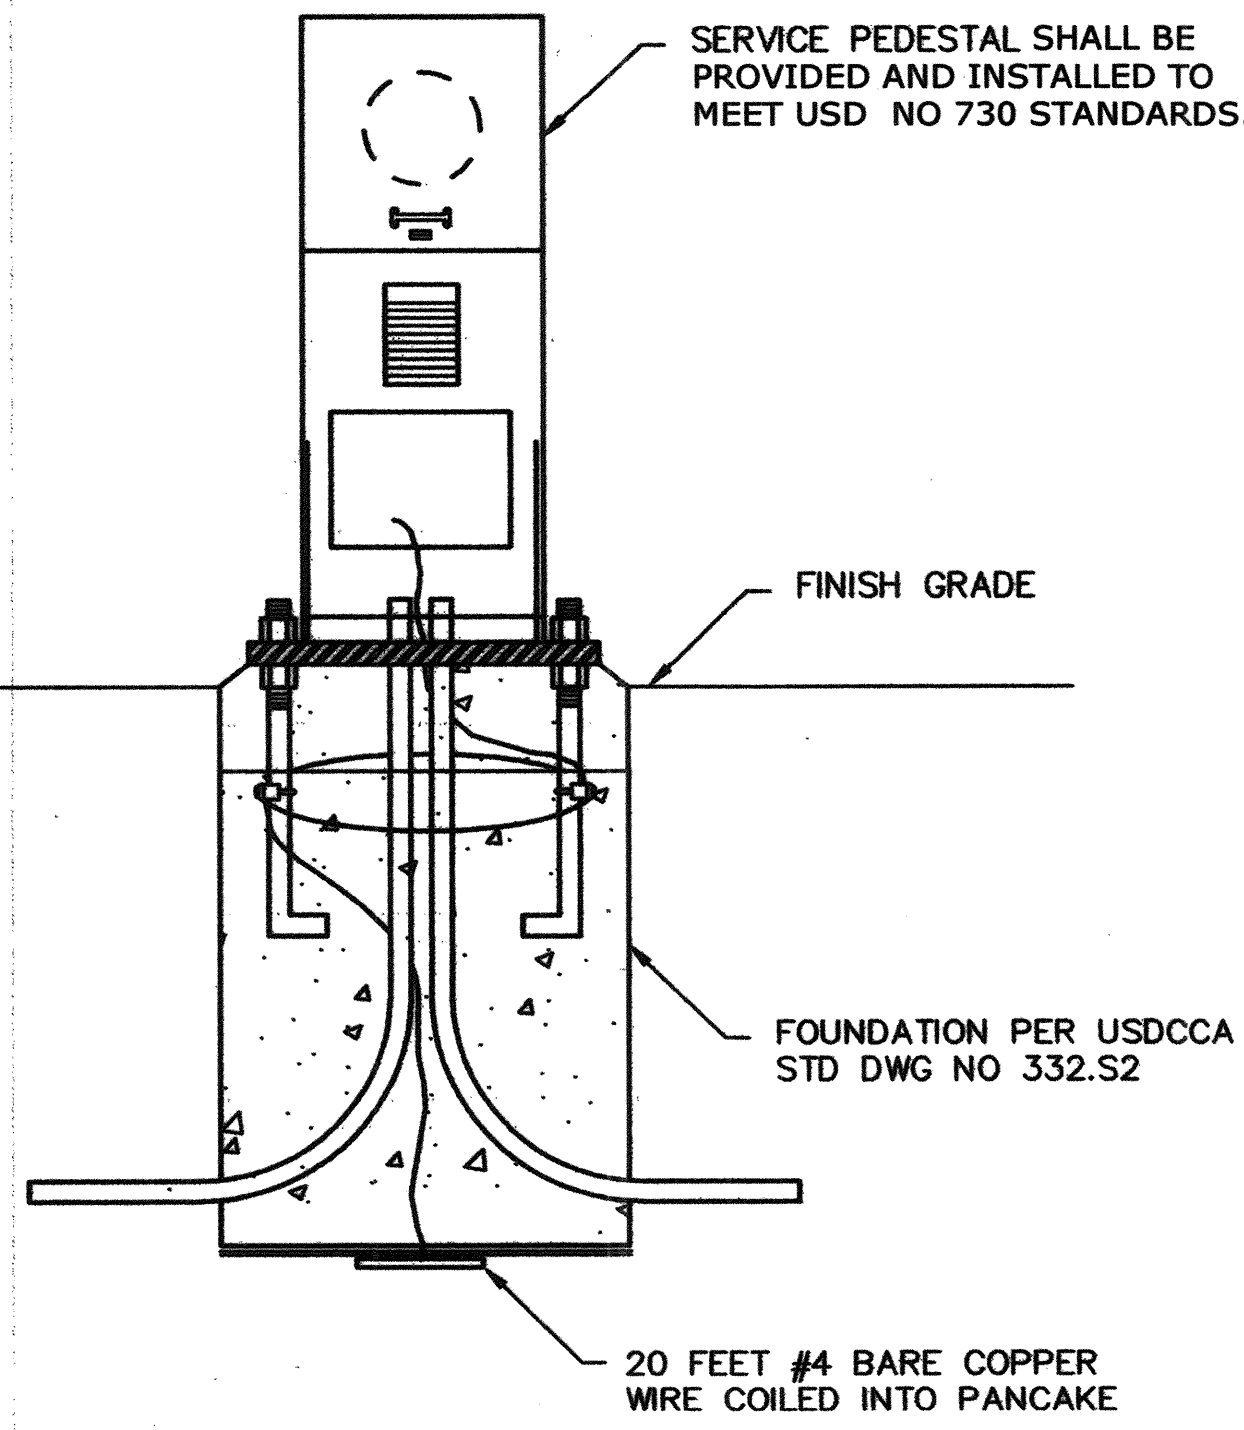

**D** SERVICE PEDASTAL AND FOUNDATION  
E0.03 NTS

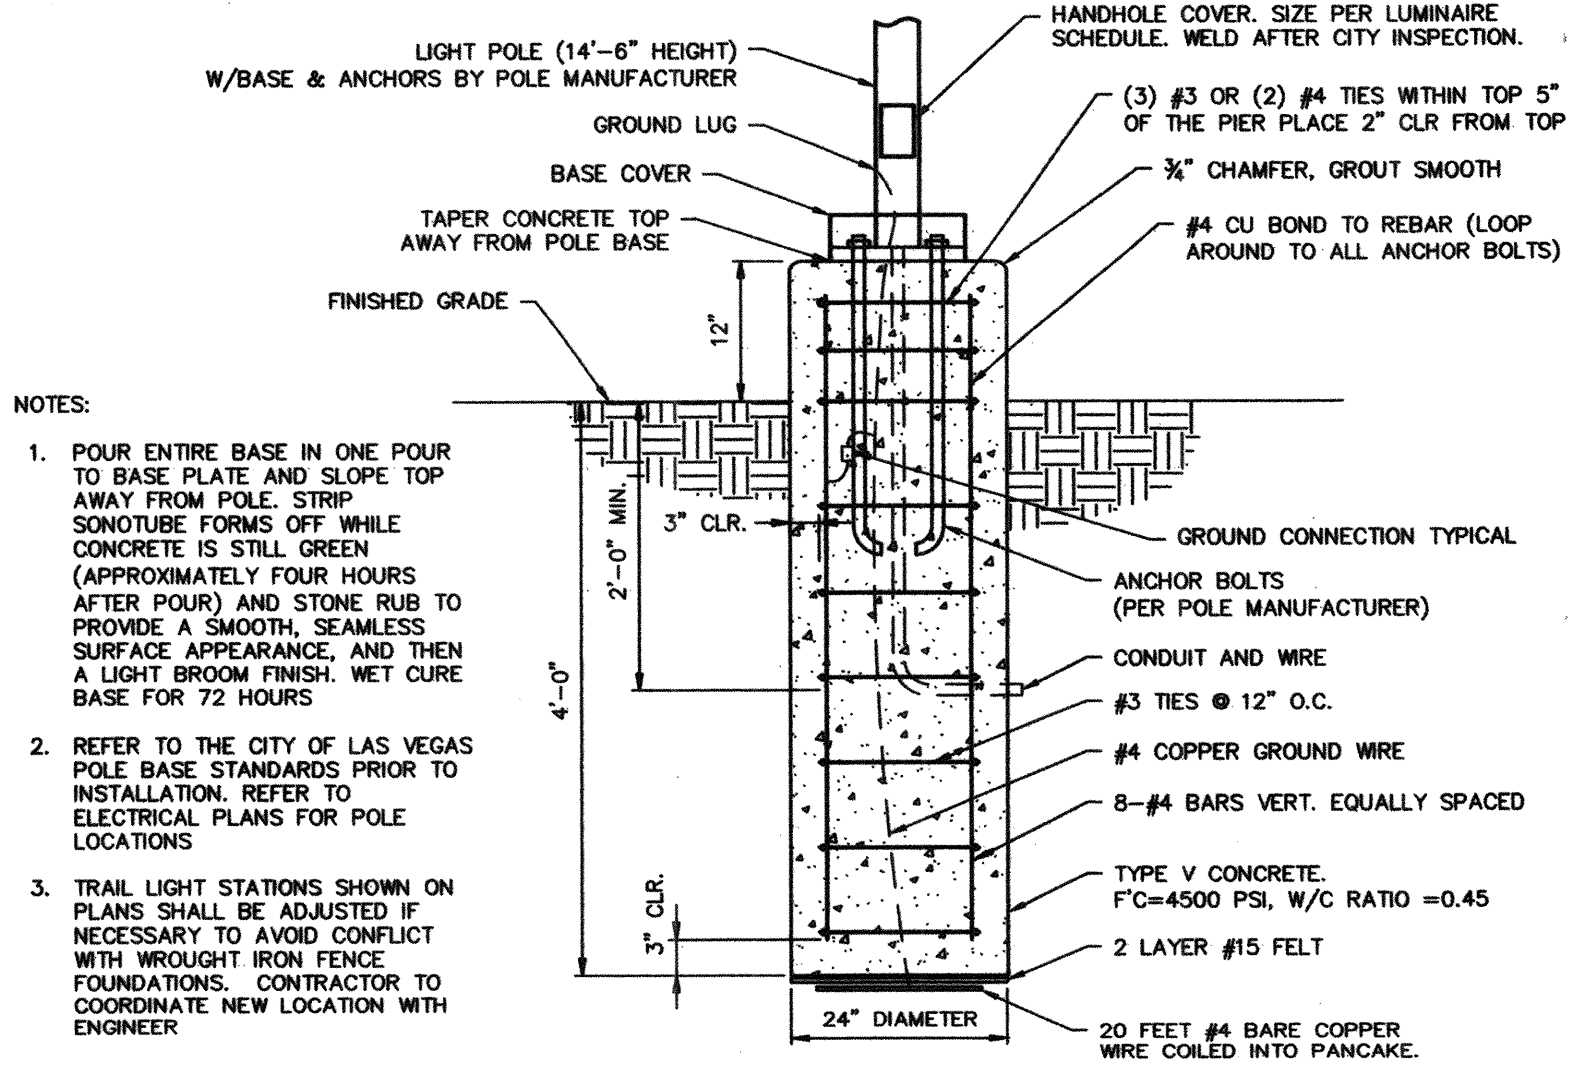

**E** TRAIL LIGHT POLE ASSEMBLY FOOTING  
E0.03 NTS

NO.	DATE	SHEET	REVISIONS

PREPARED BY  
**DEPARTMENT OF PUBLIC WORKS**  
CAPITAL PROJECT MGMT

DESIGNED BY: PE  
DRAWN BY: MSA  
CHECKED BY: PE

DATE: JANUARY 2018  
SUBMITTAL STAGE: 100% FINAL

PREPARED FOR  
**CITY OF LAS VEGAS**

BID# 17-48638  
DATE: JANUARY 2018  
SUBMITTAL STAGE: 100% FINAL

PREPARED BY  
**POGGEMEYER DESIGN GROUP**  
6800 Smoke Ranch Road - Suite 110  
Las Vegas, Nevada 89138 - (702) 295-6100

TITLE  
**CIMARRON PEDESTRIAN BRIDGE AT SUMMERLIN PARKWAY**

SHEET ELECTRICAL DETAILS

PROFESSIONAL ENGINEER-STATE OF NEVADA  
DAVID MERRILL  
E0.03  
NO. 10374  
JAN 12 2018

**msa.**  
ENGINEERING CONSULTANTS  
370 E Windmill Lane, Suite 100  
Las Vegas, NV 89123  
702.896.1100  
msa-ec.com  
MSA#L16032

SHEET  
**E0.03**  
81 OF 86  
DRAWING NO.  
**676-22**