




A
E0.04
NTS
BRIDGE GROUNDING

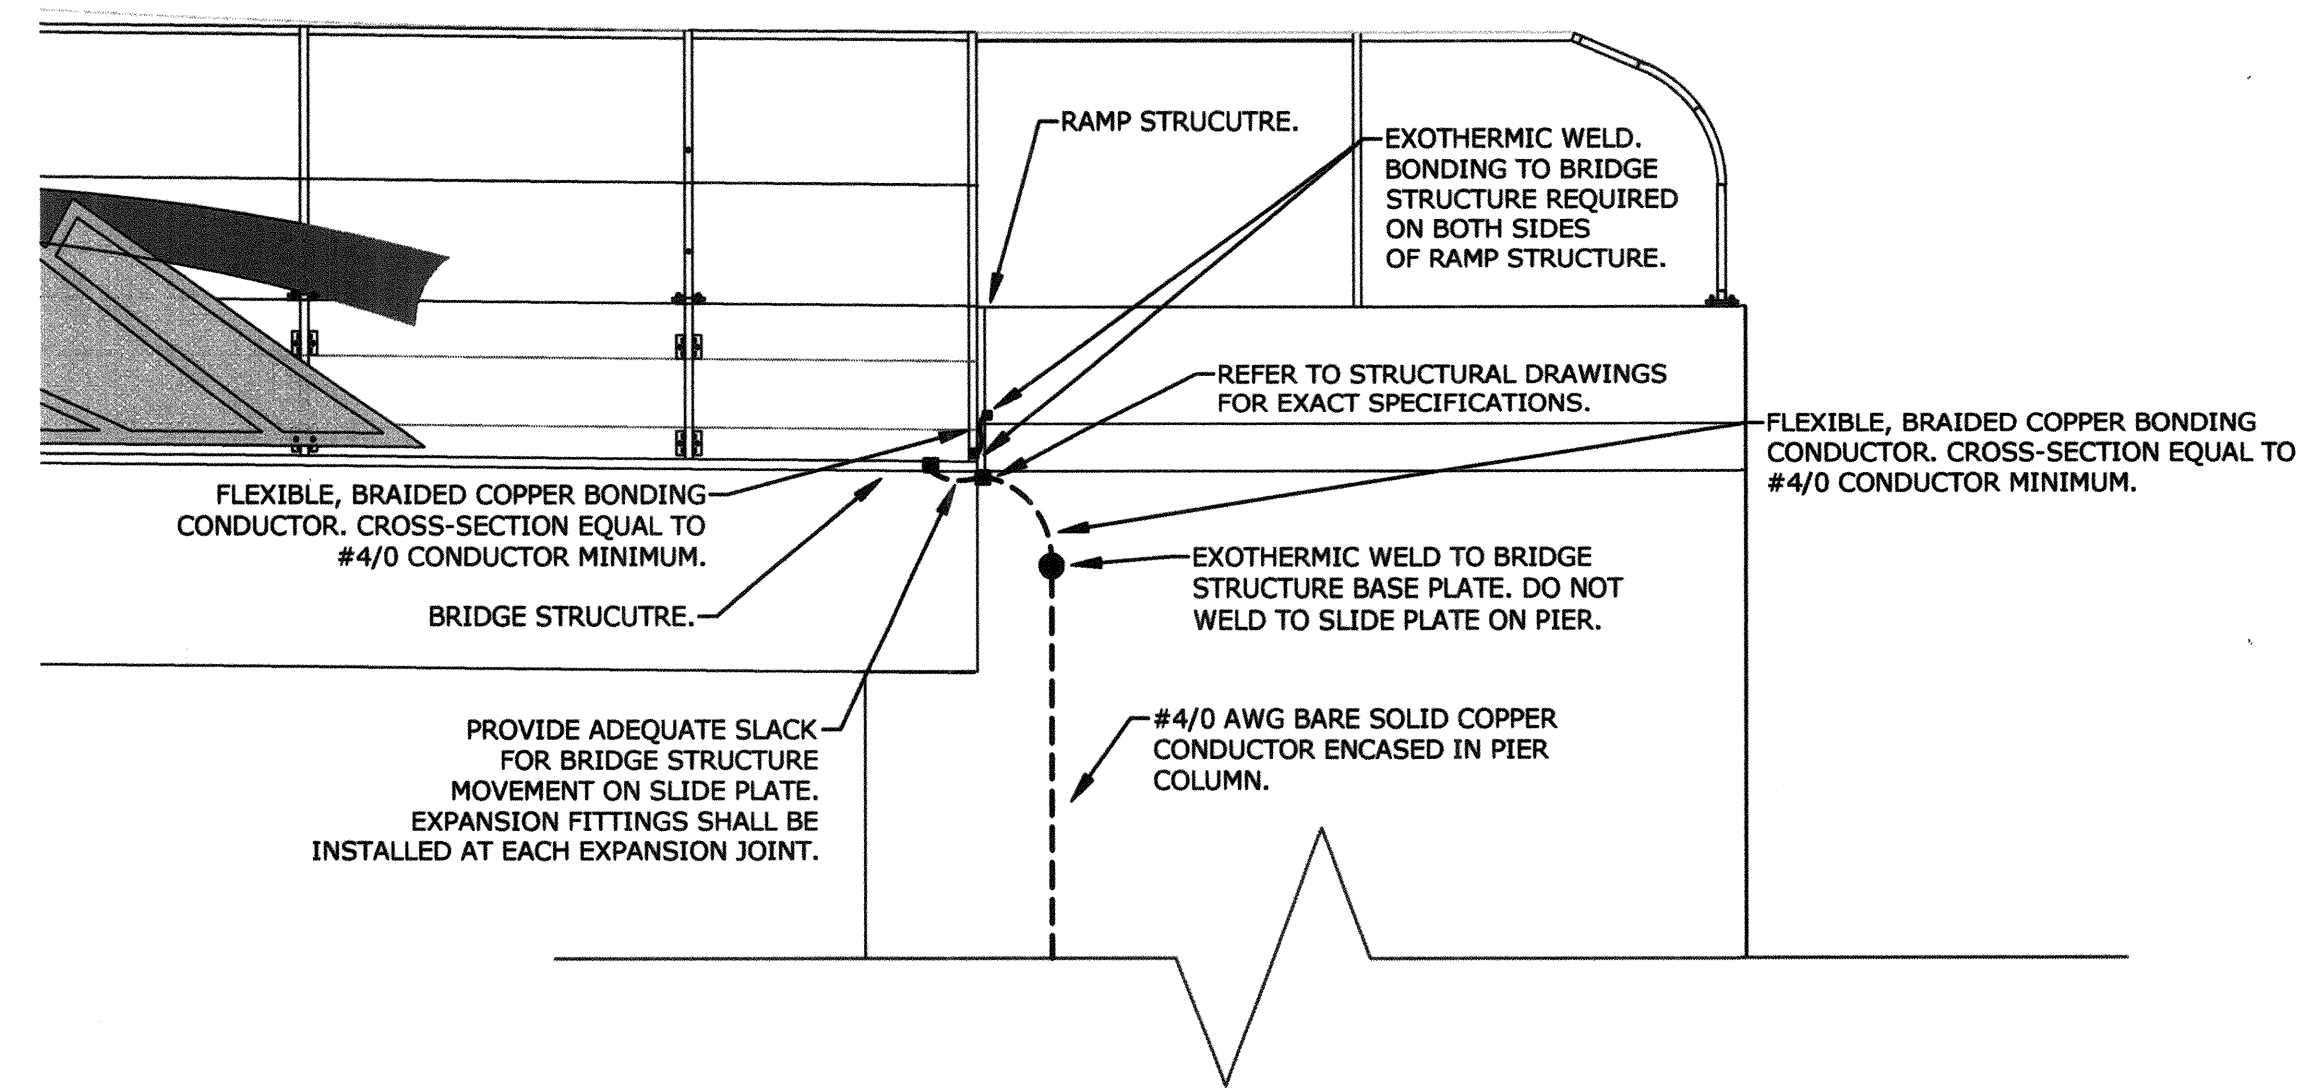

B
E0.04
NTS
BRIDGE TO RAMP BONDING DETAIL

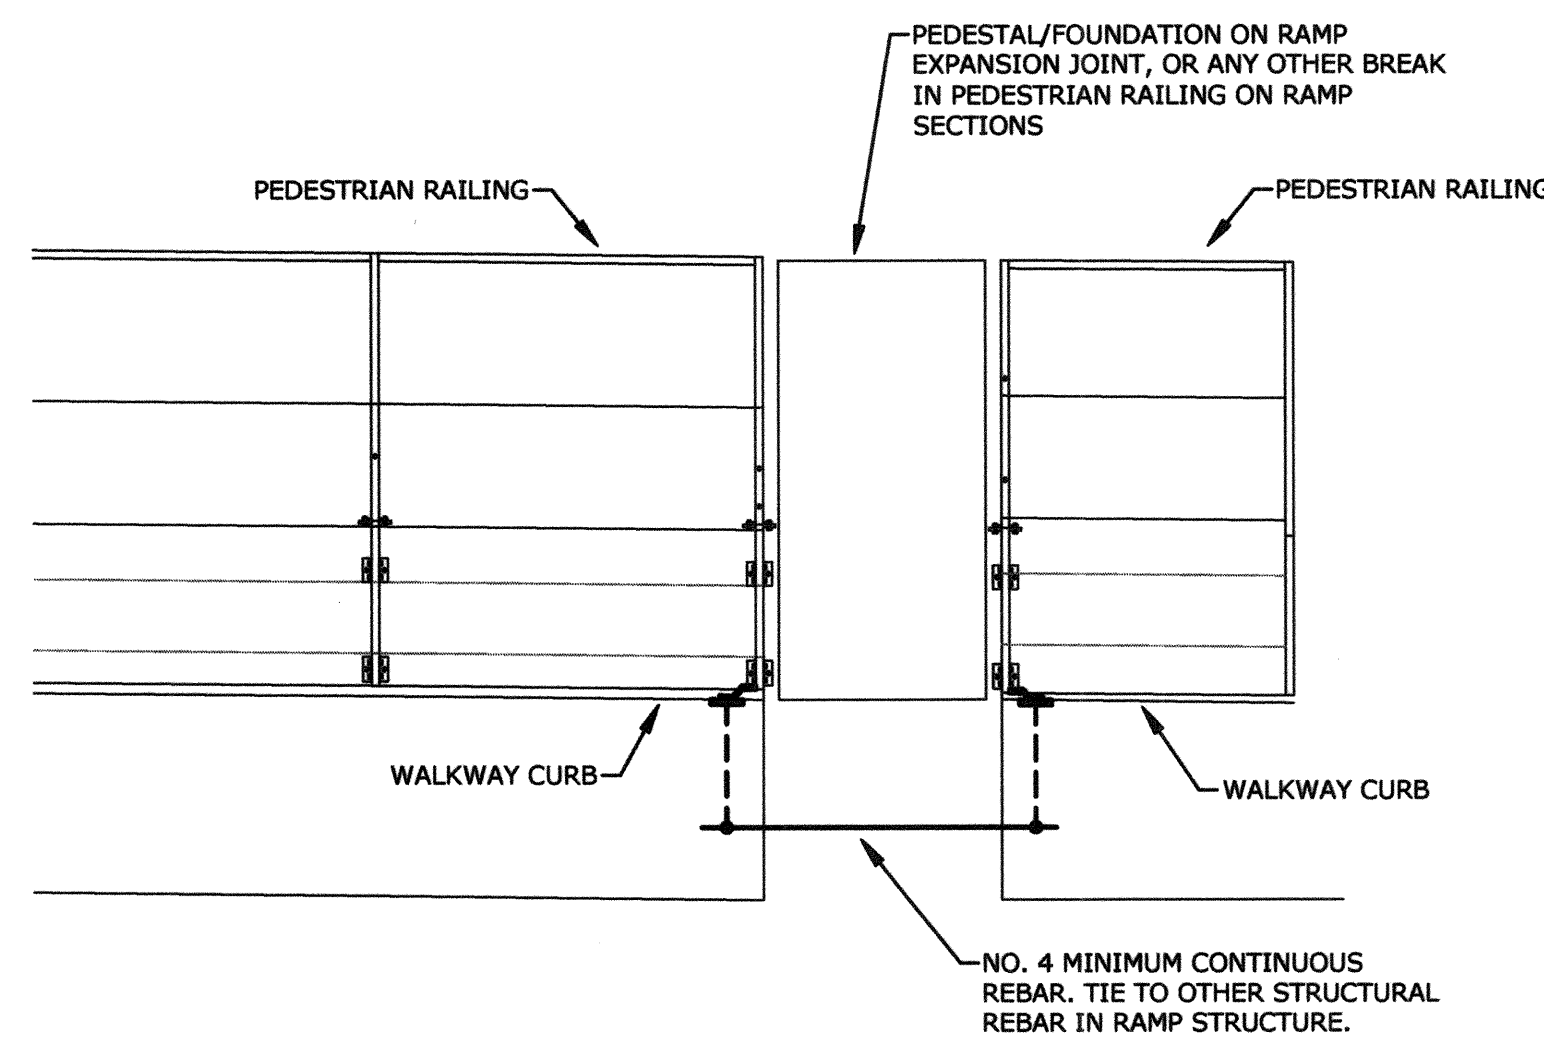

C
E0.04
NTS
PEDESTRIAN RAIL BONDING

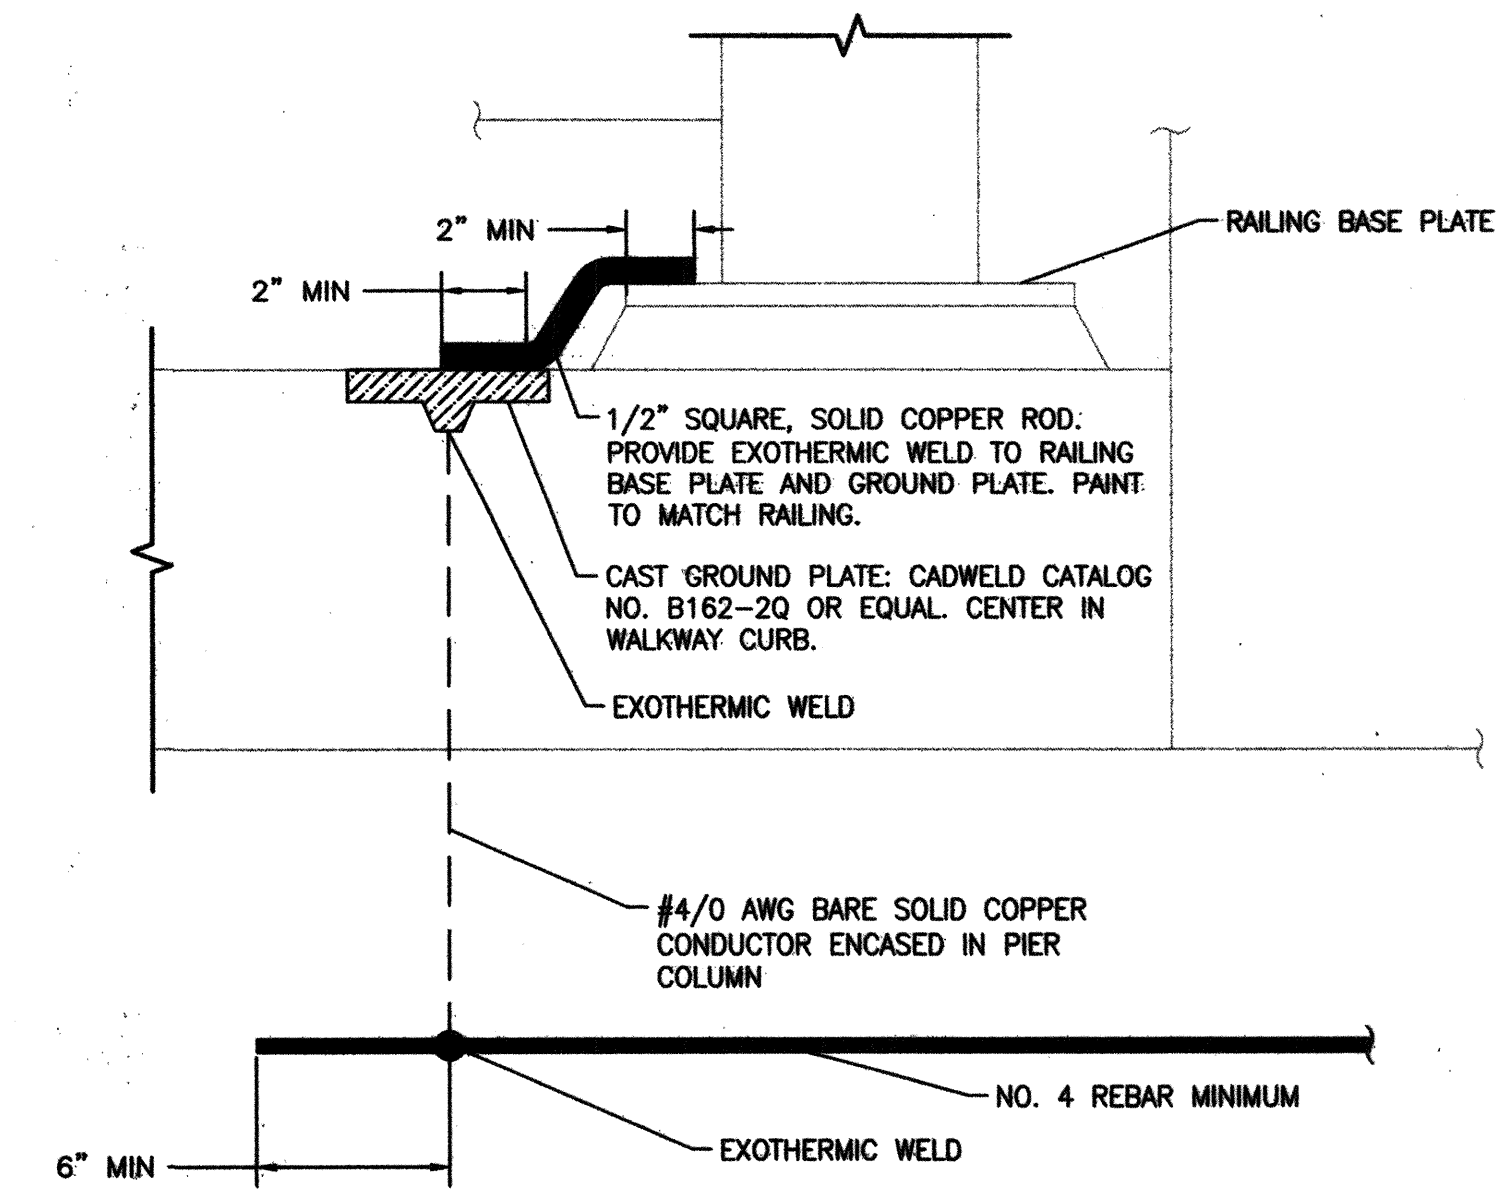

D
E0.04
NTS
PEDESTRIAN RAIL BONDING DETAIL

PREPARED BY: DEPARTMENT OF PUBLIC WORKS CAPITAL PROJECT MGMT		POGGEMEYER DESIGN GROUP 6900 Smoke Ranch Road - Suite 110 Las Vegas, Nevada 89128 - (702) 255-8100	
PREPARED FOR: CITY OF LAS VEGAS	BID# 17-48938 H# 48938	DESIGNED BY: PE DRAWN BY: MSA CHECKED BY: PE	DATE: JANUARY 2018 SUBMITTAL STAGE 100% FINAL
CIMARRON PEDESTRIAN BRIDGE AT SUMMERLIN PARKWAY		SHEET ELECTRICAL DETAILS	
TITLE		SHEET	
PROFESSIONAL ENGINEER - STATE OF NEVADA D. M. MURPHY E.L. 10078 M. 10379		JAN 12 2018	
msa ENGINEERING CONSULTANTS 370 E Windmill Lane, Suite 100 Las Vegas, NV 89123 702.896.1100 msa@msa.com		E0.04 82 OF 86 DRAWING NO. 676-22	
FEDERAL PROJECT NUMBER: CM-0003(180)		MSA#L16032	