
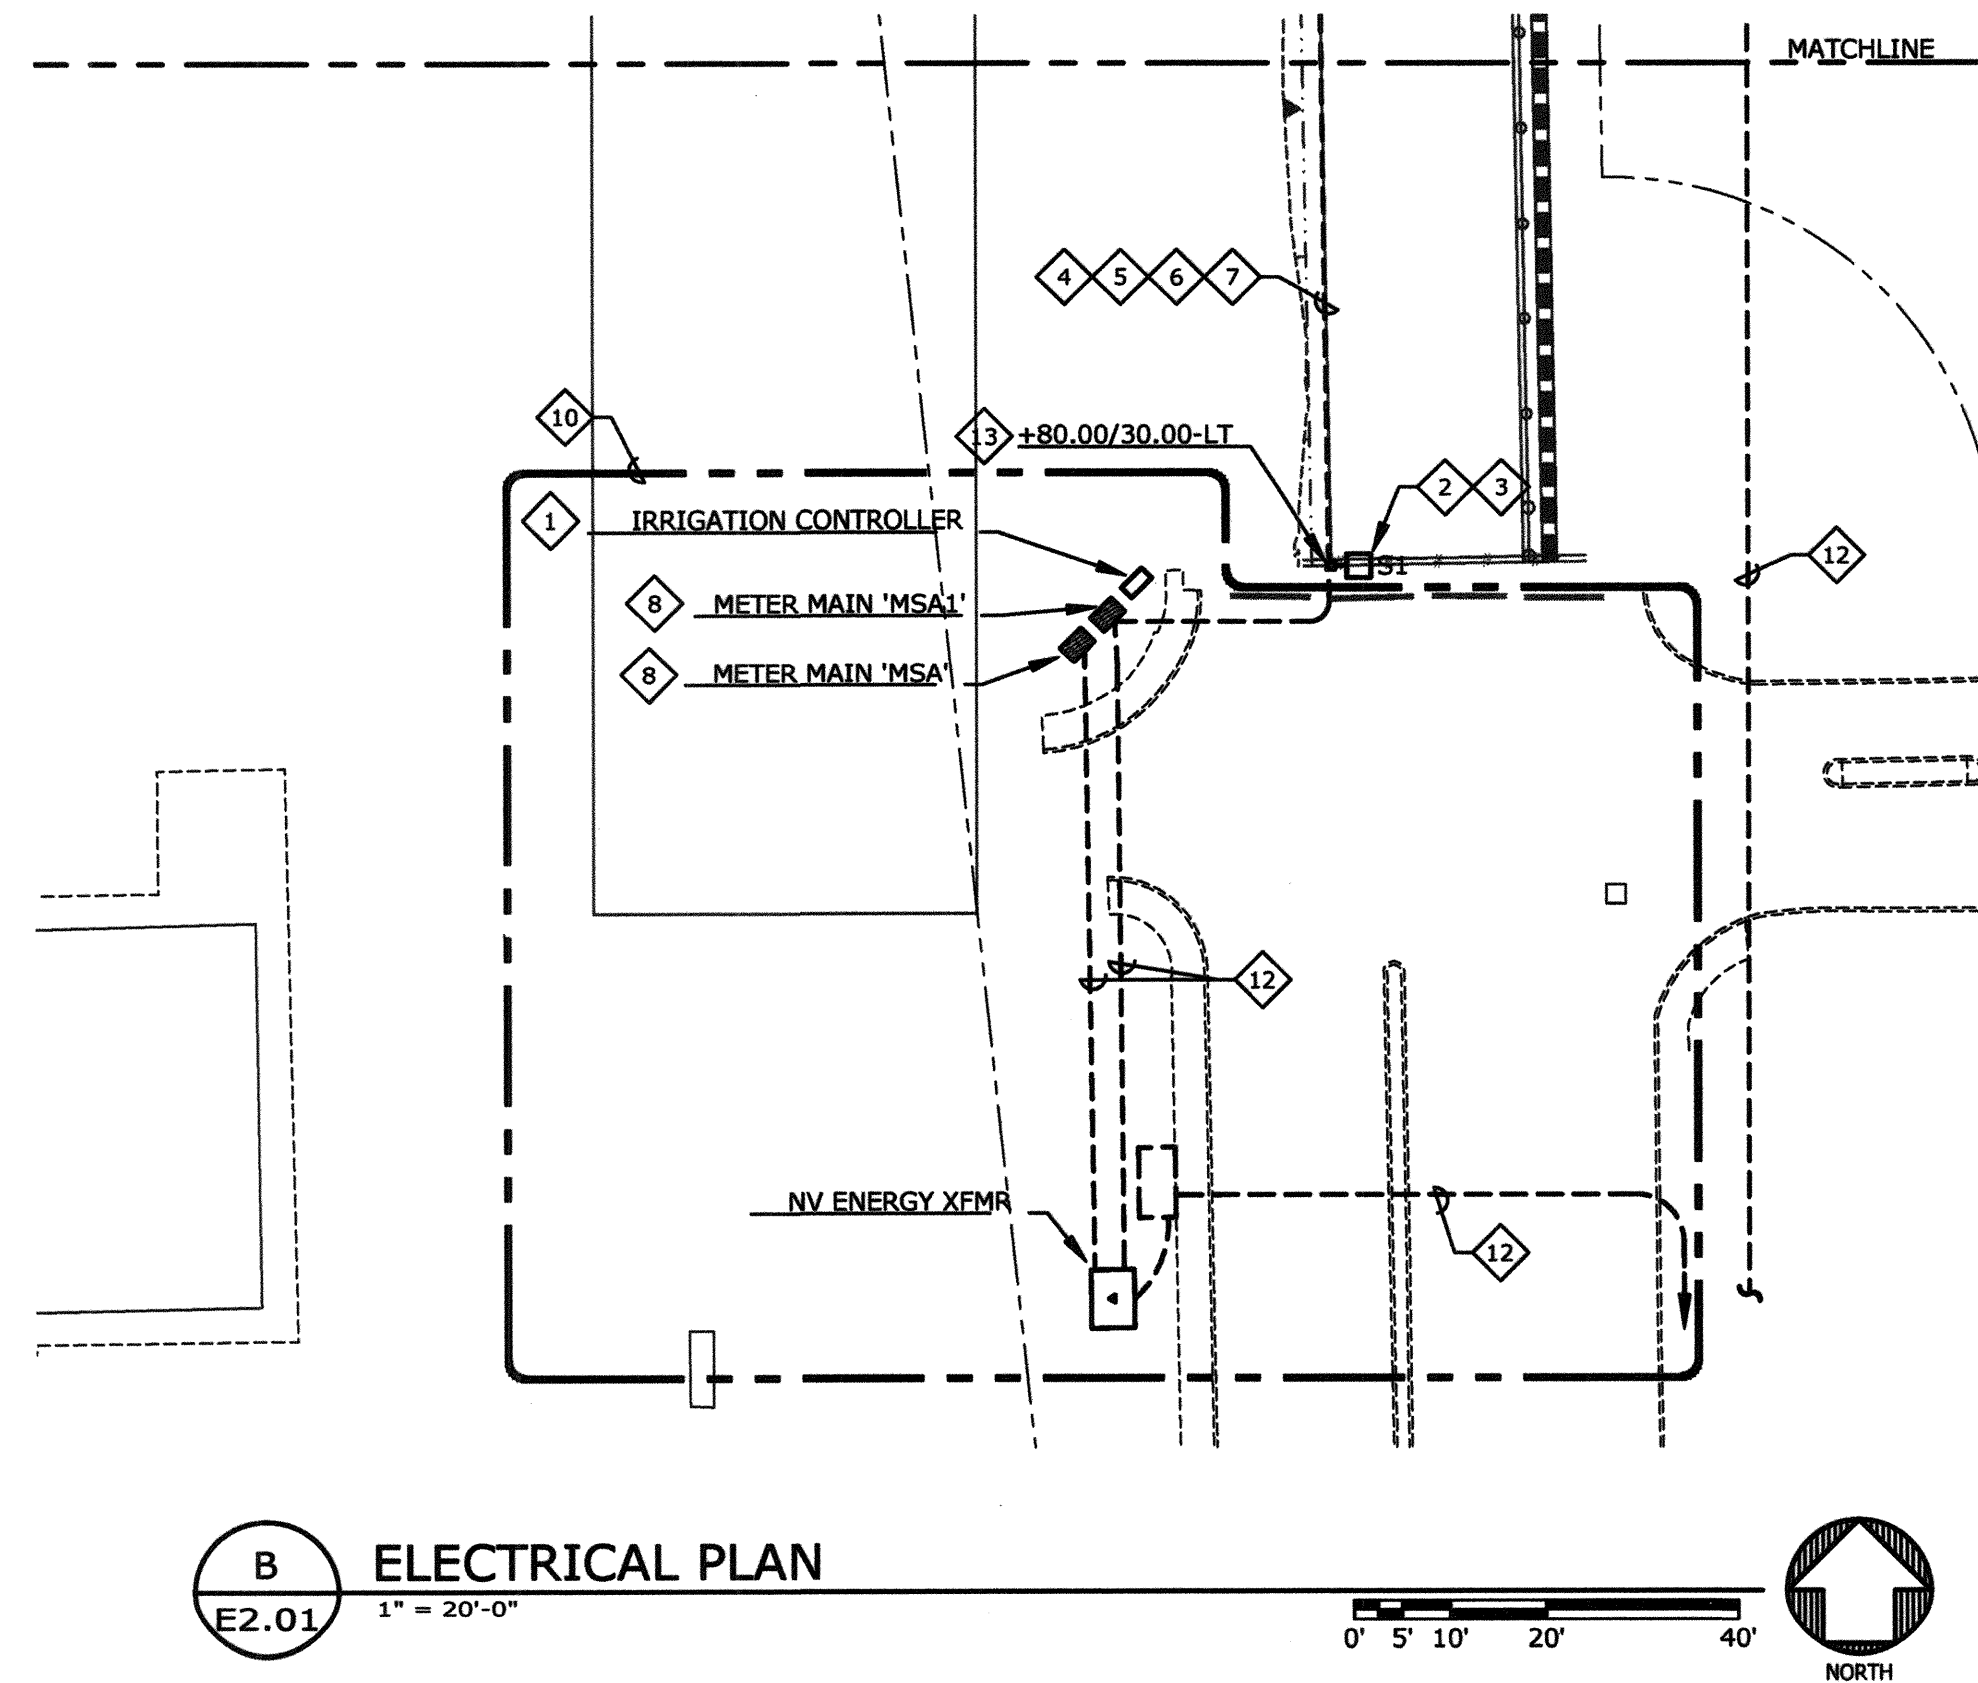
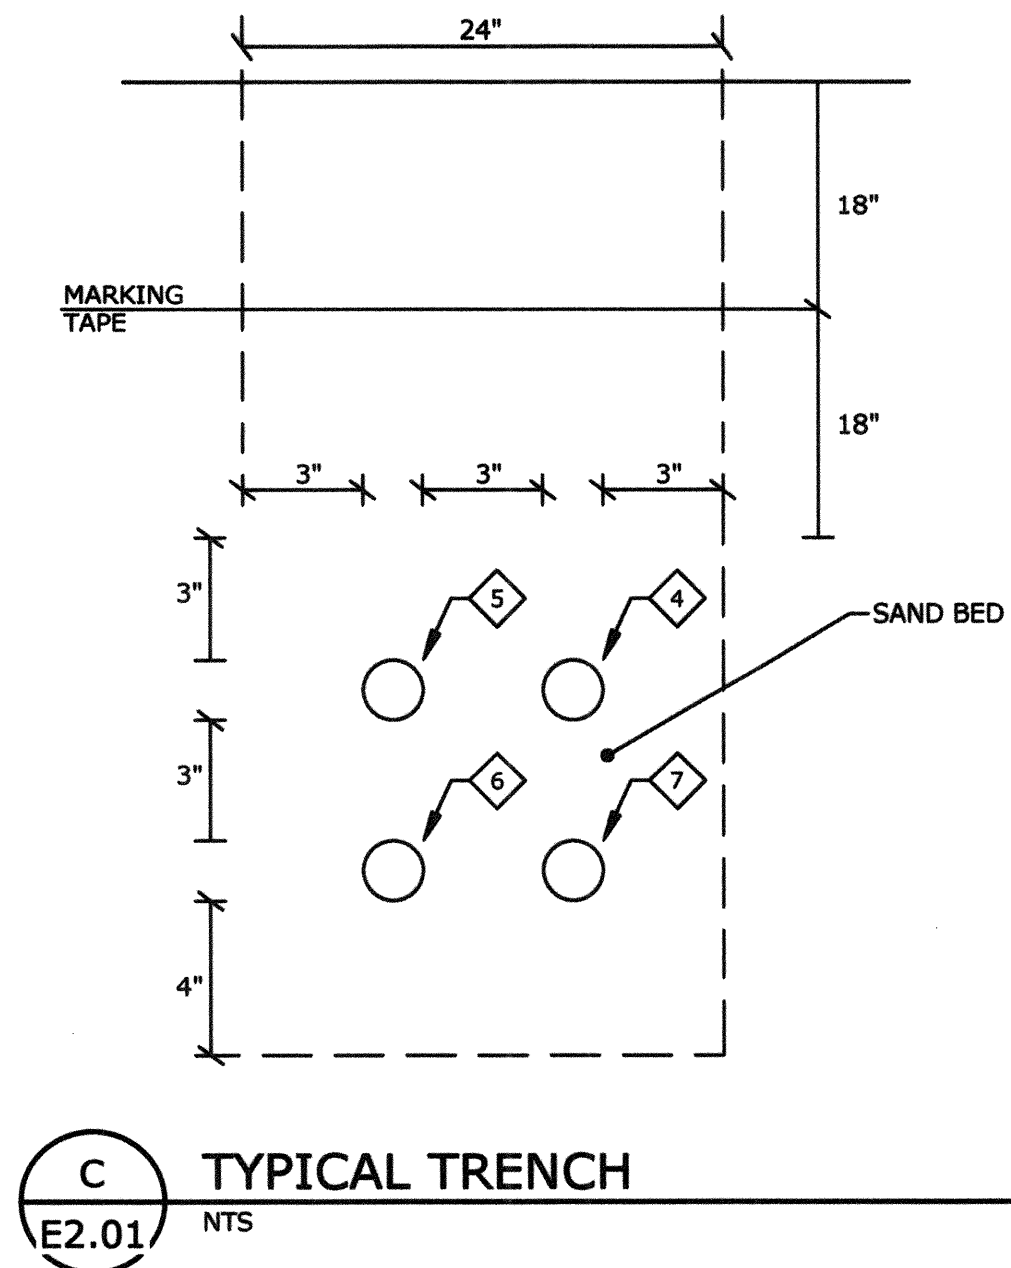


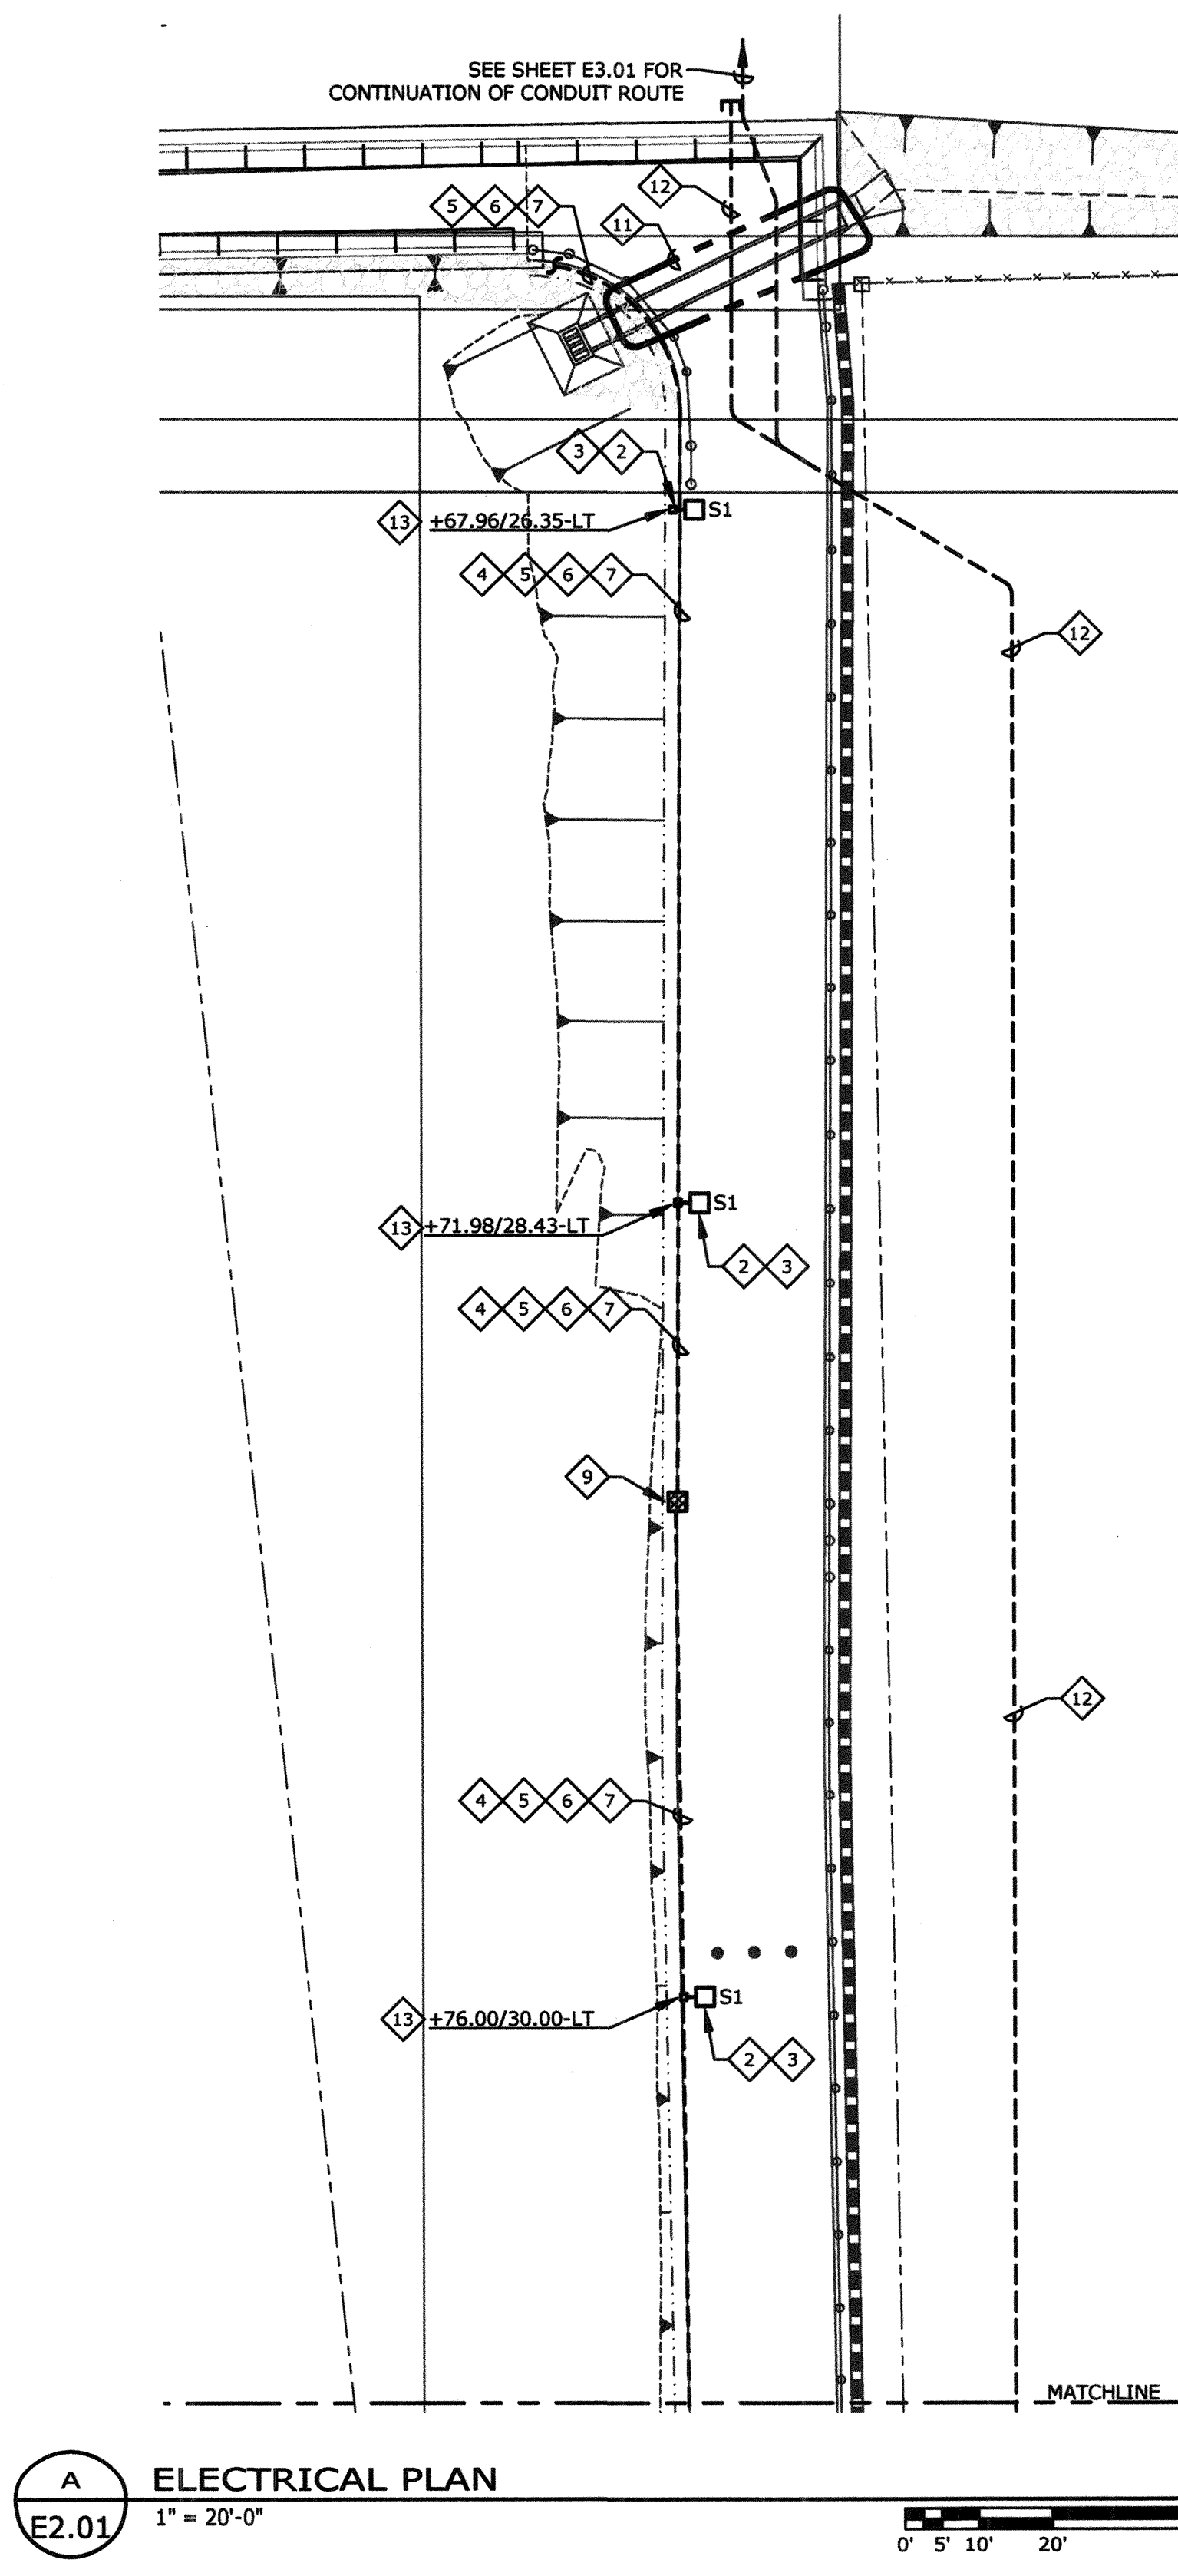

GENERAL NOTES:

- ALL CIRCUITS SHALL CARRY A GREEN GROUND CONDUCTOR.
- MULTI-WIRE BRANCH CIRCUITS SHALL BE INSTALLED TO COMPLY WITH NEC 210.4(B) AND REFERENCED SECTIONS FOR DISCONNECTING MEANS.
- CONTRACTOR SHALL BE RESPONSIBLE FOR ALL CUTTING, PATCHING AND PAINTING ASSOCIATED WITH THE ELECTRICAL WORK.

SHEET NOTES:

- PROPOSED LOCATION OF IRRIGATION CONTROLLER - COORDINATE EXACT LOCATION WITH LANDSCAPE ARCHITECT PRIOR TO ROUGH-IN. PROVIDE CONNECTION(S) AS REQUIRED PER MANUFACTURER'S SHOP DRAWINGS.
- AREA LUMINAIRE, TYPE S1 UNLESS INDICATED OTHERWISE. REFER TO CIVIL DRAWINGS FOR STATION LOCATION TO EACH LIGHT FIXTURE.
- INSTALL 14'-6" POLE, (SEE DETAIL B/E0.03).
- 2"C, 2#4, 1#8 GND., TRAIL LIGHTING CONDUIT FEEDING TRAIL LIGHT SHALL PASS THROUGH TRAIL LIGHT FOUNDATION.
- 2" CONDUIT ONLY.
- 2"C, 6#4, 1#8 GND - BRIDGE/RAMP/FEATURE LIGHT.
- 2" CONDUIT ONLY, BYPASS LIGHT POLE FOUNDATION - BRIDGE.
- 200A, 120/240V, 3W, 1~, SERVICE PEDESTAL - REFER TO DIAGRAM D ON SHEET E0.03 FOR ADDITIONAL INFORMATION.
- NO. 3 1/2 PULLBOX (USDCCA DWG. NOS. 326, 705 AND 711). PROVIDE (1) PULL BOX FOR ACTIVE CONDUIT AND (1) PULL BOX FOR SPARE CONDUIT.
- SEE NV ENERGY DRAWINGS FOR ADDITIONAL INFORMATION AND FULL SCOPE OF WORK. CONDUIT ROUTING SHALL BE BELOW THE 'STORM DRAIN' - CONFIRM ROUTING AND DEPTH OF CONDUIT WITH CIVIL ENGINEER AND NV ENERGY.
- NEW ELECTRICAL CONDUIT IN THIS AREA TO BE ROUTED UNDERNEATH PROPOSED STORM DRAIN.
- NVE CONDUIT LOCATION FOR REFERENCE, SEE NV ENERGY DRAWINGS INCLUDED IN THE DRAWING PACKAGE FOR EXACT LOCATIONS AND REQUIREMENTS.
- STATION NUMBER PER CIVIL DRAWINGS - CONTRACTOR SHALL RE-CONFIRM STATION NUMBER WITH CIVIL ENGINEER PRIOR TO STAKING EACH LIGHT POLE AND BRIDGE/RAMP LIGHT FIXTURE.

PREPARED BY DEPARTMENT OF PUBLIC WORKS CAPITAL PROJECT MGMT		DESIGNED BY: PE H# 4868		DATE: JANUARY 2018		SUBMITTAL STAGE 100% FINAL	
CITY OF LAS VEGAS		DESIGNED BY: PE H# 4868		DATE: JANUARY 2018		SUBMITTAL STAGE 100% FINAL	
CIMARRON PEDESTRIAN BRIDGE AT SUMMERLIN PARKWAY		DESIGNED BY: PE H# 4868		DATE: JANUARY 2018		SUBMITTAL STAGE 100% FINAL	
ELECTRICAL PLAN		DESIGNED BY: PE H# 4868		DATE: JANUARY 2018		SUBMITTAL STAGE 100% FINAL	
SHEET E2.01		DESIGNED BY: PE H# 4868		DATE: JANUARY 2018		SUBMITTAL STAGE 100% FINAL	
85 OF 86		DESIGNED BY: PE H# 4868		DATE: JANUARY 2018		SUBMITTAL STAGE 100% FINAL	
DRAWING NO. 676-22		DESIGNED BY: PE H# 4868		DATE: JANUARY 2018		SUBMITTAL STAGE 100% FINAL	

msa.
ENGINEERING CONSULTANTS
370 E Windmill Lane, Suite 100
Las Vegas, NV 89123
702.896.1100
msa-inc.com
MSA#L16032

FEDERAL PROJECT NUMBER: CM-0003(180)