


THIS DRAWING OR ORIGINAL
DRAWING EQUALS ONE INCH


NOTE:
FOR CHAIN LINK FENCE DETAIL
SEE GENERAL SITE "G" DRAWINGS

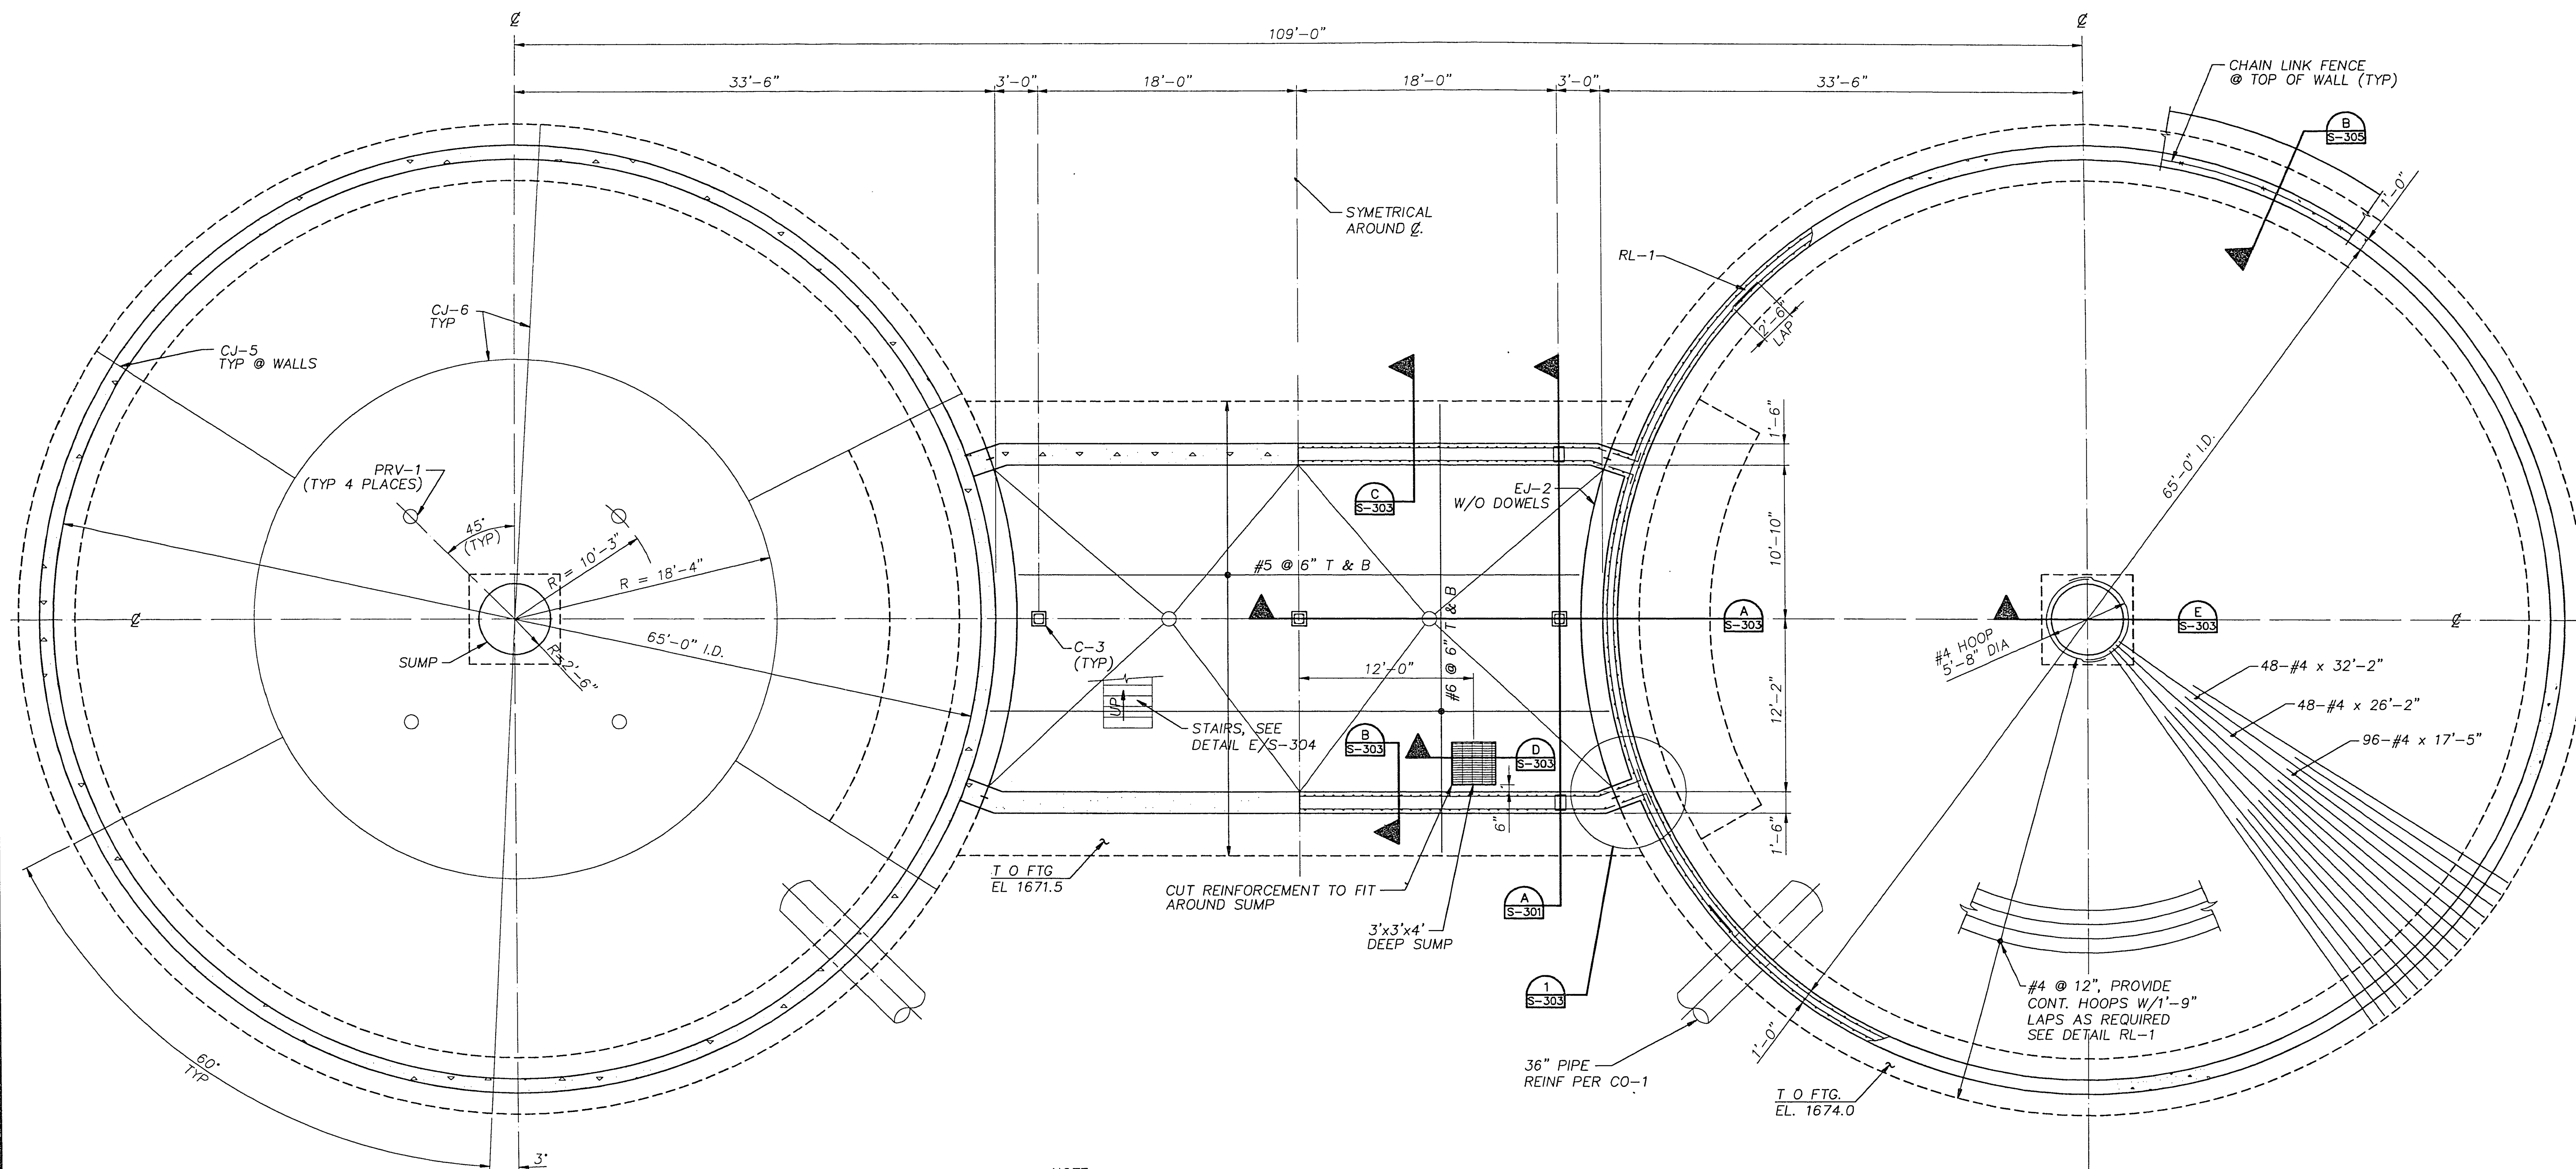

NOTE:
IT IS THE CONTRACTORS RESPONSIBILITY TO COORDINATE
THE STRUCTURAL DRAWINGS WITH ALL OTHER CONTRACT
DOCUMENTS. STRUCTURAL DRAWINGS DO NOT ATTEMPT
TO SHOW ALL MECHANICAL AND ELECTRICAL PENETRATIONS
AND ROUTING.


FOUNDATION PLAN

3/16"=1'-0"

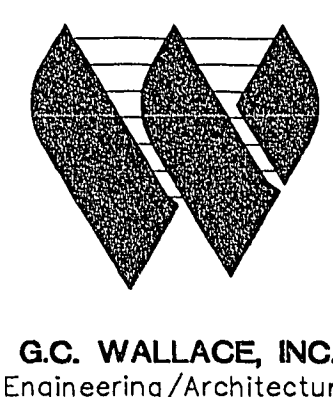

3	CORRECTED ACCORDING TO CONSTRUCTION RECORDS	7/1/93	LKE	EFH	ML	MJH
0	ISSUED FOR CONSTRUCTION	6/1/92	RAB	CLS	CRD	JBG
A	ISSUED FOR BIDS	1/6/92	RAB	CLS	CRD	JBG
Issue No.	Description	Date	Drawn	Checked	Reviewed	Project Mgr.

7/1/93	LKE	EFH	ML	MJH
6/1/92	RAB	CLS	CRD	JBG
1/6/92	RAB	CLS	CRD	JBG
Date	Drawn	Checked	Reviewed	Project Mgr.

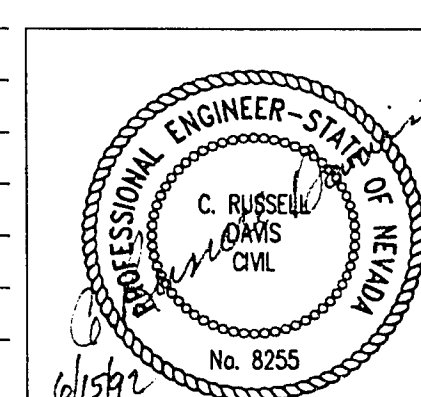

Project Manager	JEFFREY B. GLOVER
Architect	100/Process
Civil	Mechanical
Electrical	Structural
Drawn By	R. DAVIS
Checked By	R. BERGER

City of Las Vegas
Water Pollution Control Facility
Nitrification / Filtration Facilities
Contract 16
EFFLUENT FILTRATION COMPLEX

BACKWASH SURGE BASIN FOUNDATION PLAN

Date	JUNE 1992	Project No.	00120-083-141	Drawing No.	S-300	Issue	3
Scale	3/16" = 1'-0"				116 of 274		

9.1-136

311.33