

REDUCED PRESSURE DETECTOR ASSEMBLY



(RPDA) (1) 4" RPDA
THE REDUCED PRESSURE DETECTOR ASSEMBLY SHALL BE INSTALLED IN ACCORDANCE WITH THE UDACS PLATE No. 56. NO WATER SHALL BE TAKEN FROM A SERVICE REQUIRING BACKFLOW PREVENTION UNTIL THE ASSEMBLY HAS BEEN SUCCESSFULLY TESTED BY LVVWD. ANY BLOCK WALL OR OTHER FENCE MATERIAL SHALL BE DESIGNED AND CONSTRUCTED AROUND THE OUTSIDE OF THE EASEMENT(S) SO AS TO ALLOW LVVWD DIRECT ACCESS FROM THE ADJACENT RIGHT-OF-WAY. EASEMENTS SHALL BE CLEARLY MARKED OR STAKED PRIOR TO THE START OF CONSTRUCTION.

REDUCED PRESSURE PRINCIPLE ASSEMBLY

(1) 2" RPPA
APPROVED REDUCED PRESSURE PRINCIPLE ASSEMBLY(S) SHALL BE INSTALLED PER THE UDACS PLATE No. 8. NO WATER SHALL BE TAKEN FROM A SERVICE REQUIRING BACKFLOW PREVENTION UNTIL THE ASSEMBLY HAS BEEN SUCCESSFULLY TESTED BY LVVWD. ANY BLOCK WALL OR OTHER FENCE MATERIAL SHALL BE DESIGNED AND CONSTRUCTED AROUND THE OUTSIDE OF THE EASEMENT(S) SO AS TO ALLOW LVVWD DIRECT ACCESS FROM THE ADJACENT RIGHT-OF-WAY. EASEMENTS SHALL BE CLEARLY MARKED OR STAKED PRIOR TO THE START OF CONSTRUCTION.

STREETLIGHT CONSTRUCTION NOTES:

- INTERCEPT EXISTING STREETLIGHT CIRCUIT; INSTALL #3-1/2 PULLBOX, REPU. CONDUCTORS
- INSTALL 2" W/ (4) #4, (1) #8 THW WIRE (TYP.)
- INSTALL STREETLIGHT & BASE PER 303-DC & 304-DC
- TIE INTO EXISTING STREETLIGHT SYSTEM

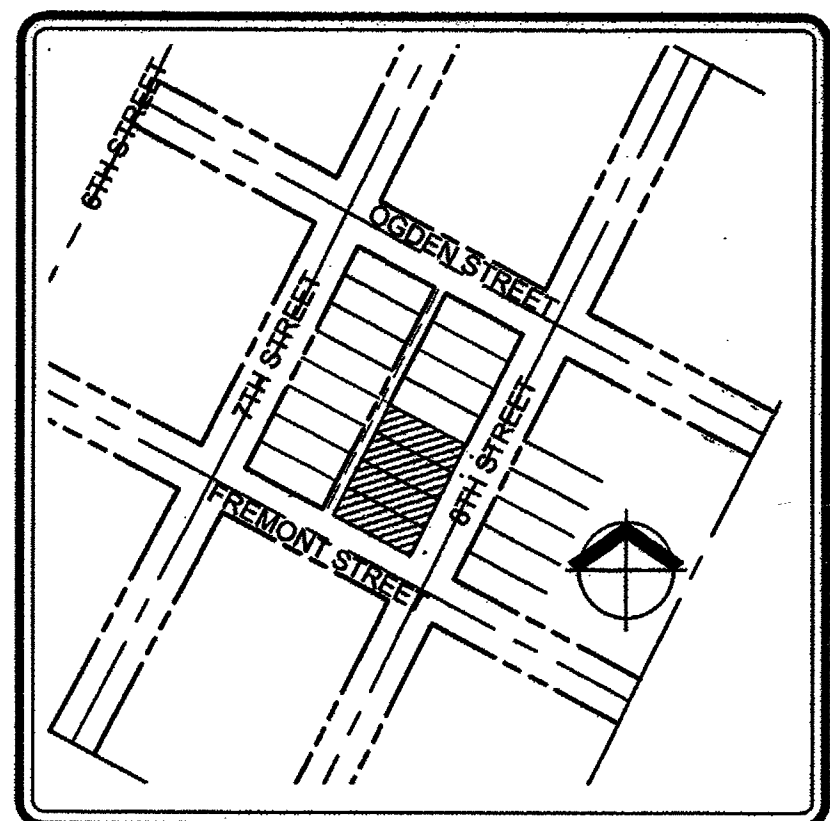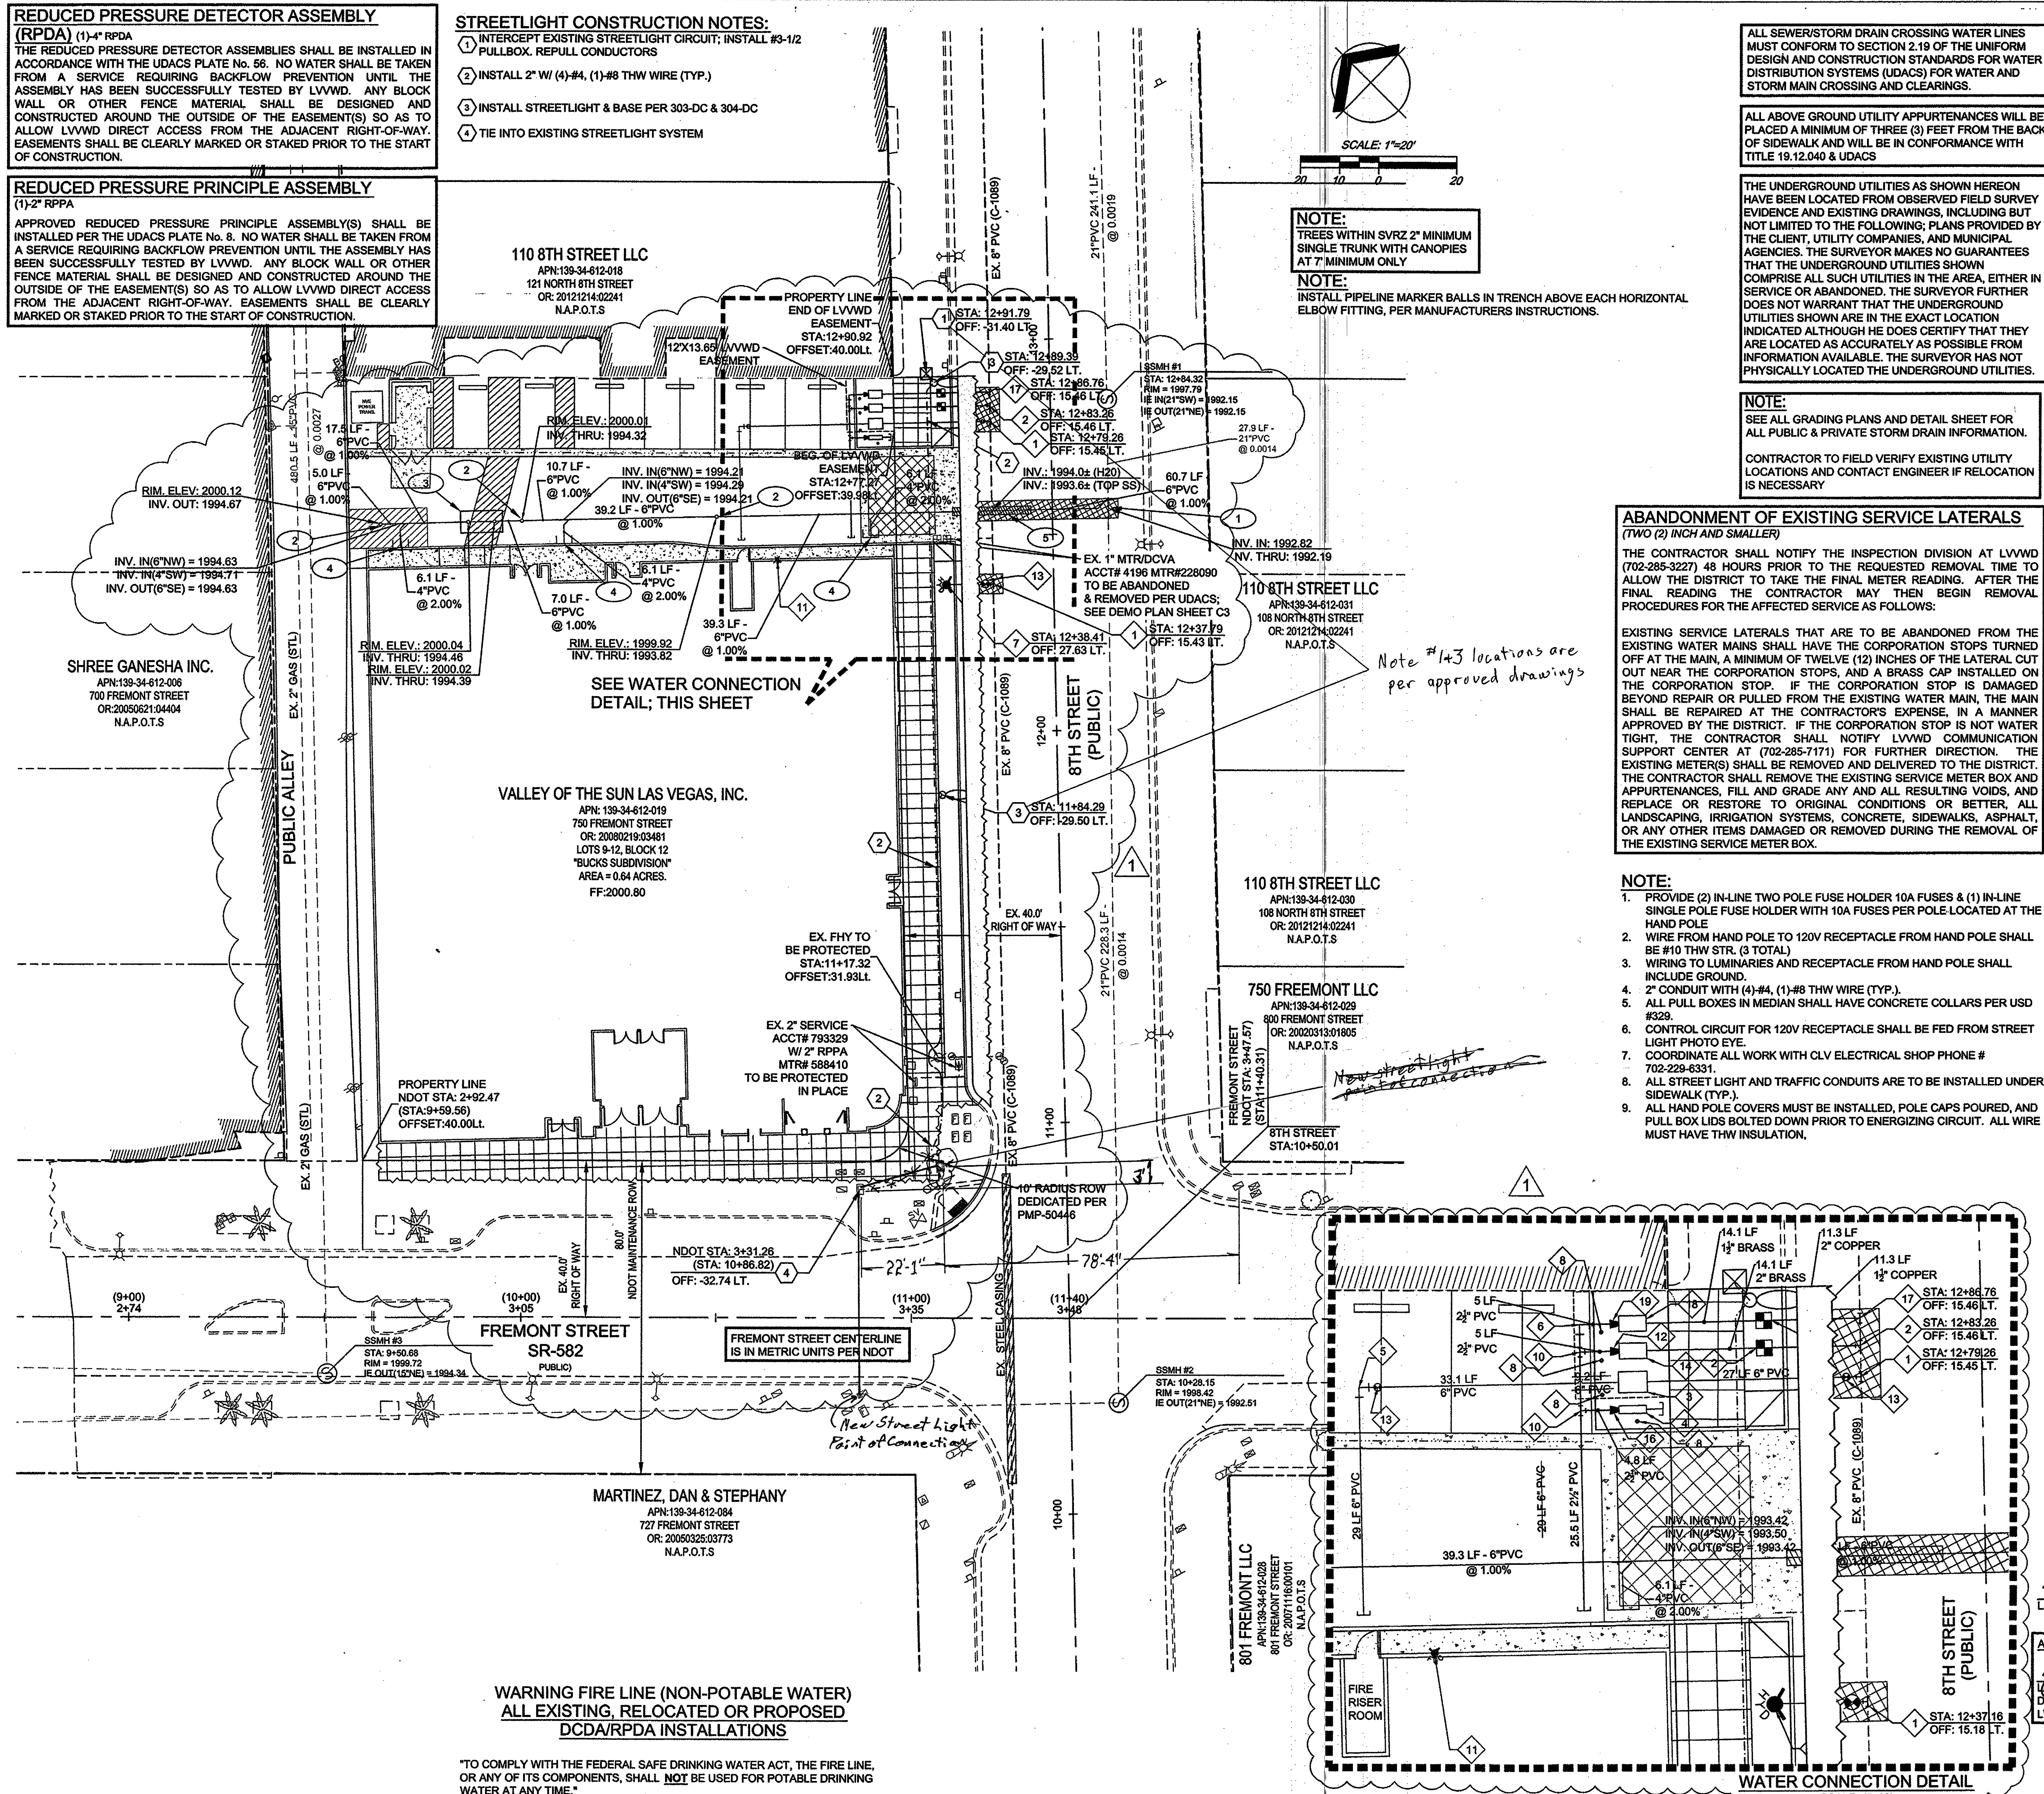

Cardno
Shaping the Future

LAS VEGAS
7115 AMIGO STREET SUITE 100, LAS VEGAS, NV 89119
TEL: (702) 990-9300 FAX: (702) 990-9300 www.cardno.com

UTILITY PLAN

VENUE OF VEGAS

VALLEY OF THE SUN LAS VEGAS, LLC

CITY OF LAS VEGAS, NEVADA

DATE: 7/24/14

DRAWN: JER

CHECKED: JER

PROJECT #: 131304010000

SHEET TITLE: UTILITY

SHEET NUMBER: 8 OF 14

C8