

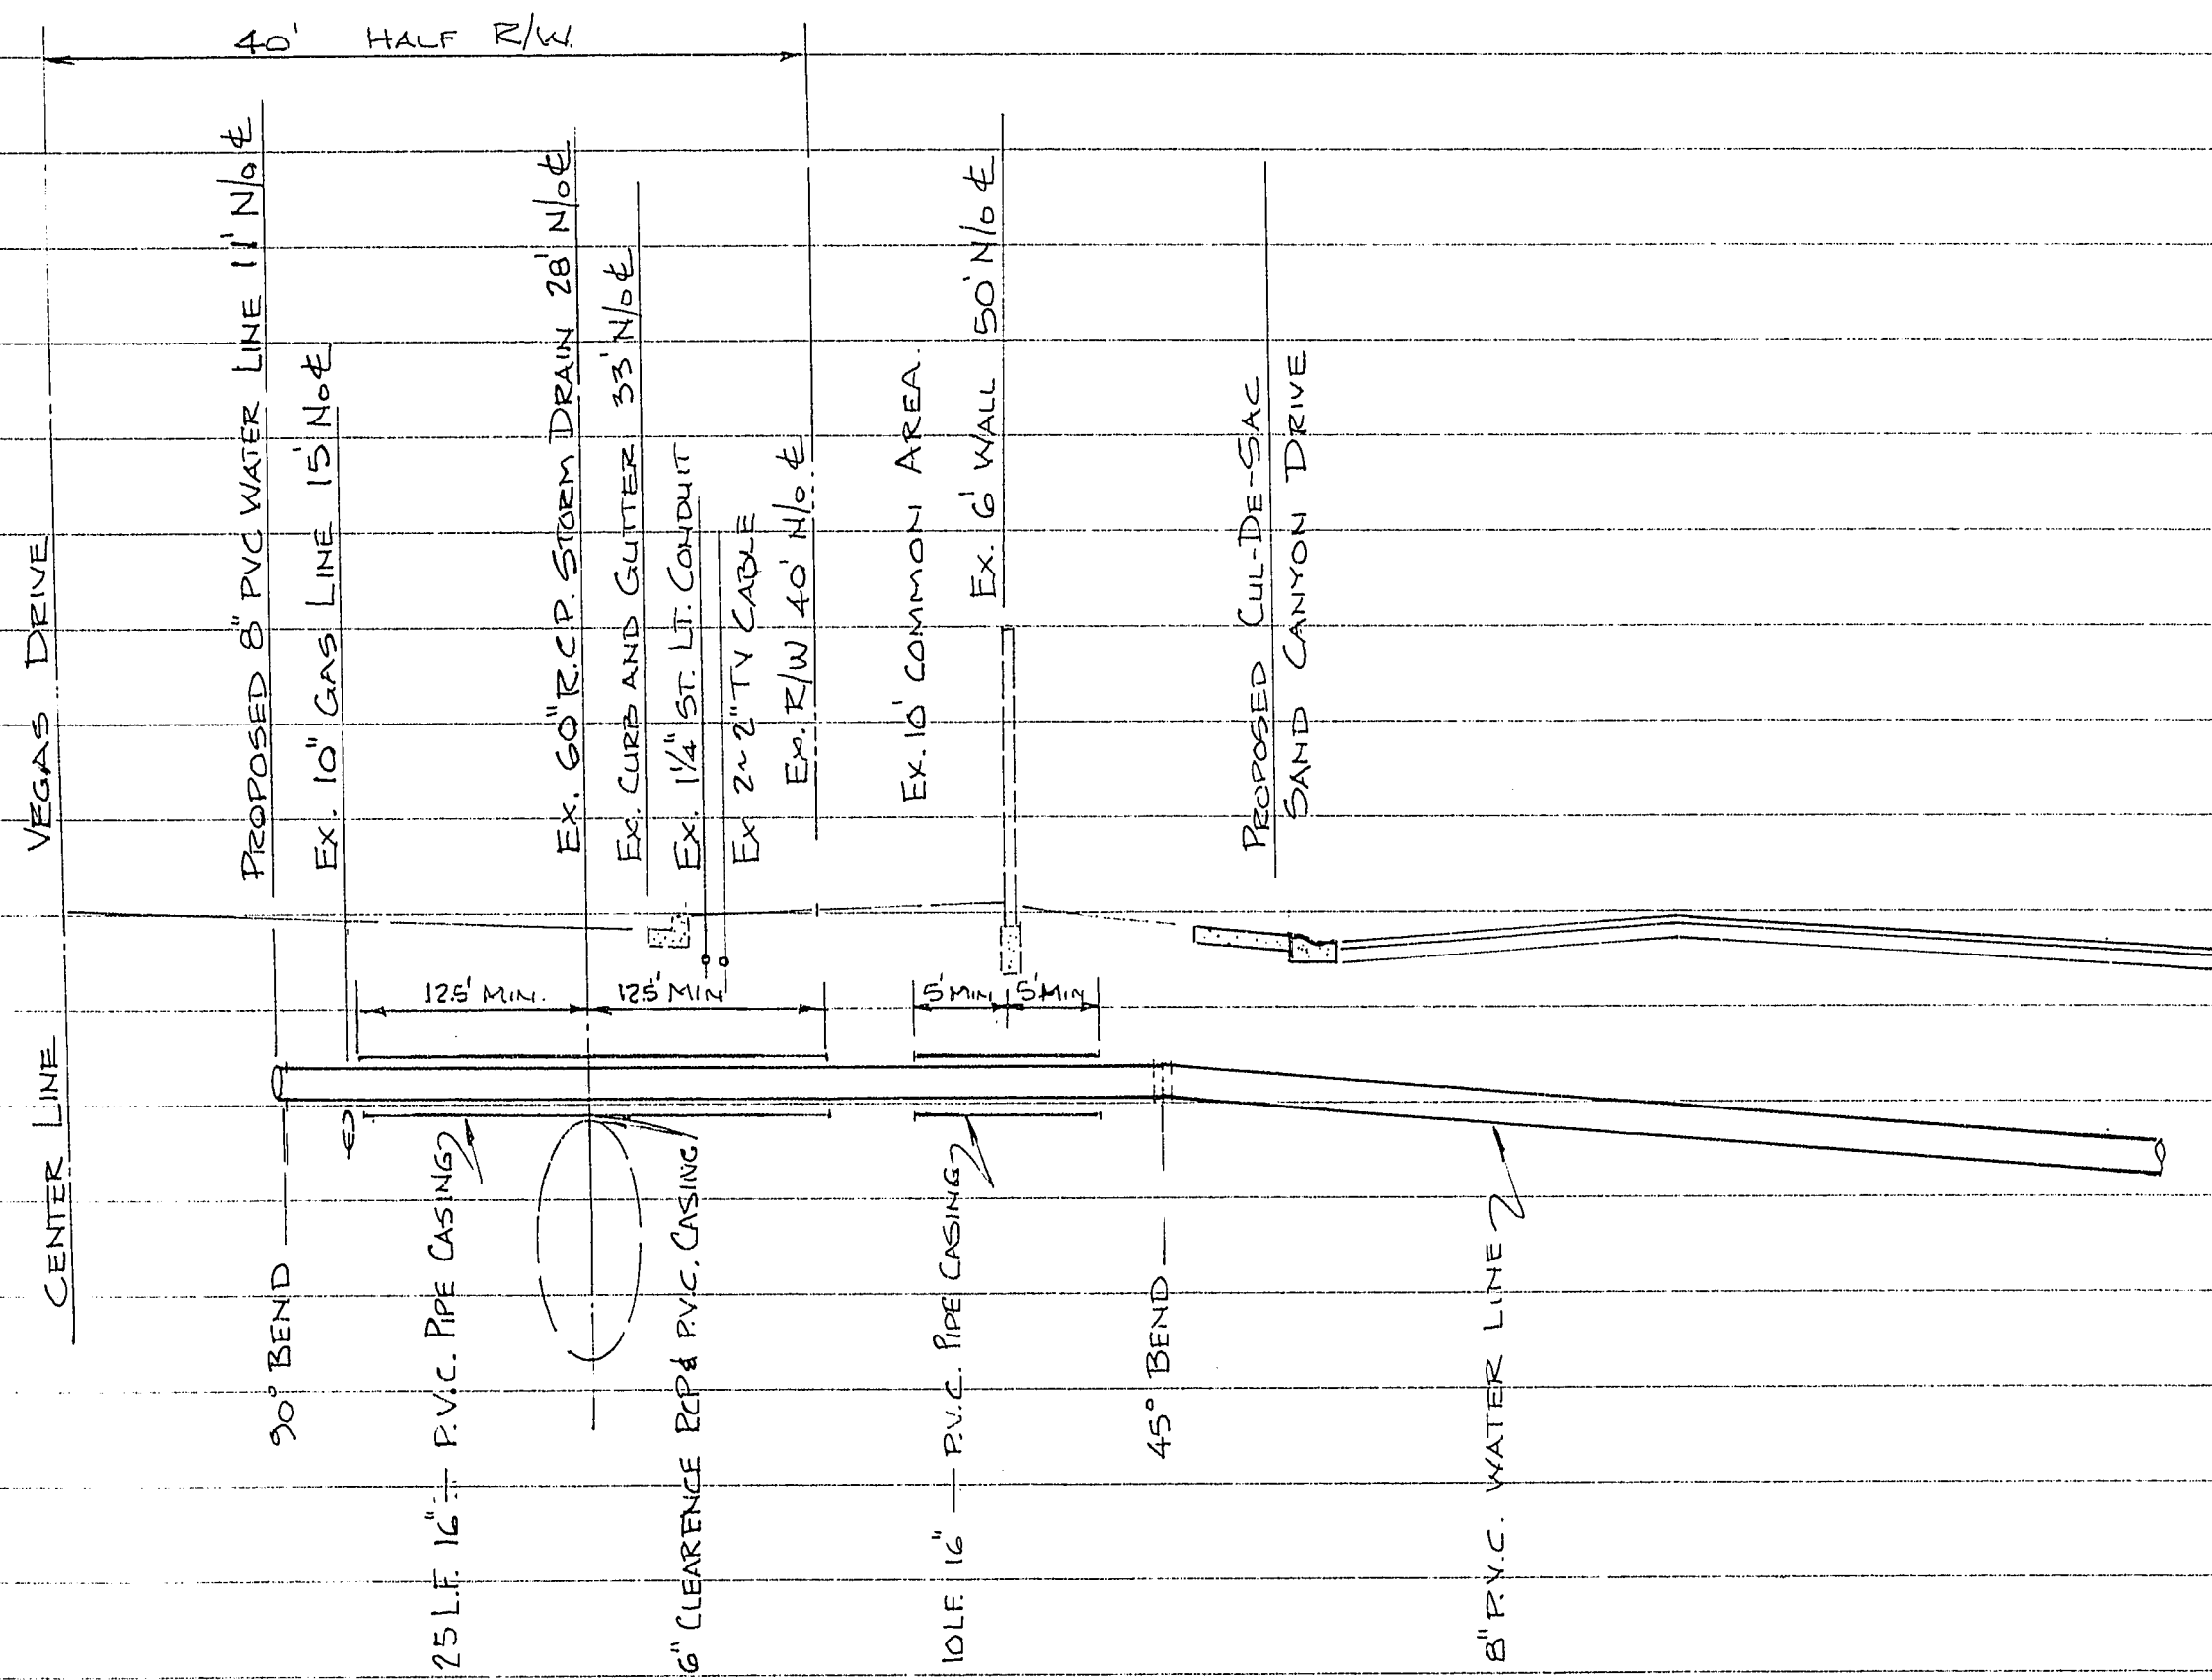


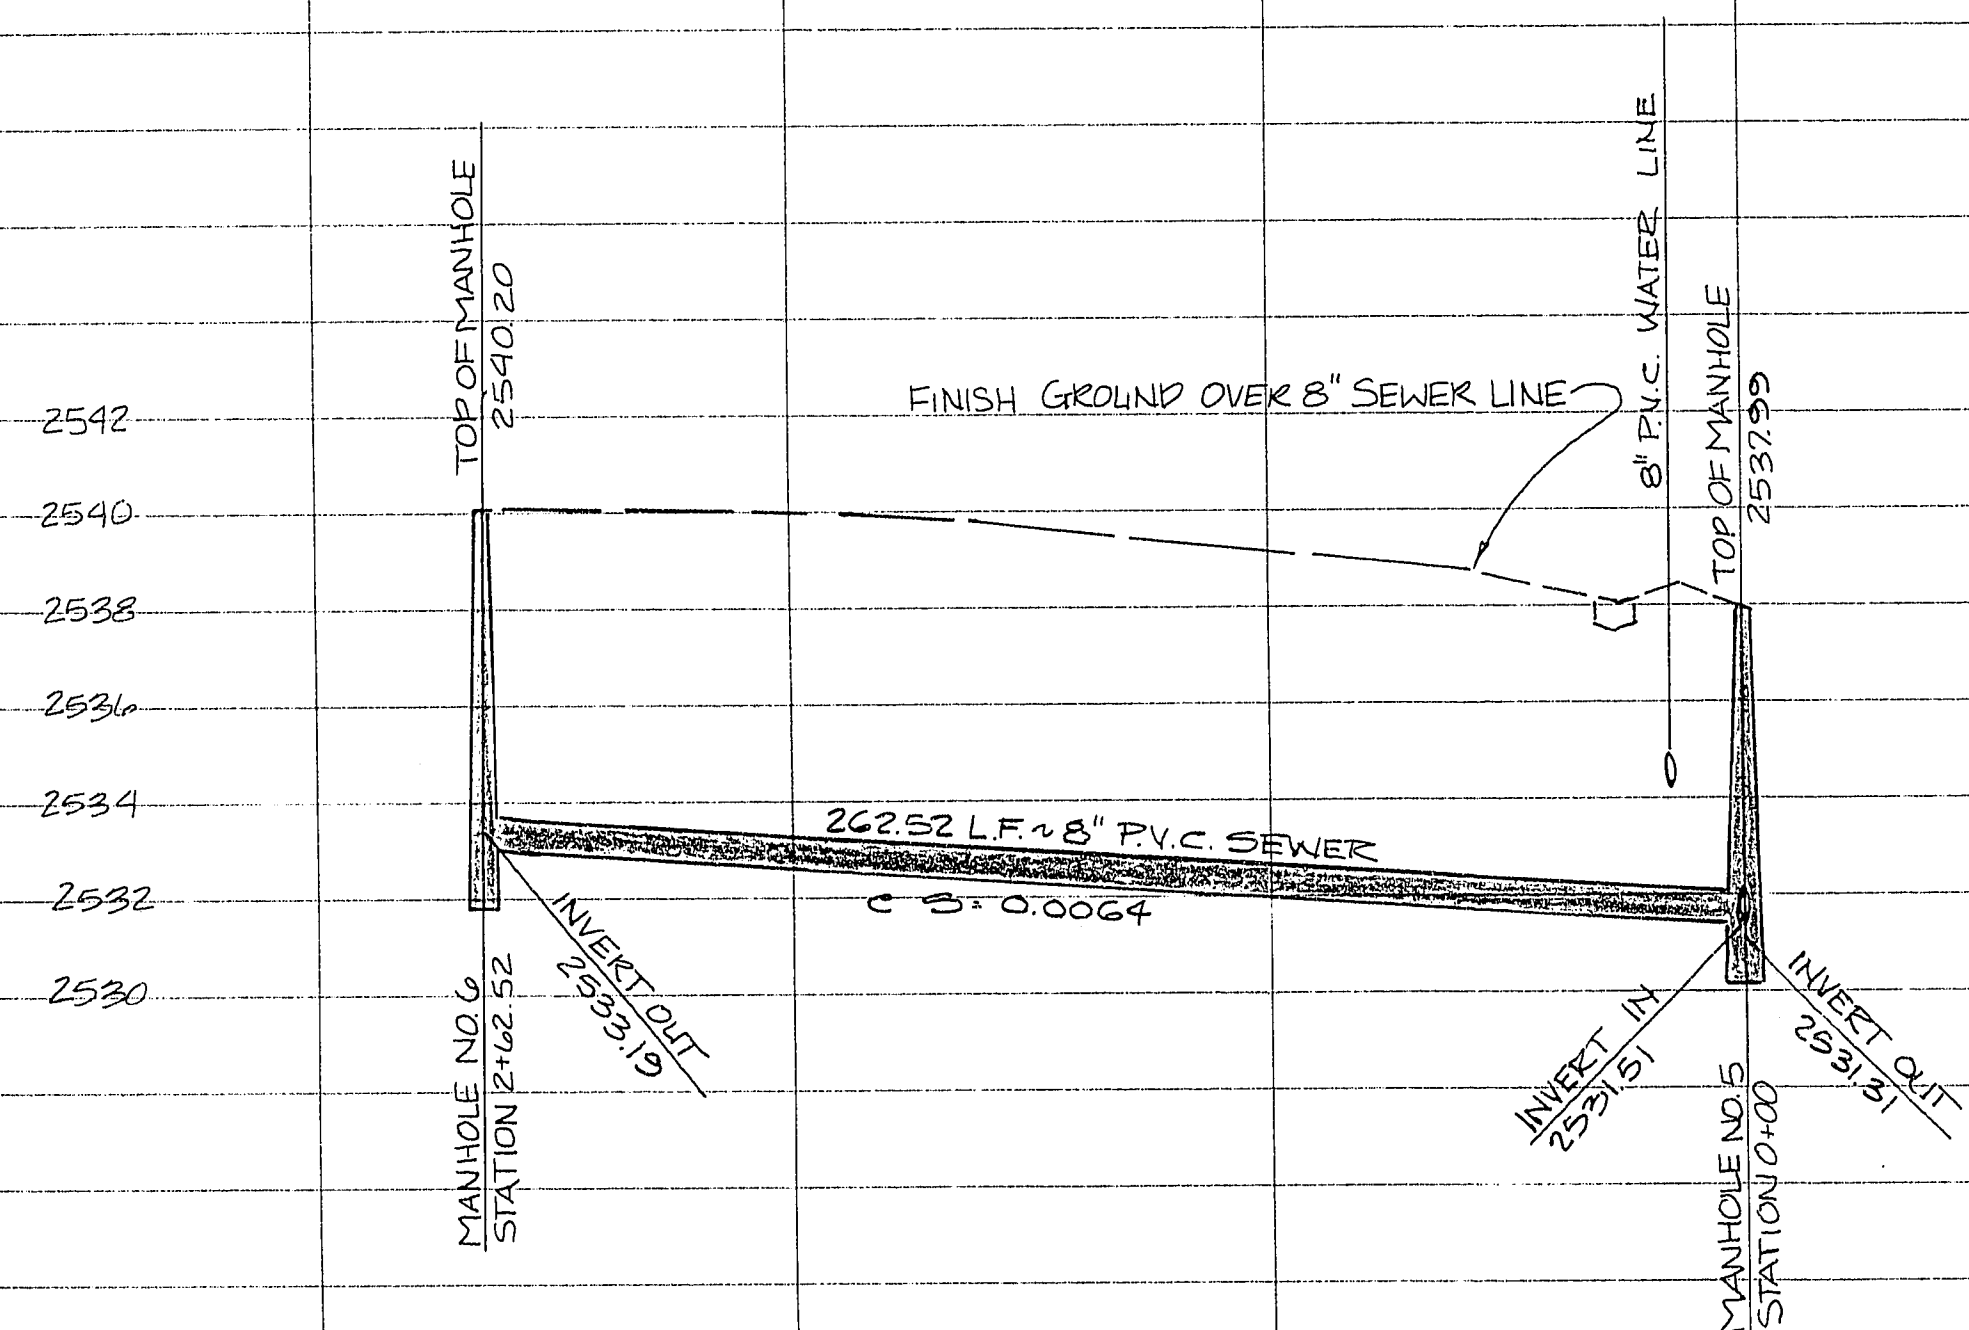


PROFILE OF 8" P. V. C. WATER LINE
AND 16" I.D. P. V. C. CASING IN
VEGAS DRIVE

SCALE HORIZ. 1" = 10'
VERT. 1" = 4'

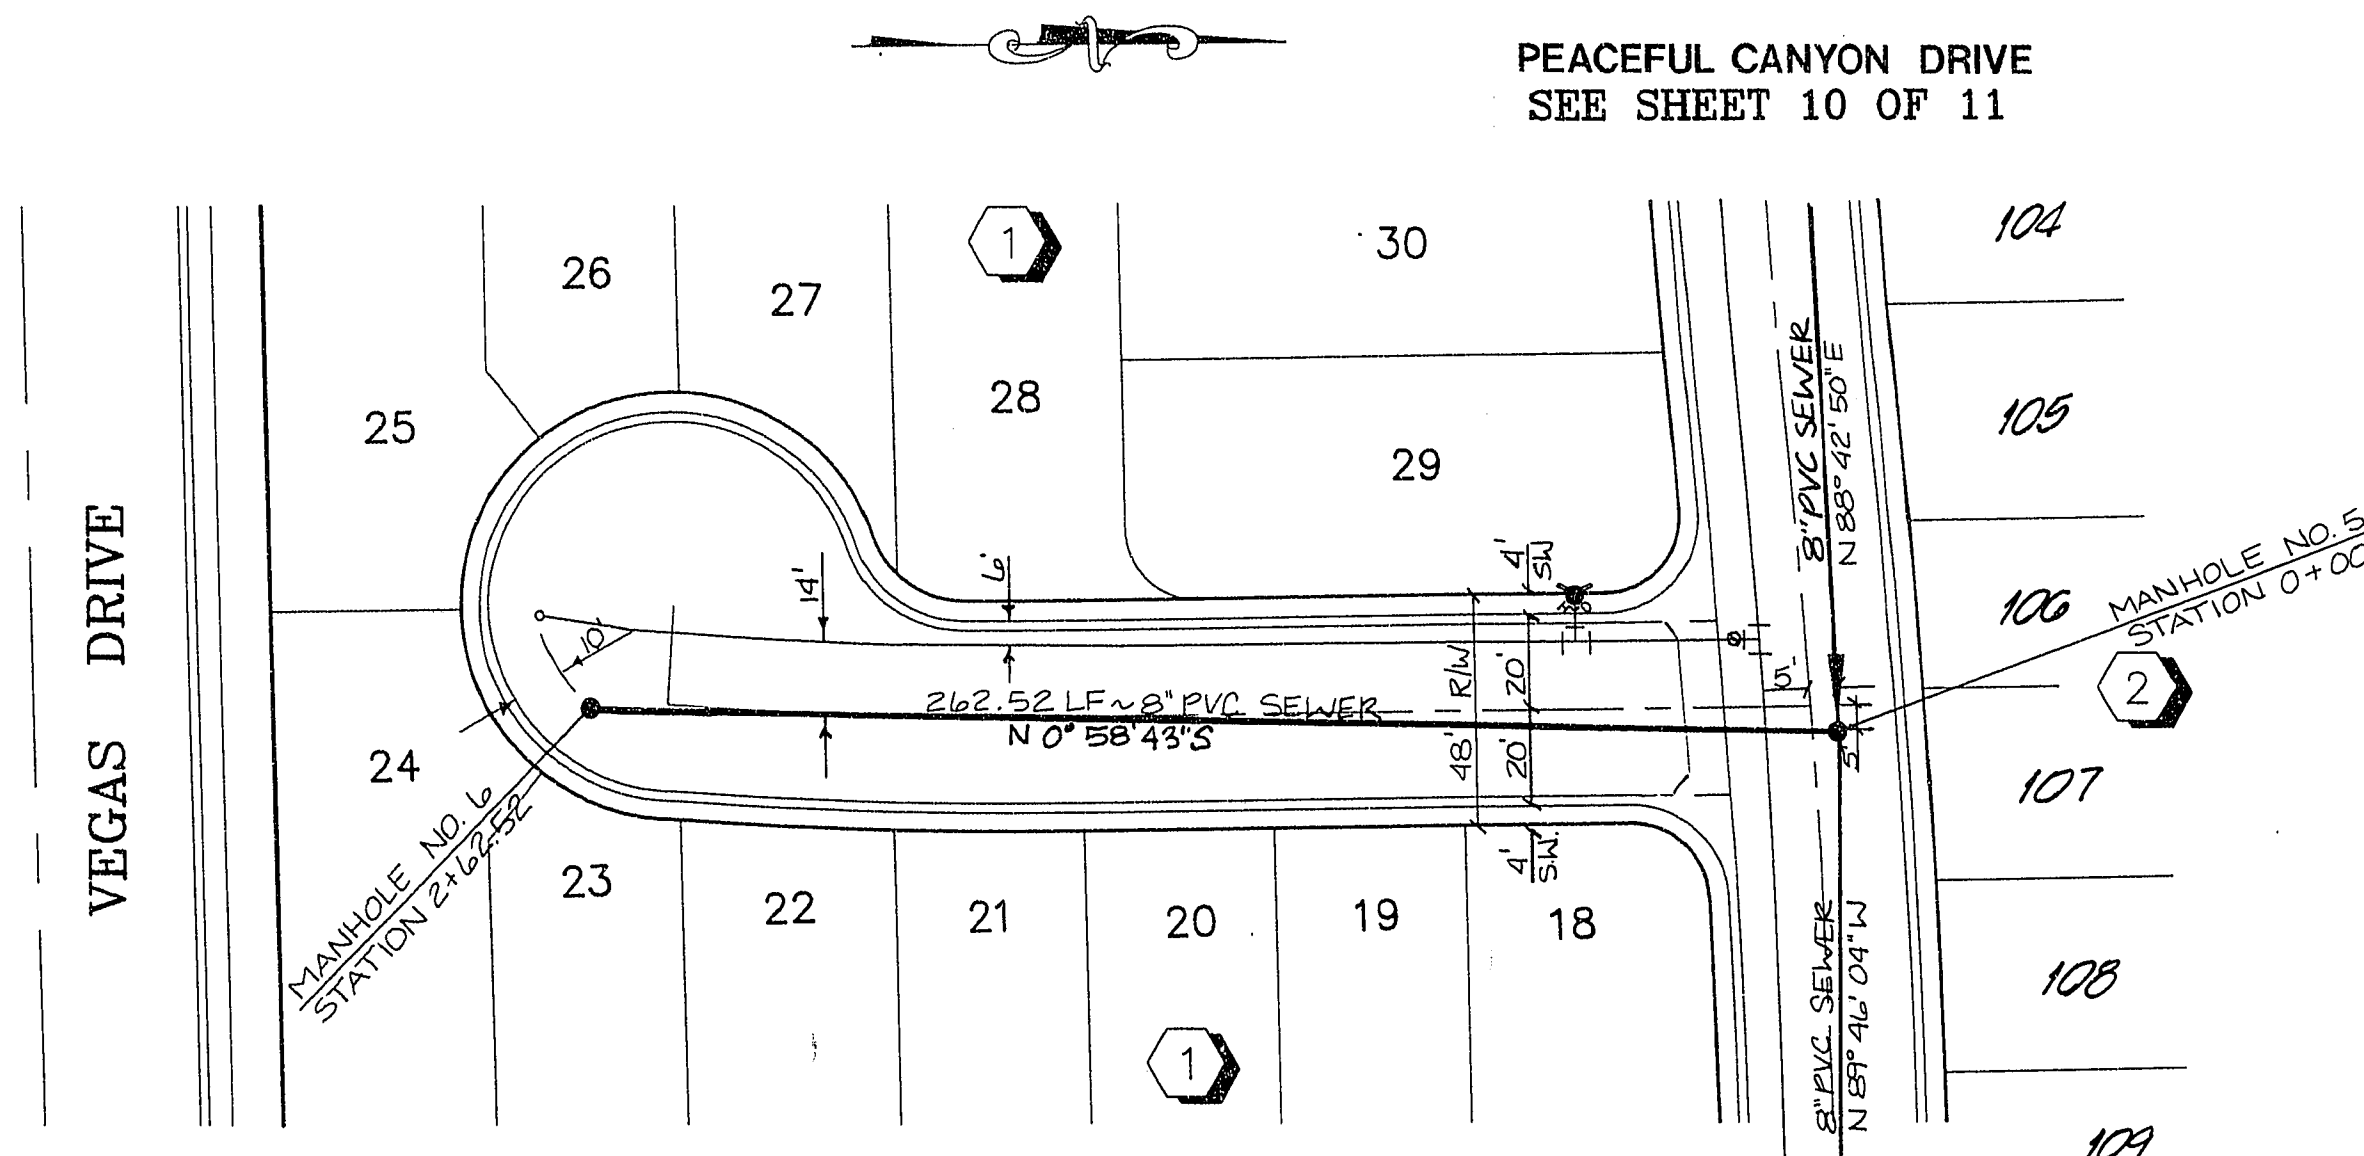

DESERT CANYON COURT

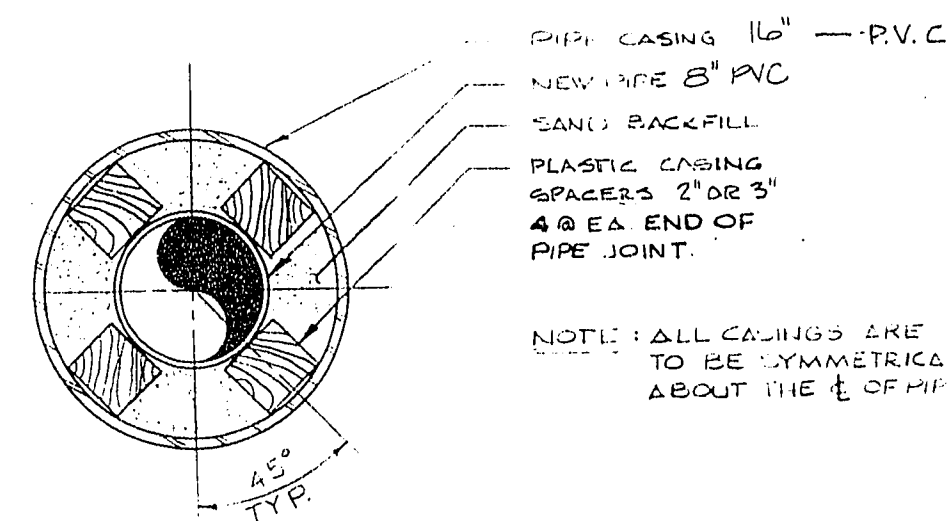

APPROVED FOR CONSTRUCTION

DATE 7/13/93
Casing Detail & Profile 07/93

2 working
0839
Call before you Dig
1-800-227-2800

BENCHMARK

CITY OF LAS VEGAS BENCHMARK
CHISELED "X" IN TOP OF CURB, AT END OF CURB ON THE WEST SIDE OF DURANGO, APPROX. 250' SOUTH OF WESTCLIFF DR.
ELEVATION = 2610.16'

NOTE:

CONTRACTOR TO VERIFY HORIZONTAL AND VERTICAL ALIGNMENT OF EXISTING UTILITIES AND TO NOTIFY THE ENGINEER IMMEDIATELY OF ANY DISCREPANCIES PRIOR TO CONSTRUCTION.

SEWER PLAN AND PROFILE
DESERT CANYON COURT

BONITA CANYON
UNIT - 1

PROJECT	
SEAL	
PROFESSIONAL ENGINEER	
NO. 4407-1	
BY KFN/EEB	
DATE 3/19/93	
SCALE HORIZ. 1" = 40' VERT. 1" = 4'	
SHEET 8 OF 11 SHEETS	

10-30-30 3074-4267-1