


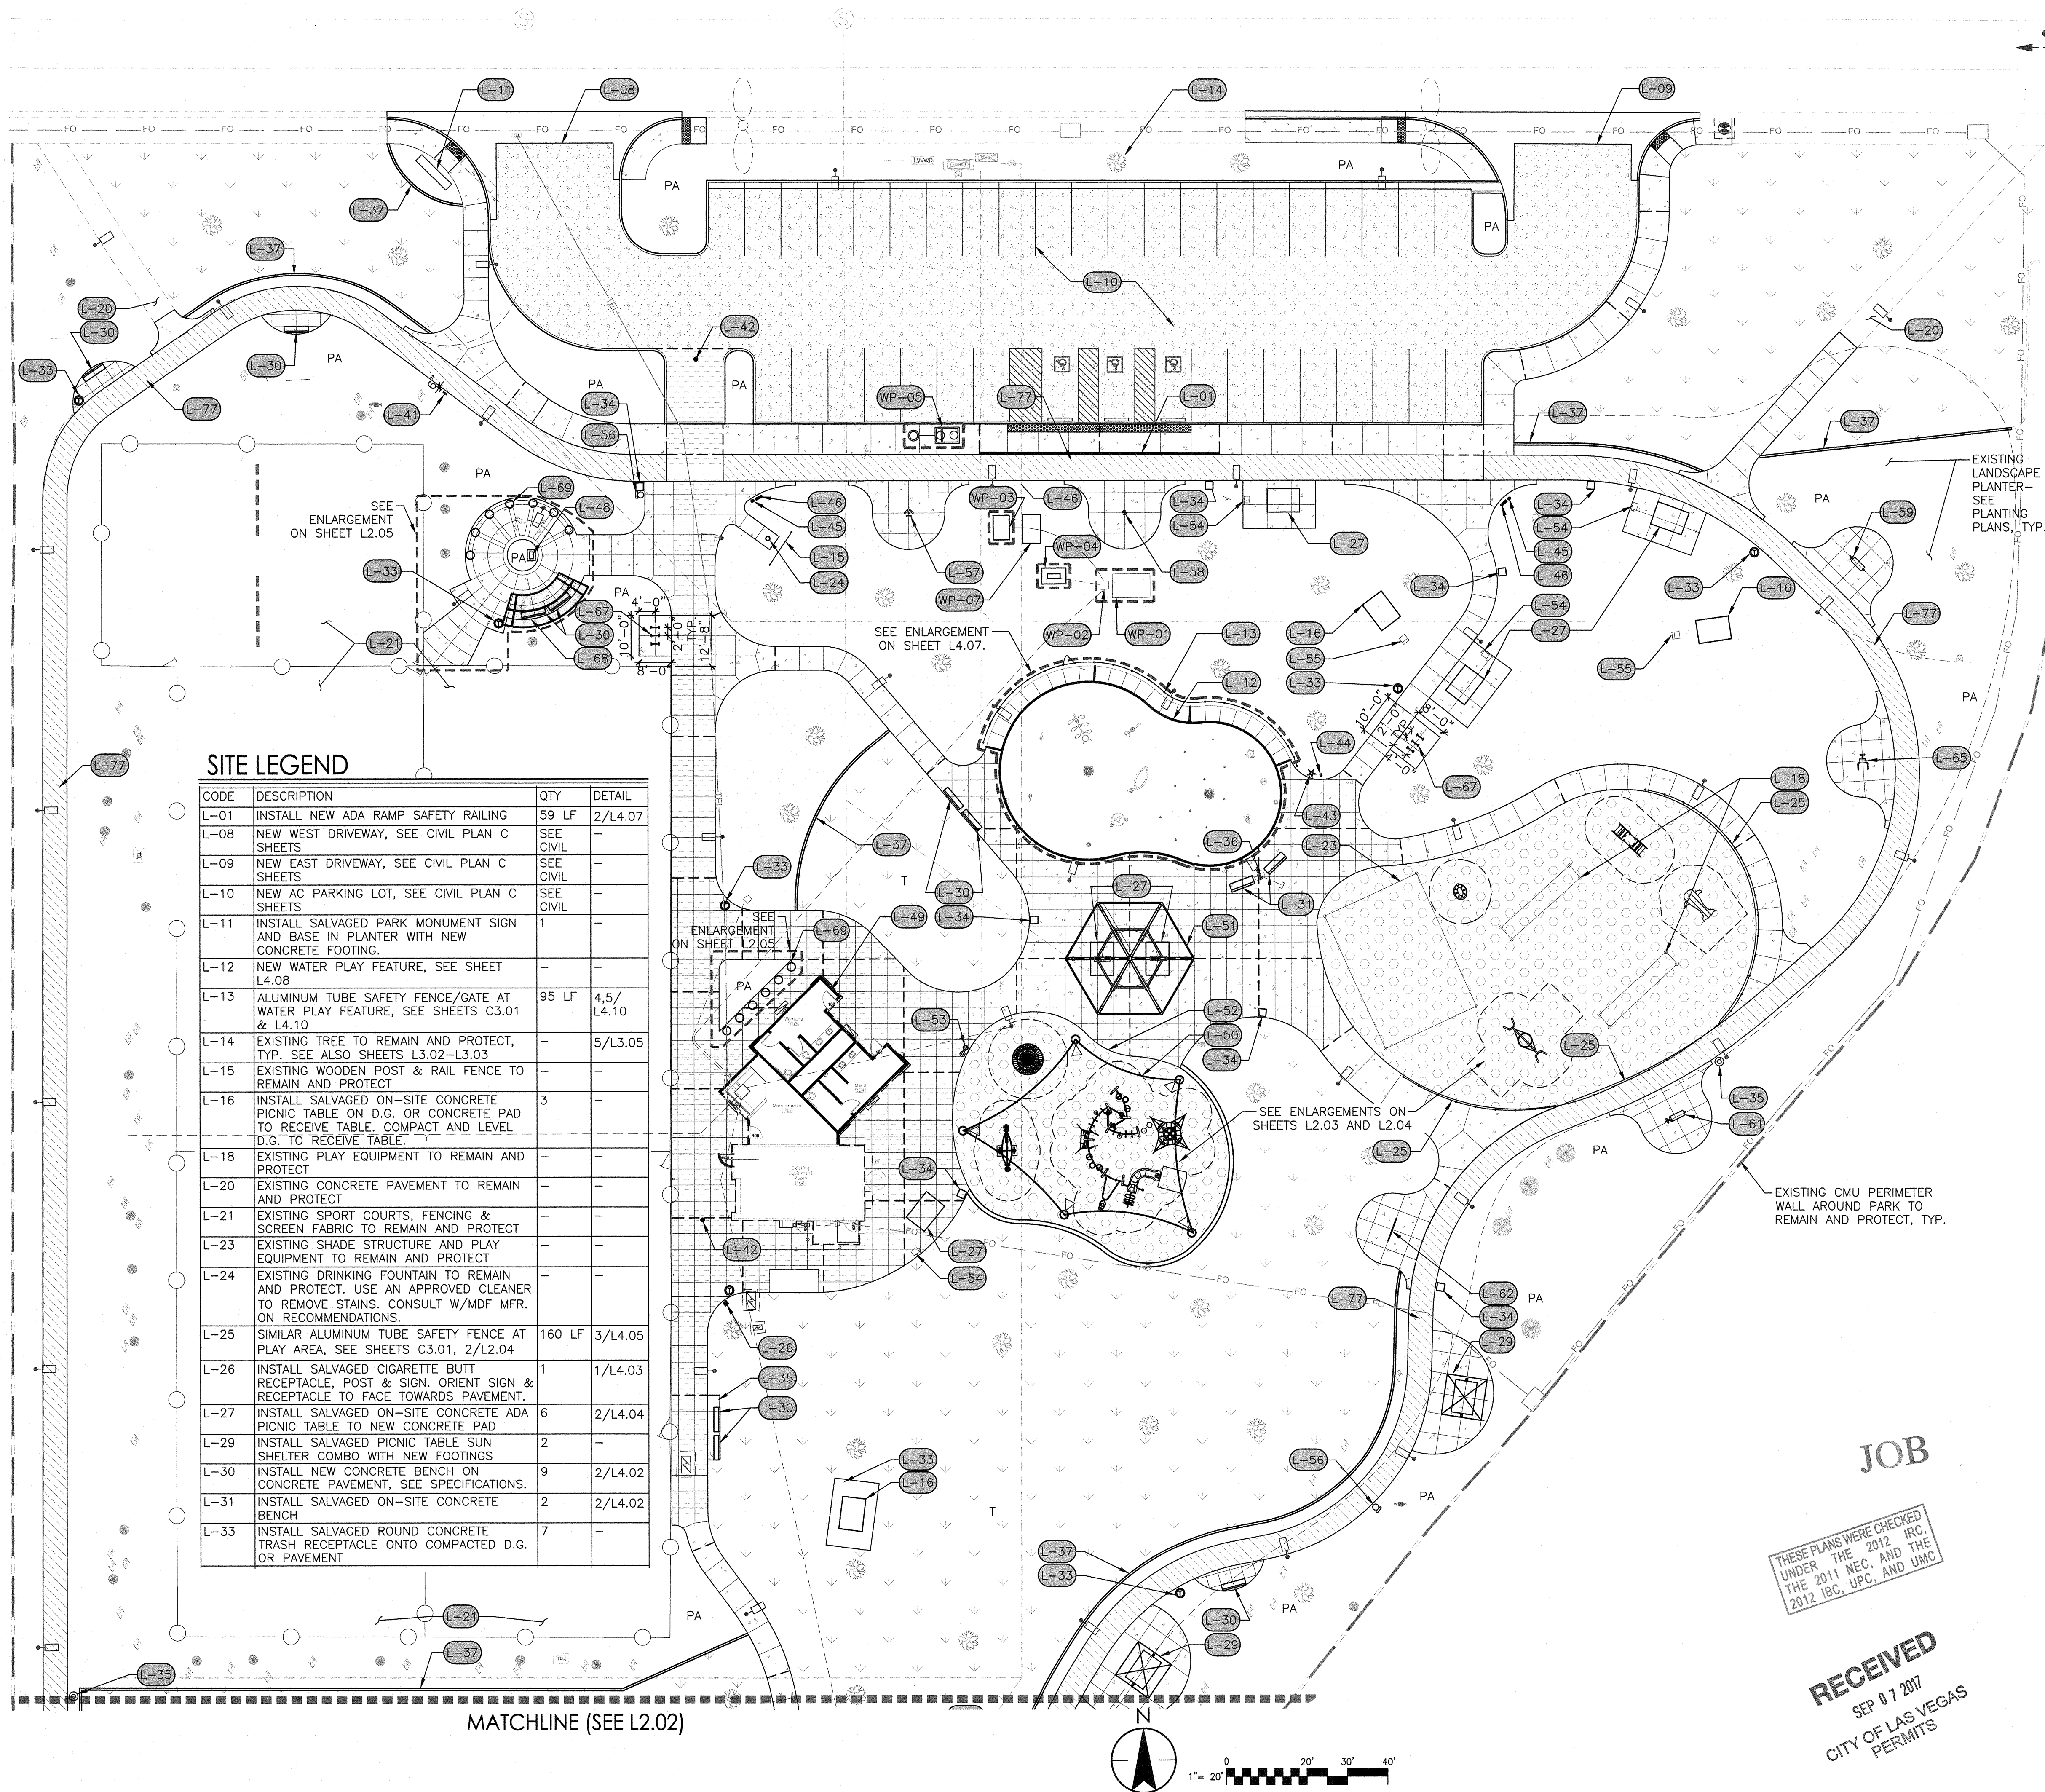

SITE LEGEND

CODE	DESCRIPTION	QTY	DETAIL
L-01	INSTALL NEW ADA RAMP SAFETY RAILING	59 LF	2/L4.07
L-08	NEW WEST DRIVEWAY, SEE CIVIL PLAN C SHEETS	SEE CIVIL	-
L-09	NEW EAST DRIVEWAY, SEE CIVIL PLAN C SHEETS	SEE CIVIL	-
L-10	NEW AC PARKING LOT, SEE CIVIL PLAN C SHEETS	SEE CIVIL	-
L-11	INSTALL SALVAGED PARK MONUMENT SIGN AND BASE IN PLANTER WITH NEW CONCRETE FOOTING.	1	-
L-12	NEW WATER PLAY FEATURE, SEE SHEET L4.08	-	-
L-13	ALUMINUM TUBE SAFETY FENCE/GATE AT WATER PLAY FEATURE, SEE SHEETS C3.01 & L4.10	95 LF	4,5/L4.10
L-14	EXISTING TREE TO REMAIN AND PROTECT, TYP. SEE ALSO SHEETS L3.02-L3.03	-	5/L3.05
L-15	EXISTING WOODEN POST & RAIL FENCE TO REMAIN AND PROTECT	-	-
L-16	INSTALL SALVAGED ON-SITE CONCRETE PICNIC TABLE ON D.G. OR CONCRETE PAD TO RECEIVE TABLE. COMPACT AND LEVEL D.G. TO RECEIVE TABLE.	3	-
L-18	EXISTING PLAY EQUIPMENT TO REMAIN AND PROTECT	-	-
L-20	EXISTING CONCRETE PAVEMENT TO REMAIN AND PROTECT	-	-
L-21	EXISTING SPORT COURTS, FENCING & SCREEN FABRIC TO REMAIN AND PROTECT	-	-
L-23	EXISTING SHADE STRUCTURE AND PLAY EQUIPMENT TO REMAIN AND PROTECT	-	-
L-24	EXISTING DRINKING FOUNTAIN TO REMAIN AND PROTECT. USE AN APPROVED CLEANER TO REMOVE STAINS. CONSULT W/MDF MFR. ON RECOMMENDATIONS.	-	-
L-25	SIMILAR ALUMINUM TUBE SAFETY FENCE AT PLAY AREA, SEE SHEETS C3.01, 2/L2.04	160 LF	3/L4.05
L-26	INSTALL SALVAGED CIGARETTE BUTT RECEPTACLE, POST & SIGN. ORIENT SIGN & RECEPTACLE TO FACE TOWARDS PAVEMENT.	1	1/L4.03
L-27	INSTALL SALVAGED ON-SITE CONCRETE ADA PICNIC TABLE TO NEW CONCRETE PAD	6	2/L4.04
L-29	INSTALL SALVAGED PICNIC TABLE SUN SHELTER COMBO WITH NEW FOOTINGS	2	-
L-30	INSTALL NEW CONCRETE BENCH ON CONCRETE PAVEMENT, SEE SPECIFICATIONS.	9	2/L4.02
L-31	INSTALL SALVAGED ON-SITE CONCRETE BENCH	2	2/L4.02
L-33	INSTALL SALVAGED ROUND CONCRETE TRASH RECEPTACLE ONTO COMPACTED D.G. OR PAVEMENT	7	-

SITE LEGEND (CONTINUED)

L-34	INSTALL SALVAGED SQUARE CONCRETE TRASH RECEPTACLE ONTO COMPACTED D.G. OR PAVEMENT.	8	-
L-35	INSTALL SALVAGED AND RELOCATED ROUND METAL TRASH RECEPTACLE	2	-
L-36	INSTALL SALVAGED POLE MOUNTED DOGPOT STATION ONTO NEW LIGHT POLE	1	-
L-37	6" CONCRETE MOW CURB	531 LF	10/L4.0
L-41	INSTALL NEW INFORMATIVE SIGN FOR JOGGING TRAIL-START OF TRAIL FOR MILE MARKER TRACKING. SIGN TO FACE TOWARDS TRAIL.	1	3/L4.03
L-42	INSTALL REMOVABLE BOLLARD IN CONCRETE FOOTING AND PAVEMENT	2	4/L4.07
L-43	INSTALL NEW WATER PLAY SIGNS ON POST. ORIENT SIGN TO FACE TOWARDS PAVEMENT. SEE BOTH DETAILS.	1	5/L4.03
L-44	INSTALL WATER PLAY RULES SIGN ON POST. ORIENT SIGN TO FACE TOWARDS PAVEMENT.	1	7/L4.03
L-45	INSTALL NEW REPORT VANDALISM SIGN. FACE SIGN TOWARDS PATH.	2	1/L4.04
L-46	INSTALL NEW PARK RULES SIGN. FACE SIGN TOWARDS PATH.	2	4/L4.04
L-48	CONSTRUCT NEW PEDESTAL FOR FUTURE PLAQUE INSTALLED BY CITY	1	3/L4.07
L-49	NEW RESTROOM TO REPLACE EXISTING, SEE ARCHITECTURAL PLANS	-	-
L-50	INSTALL NEW PLAYGROUND SHADE STRUCTURE.	1	4/L4.02
L-51	INSTALL NEW 32' HEXAGON PREMANUFACTURED GROUP PICNIC SHELTER, SEE SPECS.	1	4/L4.05
L-52	NEW PLAY AREA (AGES 5-12). SEE ENLARGEMENT SHEETS L2.03 & L2.04.	-	L2.03 L2.04
L-53	INSTALL NEW ADA DRINKING FOUNTAIN W/PET BOWL & BOTTLE FILLER.	1	3/L4.02
L-54	INSTALL NEW ADA BARBECUE GRILL, POST & FOOTING IN PAVEMENT.	4	5/L4.07
L-55	INSTALL NEW BARBECUE GRILL, POST & FOOTING IN PAVEMENT.	2	5/L4.07
L-56	INSTALL NEW DOG DISPENSER & SIGN ON POST	2	4/L4.03
L-57	INSTALL NEW EXERCISE EQUIPMENT STEP UP. SEE SPECIFICATIONS. SEE NOTE #14 FOR LOCATION PLACEMENT.	1	-
L-58	INSTALL NEW EXERCISE EQUIPMENT LEG LIFT. SEE SPECIFICATIONS. SEE NOTE #14 FOR LOCATION PLACEMENT.	1	-
L-59	INSTALL NEW EXERCISE EQUIPMENT BODY CURL. SEE SPECIFICATIONS. SEE NOTE #14 FOR LOCATION PLACEMENT.	1	-
L-61	INSTALL NEW EXERCISE EQUIPMENT SIT UP. SEE SPECIFICATIONS. SEE NOTE #14 FOR LOCATION PLACEMENT.	1	-
L-62	INSTALL NEW EXERCISE EQUIPMENT HIP ROTATION. SEE SPECIFICATIONS. SEE NOTE #14 FOR LOCATION PLACEMENT.	1	-
L-65	INSTALL NEW EXERCISE EQUIPMENT HYPER EXTENSION. SEE SPECIFICATIONS. SEE NOTE #14 FOR LOCATION PLACEMENT.	1	-
L-67	INSTALL NEW BIKE RACK LOOP, COLOR RED. SEE SPECIFICATIONS. INSTALL IN CONCRETE FOOTING. HOLD TOP OF FOOTING BELOW PAVEMENT.	6	-
L-68	INSTALL NEW CURVED SUN STRUCTURE.	1	5/L4.04
L-69	PRECAST CONCRETE ROUND SEAT, TYP.	13	1/L4.02

WATER PLAY			
CODE	DESCRIPTION	QTY	DETAIL
WP-01	NEW WATER PLAY WATER VALVE CONTROLS VAULT 1" ABOVE ADJACENT FINISH GRADE	1	1/L4.09
WP-02	NEW WATER PLAY CONTROLLER. SEE ELECTRICAL PLANS.	1	-
WP-03	NEW WATER PLAY RPPA, SEE SHEET C5.01	1	-
WP-04	NEW WATER PLAY BOOSTER PUMP STATION, SEE SHEETS C5.01 & 11.08	1	-
WP-05	NEW WATER PLAY SAND OIL SEPARATOR & SAMPLE BOX. INSTALL LIDS/RIM FLUSH W/F.G. INSTALL VENT PIPE AT LOCATION SHOWN, SEE SHEET C5.01	1	3/L4.09
WP-07	NEW IRRIGATION BOOSTER PUMP	1	-


LAYOUT			
SYMBOL	DESCRIPTION	QTY	DETAIL
	ASPHALT PARKING LOT, SEE CIVIL PLANS	14,459 SF	-
	PEDESTRIAN CONCRETE PAVING, STANDARD GRAY, TYP. MEDIUM BROOM FINISH.	16,467 SF	1-5/L4.01
	VEHICULAR CONCRETE PAVING, STANDARD GRAY, TYP. MEDIUM BROOM FINISH.	6,356 SF	1-5/L4.01
L-77	INSTALL NEW JOGGING TRAIL. PEDESTRIAN CONCRETE W/SYNTHETIC SURFACING 1/2" THK. COLOR TO BE RED. SEE SPECIFICATIONS.	2,803 SF	6-8/L4.01
	1/4" MINUS DECOMPOSED GRANITE, TYP. COLOR TO BE 'GOLD'. SUBMIT SAMPLE FOR REVIEW AND APPROVAL PRIOR TO ORDERING.	18,385 SF	4/L3.05
	RESILIENT PLAY SURFACING. SEE ENLARGEMENT PLAN AND SPECIFICATIONS.	9,286 SF	9/L4.01

SITE LEGEND - MISCELLANEOUS


MISC	DESCRIPTION
PA	PLANTER AREA - SEE PLANTING PLANS L3.01-L3.05
T	TURF - SEE PLANTING PLANS L3.01-L3.05
	EXISTING TREE TO REMAIN AND PROTECT - SEE CALLOUT L-14.
	EXISTING BOULDER TO REMAIN



REVISIONS
CONSULTANT

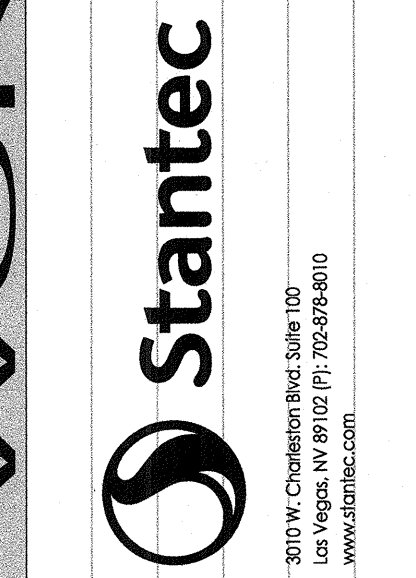

BOB BASKIN PARK
RENOVATION
SITE PLAN

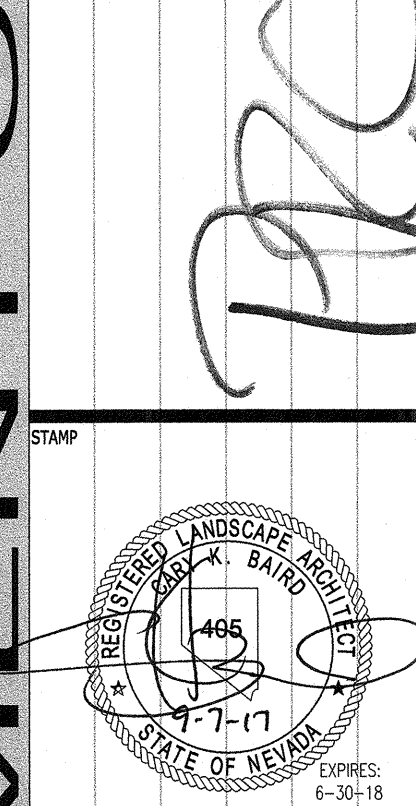

OWNER: CITY OF LAS VEGAS
DEPARTMENT OF PUBLIC WORKS
ARCHITECTURAL SERVICES
DEVELOPMENT SERVICES CENTER
333 N. RANCHO DRIVE
LAS VEGAS, NEVADA 89106
PHONE: (702) 229-6276
FAX: (702) 384-4846

DRAWN LR
FILE 180101443
DATE 9-7-17
SCALE SEE PLAN
JOB NO 17.54875.JH
CLV DWS NO 650.27-7

SHT NO
L2.01

THESE PLANS WERE CHECKED
UNDER THE 2012 IRC,
THE 2011 NEC, AND THE
2012 IBC, UPC, AND UMC



RECEIVED
SEP 07 2017
CITY OF LAS VEGAS
PERMITS

[illegible]

CODE	LAYOUT DESCRIPTION	QTY	DETAIL
L-22	EXISTING CMU WALL CORNER TO BE CLOSED OFF--SEE CIVIL PLANS	—	C SHEETS
L-27	INSTALL SALVAGED ON-SITE CONCRETE ADA PICNIC TABLE TO NEW CONCRETE PAD	1	—
L-28	INSTALL SALVAGED 3-PIECE CONCRETE PICNIC TABLE AND BENCHES TO NEW CONCRETE PAD	1	—
L-29	INSTALL SALVAGED PICNIC TABLE SUN SHELTER COMBO WITH NEW FOOTINGS	1	2/L4.04
L-30	INSTALL NEW CONCRETE BENCH ON CONCRETE PAVEMENT, SEE SPECIFICATIONS.	3	2/L4.02
L-33	INSTALL SALVAGED ROUND CONCRETE TRASH RECEPTACLE ONTO COMPACTED D.G. OR PAVEMENT	3	—
L-35	INSTALL SALVAGED AND RELOCATED ROUND METAL TRASH RECEPTACLE	1	—
L-36	INSTALL SALVAGED POLE MOUNTED DOGPOT STATION ONTO NEW LIGHT POLE	1	—
L-37	6" CONCRETE MOW CURB	728 LF	10/L4.01
L-55	INSTALL NEW BARBECUE GRILL, POST & FOOTING IN PAVEMENT.	3	5/L4.07
L-57	INSTALL NEW EXERCISE EQUIPMENT STEP UP. SEE SPECIFICATIONS. SEE NOTE #14 FOR LOCATION PLACEMENT.	1	—
L-58	INSTALL NEW EXERCISE EQUIPMENT LEG LIFT. SEE SPECIFICATIONS. SEE NOTE #14 FOR LOCATION PLACEMENT.	1	—
L-63	INSTALL NEW EXERCISE EQUIPMENT PUSH UP. SEE SPECIFICATIONS. SEE NOTE #14 FOR LOCATION PLACEMENT.	1	—
L-64	INSTALL NEW EXERCISE EQUIPMENT DIP STATION. SEE SPECIFICATIONS. SEE NOTE #14 FOR LOCATION PLACEMENT.	1	—
L-65	INSTALL NEW EXERCISE EQUIPMENT HYPER EXTENSION. SEE SPECIFICATIONS. SEE NOTE #14 FOR LOCATION PLACEMENT.	1	—
L-66	INSTALL NEW EXERCISE EQUIPMENT BENCH. SEE SPECIFICATIONS. SEE NOTE #14 FOR LOCATION PLACEMENT.	1	—
	LAYOUT		
SYMBOL	DESCRIPTION	QTY	DETAIL
	PEDESTRIAN CONCRETE PAVING, STANDARD GRAY, TYP. MEDIUM BROOM FINISH.	5,117 SF	1-5/L4.01
	INSTALL NEW JOGGING TRAIL, PEDESTRIAN CONCRETE W/SYNTHEC SURFACING 1/2" THK. COLOR TO BE RED. SEE SPECIFICATIONS.	9,007 SF	6-8/L4.01
	1/4" MINUS DECOMPOSED GRANITE, TYP. COLOR TO BE "GOLD". SUBMIT SAMPLE FOR REVIEW AND APPROVAL PRIOR TO ORDERING.	3,974 SF	4/L3.05

MISC	DESCRIPTION
PA	PLANTER AREA - SEE PLANTING PLANS L3.01-L3.05
T	TURF - SEE PLANTING PLANS L3.01-L3.05
	EXISTING TREE TO REMAIN AND PROTECT - SEE CALLOUT L-14.
	EXISTING BOULDER TO REMAIN

 
1. WRITTEN DIMENSIONS SHALL TAKE PRECEDENT OVER SCALED DIMENSIONS. ALL FIELD ADJUSTMENTS MUST BE APPROVED BY THE OWNER PRIOR TO INSTALLATION.
2. ALL LOCAL CODES AND ORDINANCES SHALL BE COMPLIED WITH. IF THERE IS A CONFLICT, THE CONTRACTOR SHALL NOTIFY THE OWNER IMMEDIATELY IN WRITING.
3. IT IS THE CONTRACTOR'S RESPONSIBILITY TO DETERMINE THE LOCATION OF ANY UNDERGROUND UTILITIES. DAMAGE CAUSED BY THE CONTRACTOR'S INSTALLATION SHALL BE REPAIRED TO THE SATISFACTION OF THE GOVERNING AGENCY AND/OR OWNER. THE CONTRACTOR SHALL BE RESPONSIBLE FOR ALL COSTS OF SUCH REPAIRS. CONTRACTOR SHALL CONTACT U.S.A. (800) 642-2444 FOR LOCATION OF ALL UNDERGROUND UTILITIES FORTY EIGHT (48) HOURS BEFORE STARTING EXCAVATION.
4. VERIFY EXISTING CONDITIONS BEFORE BEGINNING WORK. NOTIFY THE OWNER IF THERE ARE SUBSTANTIAL DISCREPANCIES.
5. CONTRACTOR SHALL BE RESPONSIBLE FOR MAINTAINING POSITIVE DRAINAGE AS SHOWN ON PLANS.
6. ALL TRADES SHALL COORDINATE WORK SO PROGRESS OF WORK IS NOT INTERRUPTED AND CAN BE COMPLETED IN A TIMELY MANNER.
7. WALKWAYS SHALL MEET ALL ACCESSIBILITY RULES AND REGULATIONS AS SET FORTH BY THE AMERICAN WITH DISABILITIES ACT (ADA). THE REQUIREMENTS OF ADA WILL BE SUBJECT TO VARIOUS, AND POSSIBLY, CONTRADICTORY INTERPRETATIONS. THE LANDSCAPE ARCHITECT HAS USED THEIR BEST PROFESSIONAL EFFORT TO INTERPRET APPLICABLE ADA REQUIREMENTS AND OTHER FEDERAL, STATE AND LOCAL LAWS, RULES, CODES ORDINANCES AND REGULATIONS AS THEY APPLY TO THIS PROJECT.
8. ALL DIMENSIONS ARE TO EDGE OF CONCRETE FLATWORK, FACE OF CURB, OR CENTER POINT OF RADIUS.
9. NEW CONCRETE FLATWORK SHALL MEET GRADE OF EXISTING CONCRETE FLATWORK PAVING. WHERE NEW CONCRETE IS PLACED ADJACENT TO CURBS OR EXISTING CONCRETE PAVING, A CONTINUOUS THICKENED EDGE JOINT SHALL BE INSTALLED BETWEEN THE NEW CONCRETE FLATWORK AND EXISTING CURB OR EXISTING CONCRETE FLATWORK.
10. SLEEPING SHALL BE INSTALLED PRIOR TO PLACING CONCRETE WORK. REFER TO IRRIGATION PLAN. CONTRACTOR TO STUDY IRRIGATION PLAN TO DETERMINE EXACT LOCATION OF SLEEPING. CONTRACTOR TO BE RESPONSIBLE FOR ALL SLEEVE LOCATIONS.
11. THE CONTRACTOR SHALL BE RESPONSIBLE FOR REPAIRING, AT NO ADDITIONAL COST TO THE OWNER, ANY EXISTING AREAS TO REMAIN WHICH ARE DISTURBED AS A CONSEQUENCE OF THE CONTRACTOR'S CONSTRUCTION OPERATIONS.
12. ALL MATERIALS AND FINISHES SHALL BE AS PER DRAWINGS, DETAILS AND SPECIFICATIONS. SOME MATERIALS MAY REQUIRE A SEVERAL-WEEK LEAD TIME. CONTRACTOR IS RESPONSIBLE FOR DETERMINING ANY AND ALL ORDERING LEAD TIMES AND PROVIDING REQUIRED MATERIALS AT THE PROJECT SITE IN A TIMELY MANNER. NO UNAPPROVED SUBSTITUTIONS WILL BE ALLOWED. CONTACT THE OWNER IMMEDIATELY IF A SPECIFIED MATERIAL IS NOT AVAILABLE.
13. ALL DIMENSIONS ARE APPROXIMATE. CONTRACTOR SHALL MATCH EXISTING CONDITIONS AND MAKE ADJUSTMENTS TO RESPOND TO THE DRAWING INTENT.
14. MANUFACTURER TO PROVIDE SHOP DRAWINGS FOR LAYOUT, PLACEMENT AND INSTALLATION OF PROPOSED EXERCISE EQUIPMENT FOR REVIEW AND APPROVAL BY OWNER OR OWNER'S REPRESENTATIVE.
15. ALL EXISTING CONCRETE FURNITURE TO BE CLEANED TO REMOVE STAINS.
16. STANDARD COLORS FOR PARK AMENITIES THAT ARE NOT SPECIFIED SHALL BE INCLUDED WITH SUBMITTAL FOR SELECTION. ALL NEW PARK AMENITIES SHALL BE IN-GROUND MOUNTED IF NOT SPECIFIED. NO EXPOSED FOOTINGS. INSTALL PER MANUFACTURER'S RECOMMENDATIONS. FOR ALL PRODUCTS SPECIFIED IN LEGEND, SEE ALSO PROJECT SPECIFICATIONS.
17. WHERE PICNIC TABLE OR TRASH RECEPTACLE SITE FURNISHINGS ARE SHOWN TO BE PLACED ON DECOMPOSED GRANITE AREAS, CONTRACTOR SHALL CONTACT DECOMPOSED GRANITE AND SUBGRADE TO 80% MIN. (60% MAX UNDER TREE CANOPIES) TO SUPPORT PLACEMENT OF SITE FURNISHINGS. GRAIL LOCATION IS SPECIFIED. SO FURNISHING IS PLACED ON LEVEL SURFACE.
18. CONTRACTOR SHALL PREPARE AND SUBMIT A SHOP DRAWING SHOWING ALL PROPOSED CONSTRUCTION, CONTROL AND EXPANSION JOINT LOCATIONS FOR REVIEW. DESIGN SHOWN ON THESE PLANS SHOWS INTENT TO ACHIEVE. ADJUSTMENTS MAY BE PROPOSED TO ACHIEVE DESIGN INTENT.

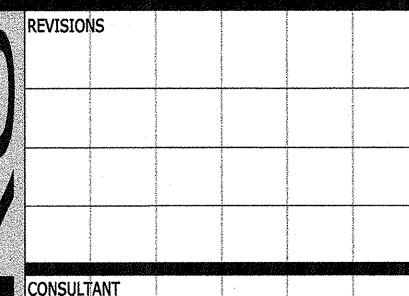

BOB BASKIN PARK

RENOVATION

SITE PLAN

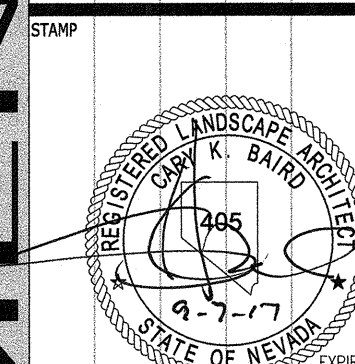


OWNER: CITY OF LAS VEGAS
DEPARTMENT OF PUBLIC WORKS
ARCHITECTURAL SERVICES

DEVELOPMENT SERVICES CENTER
333 N. RANCHO DRIVE
LAS VEGAS, NEVADA 89101
PHONE: (702) 229-6271
FAX: (702) 384-4844

DRAWN	LR		
FILE	180101443		
DATE	9-7-17		
SCALE	SEE PLAN		
BID NO	17.54875.JH		
CLV DWG NO	650.27-7		

SHT N

L2.02

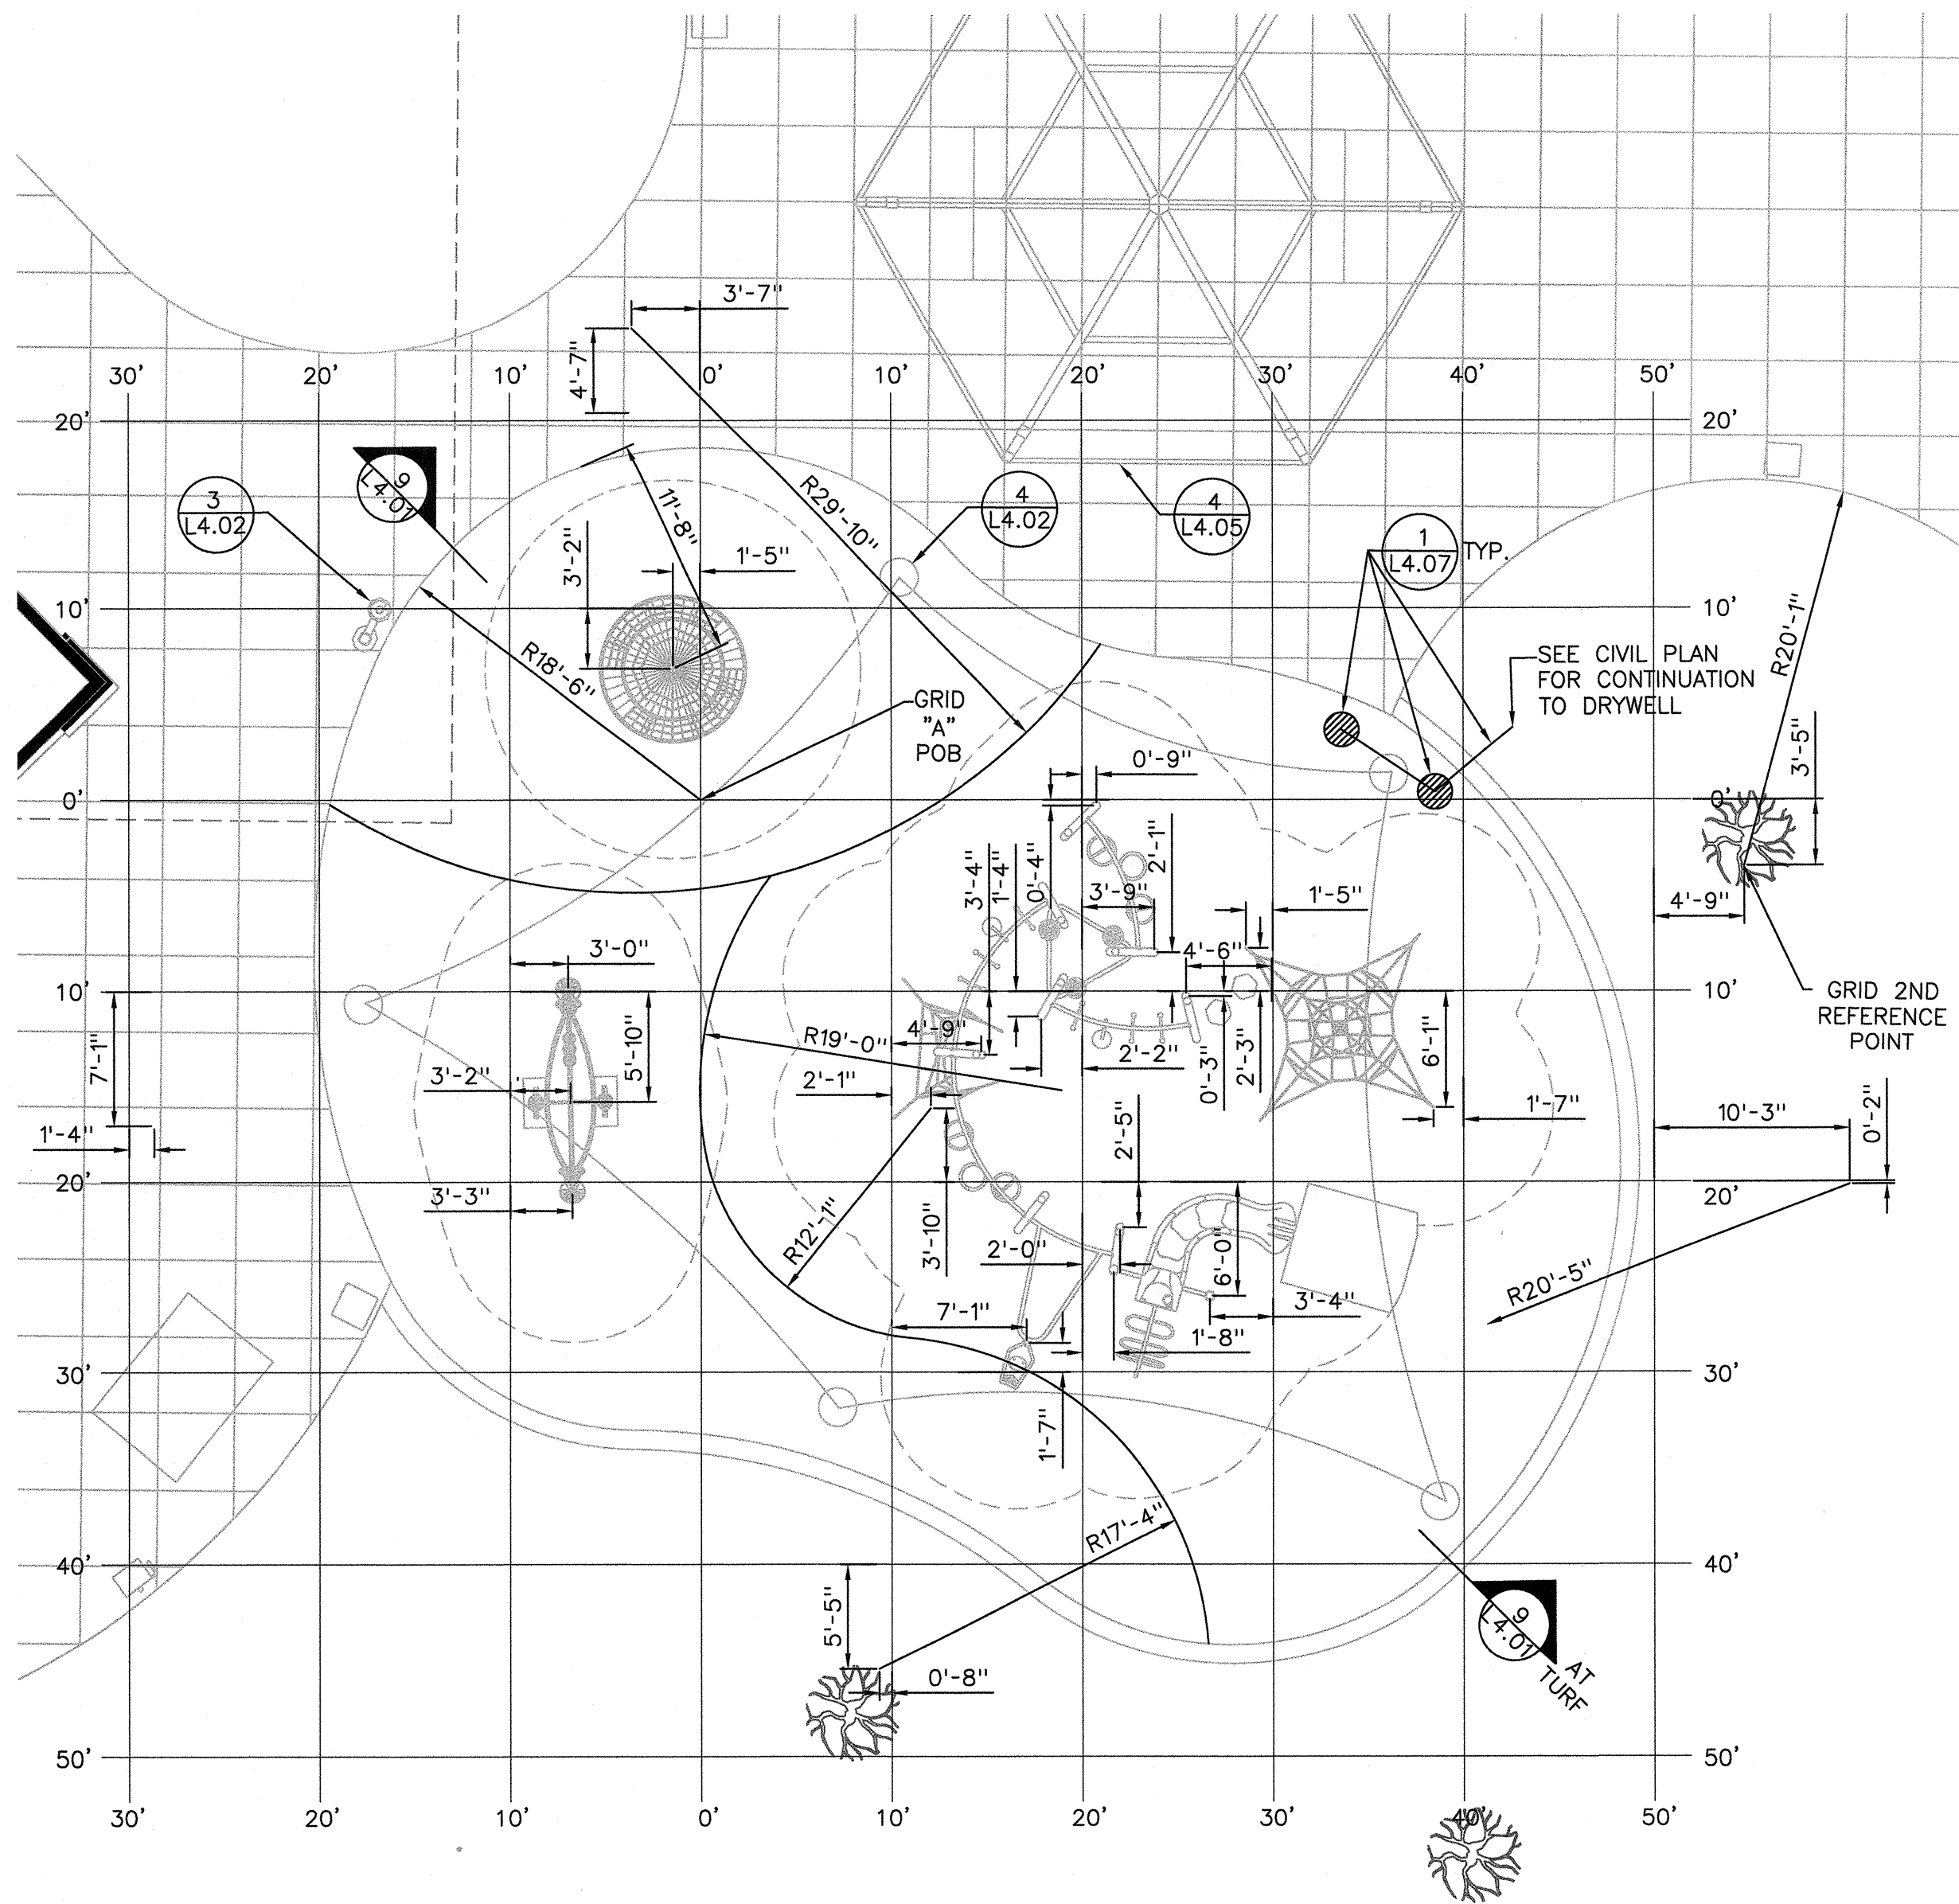


1 NEW PLAYGROUND: EQUIPMENT AND SURFACING LAYOUT

1/8" = 1'-0"

0 8' 12' 16'

N

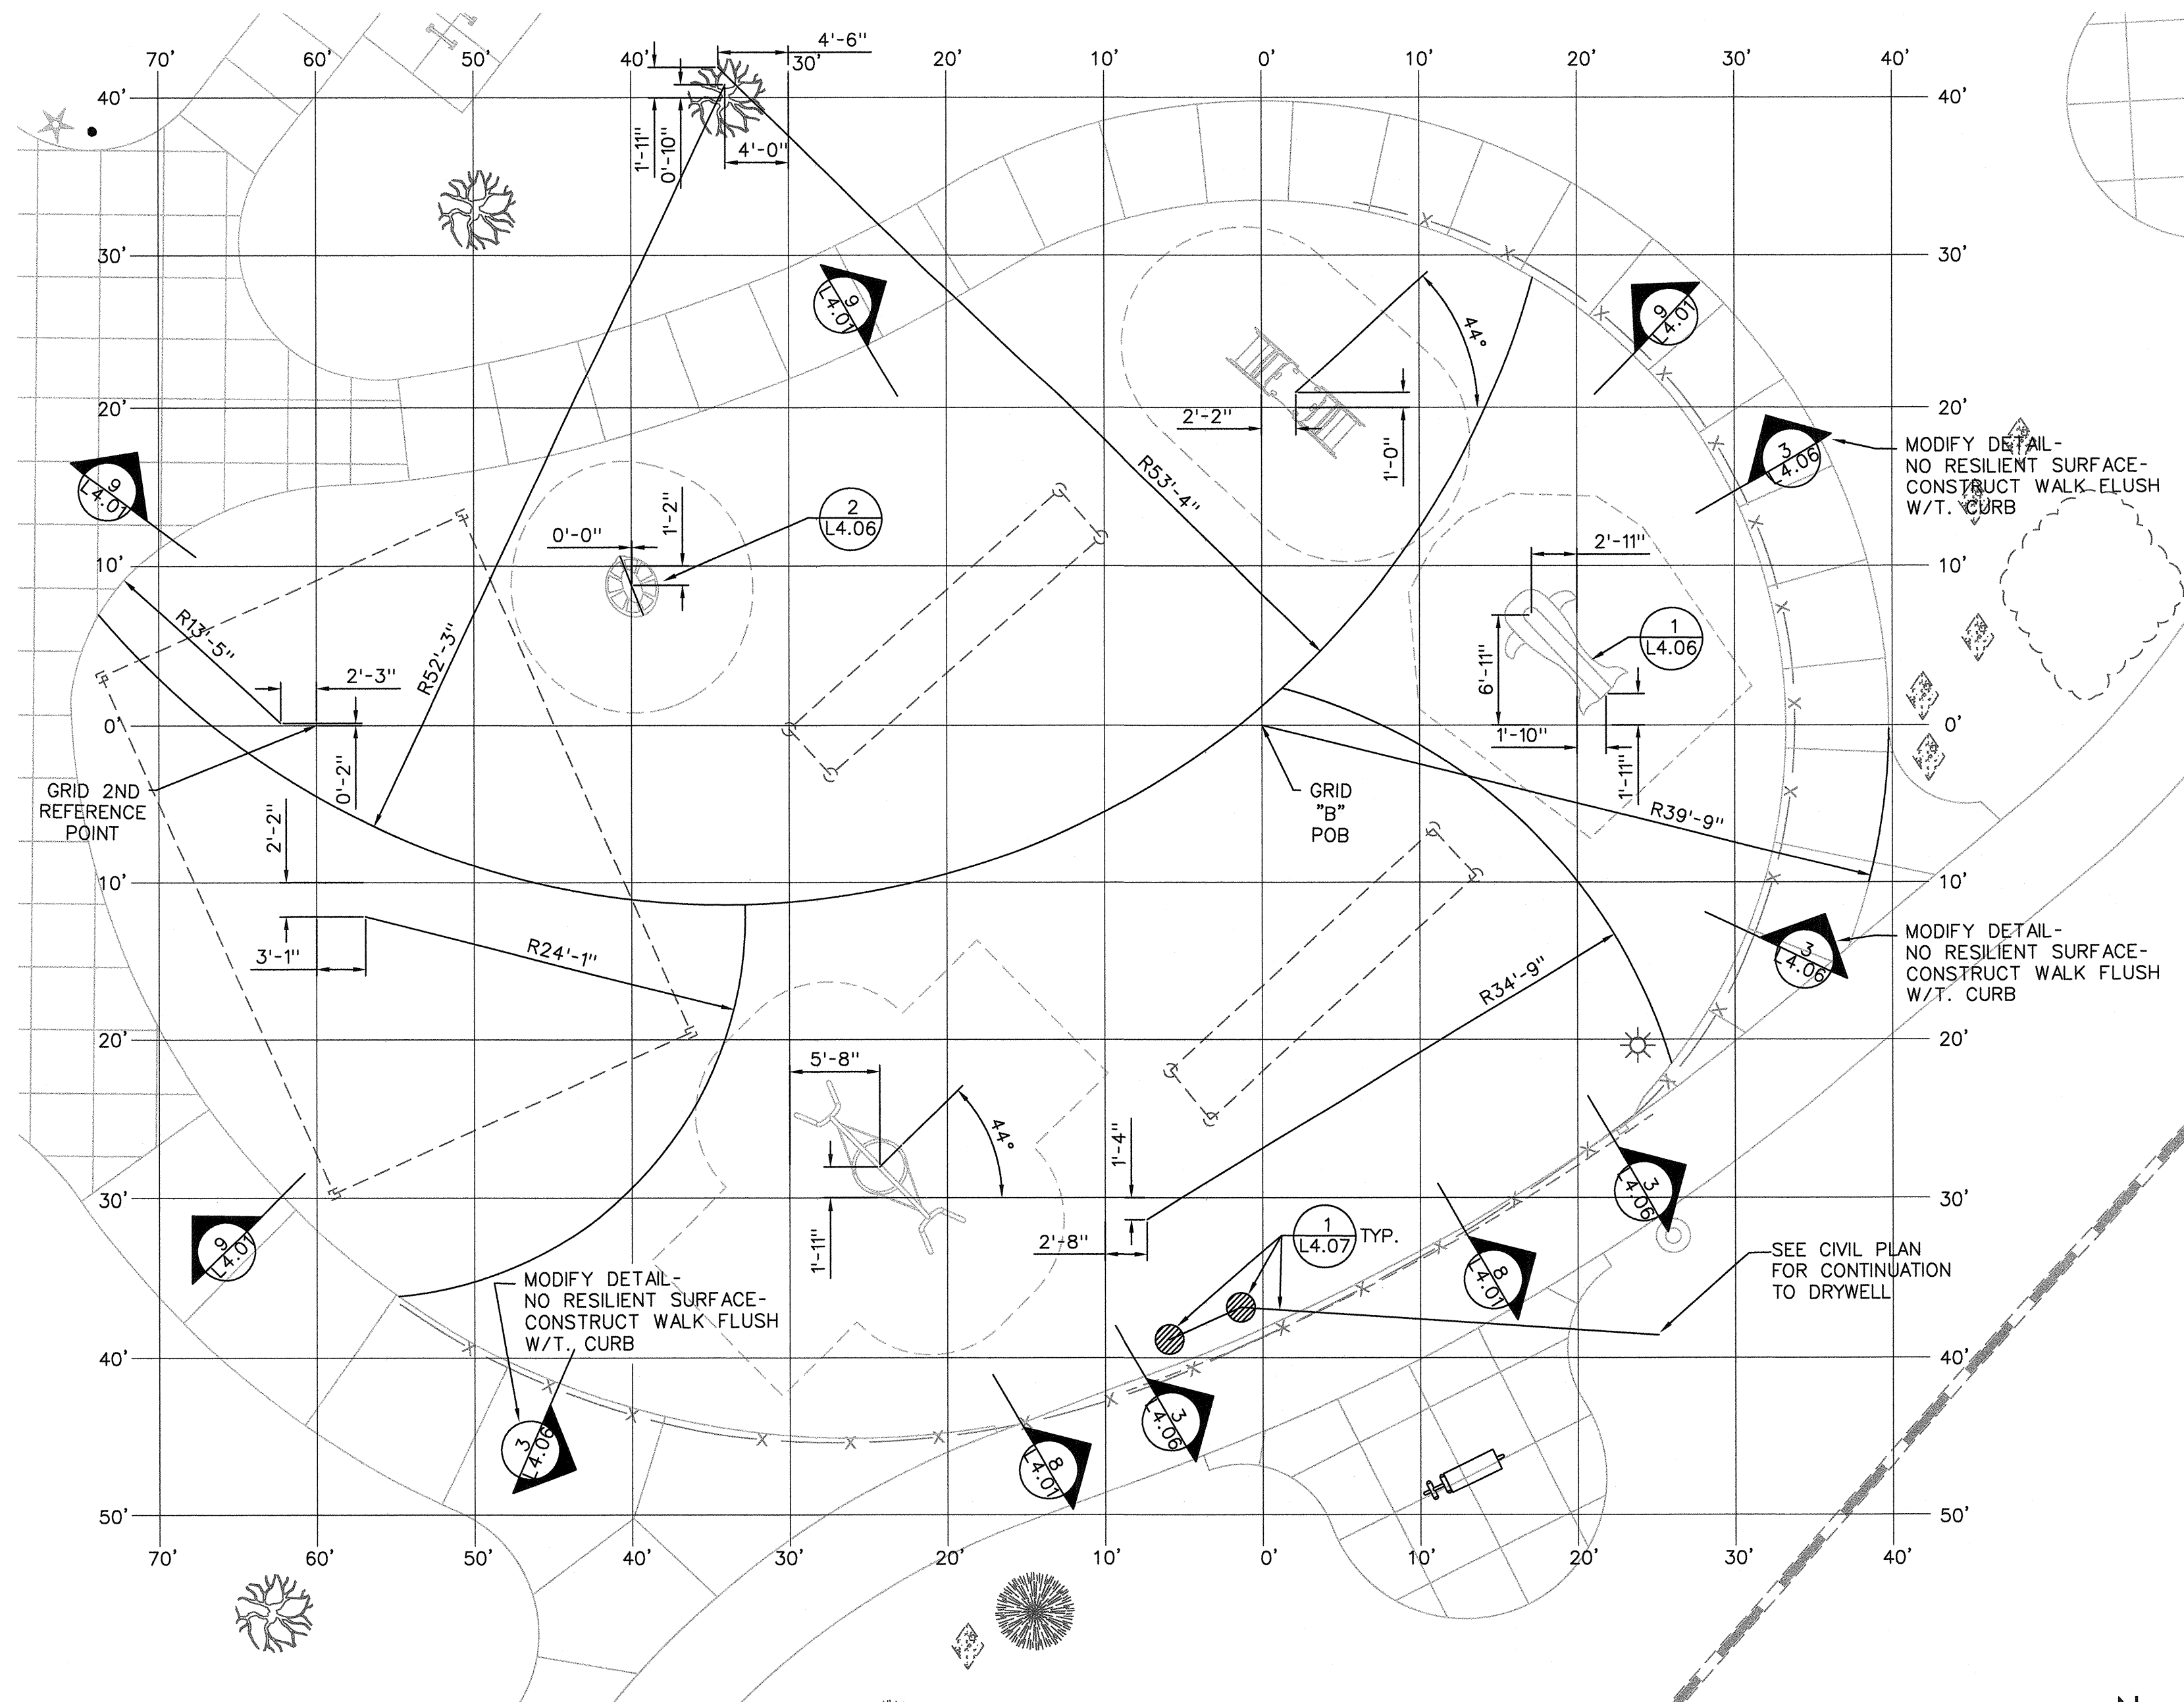

2 EXISTING PLAYGROUND: EQUIPMENT AND SURFACING LAYOUT

1/8" = 1'-0"

0 8' 12' 16'

N

PLAY AREA LAYOUT NOTES

- LAYOUT INFORMATION IS BASED ON A 10-FT X 10-FT GRID WITH ITS BASELINE DETERMINED BY A RADIUS POINT OF THE ADJACENT CONCRETE PAVEMENT THAT IS TIED TO THE HORIZONTAL CONTROL SHOWN ON THE CIVIL PLANS. IF EQUIPMENT IS TO BE FIELD SURVEY LOCATED, A CAD FILE OF THIS PLAN CAN BE MADE AVAILABLE AFTER AWARD OF CONTRACT. A RELEASE OF LIABILITY FOR CAD FILE WILL BE REQUIRED TO BE SIGNED BEFORE ITS RELEASE.
- GRID LAYOUT IS BASED ON A N 0'-0"-0" E AXIS.
- LAYOUT ALL EQUIPMENT AND SURFACE PATTERNING IN THE FIELD USING LABELED SURVEY STAKES AND PAINT FOR REVIEW BY CITY. ADJUST EQUIPMENT AND/OR PATTERN EDGE LOCATIONS AS DIRECTED BY THE CITY AS NEEDED.
- SUBMITTALS AND SHOP DRAWINGS ARE REQUIRED FOR ALL SURFACING MATERIALS AND PLAY EQUIPMENT INCLUDING SAFETY ZONES FOR REVIEW.
- SEE SPECIFICATIONS FOR ALL WORK ASSOCIATED WITH THIS PROJECT.
- SEE OTHER DRAWINGS IN THIS PLAN SET FOR DEMOLITION, SITE WORK, GRADING, HORIZONTAL CONTROL, UTILITIES, ELECTRICAL AND SITE DETAILS FOR CONSTRUCTION OF PLAY AREA IMPROVEMENTS.



REVISIONS


CONSULTANT



3010 W. CHARLESTON BLVD., SUITE 100
LAS VEGAS, NV 89102-1169 P: (702) 878-8010
www.stantec.com

BOB BASKIN PARK
RENOVATION

PLAYGROUND LAYOUT PLAN

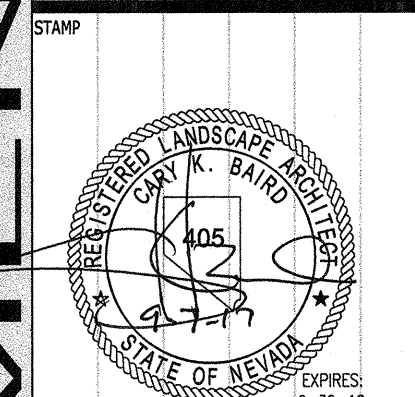

OWNER: CITY OF LAS VEGAS
DEPARTMENT OF PUBLIC WORKS
ARCHITECTURAL SERVICES

DEVELOPMENT SERVICES CENTER
333 N. RANCHO DRIVE
LAS VEGAS, NEVADA 89108
PHONE: (702) 225-6275
FAX: (702) 384-4846

DRAWN	LR
FILE	180101443
DATE	9/7/2017
SCALE	SEE PLAN
BID NO	17.54875.JH
CLV DWG NO	640.27-7
Hansen 54875	
SHT NO	

L2.04