 


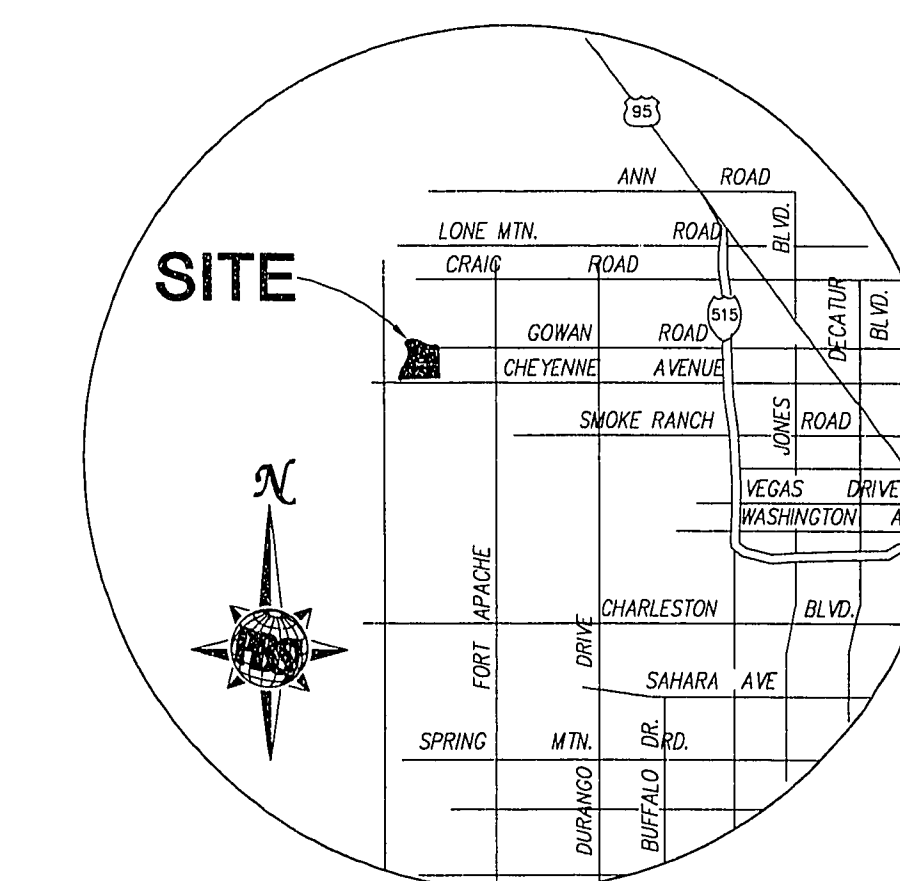


Call before you Dig
1-800-227-2600

GRAPHIC SCALE

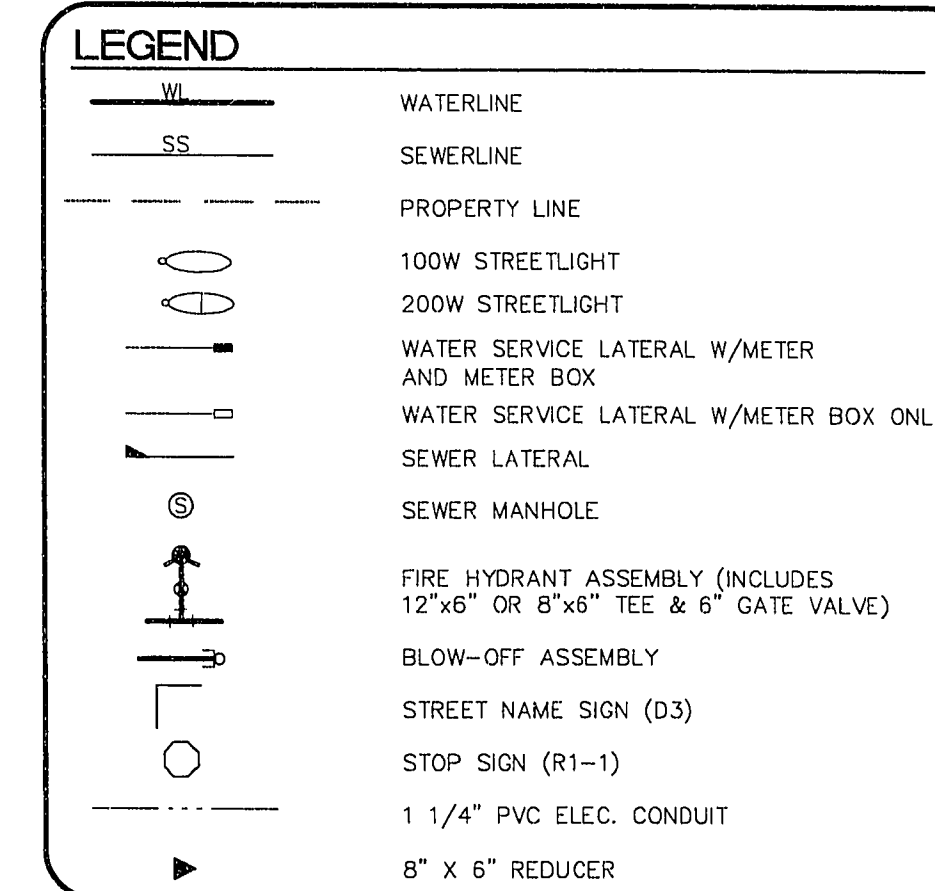


1 inch = 40 ft.

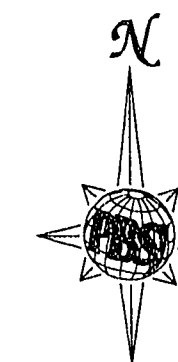

VICINITY MAP

NOT TO SCALE

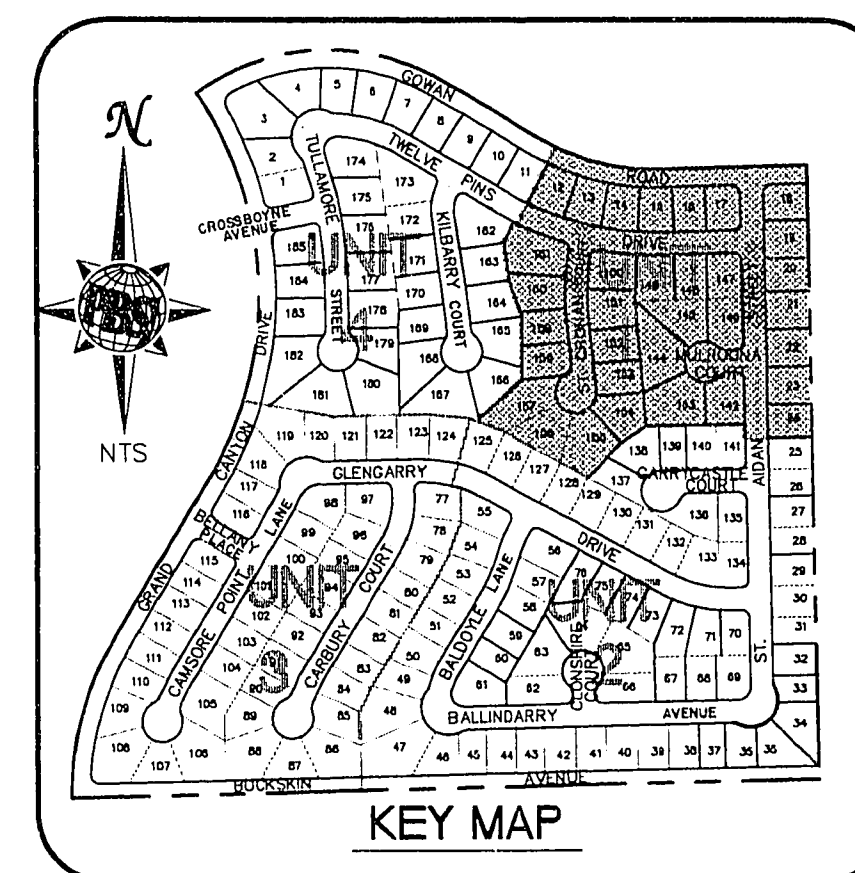


SEE SHEET 8 FOR UTILITY NOTES

FIRE FLOW INFORMATION - C.L.V. FIRE DEPARTMENT

THE FIRE FLOW REQUIREMENT IS 1500 GPM AT 20 PSI RESIDUAL PRESSURE. THIS REQUIREMENT IS BASED UPON SQUARE FOOTAGE FOR TYPE V NR CONSTRUCTION. THE FLOW INDICATED IS THE MINIMUM ALLOWED BY C.L.V.F.D. FOR SINGLE FAMILY RESIDENTIAL CONSTRUCTION. 2958 MAXIMUM VPM 6.0-94

****SEWER NOTE****
PROVIDE LATERAL FOR FUTURE LOTS 9-11 AND 25 AS SHOWN. THE EXACT LOCATION OF LATERALS TO FUTURE LOTS SHALL BE RECORDED BY THE CONTRACTOR. A COPY OF THE FIELD NOTES SHALL BE FURNISHED TO THE ENGINEER AFTER CONSTRUCTION.

DRIVEWAY LOCATIONS SHOWN ARE GRAPHIC REPRESENTATIONS ONLY. DIMENSIONS AND LOCATIONS SHALL BE VERIFIED BY THE CONTRACTOR PRIOR TO CONSTRUCTION.

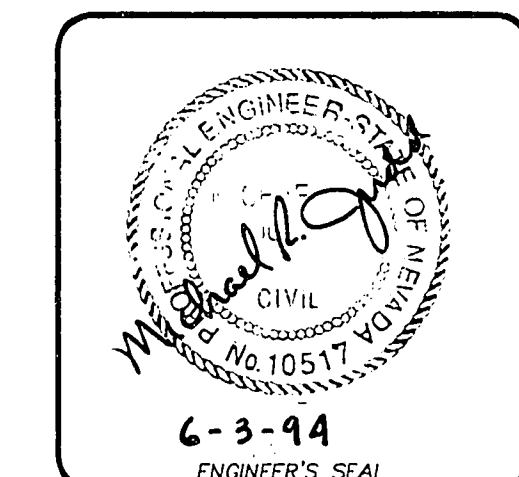


ESTIMATED WATER QUANTITIES (UNIT 1)


10" WATERLINE	331 LF
8" WATERLINE	5777 LF
6" WATERLINE	545 LF
FIRE HYDRANT	7 EA
8" GATE VALVE	19 EA
3/4" WATER SERVICE LATERAL WITH METER BOX	95 EA
3/4" METER (FROM L.V.V.D.)	33 EA
2" BLOW-OFF ASSEMBLY	7 EA
10" PRESSURE REDUCING ASSEMBLY	1 EA

J. Schuch
C.V.F.D.
6/6/94
DATE


[Signature]
L.V.V.D.
4/23/94
DATE

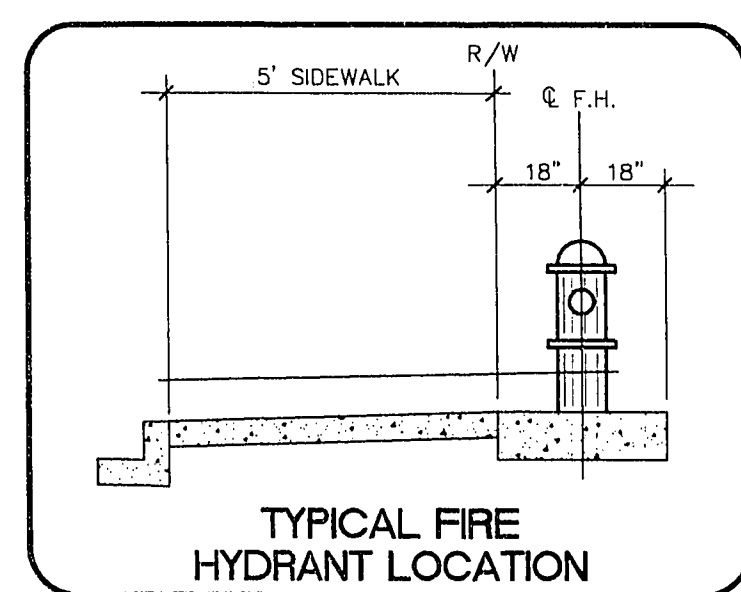

TYPICAL FIRE HYDRANT LOCATION

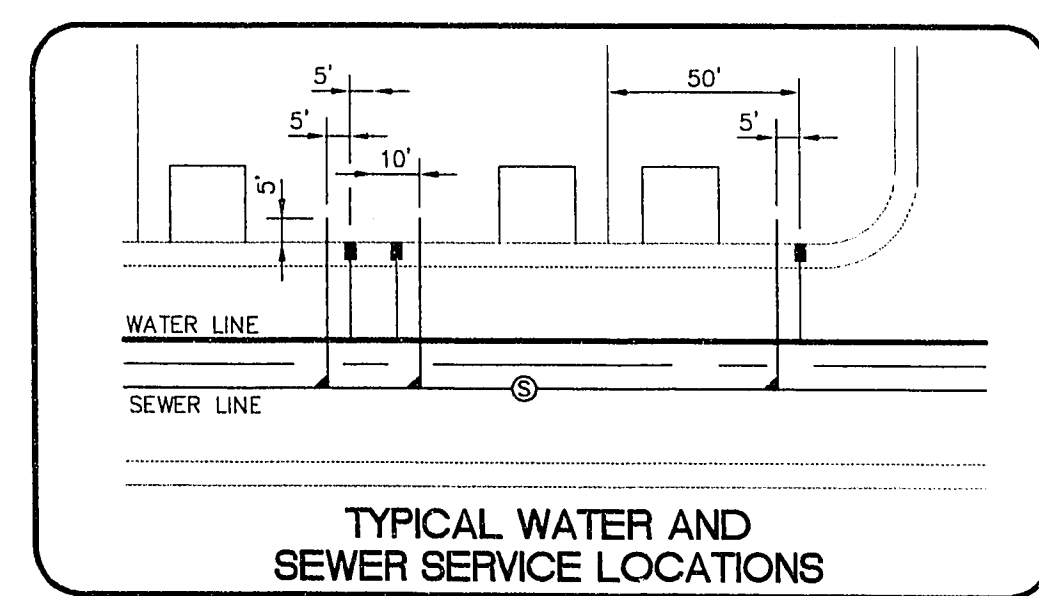

TYPICAL WATER AND SEWER SERVICE LOCATIONS

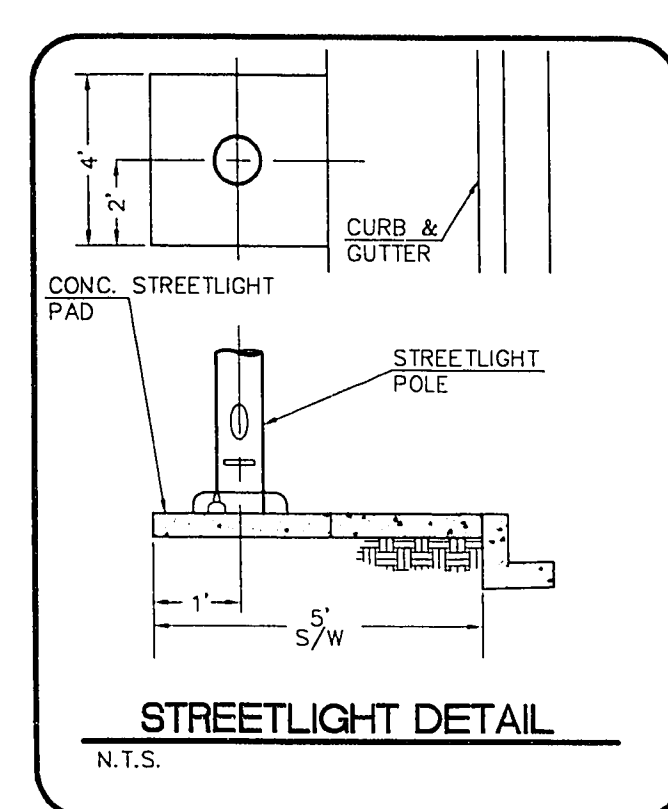

STREETLIGHT DETAIL
N.T.S.

Job Number 7225.590	Drawn by J.T.I.	Scale 1"=40'	PHASE 1 – UNIT 1 UTILITY PLAN		 FALCON Falcon Development Corporation	 POST BUCKLEY SCHLUH & JERNIGAN 6600 West Charleston Blvd. Las Vegas, Nevada 89102 Phone: 702/678-0444 Fax: 702/678-7758	No.	REVISIONS	Date	Appr.	Date
Sheet Number 9 OF 36	Date MAY 13, 1994	File No. 590IMP									