
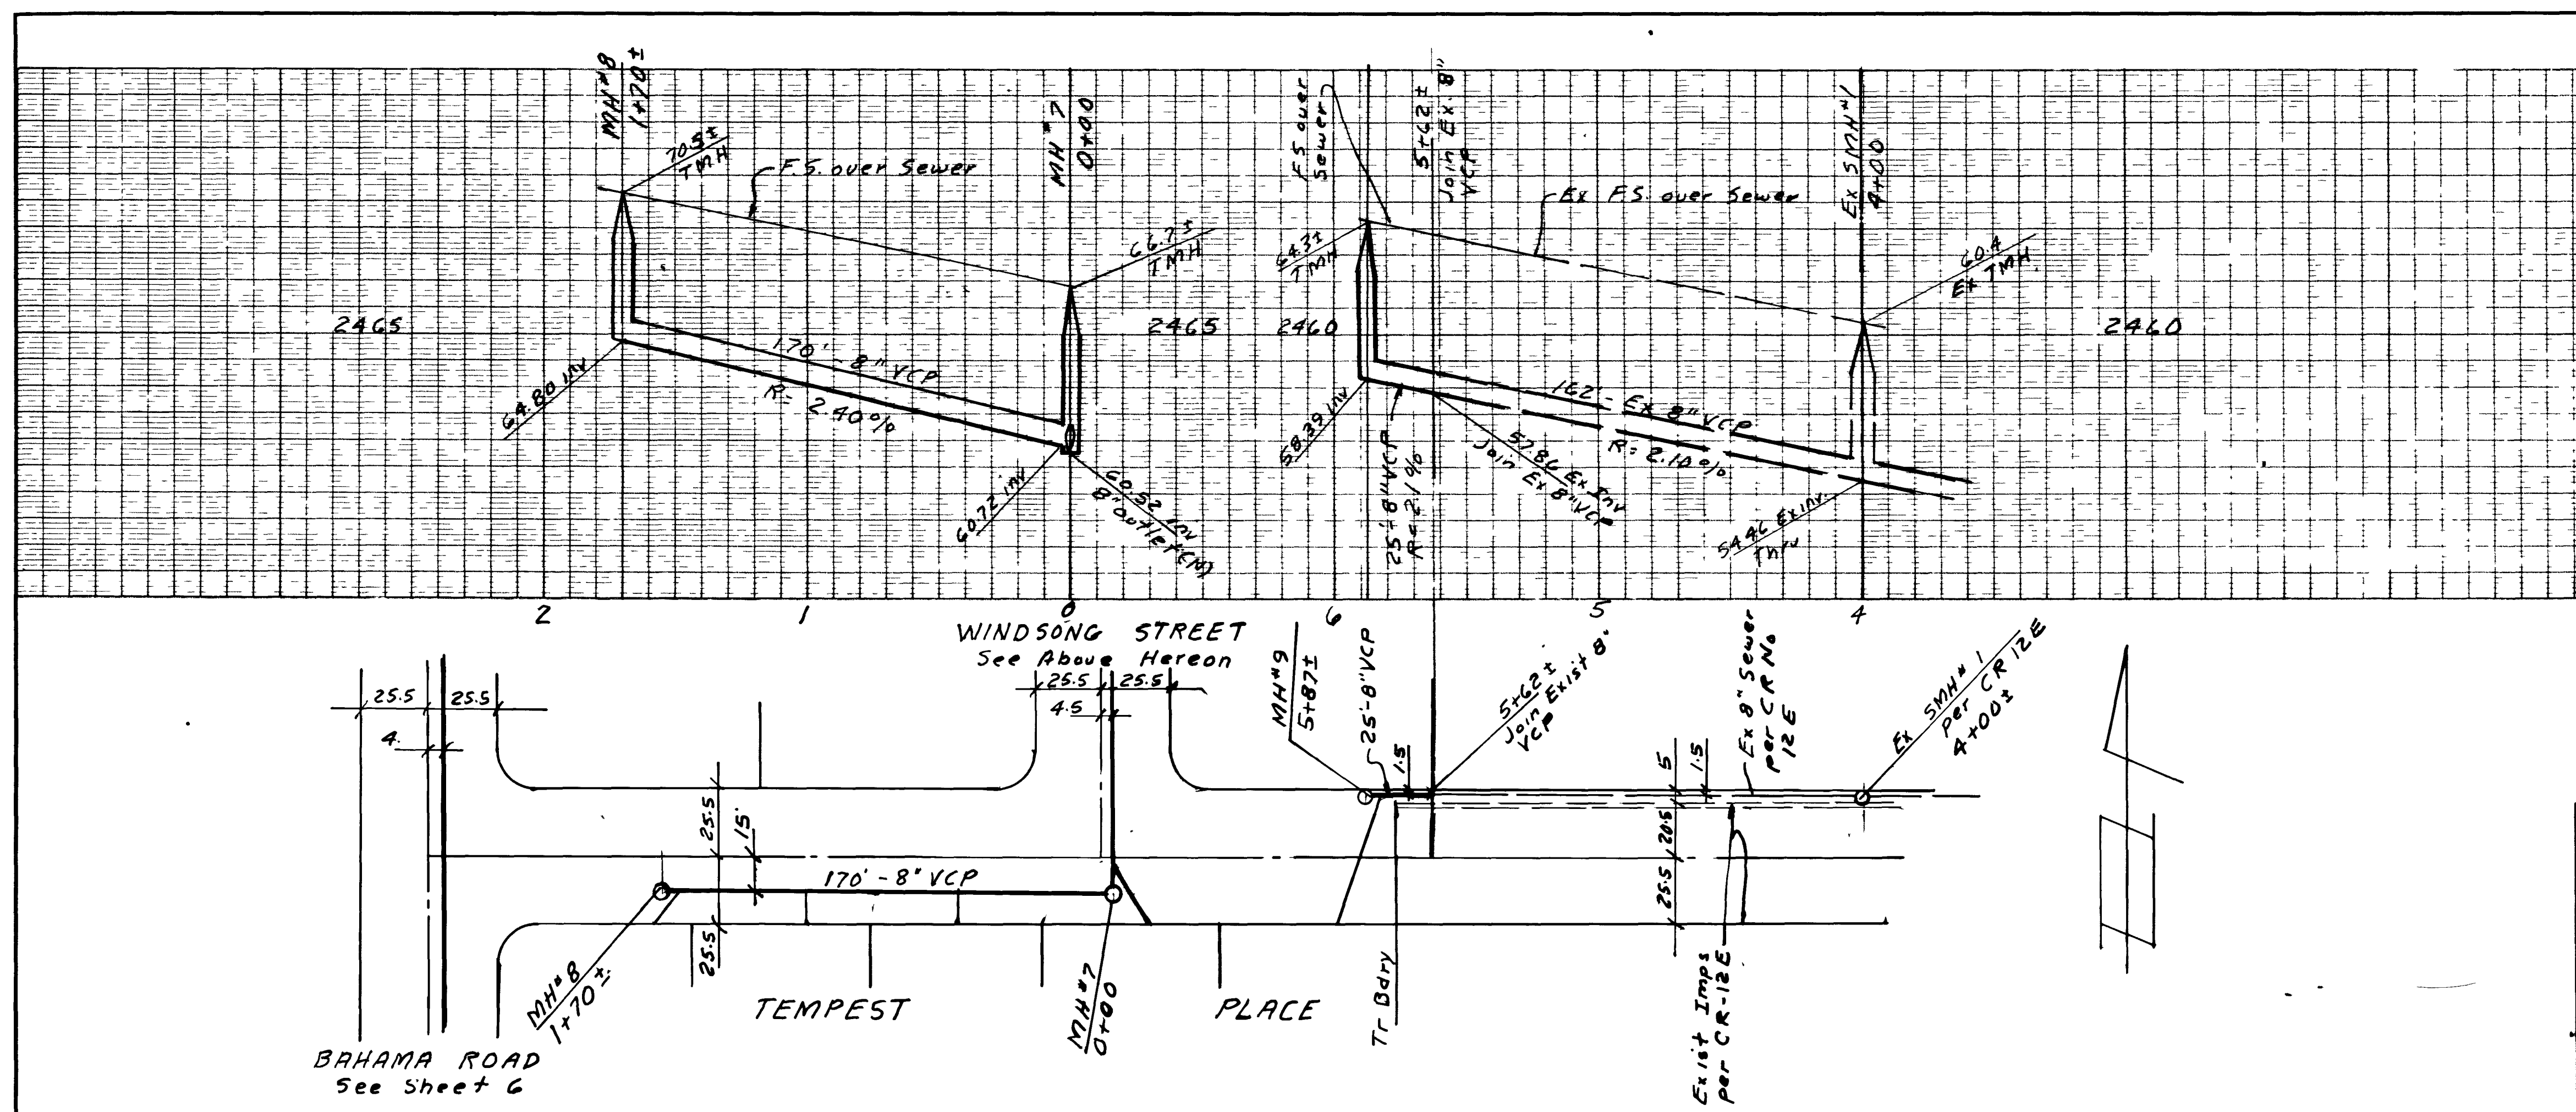


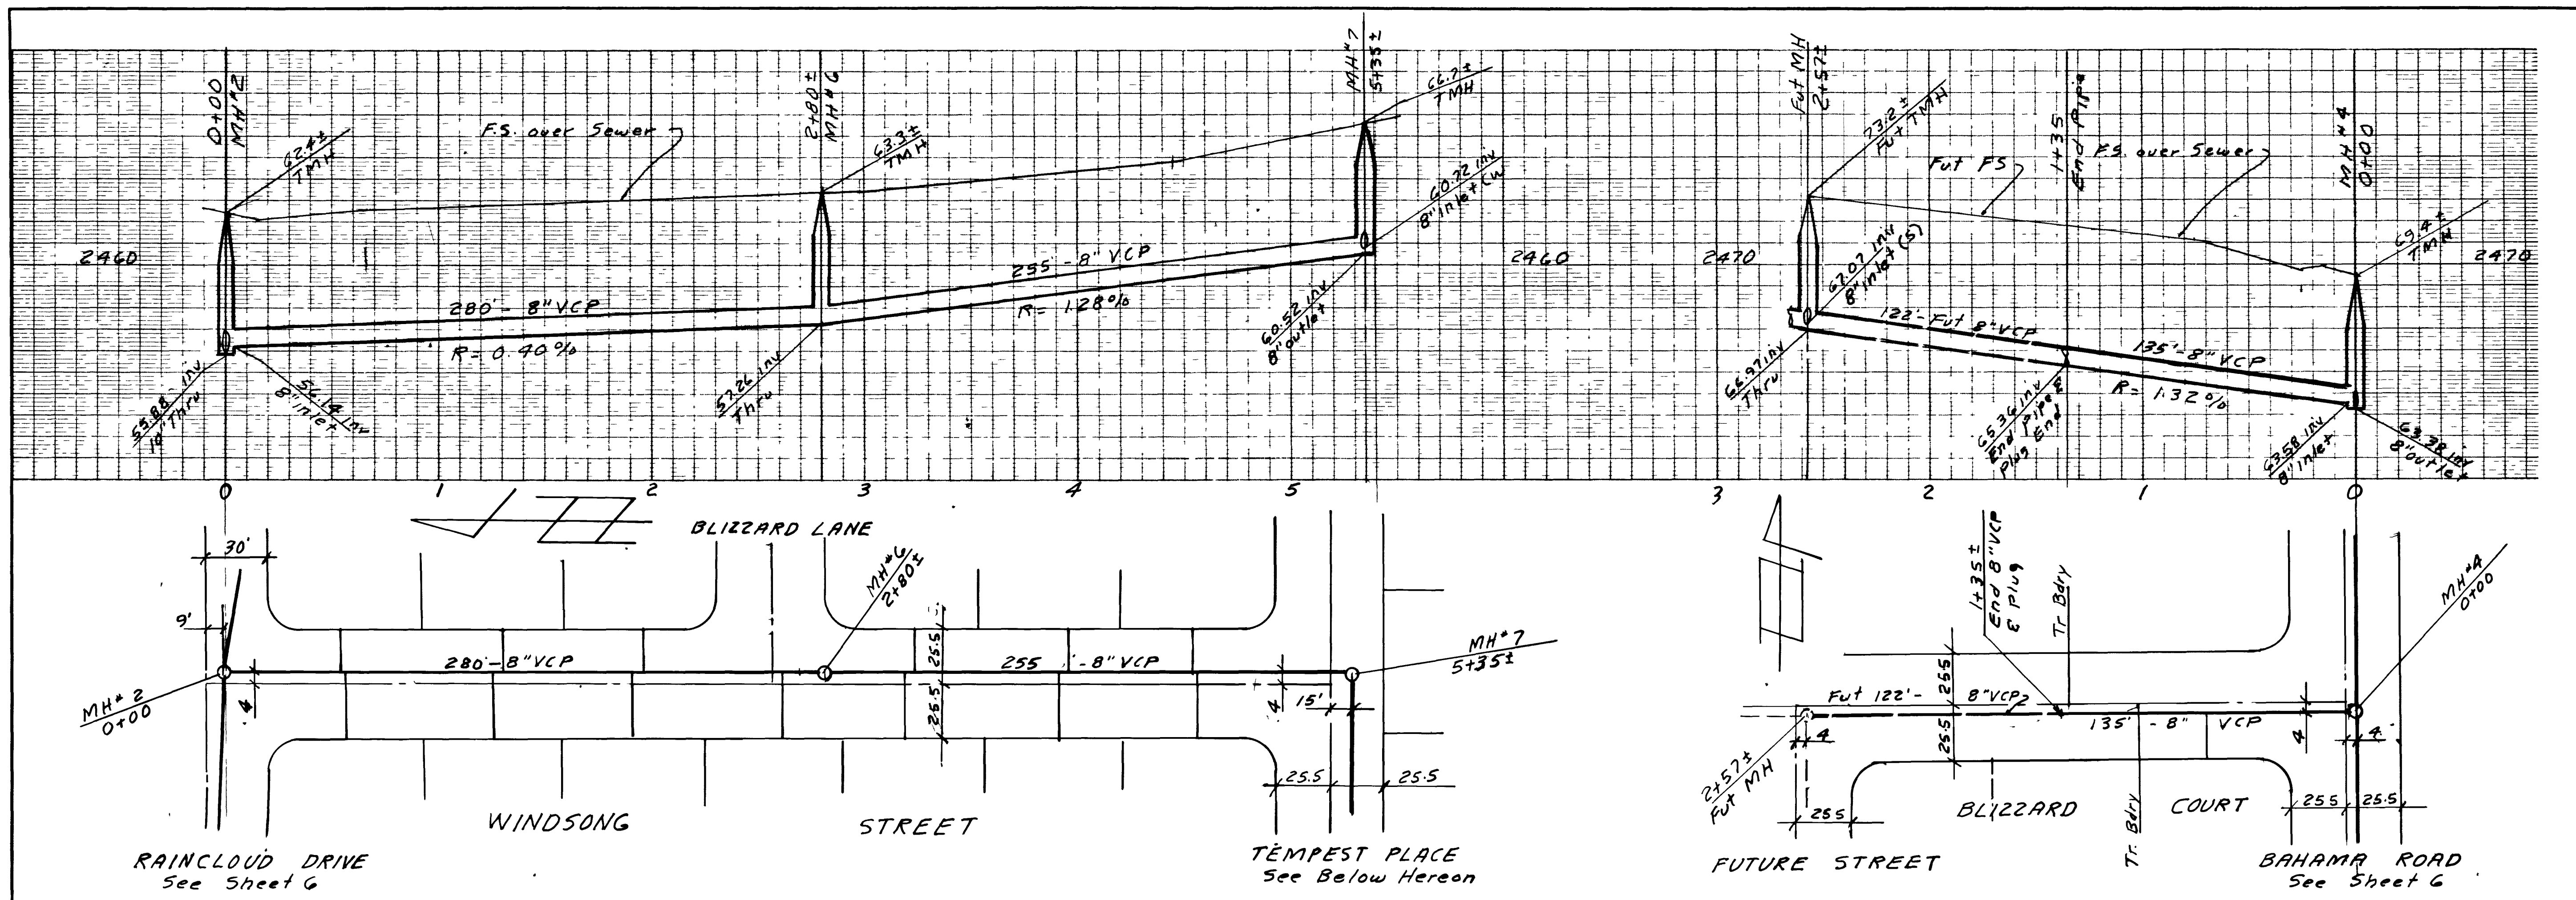



Approved By
William J. Harris 10/28/76
 Las Vegas City Engineer Date

C. J. Peterson 10-28-76
 Las Vegas Field Engineer Date

R. L. Carter 10-27-76
 City Sanitation Engineer Date

Submitted By
Charley R. Johnson 7/7/76
 Charley R. Johnson Date
 Nev Cert 3005

CONSULTING ENGINEERS • PLANNERS			
2209 PARADISE ROAD LAS VEGAS, NEVADA 89105			
(702) 735-0227			
CHARLESTON RAINBOW			
UNIT NO 14B			
SEWER PLAN AND PROFILE			
WINDSONG STREET - TEMPEST PLACE			
BLIZZARD COURT			
SCALE:	WO NO 1066-14B	DATE:	SHEET
HORIZ 1"=40'	DES.	REV.	7
VERT 1"=4'	CHK	REV.	9

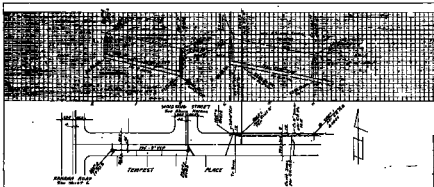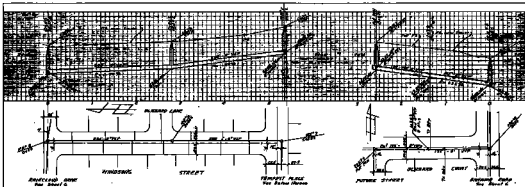

Examined by
William H. Brown
 City Engineer
 Date
 11-1-1918

Submitted by
Charles F. Brown
 City Engineer
 Date
 11-1-1918

V.M.		CORRECTION SHEET	
CHARLESTON		WEST VIRGINIA	
UNIT NO. 118		SECTION	
SOUND PLAY AND PEOPLE		INTERESTING STORIES - TEMPER PLACE	
BROADWAY STREET		BROADWAY STREET	
DATE	11-1-1918	NO.	1
TIME	7:20	NO.	2