

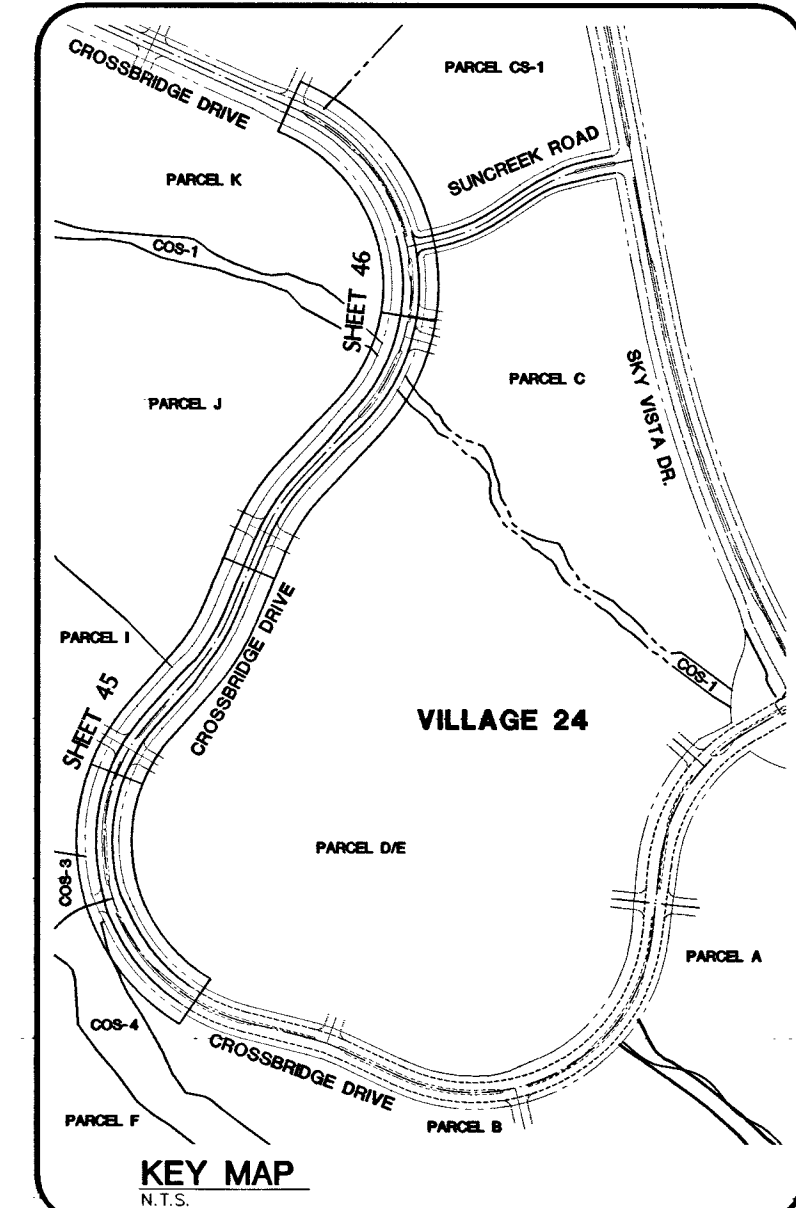
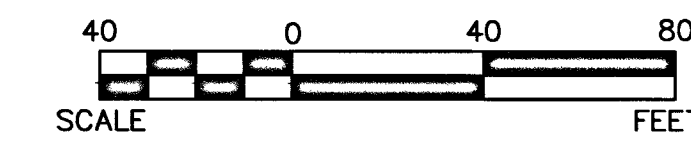
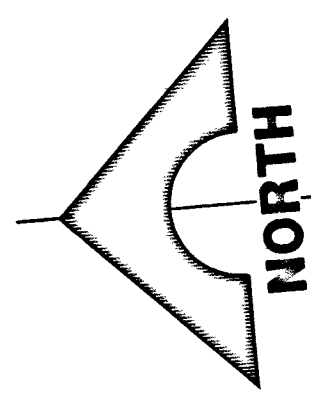


05/24/24.dwg 5/20/2024 JPB

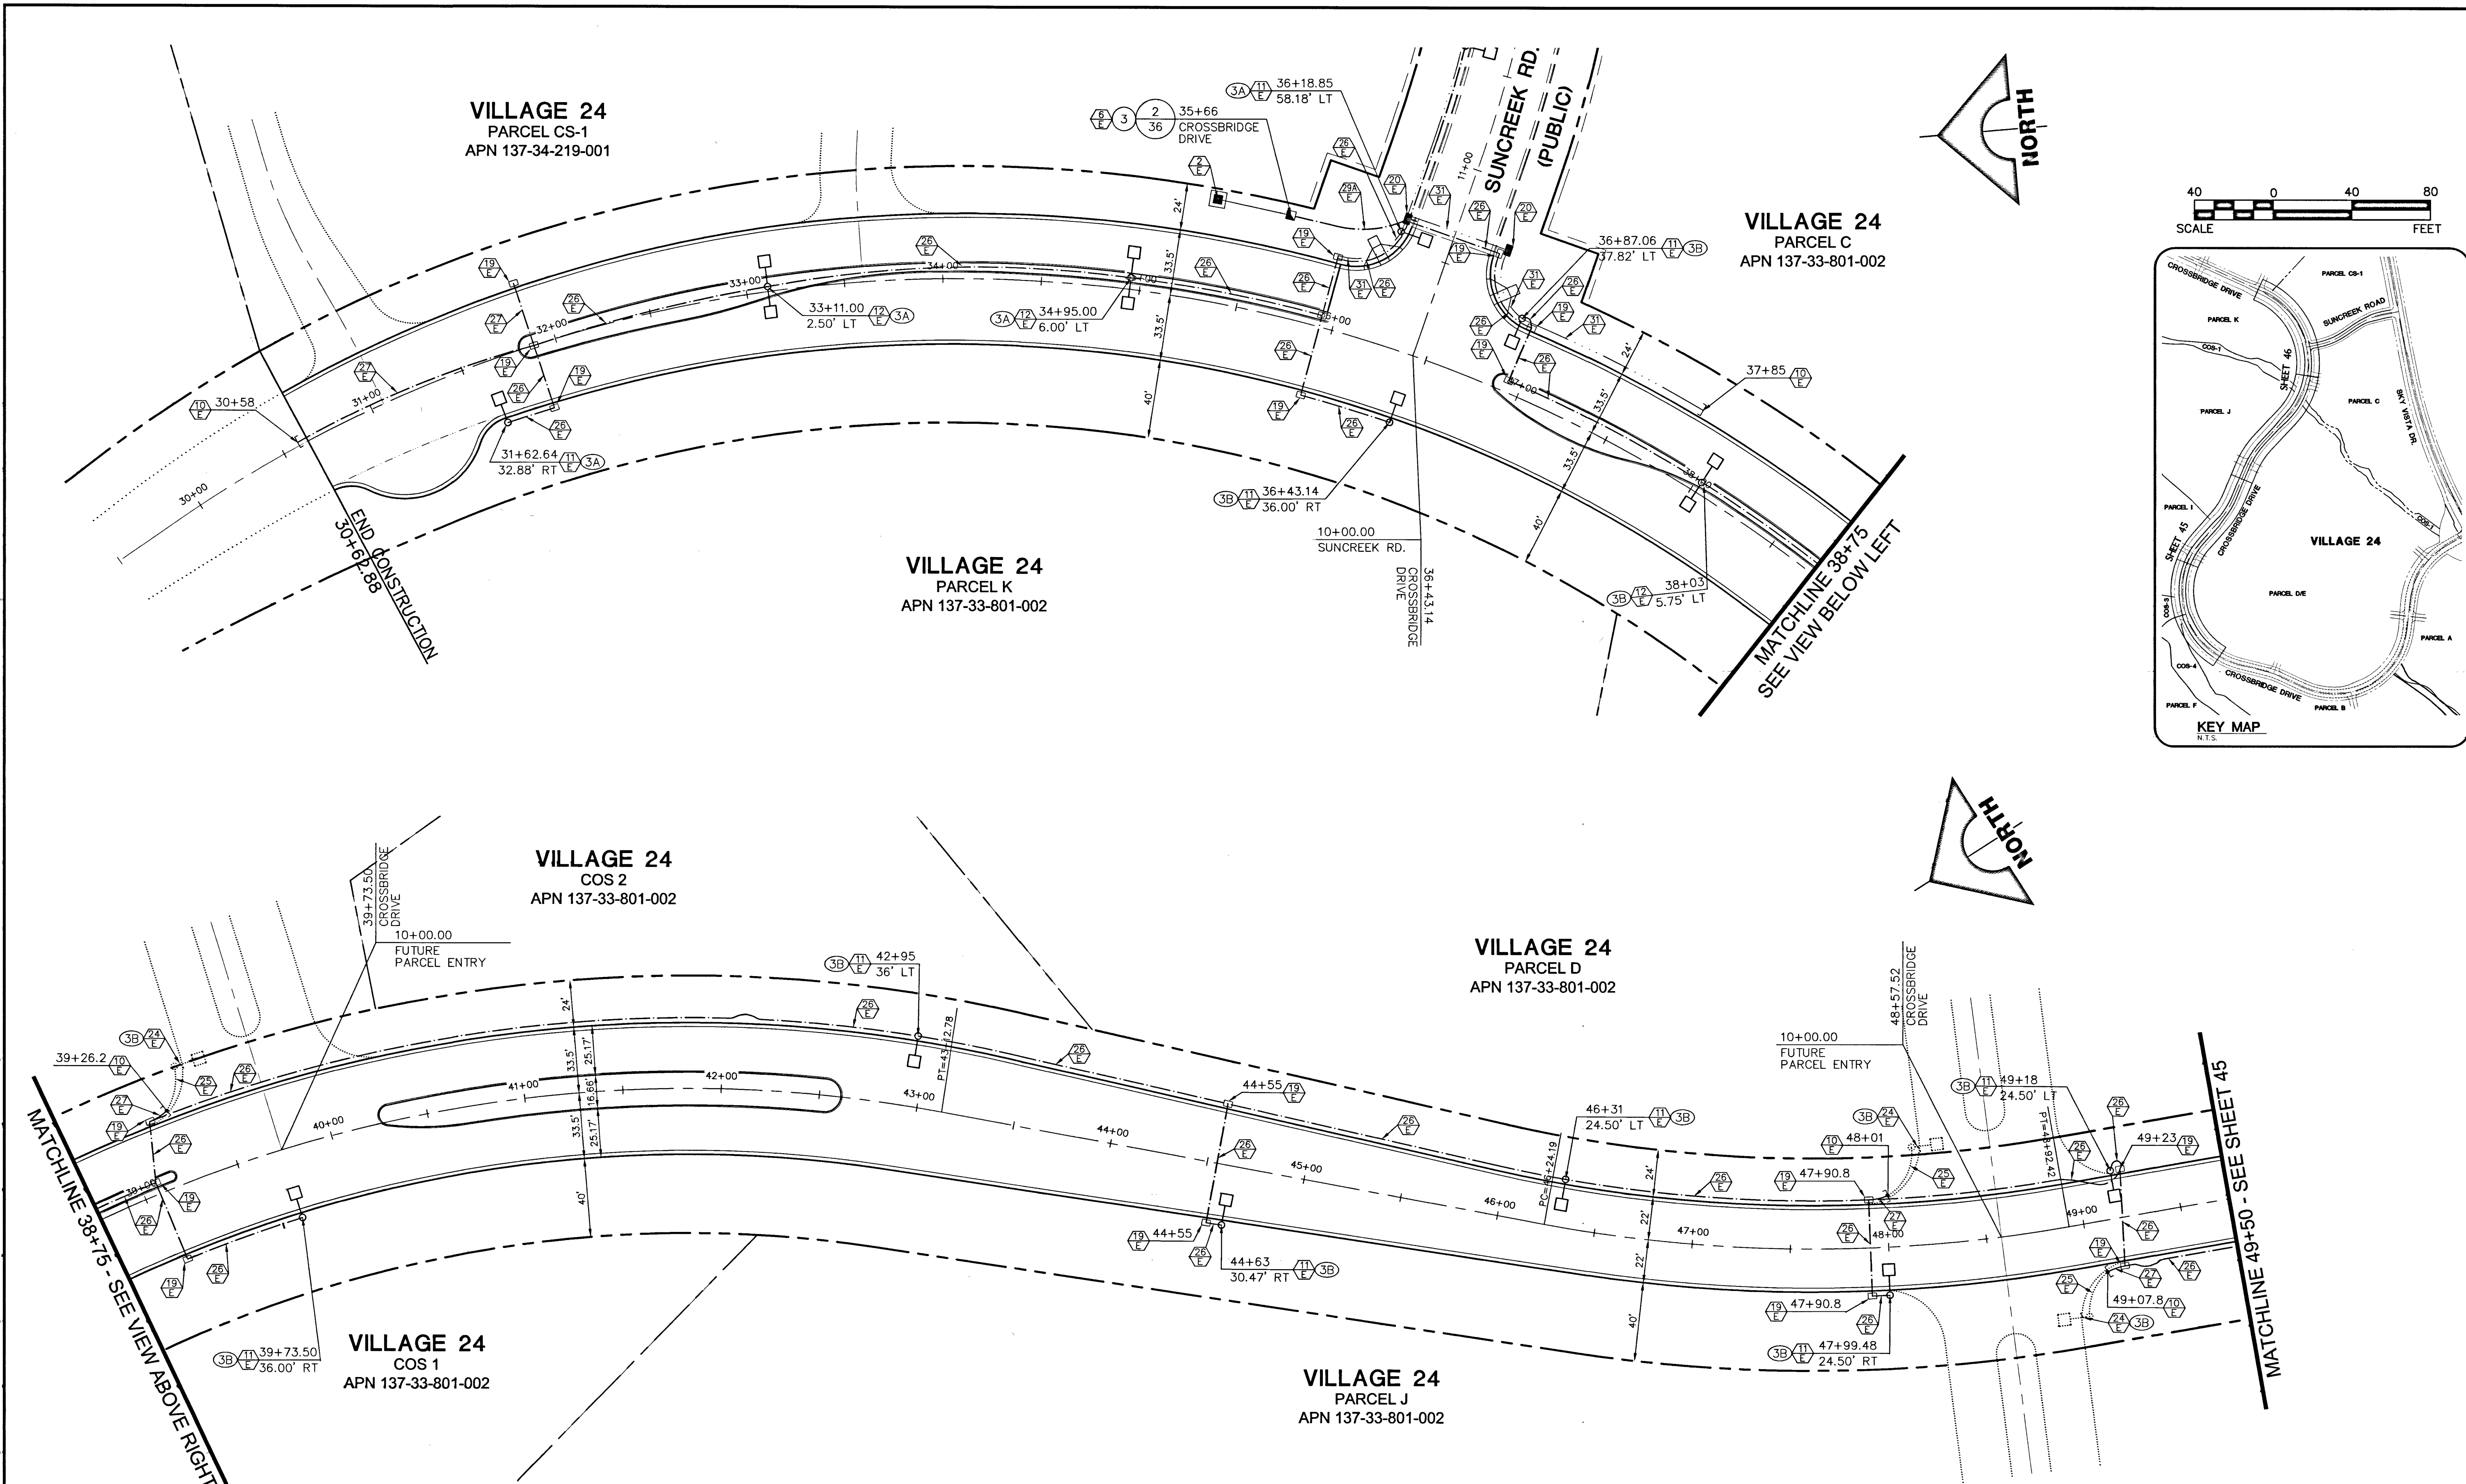

CROSSBRIDGE DRIVE (PUBLIC)

SCALE: 1"=40'

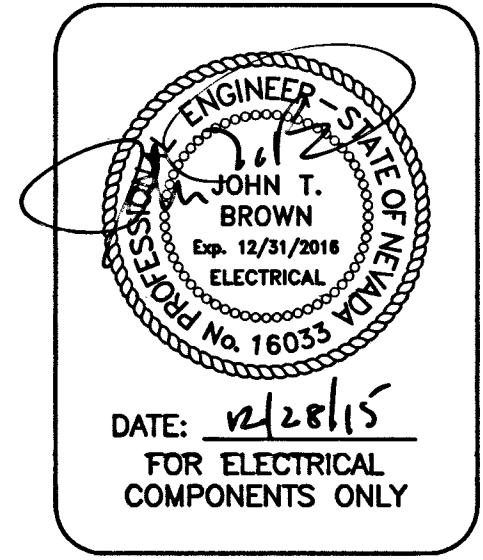

PROJECT NO. 62024-222	
DESIGN: GCW	GCW
DRAWN: GCW	JU
CHECK: JU	JU
PLOT DATE: 12-28-15	
PLOT TIME: 09:42:35	
F:\Projects\600\62024-222\DWG\Production\24CB24-46_E13.dwg	
Paul Bremard	
LAS VEGAS	
G.C. WALLACE COMPANIES ENGINEERS PLANNERS SURVEYORS 1555 S. RAINBOW BLVD., LAS VEGAS, NV 89146 T: 702.894.2000 F: 702.894.2299 GCWALLACE.COM	
THE HOWARD HUGHES COMPANY, LLC	
VILLAGE 24 - CROSSBRIDGE DRIVE UNIT 2 IMPROVEMENT PLANS	
CROSSBRIDGE DRIVE STREETLIGHT, MASTER CONDUIT AND ELECTRICAL PLAN 2	
DRAWING 46	
H462403	
107104535	
46 OF 53 SHTS	
SD NO. 812 PROJECT 9A, 9B AND 10A	