



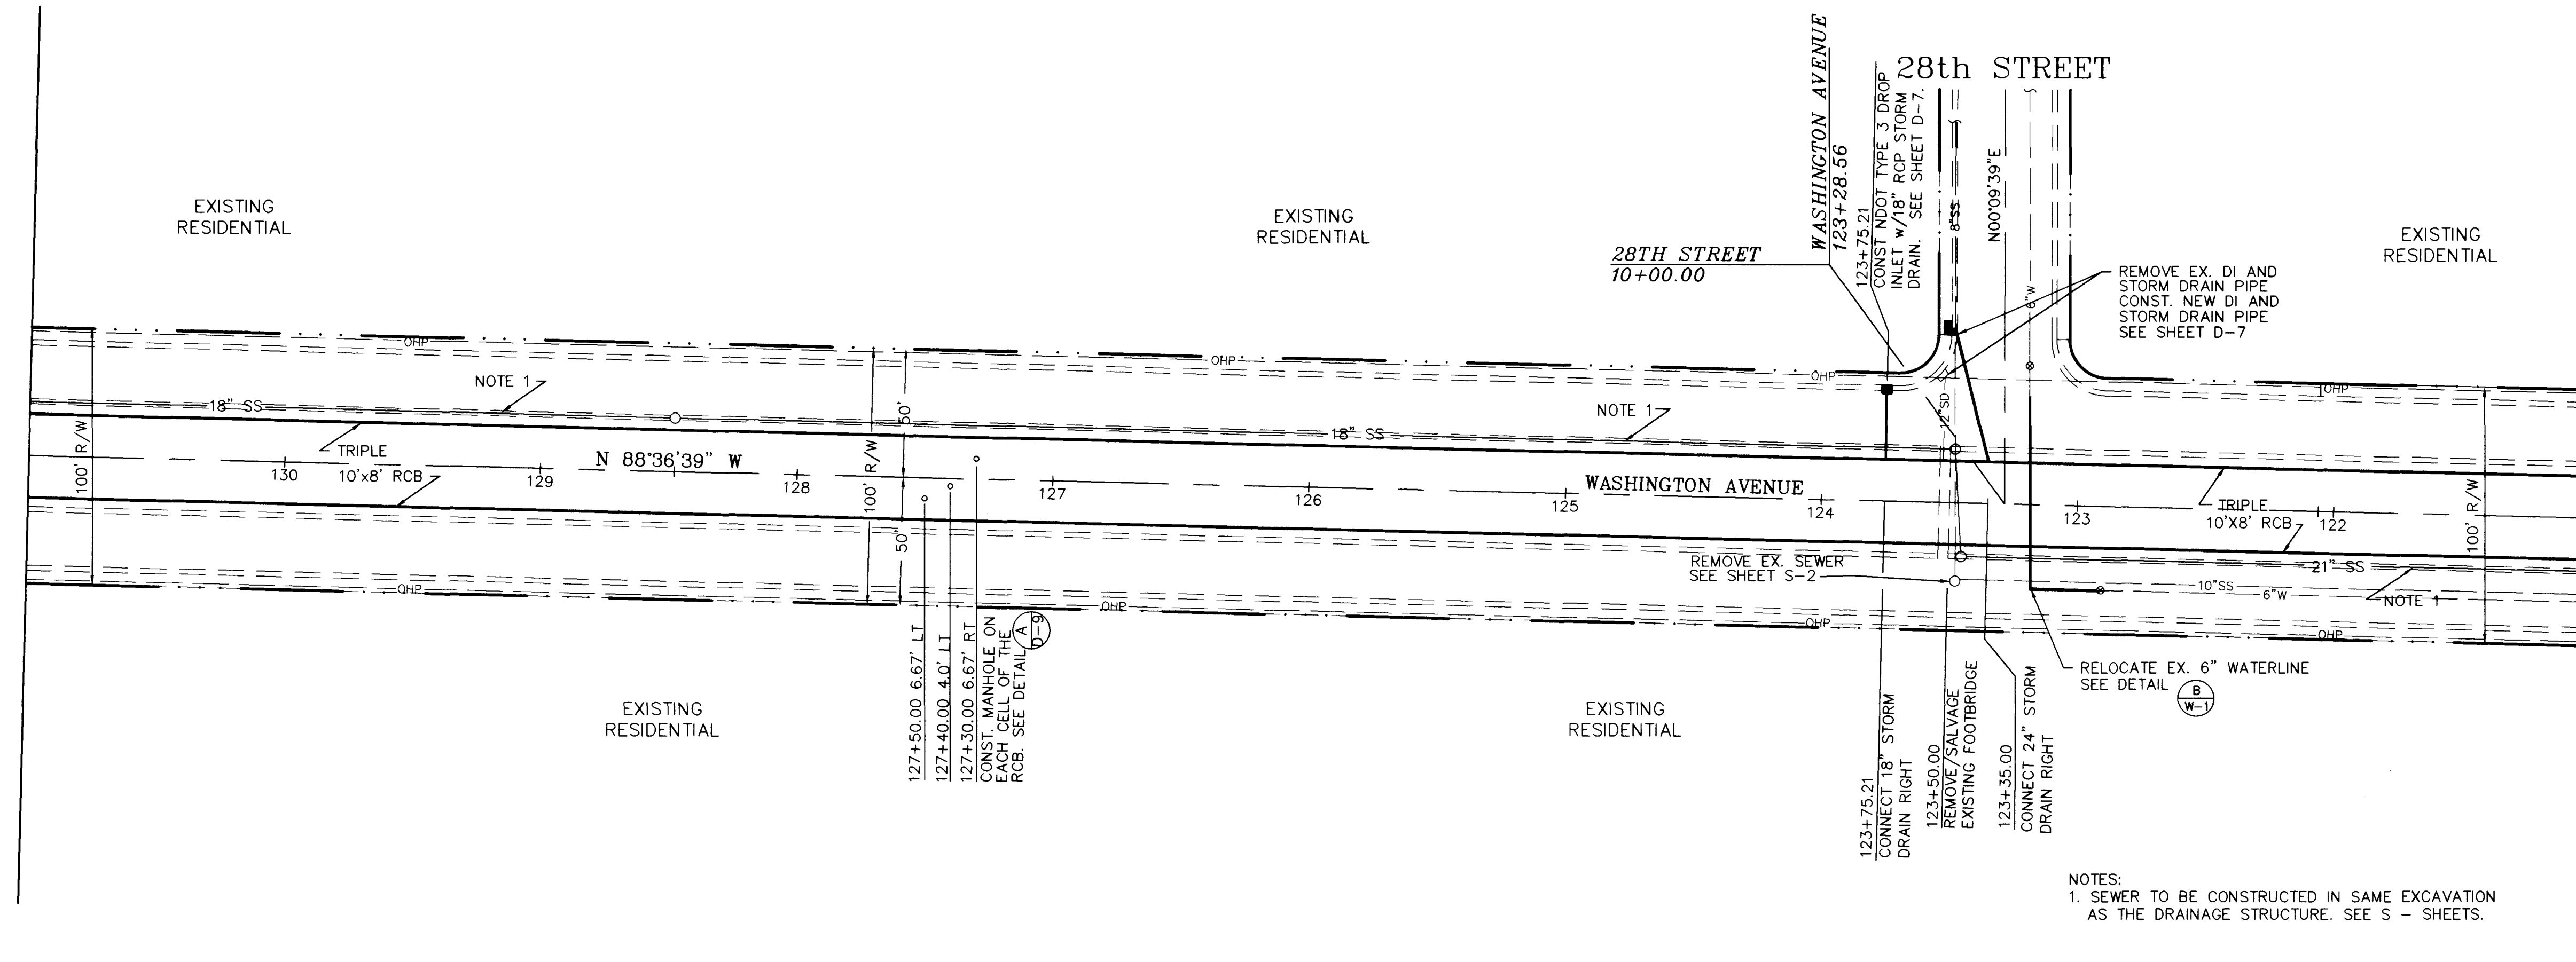


APPROVED: 1276 JB 6/14/94
LVVWD DATE

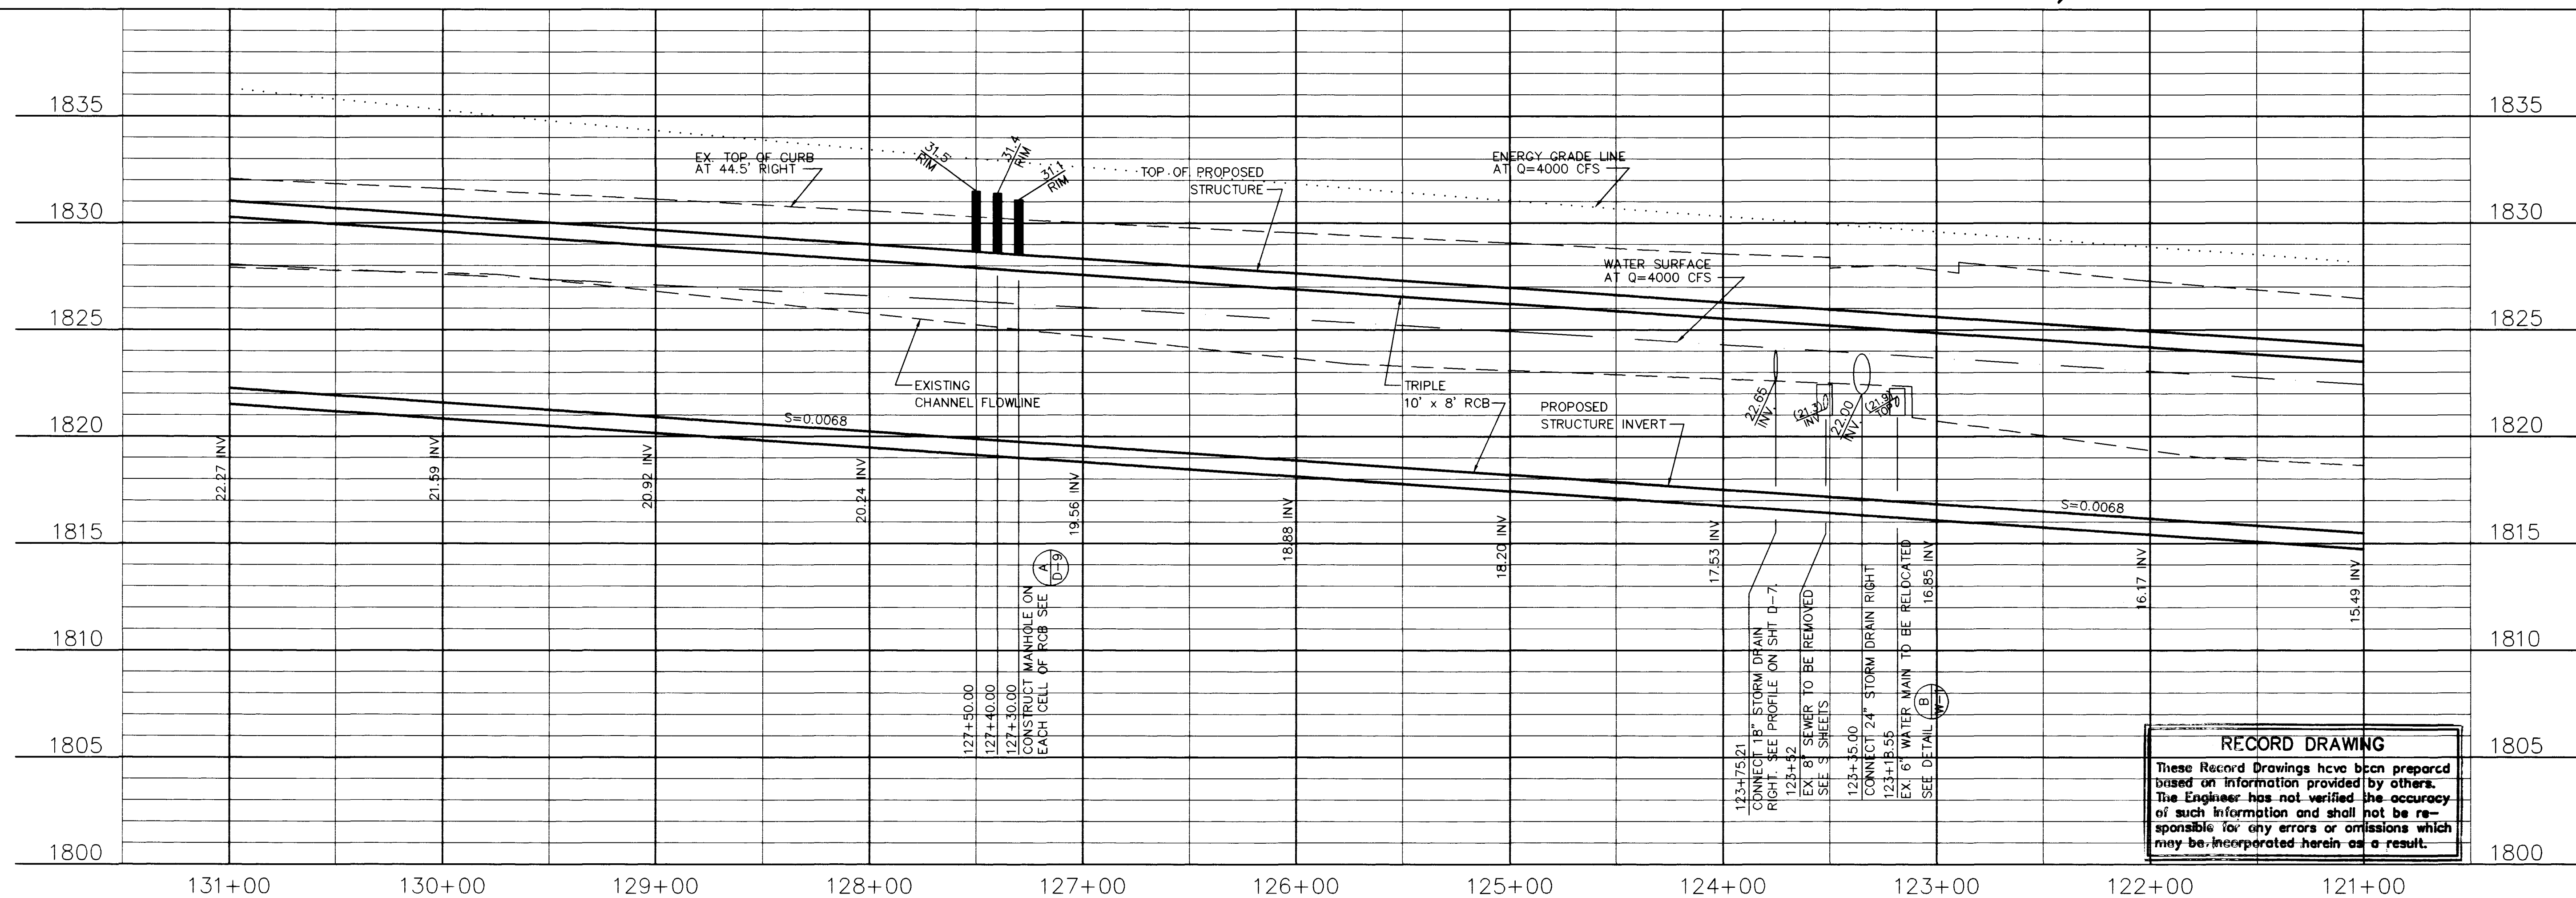

RECORD DRAWING	
These Record Drawings have been prepared based on information provided by others. The Engineer has not verified the accuracy of such information and shall not be responsible for any errors or omissions which may be incorporated herein as a result.	


PROJECT: CITY OF LAS VEGAS WASHINGTON AVENUE CONVEYANCE SYSTEM	DESCRIPTION: DRAINAGE STRUCTURE PLAN and PROFILE STA. 131+00 to 121+00	 1055 EAST TROPICANA SUITE 800 LAS VEGAS, NEVADA 89119 (702)798-1007	DESIGNED: RB/RB DRAWN: JH/JM CHECKED: RB JOB NO. 383-8-91 SCALE: HORIZ. f' = 40' VERT. f' = 4'		REVISIONS			
					No.	Date	CHD	APPD
SHEET D-2 5 OF 38								

MATCH LINE - STA. 121+00
SEE SHEET D-1

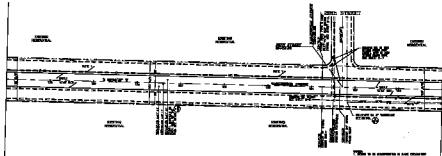

MATCH LINE - STA. 124+00
SEE SHEET D-2

THIS IS A PRELIMINARY PLAN
AND IS NOT TO BE USED FOR
CONSTRUCTION

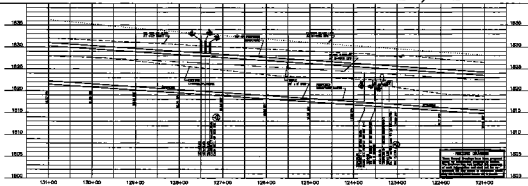

PROPOSED STRUCTURE
PROPOSED PAVEMENT
PROPOSED UTILITIES

CITY OF SAN DIEGO
ILLUSTRATING ARCHITECTURAL SYSTEM
ANALYSIS STRUCTURE PLAN AND PROFILE
STA. 121+00 TO 124+00

D-2