


APPROVED: LVVWD 6/14/99
DATE

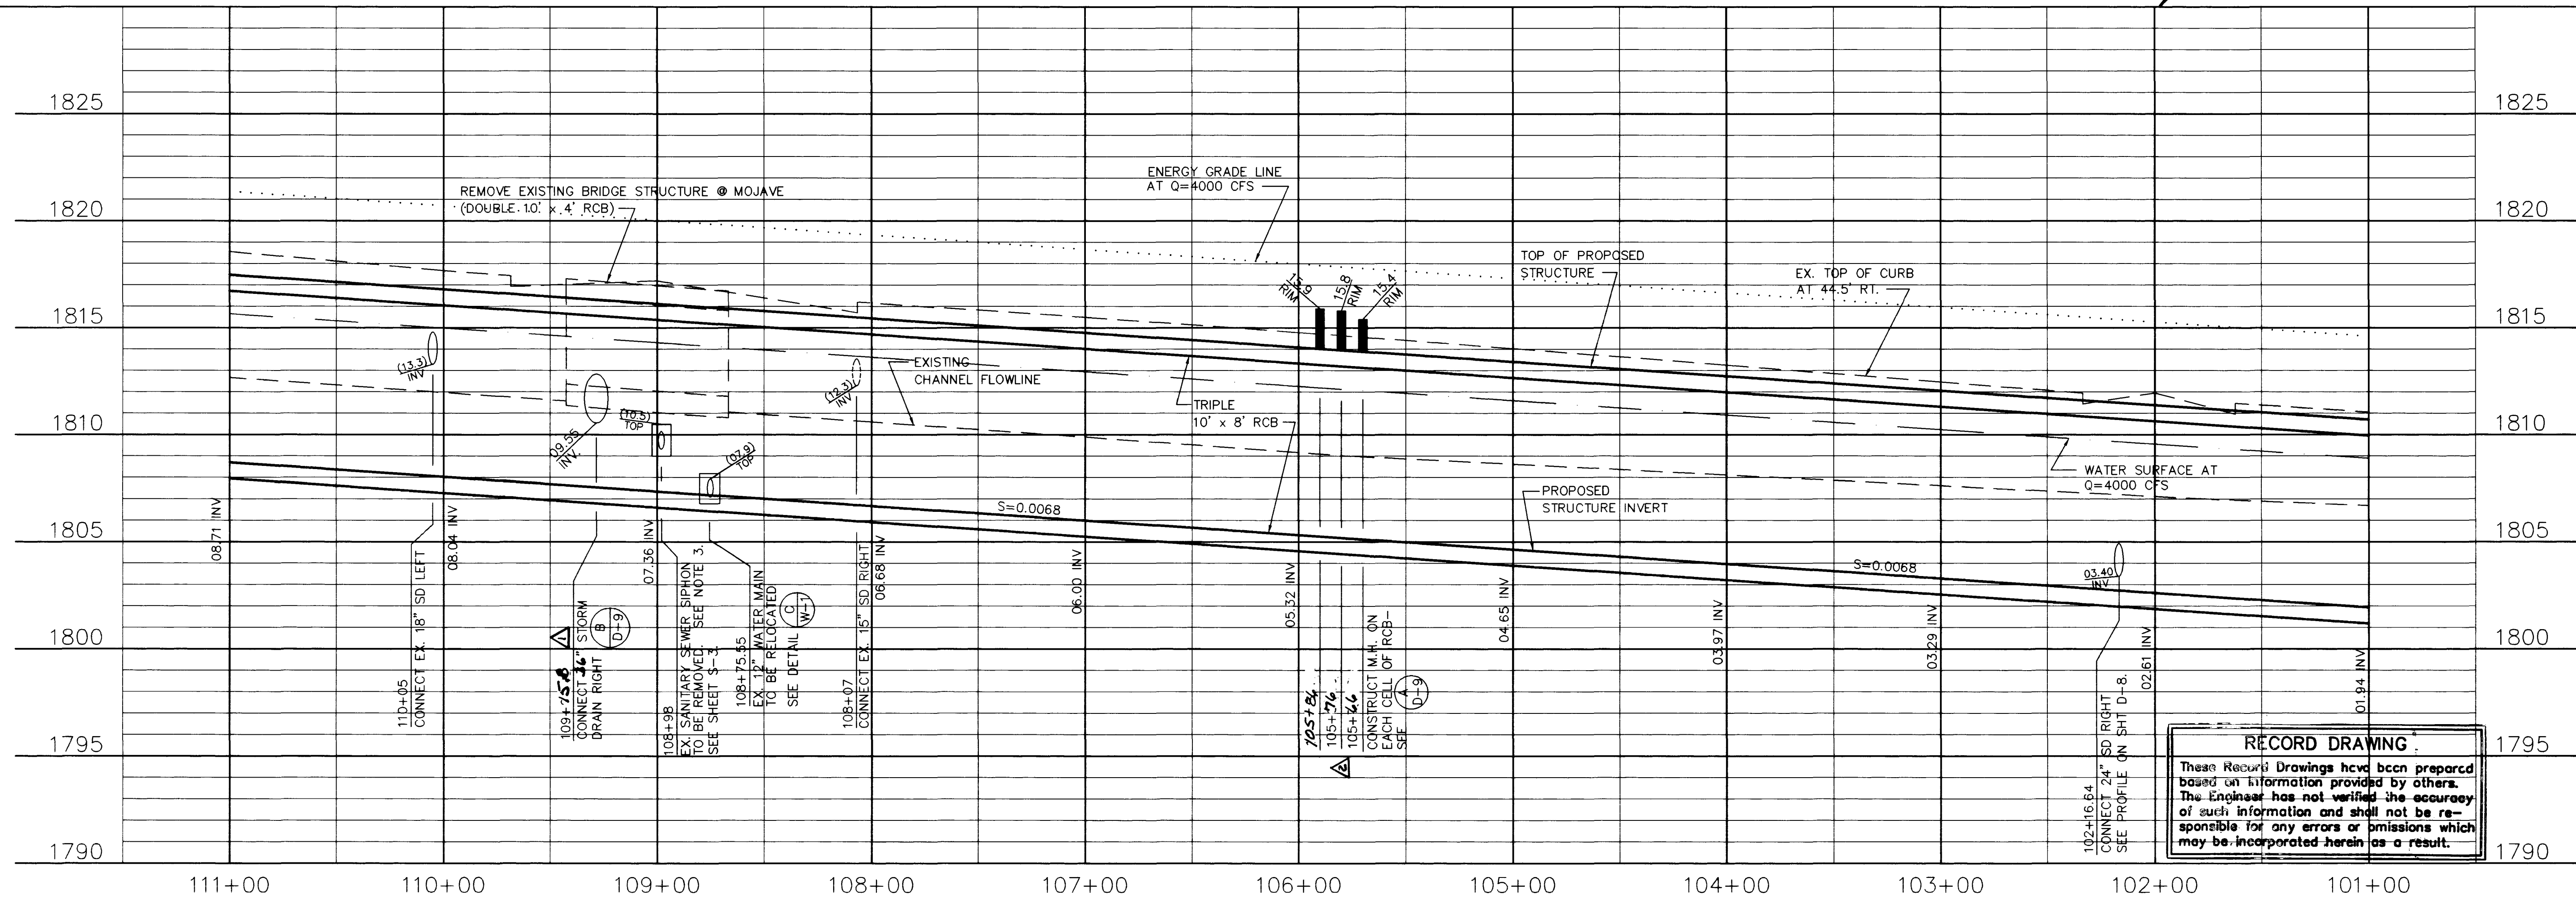

RECORD DRAWING	
These Record Drawings have been prepared based on information provided by others. The Engineer has not verified the accuracy of such information and shall not be responsible for any errors or omissions which may be incorporated herein as a result.	

PROJECT:	CITY OF LAS VEGAS	
	WASHINGTON AVENUE CONVEYANCE SYSTEM	
SHEET	D-4	
	7 OF 39	
DESCRIPTION:	DRAINAGE STRUCTURE PLAN and PROFILE	
	STA. 111+00 to 101+00	



1055 EAST TROPICANA
 SUITE 100
 LAS VEGAS, NEVADA 89119
 (702) 798-1007


DESIGNED:	RB/BB
DRAWN:	JH/LM
CHECKED:	RB
JOB NO.	393-9-81
SCALE:	
HORIZ.	1" = 40'
VERT.	1" = 4'

ENGINEER'S SEAL OF NEVADA

GLENN K. GLENN
 06/14/94
 CIVIL

REVISIONS		
No.	Date	
1	12/24/94	Added STATION LOCATION
2	01/24/95	Added STATION ELEVATION
3	02/24/95	Changed MH LOCATION

1

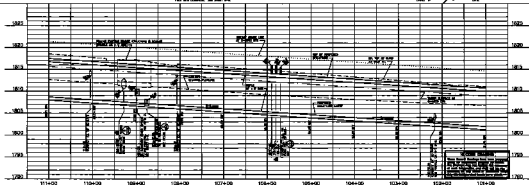[illegible]

CITY OF LAKE WALKER
WALKER AVENUE CONFORMANCE SYSTEM
ANALYSIS ATTENDING PLAN and PROPOSED
DATE: 11/10/2010 BY: JLM/MLP

D-4