


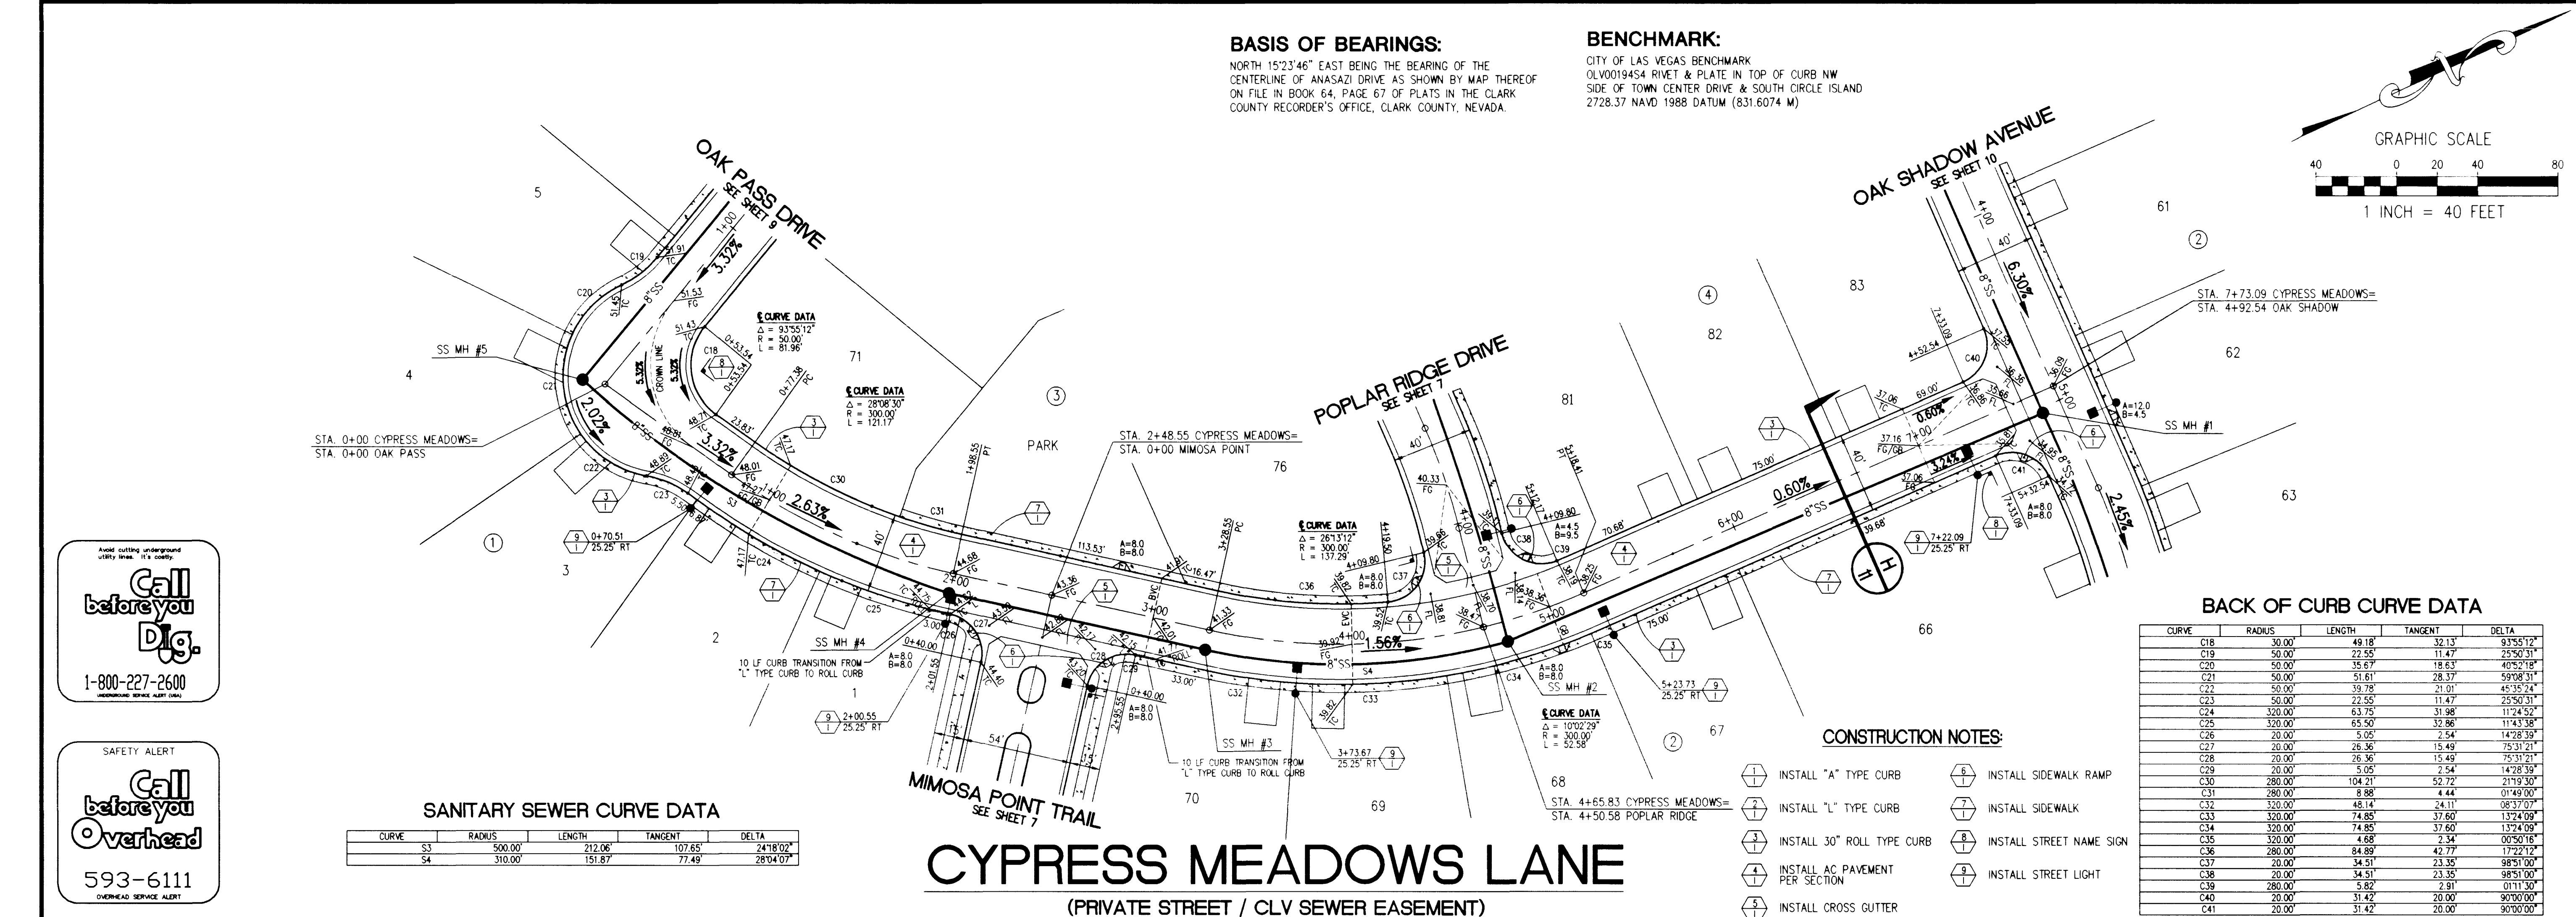

REVISIONS


No.	Date	By	Rev.

DESIGNED: C&B
DRAWN: C&B
CHECKED: R/W
JOB No.: 98004010
HORIZ: 1"=40'
VERT: 1"=4'
DATE: 8/7/96

Carter :: Burgess
Consultants in Engineering, Architecture,
Planning and the Environment
2955 East Sunset Road, Suite 105
Las Vegas, NV 89120
(702) 798-1001 Fax: (702) 798-1056

Pulte Homes
An American Favorite

PROJECT: BREAMOR HEIGHTS
DESCRIPTION: STREET & SANITARY PLAN & PROFILE
SHEET: 8 OF 12

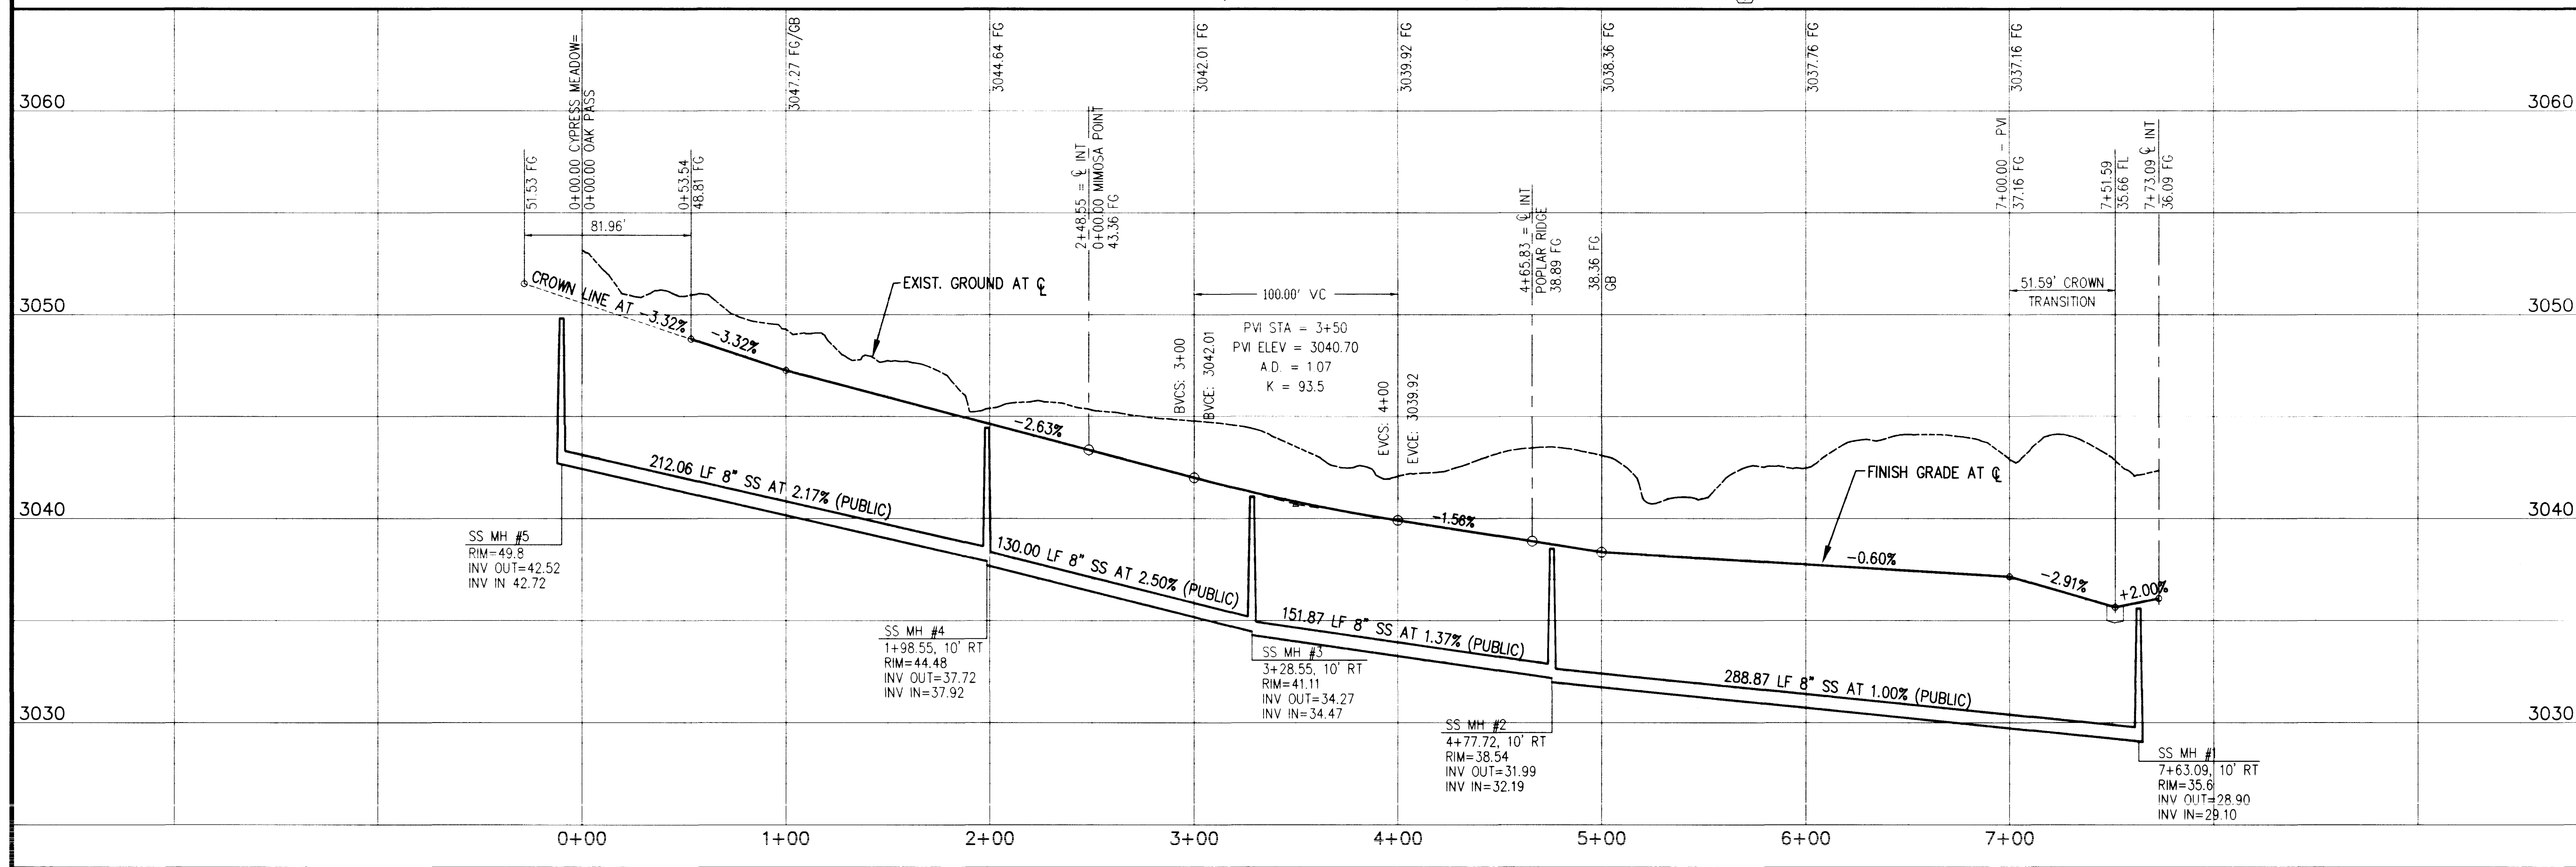

BASE OF BEARING

THE BEARING OF ANY LINE IS THE ANGLE MEASURED
CLOCKWISE FROM THE BEARING OF THE PREVIOUS
LINE TO THE BEARING OF THE NEXT LINE.


REMARKS:

REMARKS: THIS DRAWING
SHOULD BE USED AS A GUIDE ONLY
AND NOT AS A BASIS FOR CONSTRUCTION.

GRAPHIC SCALE
1 INCH = 40 FEET



CYPRESS MEADOWS LANE STATIONING / CURVE DATA

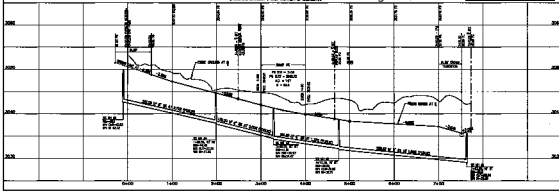

DATE: _____ **BY:** _____

PROJECT: _____

DESCRIPTION: _____

SCALE: _____

REVISIONS:

NO.	DATE	DESCRIPTION
1	10/12/01	ISSUED FOR PERMIT

APPROVED: _____

ENGINEER: _____

CHECKED: _____

DATE: _____