


VICINITY MAP

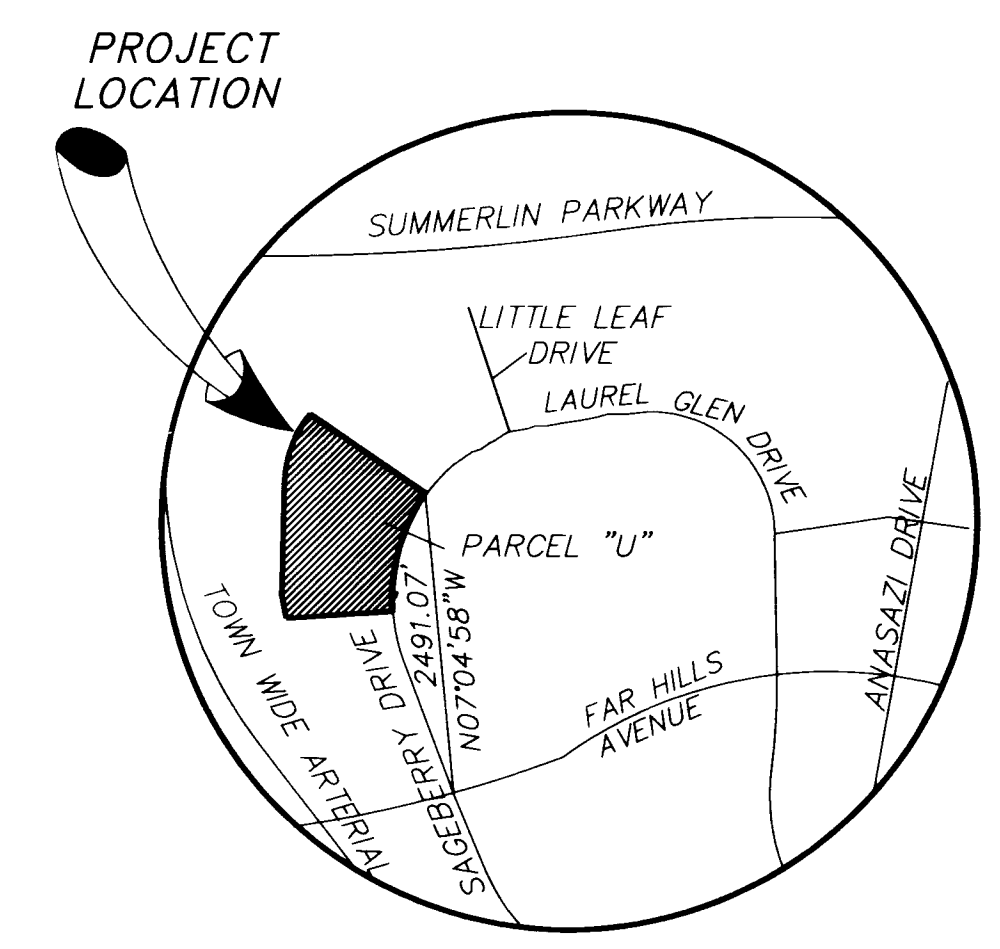

PROJECT LOCATION MAP

SYMBOLS/LINE TYPES	TO BE CONSTRUCTED		EXISTING (SHADED 60%)	
	SYMBOL	DESCRIPTION	SYMBOL	DESCRIPTION
CENTERLINE		N/A		N/A
RIGHT OF WAY		N/A		N/A
PROPERTY LINE		N/A		N/A
CONSTRUCTION CONTOUR		N/A		N/A
CHAIN LINK FENCE		N/A		N/A
WALL		N/A		N/A
SEWER MAIN (12" AND SMALLER)		12" XXX SS		12" XXX SS
SEWER MAIN (ABOVE 12")		18" XXX SS		18" XXX SS
SEWER MAIN (ABOVE 60")		60" XXX SS		60" XXX SS
STORM DRAIN (12" AND SMALLER)		12" XXX SD		12" XXX SD
STORM DRAIN (ABOVE 12")		18" XXX SD		18" XXX SD
STORM DRAIN (ABOVE 60")		60" XXX SD		60" XXX SD
WATER MAIN (12" AND SMALLER)		12" XXX WATER MAIN		12" XXX WATER MAIN
WATER MAIN (ABOVE 12")		18" XXX WATER MAIN		18" XXX WATER MAIN
WATER MAIN (ABOVE 60")		60" XXX WATER MAIN		60" XXX WATER MAIN
GAS		N/A		N/A
TELEPHONE		N/A		N/A
UNDERGROUND POWER		N/A		N/A
OVERHEAD POWER		N/A		N/A
STREETLIGHT CONDUIT		N/A		N/A
TRAFFIC SIGNAL CONDUIT		N/A		N/A
TRAFFIC SIGNAL INTERCONNECT		N/A		N/A
CABLE TELEVISION		N/A		N/A
EDGE-OF-PAVEMENT		N/A		N/A
FLOWLINE OF DITCH/CHANNEL		N/A		N/A
CURB AND GUTTER		N/A		N/A
SIDEWALK RAMPS		N/A		N/A
VALLEY GUTTER		N/A		N/A
DROP INLET		N/A		N/A
DRIVEWAY APRON		N/A		N/A
CUT OR FILL SLOPE		N/A		N/A
WATER VALVE		N/A		N/A
FIRE HYDRANT		N/A		N/A
MONUMENT		N/A		N/A
BUILDING		N/A		N/A
MISC. SYMBOLS		N/A		N/A
STUB OUT		N/A		N/A
DIRECTION OF FLOW		N/A		N/A
ELEVATION		N/A		N/A
TRAFFIC SIGNAL CONTROLLER		N/A		N/A
PULL BOX		N/A		N/A
TRAFFIC SIGNAL LOOP DETECTORS		N/A		N/A
AMP SERVICE POINT & METER PED.		N/A		N/A
AMP SERVICE POINT & RCOO		N/A		N/A
BREAK AWAY TYPE BASE		N/A		N/A
100 W LUMINAIRE		N/A		N/A
150 W LUMINAIRE		N/A		N/A
200 W LUMINAIRE		N/A		N/A
250 W LUMINAIRE		N/A		N/A
400 W LUMINAIRE		N/A		N/A
TRAFFIC SIGNAL POLE W/ LUMINAIRE		N/A		N/A
TRAFFIC SIGNAL POLE		N/A		N/A
SCHOOL FLASHER		N/A		N/A
TRAFFIC CONTROL SIGN		N/A		N/A
STREET NAME SIGN		N/A		N/A
PAD ELEVATION		N/A		N/A
NORTH ARROW		N/A		N/A
GRAPHIC SCALE		N/A		N/A
SECTION BUBBLE		N/A		N/A
DETAIL BUBBLE		N/A		N/A
GRADE BREAK		N/A		N/A

SHEET #	DESCRIPTION
1	C1 COVER SHEET
2	C2 VICINITY MAP SHEET
3	C3 GENERAL NOTES SHEET
4	C4 QUANTITIES AND SCHEDULE SHEET
5	UT1 MASTER UTILITY PLAN
6	UT2 MASTER UTILITY PLAN
7	GR1 MASTER GRADING PLAN
8	GR2 MASTER GRADING PLAN
9	PP1 PLAN AND PROFILE - ROSE REFLECT PLACE
10	PP2 PLAN AND PROFILE - SWANBROOKE DRIVE
11	PP3 PLAN AND PROFILE - DREAM BRIDGE DRIVE
12	PP4 PLAN AND PROFILE - ANIME DRIVE
13	PP5 PLAN AND PROFILE - CERBE LANE
14	PP6 PLAN AND PROFILE - CATTAL + MAYBLOOM LANE
15	S81 SEWER PLAN AND PROFILE - ROSE REFLECT PLACE
16	S82 SEWER PLAN AND PROFILE - SWANBROOKE DRIVE
17	S83 SEWER PLAN AND PROFILE - DREAM BRIDGE DRIVE
18	S84 SEWER PLAN AND PROFILE - ANIME DRIVE
19	S85 SEWER PLAN AND PROFILE - CERBE LANE
20	S86 SEWER + STORM DRAIN PLAN AND PROFILE - CATTAL + SEWER IN 34' EASEMENT
21	DT1 DETAIL SHEET
22	DT2 DETAIL SHEET

KAUFMAN BROAD 4755 INDUSTRIAL ROAD LAS VEGAS, NV 89103 (702) 291-1500		HUNSAKER & ASSOCIATES PLANNING & SURVEYING NEVADA, I.N.C. 401 N. Durbin Dr. Suite 100, Las Vegas, Nevada 89105 (702) 242-4500	
VICINITY MAP AND SHEET INDEX CITY OF LAS VEGAS NEVADA		BROOKFIELD - PARCEL "U" PHASE I AND II - SUMMERLIN	
DRAWN BY: A. IMPERIAL	QUALITY CONTROL BY: C. PEREZ	PROJECT NO.: 1506-30	SCALE: AS SHOWN
SHEET C2 2 OF 22		DRAWINGS NO. 1074-4545-142	

