


PARK PLACE  
1141 S. LAS VEGAS BLVD.  
CITY OF LAS VEGAS, NEVADA  
APN: 162-03-112-021

LEGEND

|     |                                     |
|-----|-------------------------------------|
| --- | ROADWAY CENTERLINE                  |
| --- | PROPERTY LINE / ROW LINE            |
| --- | PROPOSED PROPERTY LINE/BOUNDARY     |
| --- | EXISTING BUILDING FOOTPRINT         |
| --- | PROPOSED BUILDING FOOTPRINT         |
| --- | PROPOSED CMU WALL                   |
| --- | PROPOSED STRIPING                   |
| --- | EASEMENT                            |
| --- | EXISTING 'L' TYPE CURB              |
| --- | 'L' TYPE CURB & GUTTER              |
| --- | EXISTING 'A' TYPE CURB              |
| --- | 'A' TYPE CURB                       |
| --- | EXISTING SEWER LINE                 |
| --- | EXISTING GAS LINE                   |
| --- | EXISTING WATER LINE                 |
| --- | PROPOSED WATER LINE                 |
| --- | PROPOSED SEWER LINE                 |
| --- | EXISTING OVERHEAD POWER LINE        |
| --- | PROPOSED FLOWLINE                   |
| --- | EXISTING FIRE HYDRANT               |
| --- | PROPOSED FIRE HYDRANT               |
| --- | PROPOSED FIRE DEPT CONNECTION (FDC) |
| --- | EXISTING WATER METER                |
| --- | PROPOSED WATER METER                |
| --- | EXISTING WATER RPPA                 |
| --- | PROPOSED WATER RPPA                 |
| --- | EXISTING WATER VALVE                |
| --- | PROPOSED WATER VALVE                |
| --- | EXISTING IRRIGATION VALVE           |
| --- | EXISTING WATER RPDA                 |
| --- | PROPOSED WATER RPDA                 |
| --- | EXISTING SEWER MANHOLE              |
| --- | PROPOSED SEWER MANHOLE              |
| --- | EXISTING SEWER CLEANOUT             |
| --- | PROPOSED SEWER CLEANOUT             |
| --- | EXISTING POWER POLE                 |
| --- | EXISTING TRANSFORMER                |
| --- | EXISTING SIGN                       |
| --- | PROPOSED SIGN                       |
| --- | CONCRETE                            |
| --- | EXISTING CONCRETE                   |
| --- | NEW AC PAVEMENT                     |
| --- | PROPOSED RIP-RAP                    |
| --- | PROPOSED BOLLARD                    |
| --- | EXISTING GRADE                      |
| --- | PROPOSED GRADE                      |
| --- | PROPOSED SLOPE                      |

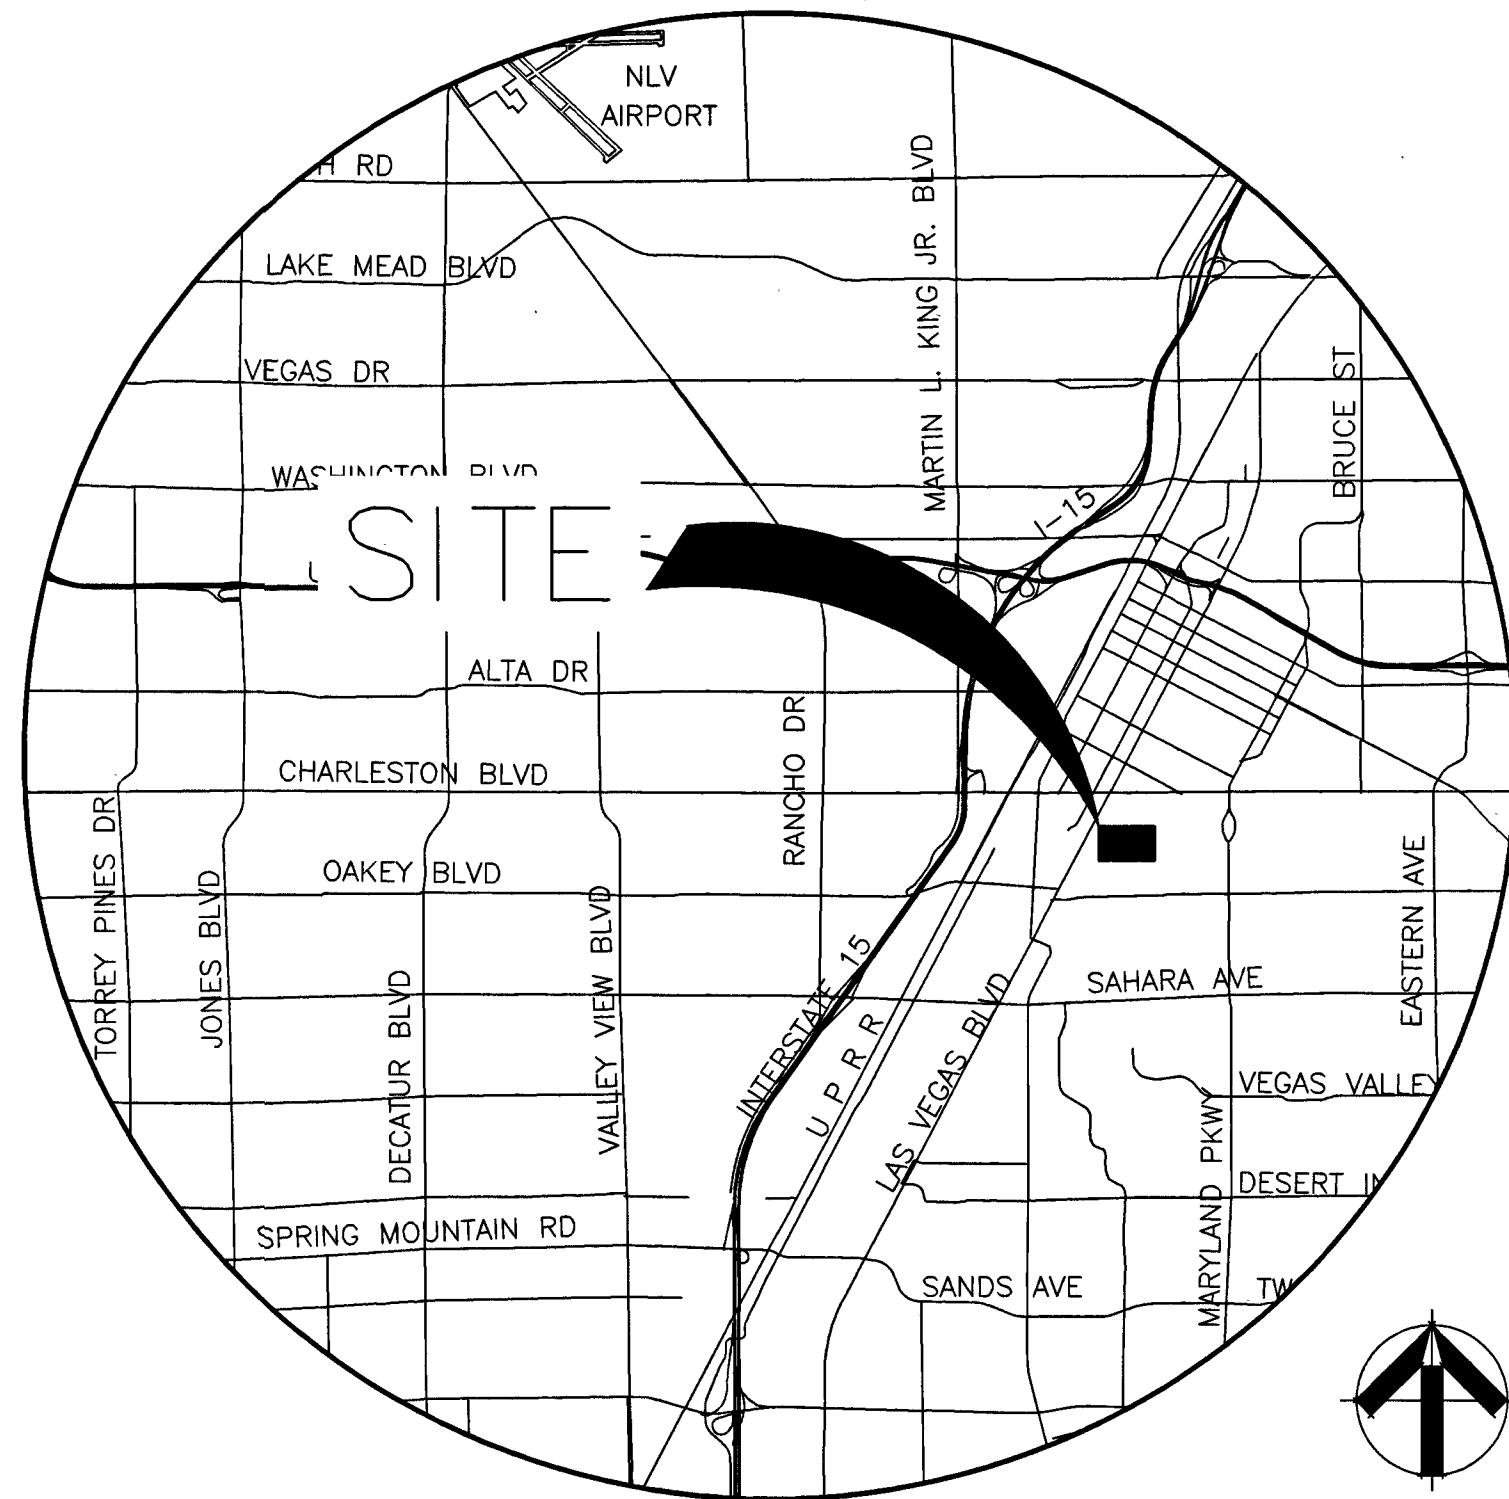

VICINITY MAP  
T21S/ R61E/ SEC 3

ABBREVIATIONS

|            |                                            |
|------------|--------------------------------------------|
| AC         | ASPHALTIC CONCRETE                         |
| AB         | AGGREGATE BASE                             |
| BCR        | BEGIN CURB RETURN                          |
| CCASUD     | CLARK COUNTY AREA UNIFORM STANDARD DRAWING |
| CL         | CENTERLINE                                 |
| CO         | CLEAN OUT                                  |
| CONC       | CONCRETE                                   |
| CY         | CUBIC YARDS                                |
| EA         | EACH                                       |
| ECR        | END CURB RETURN                            |
| EG         | EXISTING GROUND                            |
| EL         | ELECTRIC                                   |
| EP         | EDGE OF PAVEMENT                           |
| ESMT       | EASEMENT                                   |
| EX         | EXISTING                                   |
| FF         | FINISH FLOOR                               |
| FG         | FINISH GRADE                               |
| FS         | FINISHED SURFACE                           |
| G          | GAS                                        |
| GB         | GRADE BREAK                                |
| HP         | HIGH POINT                                 |
| INV        | INVERT                                     |
| LF         | LINEAR FEET                                |
| LP         | LOW POINT                                  |
| LT         | LEFT                                       |
| LVVWD      | LAS VEGAS VALLEY WATER DISTRICT            |
| MH         | MAN HOLE                                   |
| NAP        | NOT A PART                                 |
| NTS        | NOT TO SCALE                               |
| OFF        | OFFSET                                     |
| POC        | POINT OF CONNECTION                        |
| PL         | PROPERTY LINE                              |
| PVT        | PRIVATE                                    |
| ROW OR R/W | RIGHT OF WAY                               |
| RPDA       | REDUCED PRESSURE DETECTOR ASSEMBLY         |
| RT         | RIGHT                                      |
| S          | SLOPE                                      |
| SF         | SQUARE FEET                                |
| SMH        | SANITARY SEWER MANHOLE                     |
| SSCO       | SANITARY SEWER CLEANOUT                    |
| STA        | STATION                                    |
| SW         | 'SIDEWALK                                  |
| TC         | TOP OF CURB                                |
| TE         | TRASH ENCLOSURE                            |
| TYP        | TYPICAL                                    |
| USD        | UNIFORM STANDARD DRAWING                   |
| W          | WATER                                      |

APPROVALS

*Allen Pavelka* FOR ALLEN PAVELKA 12/14/17  
ALLEN PAVELKA, PE, PE# 9029 CITY ENGINEER DATE

APPROVAL OF THESE PLANS IS LIMITED TO THOSE IMPROVEMENTS CONSTRUCTED IN THE DEDICATED RIGHTS-OF-WAY AND/OR DEDICATED EASEMENTS. THIS APPROVAL DOES NOT AUTHORIZE THE CONSTRUCTION OF ANY IMPROVEMENTS THAT DEVIATE FROM ADOPTED STANDARDS AND/OR SPECIFICATIONS EXCEPT THOSE SPECIFICALLY LISTED UNDER "DEVIATIONS FROM STANDARDS". THE ENGINEER SHALL RESOLVE ANY DEVIATION OTHER THAN THOSE LISTED IN "DEVIATIONS FROM STANDARDS" IN FAVOR OF THE UNIFORM STANDARDS DRAWINGS AND SPECIFICATIONS CLARK COUNTY AREA.

*Steve Gabeke* 12/12/17  
PLANNING DEPARTMENT DATE  
THIS PLAN CONFORMS TO THE APPLICABLE STANDARDS OF THE PLANNING DEPARTMENT

*R. Smith* 11/13/17  
CLV FIRE & RESCUE DATE

*Ryan Stimmerich* 10/30/17  
SOUTHWEST GAS CORPORATION DATE

*Barbara Harrison* 10-31-17  
NEVADA POWER COMPANY, A NEVADA CORPORATION d/b/a NV ENERGY DATE  
NV ENERGY ACKNOWLEDGES THAT WE HAVE RECEIVED YOUR PLANS AND WILL PROVIDE SERVICE TO ALL ELECTRICAL NEEDS ASSOCIATED WITH THIS PROJECT. NV ENERGY RESERVES THE RIGHT TO ADDRESS ANY EXISTING OR FUTURE CONFLICTS ONCE THE FINAL DESIGN IS COMPLETED. THE NEW SERVICE AND THE RESOLUTION OF ANY CONFLICTS WILL BE ACCOMPLISHED PURSUANT TO THE NEVADA PUBLIC UTILITY COMMISSION'S RULES AND REGULATIONS.



*Michael Somma* 10/31/17  
CENTRAL TELEPHONE CO. d/b/a CENTURY LINK DATE

"THE AFFIXED CENTURY LINK APPROVAL DOES NOT ASSUME OR GUARANTEE LIABILITY FOR KNOWN OR UNKNOWN CONFLICTS WITH EXISTING OR PROPOSED IMPROVEMENTS. RESOLUTION OF ANY CONFLICT WILL BE ACCOMPLISHED PURSUANT TO LOCAL ORDINANCES, NEVADA REVISED STATUTES AND/OR PUBLIC UTILITY COMMISSION RULES AND REGULATIONS."

*COX* 10-31-17  
COX COMMUNICATIONS, LAS VEGAS, INC. DATE

APPROVED FOR CONSTRUCTION

*Disa...*  
LAS VEGAS VALLEY WATER DISTRICT ENGINEERING SERVICES MANAGER  
DATE: 11/20/17 PROJECT No. 124710  
LVVWD APPROVED FIRE FLOW 1500 GPM AT 20 PSI RESIDUAL  
SHEET #S 1, 2, 3 & 6

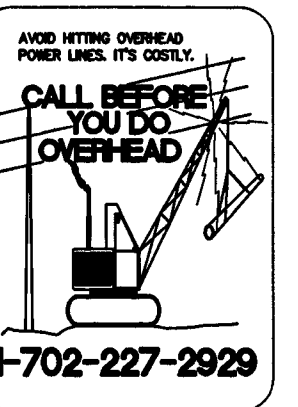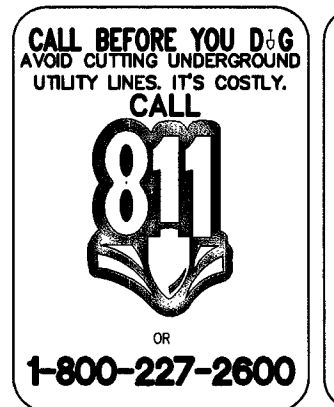

LEGAL DESCRIPTION

THAT PORTION OF LOT "H" OF PARK PLACE ADDITION TO THE CITY OF LAS VEGAS, AS SHOWN BY MAP THEREOF ON FILE IN BOOK 1 OF PLATS, PAGE 48, IN THE OFFICE OF THE COUNTY RECORDER OF CLARK COUNTY, NEVADA, DESCRIBED AS FOLLOWS:

COMMENCING AT THE SOUTHWEST CORNER OF SAID LOT "H" AND RUNNING THENCE NORTH 27°45'00" EAST 218.57 FEET TO A POINT ON THE WEST LINE OF SAID LOT; THENCE NORTH 89°57'00" EAST 201.50 FEET TO A POINT ON THE EAST LINE OF SAID LOT; THENCE SOUTH 02°22'00" WEST 191.00 FEET TO THE SOUTHEAST CORNER OF SAID LOT; THENCE SOUTH 89°57'00" WEST 295.00 FEET TO THE POINT OF BEGINNING.

SAID PARCEL CONTAINS 1.09 ACRES, MORE OR LESS.

NOTE: LEGAL DESCRIPTION DOCUMENT #20120829-0001892, BEING THE CURRENT LEGAL DESCRIPTION OF RECORD, DOES NOT CLOSE. THIS LEGAL DESCRIPTION APPEARS TO HAVE BEEN CREATED FROM THE ORIGINAL PLATTED LOT, BEING LOT "H".

BENCHMARK

CITY OF LAS VEGAS VERTICAL CONTROL V2003 (NAVD 88)  
BENCHMARK NO. 418203H NDOT BRASS CAP MONUMENT TOP CURB @ SE CORNER OF LAS VEGAS BLVD. & CHARLESTON BLVD. (STAMPED 418203H 1998 GIS CONTROL MONUMENT)  
NAVD 88 DATUM 615.624 METERS (2019.76 FEET)

BASIS OF BEARING

NORTH 27°54'36" EAST BEING THE CENTERLINE OF LAS VEGAS BOULEVARD SOUTH BETWEEN PARK PASEO AND CHARLESTON BOULEVARD AS SHOWN ON RECORD OF SURVEY MAPS, FILE 82, PAGE 84 OF CLARK COUNTY, NEVADA OFFICIAL RECORDS.

OWNER/DEVELOPER

3250 SPRING MOUNTAIN TRUST & LOVE LANNY D TRUSTEE  
3650 TROPICANA  
SUITE D  
N LAS VEGAS, NV  
TEL: (702)-383-1100

GENERAL CONTRACTOR

AJB GENERAL CONTRACTOR  
102 E. MAYFLOWER AVE.  
N LAS VEGAS, NV 89030  
TEL: (702)-876-6544  
FAX: (702)-876-6234

INDEX OF DRAWINGS

1. COVER SHEET
2. GENERAL NOTES
3. DEMOLITION PLAN
4. SECTIONS AND DETAIL SHEET
5. HORIZONTAL CONTROL PLAN
6. UTILITY PLAN
7. GRADING PLAN
8. LANDSCAPE PLAN I
9. LANDSCAPE PLAN II

|                           |          |
|---------------------------|----------|
| Job No.                   | 15464    |
| FILE No.                  | 10/30/17 |
| REUSE OF DOCUMENTS        | N/A      |
| APPROVED                  |          |
| REVISIONS                 |          |
| NO.                       | DATE     |
| STAMP                     |          |
| CITY OF LAS VEGAS, NEVADA |          |
| 1141 S. LAS VEGAS BLVD.   |          |
| APN: 162-03-112-021       |          |
| CITY OF LAS VEGAS, NEVADA |          |
| JOB No. 15464             |          |
| DATE 10/30/17             |          |
| VERT. SCALE N/A           |          |
| HORIZ. SCALE N/A          |          |
| DRAWN BY: JGR             |          |
| CHECKED BY: DAD           |          |
| SHEET 1 of 9              |          |
| 107V7142                  |          |
| CLV# 70003                |          |



CITY OF LAS VEGAS VERTICAL CONTROL V2003 (NAVD  
88)  
BENCHMARK NO. 418203H NDOT BRASS CAP  
MONUMENT TOP CURB @ SE CORNER OF LAS VEGAS  
BLVD. & CHARLESTON BLVD. (STAMPED 418203H 1998  
GIS CONTROL MONUMENT).  
NAVD 88 DATUM 615.624 METERS (2019.76 FEET)

NORTH 27°54'36" EAST BEING THE CENTERLINE OF LAS VEGAS BOULEVARD SOUTH BETWEEN PARK PASEO AND CHARLESTON BOULEVARD AS SHOWN ON RECORD OF SURVEY MAPS, FILE 82, PAGE 84 OF CLARK COUNTY, NEVADA OFFICIAL RECORDS.

THAT PORTION OF LOT "H" OF PARK PLACE ADDITION  
TO THE CITY OF LAS VEGAS, AS SHOWN BY MAP  
THEREOF ON FILE IN BOOK 1 OF PLATS, PAGE 48, IN  
THE OFFICE OF THE COUNTY RECORDER OF CLARK  
COUNTY, NEVADA, DESCRIBED AS FOLLOWS:

COMMENCING AT THE SOUTHWEST CORNER OF SAID LOT "H" AND RUNNING THENCE NORTH 27°45'00" EAST 218.57 FEET TO A POINT ON THE WEST LINE OF SAID LOT; THENCE NORTH 89°57'00" EAST 201.50 FEET TO A POINT ON THE EAST LINE OF SAID LOT; THENCE SOUTH 02°20'00" WEST 191.00 FEET TO THE SOUTHEAST CORNER OF SAID LOT; THENCE SOUTH 89°57'00" WEST 295.00 FEET TO THE POINT OF BEGINNING.

SAID PARCEL CONTAINS 1.09 ACRES, MORE OR LESS.

NOTE: LEGAL DESCRIPTION DOCUMENT  
#20120829:0001882, BEING THE CURRENT LEGAL  
DESCRIPTION OF RECORD, DOES NOT CLOSE. THIS  
LEGAL DESCRIPTION APPEARS TO HAVE BEEN CREATED  
FROM THE ORIGINAL PLATTED LOT, BEING LOT "H".

NONE

LAS VEGAS VALLEY WATER DISTRICT STANDARD NOTE  
LVWD PROJECT No. 124710

1. NO WORK SHALL BEGIN UNTIL THE WATER PLANS HAVE BEEN APPROVED FOR CONSTRUCTION BY THE LVVWD. FOLLOWING WATER PLAN APPROVAL, WORK SHALL BE GIVEN TO THE LVVWD COMMUNICATIONS SUPPORT CENTER (258-7171) TWO (2) WORKING DAYS PRIOR TO THE START OF CONSTRUCTION. FOR FUTURE INSPECTIONS, NOTICE MUST BE GIVEN BY 2:00 P.M. THE BUSINESS DAY PRIOR TO THE REQUESTED LVVWD INSPECTION. WHEN REQUESTING INSPECTIONS, PLEASE REFER TO THE PROJECT # IDENTIFIED ABOVE.
2. ALL WORK SHALL CONFORM TO LVVWD STANDARD PLATES, DRAWINGS, AND SPECIFICATIONS, AND TO THE 2010 EDITION OF THE UNIFORM DESIGN AND CONSTRUCTION STANDARDS FOR POTABLE WATER SYSTEMS (UDACS). THE LATEST EDITION OF UDACS SHALL SUPERSEDE ANY CONDITIONS CONTAINED IN THE APPROVED DRAWINGS AND/OR SPECIFICATIONS.
3. ALL WORK, EXCEPT AS MODIFIED BY THESE PLANS OR BY NOTE 2 ABOVE, SHALL BE DONE IN ACCORDANCE WITH THE MOST RECENT DRAFT OR EDITION OF THE UNIFORM STANDARD SPECIFICATIONS FOR PUBLIC WORKS CONSTRUCTION OFFSITE IMPROVEMENT, CLARK COUNTY AREA.
4. A SINGLE PIPE MATERIAL SHALL BE USED THROUGHOUT THE PROJECT UNLESS OTHERWISE APPROVED BY THE LVVWD.
5. ALL SERVICE LATERALS TWO (2) INCHES IN DIAMETER AND SMALLER SHALL BE TYPE K COPPER TUBING WITH LVVWD APPROVED SERVICE SADDLES.
6. ALL WATER METER BOXES SHALL BE LOCATED OUTSIDE OF DRIVEWAY AREAS.
7. ALL VALVES SHALL BE LOCATED OUTSIDE OF DRIVEWAYS, VALLEY AND CURB GUTTERS.
8. ALL WATER AND STORM DRAIN OR SANITARY SEWER CROSSINGS SHALL CONFORM TO SECTION 2.22 OF THE 2010 EDITION OF THE UDACS.
9. ALL WATER FACILITIES SHALL BE FILLED, DISINFECTED, PRESSURE TESTED, FLUSHED, FILLED, AND AN ACCEPTABLE WATER SAMPLE OBTAINED, PRIOR TO CONNECTION TO THE LVVWD DISTRIBUTION SYSTEM.
10. THE CONTRACTOR MUST OBTAIN ALL METERS TWO (2) INCHES AND SMALLER FROM LVVWD CORKING STORES. TELEPHONE 258-3152 OR 258-3802, TWO (2) WORKING DAYS PRIOR TO METER PICKUP.
11. ANY INTERRUPTION OF SERVICE MUST BE PERFORMED IN ACCORDANCE WITH UDACS SECTION 3.14.01, AND APPROVED BY THE LVVWD. CONSTRUCTION DIVISION PRIOR TO ANY WORK. PROPER WRITTEN NOTIFICATION MUST BE GIVEN TO ALL AFFECTED CUSTOMERS.
12. ALL WATER FACILITY CONSTRUCTION MATERIALS USED MUST BE AS LISTED ON THE LVVWD PRE-APPROVED MATERIALS AND MANUFACTURERS LISTING FOR NEW FACILITIES. LATEST REVISION, OR SPECIFICALLY APPROVED BY THESE PLANS.
13. TELEPHONE \*CALL BEFORE YOU DIG\* AT 811\* OR 1-800-227-2600.

14. THE INSTALLATION OF LAS VEGAS VALLEY WATER DISTRICT (LVVWD) MUNICIPAL WATER FACILITIES WITHIN ALL STREETS IS ASSUMED TO BE IN COMPLIANCE WITH THE UNIFORM STANDARDS, INCLUDING THE PLACEMENT OF ASPHALT PAVING STREET SURFACES. ANY REPAIR WORK DONE BY THE LVVWD TO THE MUNICIPAL WATER FACILITIES WILL INCLUDE THE PLACEMENT OF AN APPROPRIATELY SIZED ASPHALT REPAIR PATCH ON THE STREET SURFACE.

ANY DECORATIVE PAVING SURFACE WITHIN THE STREET IS THE RESPONSIBILITY OF THE OWNER'S ASSOCIATION, OR THE INDIVIDUAL PROPERTY OWNERS IF NO OWNER'S ASSOCIATION IS IN EXISTENCE, OR THE AGENCY HAVING JURISDICTION.

DECORATIVE SURFACE MATERIALS PLACED WITHIN THE TEN FOOT EASEMENT ABUTTING A PUBLIC OR PRIVATE STREET, IF DISTURBED BY THE LVVWD DURING THE REPAIR OR OPERATION OF ITS FACILITIES, WILL BE REPLACED BY LVVWD WITH AN APPROPRIATELY SIZED PLAIN FINISH CONCRETE PATCH. THE LVVWD WILL NOT RESTORE, AND WILL NOT BE RESPONSIBLE FOR THE RESTORATION OF, ANY DECORATIVE PAVING SURFACE WITHIN THE STREET. THE LVVWD WILL NOT ATTEMPT TO MATCH COLOR OR FINISH OF ANY ADJACENT MATERIALS.

15. NO LEAD COMPLIANCE NOTE:  
TO COMPLY WITH THE FEDERAL SAFE DRINKING WATER ACT, ALL WATER  
WORKS BRASS PRODUCTS PROPOSED TO BE RELOCATED, OR  
INSTALLED AS NEW MUST BE INSTALLED WITH THE LEAD FREE  
APPROVED PRODUCT. THE OLD LEADER PRODUCT MAY NOT BE  
REUSED.

REVISÉ 01/09/17

4 - J. SHARI FOR - JSM  
LAS VEGAS VALLEY WATER DISTRICT ENGINEERING SERVICES MANAGER  
DATE: 11/20/17 PROJECT No. 124710  
LVWVD APPROVED FIRE FLOW 1500 GPM AT 20 PSI RESIDUAL

1. ALL CONSTRUCTION AND MATERIALS SHALL BE IN ACCORDANCE WITH THE 'UNIFORM STANDARD SPECIFICATIONS FOR PUBLIC WORKS CONSTRUCTION OFF-SITE IMPROVEMENTS, CLARK COUNTY AREA NEVADA'; LATEST ISSUE; THE 'UNIFORM STANDARD DRAWINGS FOR PUBLIC WORKS CONSTRUCTION, CLARK COUNTY AREA NEVADA'; LATEST REVISED EDITION; THE 'SUMMERLIN IMPROVEMENT STANDARDS' FOR WORK IN THE SUMMERLIN AREA; AND OTHER APPLICABLE APPROVED STANDARDS ISSUED BY THE CONTROLLING AGENCY; THE UNIFORM BUILDING CODE; AND ALL LOCAL CITY CODES AND ORDINANCES APPLICABLE, EXCEPT AS NOTED ON THIS SHEET AS 'DEVIATIONS FROM STANDARDS'.

- THE EXISTENCE AND LOCATION OF ANY OVERHEAD OR UNDERGROUND UTILITY LINES, PIPES, OR STRUCTURES SHOWN ON THESE PLANS ARE OBTAINED BY A FIELD SURVEY. THE AVAILABLE RECORD EXISTING UTILITY LINES AS SHOWN FROM CLV PLANS LIBRARY ARE APPROXIMATE AND FOR RECORD PURPOSES. EXISTING UTILITIES ARE LOCATED ON PLANS ONLY FOR THE CONVENIENCE OF THE CONTRACTOR. EXISTING UTILITY SERVICE LATERALS MAY NOT BE SHOWN ON THE PLANS. THE CONTRACTOR SHALL, AT HIS OWN EXPENSE, LOCATE ALL UNDERGROUND AND OVERHEAD INTERFERENCE WHICH MAY AFFECT HIS OPERATION DURING CONSTRUCTION AND SHALL TAKE ALL NECESSARY PRECAUTIONS TO AVOID DAMAGE TO SAME. THE CONTRACTOR SHALL USE EXTREME CAUTION WHEN WORKING NEAR OVERHEAD UTILITIES SO AS TO SAFELY PROTECT ALL PERSONNEL AND EQUIPMENT, AND SHALL BE RESPONSIBLE FOR ALL COST AND LIABILITY IN CONNECTION THEREWITH.
3. THE CONTRACTOR SHALL TAKE ALL PRECAUTIONARY MEASURES NECESSARY TO PROTECT EXISTING UTILITY LINES, STRUCTURES AND STREET LIGHTS AND STRUCTURES WHICH ARE TO REMAIN. FROM DAMAGE, AND ALL SUCH IMPROVEMENTS OR STRUCTURES DAMAGED BY THE CONTRACTOR'S OPERATIONS SHALL BE REPAIRED OR REPLACED SATISFACTORILY TO THE CONTRACTOR AND OWNING UTILITY COMPANY AT THE EXPENSE OF THE CONTRACTOR.
4. ALL CONSTRUCTION SHALL BE AS SHOWN ON THESE PLANS. ANY REVISIONS SHALL HAVE THE PRIOR WRITTEN APPROVAL OF THE CITY ENGINEER.
5. TYPE V CEMENT SHALL BE USED IN ALL OFF-SITE CONCRETE WORK. CONCRETE TO BE 3000 P.S.I. MINIMUM @ 28 DAYS. MIX DESIGNS TO BE APPROVED BY THE CITY, PRIOR TO THE USE ON THE PROJECT.
6. PERMITS ARE REQUIRED FOR ANY WORK IN THE PUBLIC RIGHT-OF-WAY. THE CONTRACTOR SHALL SECURE ALL PERMITS AND INSPECTIONS REQUIRED FOR THIS CONSTRUCTION.
7. EXPANSION JOINTS REQUIRED, MAXIMUM EVERY 300' IN EXTRUDED-TYPE CURBS.
8. AC PAVEMENT TO BE ONE-HALF INCH (1/2") ABOVE LIP OF ALL GUTTERS AFTER COMPACTION, EXCEPT AT SIDEWALK RAMPS AND CROSS GUTTERS.
9. CURB AND GUTTER FOUND TO BE UNACCEPTABLE TO THE CITY OF LAS VEGAS SHALL BE REMOVED AND REPLACED PER STANDARD DRAWING 216.
10. SIDEWALK RAMPS SHALL BE CONSTRUCTED IN EACH QUADRANT OF AN INTERSECTION PER STANDARD DRAWING 216. LOCATION OF RAMPS MAY BE ADJUSTED IN THE FIELD BY A CITY INSPECTOR.
11. CONTRACTOR SHALL PROVIDE ALL NECESSARY HORIZONTAL AND VERTICAL TRANSITIONS BETWEEN NEW CONSTRUCTION AND EXISTING SURFACES TO PROVIDE FOR PROPER DRAINAGE AND FOR INGRESS AND EGRESS TO NEW CONSTRUCTION. THE EXTENT OF TRANSITIONS TO BE AS SHOWN ON PLANS.
12. ALL GRADING WORK SHALL CONFORM TO THE SOILS REPORT AS PREPARED BY THE  
JOB NUMBER: NOVA GEOTECHNICAL  
ENGINEER: FEBRUARY 29, 2016  
DATE: E-16-020

APPROVED BY THE CITY ENGINEER, AND AS SHOWN ON THESE PLANS.

3. EXACT LOCATION OF ALL SAWCUT LINES MAY BE ADJUSTED OR DETERMINED BY FIELD MEASUREMENT. A CITY OF LAS VEGAS ENGINEER'S LOCATION ON PLANS IS NOT CLEARLY SHOWN, OR EXISTING PAVEMENT CONDITION REQUIRES RELOCATIONS.
  14. THE CONTRACTOR SHALL TAKE ALL PRECAUTIONS NECESSARY TO PROTECT EXISTING PERMANENT SURVEY MONUMENTS. ANY MONUMENTS DISTURBED SHALL BE REPLACED AND ADJUSTED PER AVAILABLE RECORDS IN ACCORDANCE WITH N.E.S. STATUTE NO. 625.380 & CITY OF LAS VEGAS TITLE 18, APPENDIX D.
  15. UTILITY COMPANY METER BOXES, MANHOLE LIDS, VALVE COVERS, ETC., SHALL BE LOCATED OUTSIDE OF DRIVEWAYS, DRIVEWAY APRONS, CLOWNIES, AND CROSS TYPERS UNLESS WRITTEN APPROVAL IS GRANTED BY THE UTILITY COMPANY AND THE CITY ENGINEER.
- WALL NOTES:
16. ALL WALLS, NEW OR EXISTING, ARE ONLY SHOWN ON CIVIL PLANS FOR THE PURPOSE OF REVEALING GRADING RELATIONSHIPS, FLOOD CONTROL, AND SIGHT DISTANCE AT INTERSECTIONS. NEW WALLS REQUIRE A SEPARATE PERMIT AND INSPECTION BY THE BUILDING DEPARTMENT.
  17. ASPHALT MIX DESIGN MUST BE SUBMITTED AND APPROVED BY THE CITY ENGINEER PRIOR TO THE PLACEMENT OF ASPHALT WITHIN CITY RIGHT OF WAY.
  18. CONTRACTOR SHALL ADJUST ALL NEW AND EXISTING INLETS, VALVE BOXES, MANHOLE RIMS, AND SEWER CLEAN OUTS, ETC. TO FINISH GRADE AS APPLICABLE WHETHER OR NOT THEY ARE SHOWN ON THE PLANS.
  19. MATERIALS, HANDLING AND PLACEMENT OF PORTLAND CEMENT CONCRETE SHALL BE IN ACCORDANCE WITH APPLICABLE SECTIONS OF NDOT OR THE CLARK COUNTY AREA SPECIFICATIONS (AS APPLICABLE) AND THE PLANS AND DETAILS SHOWN HEREON.
  20. WHEN INSTALLING UNDERGROUND FACILITIES THAT REQUIRE UNDERGROUND LOCATING DEVICES SUCH AS MARKER BALLS, CREATING RIBBON, ETC., THE CONTRACTOR SHALL SUBMIT A WRITTEN DOCUMENT TO THE CITY ENGINEER. INSPECTION AND TESTING CERTIFYING THAT ALL DEVICES HAVE BEEN PLACED AND VERIFIED TO BE IN GOOD WORKING CONDITION PRIOR TO THE CONSTRUCTION OF ANY ROAD BASE.
  21. SANITARY SEWER AND STORM DRAIN FINAL LOCATION MAP(S) SHALL BE PROVIDED TO THE CITY AND APPROVED PRIOR TO ACCEPTANCE OF THE PROJECT. THESE MAP(S) SHALL BE BASED ON THE HORIZONTAL AND VERTICAL (INVERT) LOCATION OF PUBLIC SEWER MANHOLES, STORM DRAIN MANHOLES AND TRANSITION STRUCTURES, STORM DRAIN LATERALS AT THE CONNECTION TO THE STORM DRAIN MAIN AND AT THE CONNECTION TO THE SEWER INLET, AND THE CONNECTION OF SEWAL SERVICE LATERALS TO THE SEWER MAIN AND WHERE THE SEWER SERVICE LATERALS EXIT THE PUBLIC RIGHT-OF-WAY, AND STORM DRAIN MAIN ALIGNMENT, INCLUDING DEFLECTION POINTS. THE LOCATION SHALL BE DESCRIBED BY COORDINATES WHICH MAY BE BASED ON EITHER AN OPTICAL HORIZONTAL AND VERTICAL CONTROL NETWORKS OF THE CITY OF LAS VEGAS. FINAL LOCATION MAPS MUST BE SEALED AND CERTIFIED BY A NEVADA LICENSED PROFESSIONAL ENGINEER. THE POSITIONING DATA SHALL BE TO  $\pm 0.09$  METERS ( $\pm 0.3$  FEET) HORIZONTALLY AND VERTICALLY. A SEPARATE ELECTRONIC COMMA DELIMITED FILE FOR THE SANITARY SEWER AND STORM DRAIN COORDINATES SHALL ALSO ACCOMPANY THE SANITARY SEWER AND STORM DRAIN FINAL LOCATION MAP(S).
- OR

SANITARY SEWER AND STORM DRAIN FACILITIES SHOWN ON THESE PLANS SHALL BE USED TO MEET THE REQUIREMENTS OF NRS 455 AND SHALL SHOW AT A MINIMUM THE HORIZONTAL AND VERTICAL (INVERT) LOCATION OF PUBLIC SEWER MANHOLES, STORM DRAIN MANHOLES, STORM DRAIN LATERALS AT THE CONNECTION TO THE STORM DRAIN MAIN AND AT THE CONNECTION TO A DROP INLET, AND THE CONNECTION OF SEWER SERVICE LATERALS TO THE SEWER MAIN AND WHERE THE SEWER SERVICE LATERAL EXIT THE PUBLIC RIGHT-OF-WAY. ANY DEVIATIONS FROM THE INFORMATION SHOWN SHALL BE NOTED AND SUBMITTED AS A REVISION TO THE PLANS AND APPROVED PRIOR TO ACCEPTANCE OF FACILITY VIDEO INSPECTION.

22. CCTV VIDEO INSPECTION IS REQUIRED FOR ALL SEWER AND STORM DRAINS. THE CCTV VIDEO INSPECTIONS NEED TO BE PERFORMED PER THE DESIGN AND CONSTRUCTION STANDARDS FOR WASTEWATER COLLECTION SYSTEMS LATEST ADDITION.

REVISÉ 02/02/15

1. ALL WORK SHALL BE DONE IN STRICT ACCORDANCE WITH THE LAS VEGAS FIRE AND RESCUE ADOPTED FIRE CODE ORDINANCE #6325 FOR HYDRANT SPECIFICATIONS AND HYDRANT INSTALLATION SPECIFICATIONS.

2. ONLY FIRE HYDRANTS THAT ARE ON THE LAS VEGAS VALLEY WATER DISTRICT'S APPROVED PRODUCTS LIST ARE ALLOWED TO BE INSTALLED.
3. A PERMIT IS REQUIRED FROM LAS VEGAS FIRE AND RESCUE FOR THE INSTALLATION OF ON-SITE WATER LINES AND FIRE HYDRANTS. THE PERMIT AND CONTRACTORS MATERIAL TEST CERTIFICATE FOR UNDERGROUND PIPING FORM SHALL BE OBTAINED FROM THE FIRE PROTECTION ENGINEER BEFORE COMMENCEMENT OF WORK. [FC 105.7.12]
4. ON ANY RESIDENTIAL OR COMMERCIAL INSTALLATIONS, FIRE HYDRANTS SHALL BE INSTALLED AND FIRE APPARATUS ACCESS ROADS SHALL BE MAINTAINED BEFORE COMMENCEMENT OF ANY COMBUSTIBLE CONSTRUCTION. ALL FIRE HYDRANTS SHALL BE IN GOOD WORKING ORDER AND SHALL BE CAPABLE OF DELIVERING THE REQUIRED FIRE FLOW. [FC 3310, 3312]
5. TO IDENTIFY THE FIRE HYDRANT LOCATIONS, THE CONTRACTOR SHALL PLACE A BLUE REFLECTIVE MARKER AT THE CENTER LINE OF THE STREET ADJACENT TO THE FIRE HYDRANTS. [FC 507.5.7.3]
6. ALL UNDERGROUND INSPECTIONS, PRESSURE AND FLUSH VERIFICATIONS OF ALL FIRE HYDRANTS AND FIRE LINES, SHALL BE CONDUCTED BEFORE COVERING THE LINES. CENTER LOADING IS ACCEPTABLE FOR THE HYDRO TESTS WITH PRIOR FIRE PREVENTION APPROVAL. [FC 106.3]
7. ALL ON-SITE UNDERGROUND WATER MAINS AND MATERIALS SHALL BE U.L. LISTED, A.W.W.A. APPROVED AND SHALL BE RATED FOR THE APPROPRIATE WORKING PRESSURE. [FC 507.2.1, NFPA 24]
8. PAINTING OF CURBS, FIRE HYDRANTS, PADS, PROTECTION OF FIRE HYDRANTS FROM PHYSICAL DAMAGE, AND ALL OTHER WORK NECESSARY PER PLANS SHALL BE COMPLETED BEFORE APPROVAL BY LAS VEGAS FIRE AND RESCUE, FIRE PREVENTION DIVISION. [FC 507]
9. PRIVATE FIRE HYDRANTS SHALL BE PAINTED RED. [FC 507.5.7.1]
10. PRIOR TO THE FINAL OCCUPANCY, A FIRE FLOW TEST SHALL BE WITNESSED BY LAS VEGAS FIRE AND RESCUE, FIRE PREVENTION DIVISION TO VERIFY AVAILABILITY OF THE REQUIRED FIRE FLOW. [FC 507]
11. FIRE HYDRANTS SPACING SHALL BE AS FOLLOWS: [FC 1102]  
RESIDENTIAL - 500 FEET UNSPRINKLERED; 600 FEET SPRINKLERED.  
COMMERCIAL - 300 FEET UNSPRINKLERED; 400 FEET SPRINKLERED.

12. WHERE THE WATER MAINS ARE EXTENDED ALONG STREETS OR NEW STREETS ARE INSTALLED WHERE FIRE HYDRANTS ARE NOT NEEDED FOR PROTECTION OF THE STRUCTURES, FIRE HYDRANTS SHALL BE INSTALLED AT A MAXIMUM OF 1,000 FT SPACING TO PROVIDE FOR TRANSPORTATION HAZARDS. WHERE STREETS ARE PROVIDED WITH MEDIAN DIVIDERS OR HAVE FOUR (4) OR MORE TRAFFIC LANES AND HAVE A TRAFFIC COUNT OF MORE THAN 30,000 PER DAY, HYDRANTS ARE REQUIRED ON EACH SIDE OF THE STREET SPACED AT 500 FT ON AN ALTERNATING BASIS. [IFC 502.8]
13. NO FIRE HYDRANTS SHALL BE LOCATED WITHIN THE RADIUS OF A CUL-DE-SAC OR WITHIN 20 FT OF THE PERIMETER OF THE RADIUS OF THE CUL-DE-SAC.
14. NO FIRE HYDRANTS SHALL BE LOCATED WITHIN 6 FT OF ANY CURB RETURN, DRIVEWAY, POWER POLE, STREETLIGHT OR ANY OTHER OBSTRUCTION. [IFC 502.12]
15. A MAXIMUM DISTANCE FROM A FIRE HYDRANT TO A ONE-TWO FAMILY DWELLING SHALL NOT EXCEED 300 FEET, AS MEASURED BY AN APPROVED ROUTE. [IFC 502.4]
16. THE MAXIMUM DISTANCE FROM A FIRE HYDRANT TO A FIRE DEPARTMENT CONNECTION (FDC) SHALL NOT EXCEED 100 FEET, AS MEASURED BY AN APPROVED ROUTE. [IFC 502.7]
17. THE MAXIMUM DISTANCE FROM A HYDRANT TO THE END OF A DEAD-END STREET SHALL NOT EXCEED 200 FT. [IFC 502.6]
18. TWO (2) SOURCES OF SUPPLY ARE REQUIRED WHENEVER THERE IS 4 OR MORE FIRE HYDRANTS/SPRINKLER LEAD-INS ARE INSTALLED ON A SINGLE SYSTEM. SECTORAL CONTROL VALVES SHALL BE INSTALLED SO THAT NO MORE THAN 2 FIRE HYDRANTS CAN BE OUT OF SERVICE DUE TO A BREAK IN A WATER MAIN. [IFC 501.4]
19. ALL FIRE APPARATUS ACCESS ROADS SHALL BE PAVED TO PROVIDE ALL-WEATHER DRIVING CAPABILITIES, AND SHALL BE DESIGNED AND MAINTAINED TO SUPPORT THE IMPOSED LOADS OF THE FIRE APPARATUS. [IFC 503.2.3]
20. THE GRADIENT FOR THE FIRE APPARATUS ACCESS ROADS SHALL NOT EXCEED 12% ANGLES OF APPROACH AND ANGLES OF DEPARTURE SHALL NOT EXCEED 6% FOR 25 FT PRIOR TO OR AFTER THE GRADE CHANGE. ADJACENT TO THE STRUCTURES GRADIENT SHALL NOT EXCEED 6%. [IFC 503.2.7, 503.2.8]
21. THE TURNING RADIUS OF THE FIRE APPARATUS ACCESS ROADS SHALL BE NO LESS THAN 52 FEET OUTSIDE AND 28 FEET INSIDE TURNING RADIUS. [IFC 503.2.4]
22. VERTICAL CLEARANCE OF ALL FIRE APPARATUS ACCESS ROADS SHALL BE NOT BE LESS THAN 13 FT 6 INS. [IFC 503.2.1]
23. FIRE DEPARTMENT ACCESS ROADS SHALL HAVE A MINIMUM UNOBSTRUCTED WIDTH OF NOT LESS THAN 40 FT FLOW LINE TO FLOW LINE WITH PARALLEL PARKING PERMITTED ON BOTH SIDES. NOT LESS THAN 32 FT WIDE, FLOW LINE TO FLOW LINE, WHERE PARKING IS PERMITTED ONLY ON ONE SIDE OF THE FIRE APPARATUS ROAD, NOT LESS THAN 24 FT WIDE, FLOW LINE TO FLOW LINE, WHERE NO PARKING IS PERMITTED ON EITHER SIDE OF THE ROAD. FLOW LINES THROUGH PARKING LOTS SHALL BE NOT LESS THAN 24 FT. [IFC 503.2.1.1]
24. A FIRE APPARATUS ACCESS ROAD SHALL BE REQUIRED WHEN ANY PORTION OF AN EXTERIOR WALL OF THE FIRST STORY IS LOCATED MORE THAN 150 FT FROM A FIRE DEPARTMENT VEHICLE ACCESS. THIS DISTANCE COULD BE INCREASED TO 250 FT IF THE BUILDING IS SPRINKLERED. [IFC 503.1.1]

1. IN THE EVENT OF NATURAL GAS EMERGENCIES CALL 911 OR 1-877-860-6020.

2. THERE SHALL BE A MINIMUM HORIZONTAL AND VERTICAL CLEARANCE OF 12-INCHES BETWEEN NATURAL GAS FACILITIES AND ANY UNDERGROUND FACILITIES AND/OR STRUCTURES, INCLUDING BUT NOT LIMITED TO WATER, SEWER, STORM DRAIN, COMMUNICATIONS AND ELECTRIC.
3. FOR VALVE ADJUSTMENT CONTACT 702-668-6107 FORTY EIGHT (48) HOURS PRIOR TO CONSTRUCTION.
4. IN THE EVENT OF A NATURAL GAS CONFLICT WITH PROPOSED UTILITIES AND/OR STRUCTURES CONTACT 702-365-2099.
5. SOUTHWEST GAS STANDBY BY CONTACT IS 702-400-1789.

SOUTHWEST GAS CORPORATION : : DATE

ALL CONSTRUCTION SIGNING, BARRICADING, AND TRAFFIC DELINEATION SHALL CONFORM TO THE "MANUAL ON UNIFORM TRAFFIC CONTROL DEVICES", LATEST EDITION.

- THE STREET SIGN CONTRACTOR SHALL OBTAIN STREET NAMES AND BLOCK NUMBERING FROM THE PLANNING DEPARTMENT PRIOR TO CONSTRUCTION.
- BEFORE ANY WORK IS STARTED IN THE RIGHT-OF-WAY, THE CONTRACTOR SHALL INSTALL ALL ADVANCE WARNING SIGNS FOR THE CONSTRUCTION ZONE. THE CONTRACTOR SHALL INSTALL TEMPORARY STOP SIGNS AT ALL INTERSECTIONS WHERE THE CONSTRUCTION ZONE IS LOCATED WHERE THE WORK IS WARRANTED IMMEDIATELY. AFTER STREET GRADING WORK IS ACCOMPLISHED, AND SHALL MAINTAIN SAID SIGNS UNTIL PERMANENT SIGNS ARE INSTALLED.
- WHEN A DESIGNATED "SAFE ROUTE TO SCHOOL" IS ENCLOSED UPON BY A CONSTRUCTION WORK ZONE AND PUBLIC WORKS STAFF IDENTIFIES A NEED FOR STUDENTS TO BE ASSISTED IN THE SAFE CROSSING THROUGH THAT WORK ZONE, THE CONTRACTOR SHALL BE REQUIRED TO PROVIDE A TEMPORARY STOP SIGN AND A STOP SIGN WITH A MESSAGE FOR THE FULL DURATION OF TIME THAT CHILDREN ARE LIKELY TO BE PRESENT.
- IF THE IMPROVEMENTS NECESSITATE THE OBLITERATION, TEMPORARY OBSTRUCTION, TEMPORARY REMOVAL OR RELOCATION OF ANY EXISTING TRAFFIC PAVEMENT MARKING, SUCH PAVEMENT MARKING SHALL BE RESTORED OR REPLACED WITH LIKE MATERIALS TO THE SATISFACTION OF THE CITY TRAFFIC ENGINEER.
- THE CONTRACTOR SHALL BE RESPONSIBLE FOR PROVIDING AND INSTALLING ALL PERMANENT SIGNAGE AND TRAFFIC PLANS. ALL NEW TRAFFIC SIGNS SHALL BE FABRICATED WITH DIAMOND GRADE VIF SIGNAGE. ALL NEW SHEETING OR APPROVED EQUAL ALL NEW TRAFFIC SIGNS, EXCEPT STREETNAME AND SCHOOL SPEED LIMIT SIGNS, SHALL HAVE 3/8 SERIES 1150 APPROVED APPROVED ANTI-GRAFFITI PROTECTIVE OVERLAY FILM; SCHOOL ZONE SIGNS SHALL HAVE 3/8 SERIES 1150 ANTI-GRAFFITI PROTECTIVE OVERLAY FILM. STREET NAME SIGNS SHALL CONFORM IN THEIR DESIGN TO THE CURRENT CITY OF LAS VEGAS TRAFFIC SIGNS. ALL STANDARD SIZE UNITS OTHERWISE SPECIFIED ON THE CITY SIGNS POSTS SHALL BE INSTALLED IN ACCORDANCE WITH THE CURRENT CITY STANDARDS.
- WHEN A PROPOSED STREET LIGHT STANDARD IS LOCATED WITHIN FIVE (5') FEET OF ANY PROPOSED SIGN SHOWN ON THE PLANS TO BE MOUNTED ON A SIGNPOST, THE SIGN SHALL BE MOUNTED ON THE STREET LIGHT STANDARD AND THE SIGNPOST SHALL BE ELIMINATED.
- ALL PERMANENT TRAFFIC CONTROL DEVICES CALLED FOR HEREON SHALL BE INSTALLED IN ACCORDANCE WITH THE CITY OF LAS VEGAS TRAFFIC CONTROL PORTIONS OF THE ROAD(S) BEING IMPROVED HERE UNDER, REGARDLESS OF THE STATUS OF COMPLETION OF PAVING OR OTHER OFF-SITE IMPROVEMENTS CALLED FOR BY THESE PLANS.
- STREET SIGNS AND STOPS SIGNS SHALL BE INSTALLED PER CITY STANDARD SPECIFICATIONS FOR PLACEMENT OF STREET NAME SIGNS.
- THE CONTRACTOR SHALL PROVIDE ALL NECESSARY TRAFFIC CONTROL DEVICES AND FLAGGERS TO INSURE THE SAFETY OF THE PUBLIC IN OR AROUND THE WORK AREA. THE CONTRACTOR SHALL HAVE A CERTIFIED TRAFFIC CONTROL TECHNICIAN TO APPROVE OR DISAPPROVE SAFETY SPECIALIST SET UP, MAINTAIN AND/OR REMOVE ALL TRAFFIC CONTROL DEVICES IN THE CITY OF LAS VEGAS RIGHT OF WAY.
- WORK IN PUBLIC STREETS, ONCE BEGUN, SHALL BE EXPEDITED TO COMPLETION SO AS TO PROVIDE MINIMUM INCONVENIENCE TO ADJACENT PROPERTY OWNERS AND TO THE TRAVELING PUBLIC.
- THE CONTRACTOR SHALL BE RESPONSIBLE FOR NOTIFYING CITIZENS AREA TRANSIT (C.A.T.) IF THE CONSTRUCTION INTERRUPTS OR RELOCATES A BUS STOP OR HAS AN ADVERSE EFFECT ON BUS SERVICE ON THAT STREET TO ARRANGE FOR TEMPORARY RELOCATION OF STOP.
- GUARDS SHALL BE OBTAINED BY CONTACTING THE METROPOLITAN POLICE DEPARTMENT SPECIAL EVENTS UNIT (PHONE # 828-3442) WHO WILL PROVIDE THE NECESSARY GUARDS AND TRAFFIC CONTROL DEVICES FOR THE USE OF THESE OFFICERS SHALL BE SET BY METRO AND WILL BE PAID BY THE CONTRACTOR. THE CONTRACTOR IS RESPONSIBLE FOR ALL ARRANGEMENTS WITH METRO.
- ANY WORK WITHIN 300' OF A SIGNALIZED INTERSECTION WILL BE NIGHT WORK, UNLESS DIRECTED BY THE CITY OF LAS VEGAS TRAFFIC ENGINEER.
- THE CONTRACTOR SHALL CONTACT THE TRAFFIC ENGINEERING DIVISION (TRANSPORTATION SECTION) THROUGH THE PROJECT'S OFFSITE INSPECTOR PRIOR TO INITIATING PAVING TO RECEIVE DIRECTION FOR ANY PERMANENT PAVEMENT MARKINGS TO BE INSTALLED. THE CONTRACTOR SHALL OBTAIN FINAL PAVEMENT TRANSITIONS, MARKINGS AND SIGNING THAT ARE REQUIRED TO MATCH ADJACENT ROADWAY SEGMENTS. THE CONTRACTOR SHALL PROVIDE DRAWING FOR APPROVAL BY THE TRAFFIC ENGINEERING DIVISION. ALL PAVING AND MARKING SHALL BE DONE IN ACCORDANCE WITH THE CITY OF LAS VEGAS TRAFFIC ENGINEERING DIVISION'S PAVEMENT MARKINGS AND SIGNAGE, WHICH MAY INCLUDE OMITTING, ADDING OR MODIFYING PAVEMENT MARKINGS AND TRAFFIC CONTROL SIGNS SUCH THAT ADJACENT ROADWAY SEGMENTS ARE TRANSITIONED.

1. IN THE EVENT THAT ANY UNFORESEEN CONDITIONS NOT COVERED BY THESE NOTES ARE ENCOUNTERED DURING GRADING OPERATIONS, THE OWNER/ENGINEER SHALL BE IMMEDIATELY NOTIFIED FOR DIRECTION.
2. IT SHALL BE THE RESPONSIBILITY OF THE CONTRACTOR TO PERFORM ALL NECESSARY CUTS AND FILLS WITHIN THE LIMITS OF THIS PROJECT AND THE RELATED OFF-SITE WORK, SO AS TO GENERATE THE DESIRED SUBGRADE, FINISH GRADES AND SLOPES SHOWN.

3. CONTRACTOR SHALL TAKE FULL RESPONSIBILITY FOR ALL EXCAVATION. ADEQUATE SHORING SHALL BE DESIGNED AND PROVIDED BY THE CONTRACTOR TO PREVENT UNDERMINING OF ANY ADJACENT FEATURES OR FACILITIES AND/OR CAVING OF THE EXCAVATION.
4. THE CONTRACTOR IS WARNED THAT AN EARTHWORK BALANCE WAS NOT NECESSARILY THE INTENT OF THIS PROJECT. ANY ADDITIONAL MATERIAL REQUIRED OR LEFTOVER MATERIAL FOLLOWING EARTHWORK OPERATIONS BECOMES THE RESPONSIBILITY OF THE CONTRACTOR.
5. THE GRADING CONTRACTOR IS RESPONSIBLE TO COORDINATE WITH THE OWNER TO PROVIDE FOR THE REQUIREMENTS OF THE PROJECT STORM WATER POLLUTION PREVENTION PLAN (SWPPP) AND ASSOCIATED PERMIT.
6. THE CONTRACTOR SHALL GRADE TO THE LINES AND ELEVATIONS SHOWN ON THE PLANS WITHIN THE FOLLOWING HORIZONTAL AND VERTICAL TOLERANCE AND DEGREES OF COMPACTION, IN THE AREAS INDICATED:
 

|                           | <u>HORIZONTAL</u> | <u>VERTICAL</u> | <u>COMPACTION</u> |
|---------------------------|-------------------|-----------------|-------------------|
| A. PAVEMENT AREA SUBGRADE | 0.15" +           | +0.0' TO -0.1'  | SEE SOILS REPORT  |
| B. ENGINEERED FILL        | 0.5" +            | +0.1' TO -0.1'  | SEE SOILS REPORT  |
- COMPACTION TESTING WILL BE PERFORMED BY THE OWNER OR HIS REPRESENTATIVE.
7. ALL CUT AND FILL SLOPES SHALL BE PROTECTED UNTIL EFFECTIVE EROSION CONTROL HAS BEEN ESTABLISHED.
8. THE USE OF POTABLE WATER WITHOUT A SPECIAL PERMIT FOR BUILDING OR CONSTRUCTION PURPOSES INCLUDING CONSOLIDATION OF BACKFILL OR DUST CONTROL IS PROHIBITED. THE CONTRACTOR SHALL OBTAIN ALL NECESSARY PERMITS FOR CONSTRUCTION WATER.
9. THE CONTRACTOR SHALL MAINTAIN THE STREETS, SIDEWALKS AND ALL OTHER PUBLIC RIGHT-OF-WAY IN A CLEAN, SAFE AND USABLE CONDITION. ALL SPILLS OF SOIL, ROCK OR CONSTRUCTION DEBRIS SHALL BE PROMPTLY REMOVED FROM THE PUBLICLY OWNED PROPERTY DURING CONSTRUCTION AND UPON COMPLETION OF THE PROJECT. ALL ADJACENT PROPERTY, PERSONS AND PROPERTY SHALL BE MAINTAINED IN A CLEAN, SAFE AND USABLE CONDITION.

1. ALL CONSTRUCTION AND MATERIALS SHALL BE IN ACCORDANCE WITH THE LATEST EDITION OF THE DESIGN AND CONSTRUCTION STANDARDS FOR WASTEWATER COLLECTION SYSTEMS AND THE UNIFORM STANDARD SPECIFICATIONS FOR PUBLIC WORKS' CONSTRUCTION OFF-SITE IMPROVEMENTS, CLARK COUNTY AREA, NEVADA, AS AMENDED. IT WILL BE THE RESPONSIBILITY OF THE CONTRACTOR TO BE AWARE OF THE CONTENT OF THE ABOVE SPECIFICATIONS.

2. IT SHALL BE THE CONTRACTOR'S RESPONSIBILITY TO PERFORM CONSTRUCTION AS PER PLANS, ANY ADDITIONS, DELETIONS, OR CHANGES SHALL FIRST MEET WITH THE APPROVAL OF THE CITY ENGINEER.
3. CHISEL "S" OR "G" IN CURBS WHERE SEWER OR GAS LATERALS PASS UNDER THE CURB.
4. POLYVINYL (PVC) SEWER PIPE SHALL MEET ASTM D-3034 SDR 35 SPECIFICATIONS, INSTALLED WITH SAND BEDDING AND BACKFILL OF TYPE II AGGREGATE BASE.
5. ALL MANHOLES PAVED IN STREETS EIGHTY (80') FOOT R/W AND LARGER SHALL HAVE CONCRETE COLLECTORS, STREETS LESS THAN EIGHTY (80') FOOT R/W WILL REQUIRE RETROFIT IF PAVING DOES NOT CONFORM TO CITY STANDARDS AT THE MANHOLE.
6. TEE SADDLES SHALL BE USED TO CONNECT SEWER LATERALS TO EXISTING MAIN LINES UP TO TWELVE INCH (12") DIAMETER, CONNECTIONS TO FIFTEEN INCH (15") OR LARGER MAINS SHALL REQUIRE SPECIAL PROCEDURES IN LINE "Y" S SHALL BE USED ON LINES TWELVE INCHES (12") OR ABOVE.
7. WATER MAINS SHALL BE PROTECTED IN ACCORDANCE WITH LVWD STANDARDS WHENEVER A SEWER MAIN CROSSES OVER A WATER MAIN OR THE SEWER IS LESS THAN EIGHTEEN INCH (18") UNDER A WATER MAIN.
8. ALL CONTRACTORS INSTALLING SEWER MAINS THAT WILL BE UNDER THE JURISDICTION OF THE CITY OF LAS VEGAS MUST BE STATE OF NEVADA CLASS "A" CONTRACTORS.
9. THE CITY OF LAS VEGAS WILL NOT ACCEPT ANY SEWER MAINS WHICH HAVE A VERTICAL DEFLECTION OF MORE THAN ONE TENTH (0.1) OF A FOOT FROM THE APPROVED CONSTRUCTION PLANS AT ANY LOCATION. SEWER MAINS TO BE MOVED TO EXCEED THIS TOLERANCE WILL HAVE TO BE REPAIRED OR REMOVED OR REPLACED TO THE SATISFACTION OF THE CITY ENGINEER PRIOR TO ACCEPTANCE BY THE CITY OF LAS VEGAS.
10. INSTALLATION OF CURVED SEWER REQUIRES THE USE OF C-900 PIPE WHICH ALLOWS FOR PIPE DEFLECTION AT THE JOINTS.

**STORMWATER RUNOFF MANAGEMENT**  
(REQUIRED FOR ALL SITES GREATER THAN 1 ACRE (43,560 SQ. FT.)

1. THE OWNER, SITE DEVELOPER, CONTRACTOR AND/OR THEIR AUTHORIZED AGENTS SHALL EACH DAY REMOVE ALL SEDIMENT, MUD, CONSTRUCTION DUST AND OTHER POTENTIAL POLLUTANTS THAT HAVE BEEN DISCHARGED TO, OR ACCUMULATED IN THE PUBLIC RIGHTS OF WAY OF THE CITY OF LAS VEGAS AS A RESULT OF CONSTRUCTION ACTIVITIES ASSOCIATED WITH THIS SITE DEVELOPMENT OR CONSTRUCTION PROJECT. SUCH MATERIALS SHALL BE PREVENTED FROM ENTERING THE STORM SEWER SYSTEM.
2. ADDITIONAL CONSTRUCTION SITE DISCHARGE BEST MANAGEMENT PRACTICES MAY BE REQUIRED BY THE OWNER AND HIS OR HER AGENTS DUE TO UNUSUAL OR EXTREMELY SEVERE WEATHER CONDITIONS THAT DOES NOT MEET THE PERFORMANCE STANDARDS SPECIFIED IN THE CITY OF LAS VEGAS AND THE LAS VEGAS VALLEY CONSTRUCTION SITE BEST MANAGEMENT PRACTICES MANUAL (MOST CURRENT EDITION).
3. TEMPORARY OR PERMANENT STABILIZATION PRACTICES WILL BE INSTALLED ON DISTURBED AREAS AS SOON AS PRACTICABLE AND NO LATER THAN 14 DAYS AFTER THE COMPLETION OF THE DISTURBED AREA. IF THE SITE HAS TEMPORARILY OR PERMANENTLY EXPOSED, SOME EXCEPTIONS MAY APPLY: REFER TO NEVADA STORMWATER GENERAL PERMIT FOR CONSTRUCTION ACTIVITY NVR100000, SECTION III.A.5.
4. AT A MINIMUM, THE CONTRACTOR OR HIS AGENT SHALL INSPECT ALL DISTURBED AREAS, AREAS USED FOR STORAGE OF MATERIALS AND EQUIPMENT THAT ARE EXPOSED TO PRECIPITATION, VEHICLE ENTRANCE AND EXIT, AND CONSTRUCTION AREAS WITHIN 24 HOURS OF ANY ACTUAL RAIN EVENT OF 0.5 INCHES OR MORE. THE CONTRACTOR OR HIS AGENT SHALL UPDATE OR MODIFY THE STORM WATER POLLUTION PREVENTION PLAN AND NEVADA STORMWATER GENERAL PERMIT FOR CONSTRUCTION INSPECTIONS MAY INCLUDE SUCH AS SUSPENSION OF LAND DISTURBANCE ACTIVITIES. REFER TO NEVADA STORMWATER GENERAL PERMIT FOR CONSTRUCTION ACTIVITY NVR100000, SECTION III.A.12.
5. ACCUMULATED SEDIMENT IN BMPs SHALL BE REMOVED WITHIN SEVEN DAYS AFTER A STORMWATER RUNOFF EVENT OR PRIOR TO THE NEXT ANTICIPATED STORM EVENT, WHICHEVER IS EARLIER. SEDIMENT MUST BE REMOVED WHEN BMP DESIGN CAPACITY HAS BEEN REDUCED BY 50 PERCENT OR MORE.

1. ALL STREET LIGHTING INSTALLATIONS SHALL BE IN ACCORDANCE WITH THE STREET LIGHTING PLANS, THE "UNIFORM STANDARD SPECIFICATIONS FOR PUBLIC WORKS CONSTRUCTION OFF-SITE IMPROVEMENTS, CLARK COUNTY AREA, NEVADA"; LATEST REVISION, AND THE "UNIFORM STANDARD DRAWINGS FOR PUBLIC WORKS CONSTRUCTION OFF-SITE IMPROVEMENTS, CLARK COUNTY AREA, NEVADA"; LATEST REVISION AND ANY ADOPTED SPECIAL AREA STANDARDS.

2. NO DEVIATION OF STREET LIGHT, PULL BOX, CONDUITS (ETC.) LOCATIONS SHALL BE PERMITTED WITHOUT WRITTEN APPROVAL OF THE CITY ENGINEERING AND THE CITY ENGINEER.
3. ALL EXISTING STREET LIGHTING SHALL REMAIN OPERATIONAL DURING CONSTRUCTION.
4. ALL STREET LIGHTING CONDUITS STUB SHALL HAVE AT LEAST ONE GREEN #8 THW WIRE INSTALLED, AS TRACER MRL. WHEN "EMPTY" CONDUIT IS COMPLETELY INSTALLED FROM PS TO PB, IT SHALL HAVE MINIMUM OF #8 AND #8 THW WIRE WITH THE ENDS "TAPED OR "SAFE OFF" PRIOR TO FINAL INSPECTION.
5. ANY STRUCTURE SUCH AS BLOCK WALLS, CHAIN LINK FENCES, RETAINING WALLS, ETC., SHALL LEAVE A MINIMUM CLEARANCE IN ACCORDANCE WITH USD NO. 320A.
6. AS-BUILT DRAWINGS SHALL BE SUPPLIED TO THE TEF0 PRIOR TO ANY PRE-FINAL INSPECTION. THE AS-BUILT DRAWING NEEDS TO BE STAMPED AS-BUILT AND SIGNED BY THE PREPARER.
7. SERVICE POINT SHALL BE COORDINATED WITH NV ENERGY COMPANY, AND WHEREVER POSSIBLE, BE LOCATED AT THE CENTER OF THE CIRCUIT. SERVICE POINTS SHALL BE SHOWN ON THE CIVIL PLANS.
8. IT SHALL BE ASSUMED THAT IN THE ABSENCE OF AN EXISTING WORKABLE CIRCUIT TO ATTACH TO, ALL INSTALLATIONS SHALL REQUIRE A NEW SERVICE FOR OPERATION OF THE CIRCUIT.
9. WHEREVER THERE IS AN OVERHEAD UTILITY THAT MAY CONFLICT WITH THE INSTALLATION OF STREET LIGHTING CIRCUITS AND/OR POLES, THESE CONFLICTS MUST BE RESOLVED BETWEEN THE DEVELOPER AND THE CITY OF LAS VEGAS, AT NO EXPENSE TO THE CITY OF LAS VEGAS, BEFORE STREETLIGHT BASES ARE INSTALLED.
10. THE CONTRACTOR SHALL FURNISH COMPLETE SERVICE TO TRANSFORMERS AND CONTROL SYSTEMS IF REQUIRED ON PLANS.
11. THE DEVELOPER/OWNER WILL BE REQUIRED TO SUPPLY POWER TO ALL NEW PUBLIC STREET LIGHTS INSTALLED UNDER THIS DESIGN PRIOR TO BOND RELEASE OR PROJECT COMPLETION. THE DEVELOPER/OWNER WILL BE RESPONSIBLE FOR ALL ITEMS ASSOCIATED WITH THE INSTALLATION, INCLUDING, BUT NOT LIMITED TO, DESIGN, MANUFACTURING AND OPERATIONAL COST OF SAID STREET LIGHTS PRIOR TO PROJECT COMPLETION. REFER TO THE PLAN FOR ANY NEW SERVICE REQUIREMENTS. THE TRANSFER OF OWNERSHIP FROM THE DEVELOPER/OWNER TO THE CITY OF LAS VEGAS FOR PUBLIC STREET LIGHTS UNDER THIS DESIGN SHALL BE INSTALLED UNDER THIS PLAN DESIGN WILL BE IN CONJUNCTION WITH THIS PROJECT COMPLETION. COORDINATE ALL MAINTENANCE AND OPERATIONAL TRANSFERS WITH THE CITY OF LAS VEGAS TRAFFIC ENGINEERING DEPARTMENT (TEF0) AT (702) 229-6331.

[illegible]

 **DWYER ENGINEERING INC.**  

---


CIVIL ENGINEERS      WATER RIGHTS  
LAND SURVEYORS      LAND USE PLANNING  
7310 SMOKE RANCH RD., SUITE E  
LAS VEGAS, NEVADA 89128  
tel: (702) 254-2200  
fax: (702) 254-2286

|                                                                                                            |
|------------------------------------------------------------------------------------------------------------|
| GENERAL NOTES                                                                                              |
| <p>PARK PLACE<br/>1141 S. LAS VEGAS BLVD.</p> <p>CITY OF LAS VEGAS, NEVADA      A.P.N.: 162-03-112-021</p> |

|               |          |
|---------------|----------|
| JOB No.       | 15464    |
| DATE:         | 10/30/17 |
| VERT. SCALE:  | N/A      |
| HORIZ. SCALE: | N/A      |
| DRAWN BY:     | JGR      |
| CHECKED BY:   | DAD      |
| SHEET         |          |
| 2 of 9        |          |
| 10227142      |          |
| CLV# 70003    |          |


PROJ#:124710 AGR:115969 QS:162-03-NW



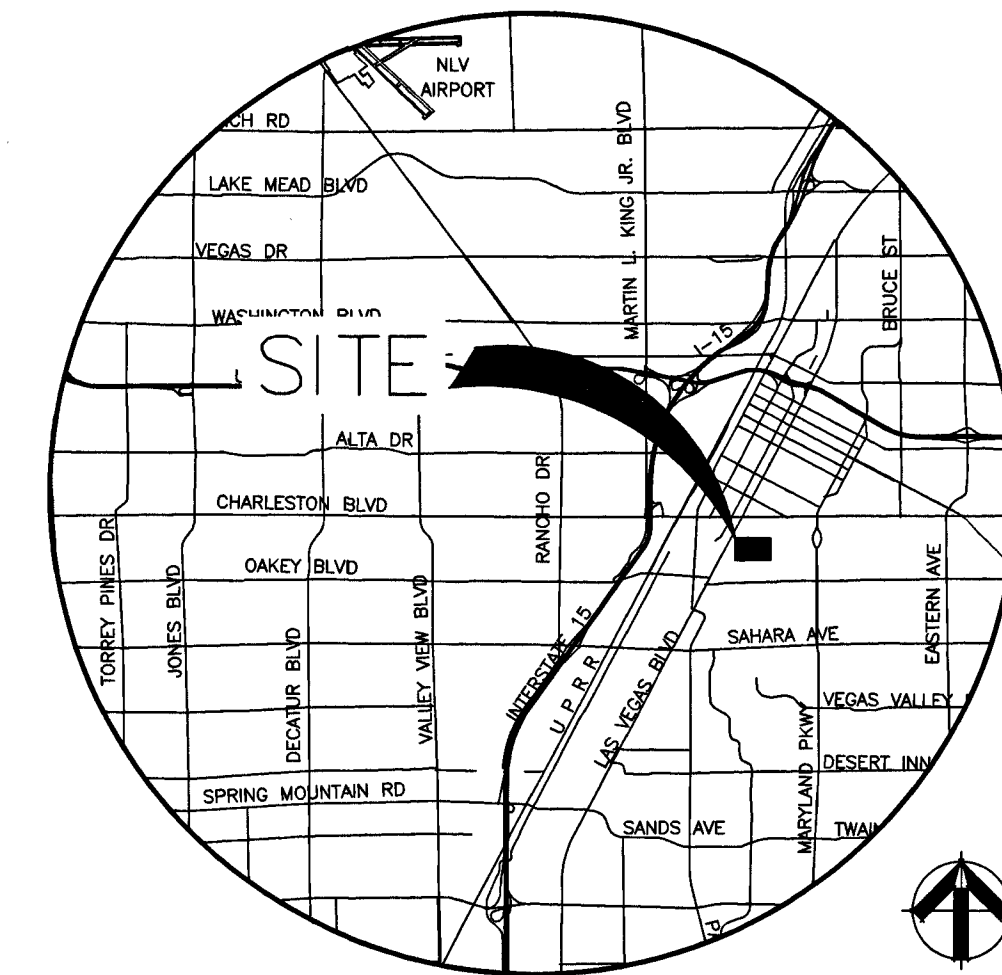

**SEE SHEET #1 FOR LEGEND AND ABBREVIATIONS**

 **DEMOLITION NOTES**

- |   | DEMOLITION AND REMOVAL                                                                                                                                                                                | AC                |
|---|-------------------------------------------------------------------------------------------------------------------------------------------------------------------------------------------------------|-------------------|
| 1 | DEMOLISH AND REMOVE PORTION OF EXISTING BUILDING AND FOUNDATION AS SHOWN.<br> -PORTION OF EX BUILDING TO BE DEMO'D | 1 EA (PRIVATE)    |
| 2 | COMPLETELY DEMOLISH AND REMOVE EXISTING AC PAVING.                                                                                                                                                    | 3525 SY (PRIVATE) |
| 3 | COMPLETELY DEMOLISH AND REMOVE EXISTING PUBLIC SIDEWALK ON LAS VEGAS BLVD. & PARK PASEO AS SHOWN.                                                                                                     | 4630 SF (PUBLIC)  |
| 4 | COMPLETELY DEMOLISH AND REMOVE EXISTING PUBLIC CURB AND GUTTER ON LAS VEGAS BLVD. & PARK PASEO AS SHOWN.                                                                                              | 230 LF (PUBLIC)   |
| 5 | EXISTING POWER LINES AND POLE TO BE REMOVED/RELOCATED PER NV ENERGY AND ELECTRICAL PLANS.                                                                                                             |                   |
| 6 | PROTECT EXISTING FIRE HYDRANT IN PLACE.                                                                                                                                                               |                   |
| 7 | CONTACT SWG CONSTRUCTION AT 702-668-6107 TO ADJUST VALVE CAN TO GRADE.                                                                                                                                |                   |

### ESTIMATED QUANTITIES

1 EA (PRIVATE)

3525 SY (PRIVATE)

4630 SF (PUBLIC)

230 LF (PUBLIC)

**GENERAL DEMOLITION NOTES:**

1. REPLACE ALL TRAFFIC CONTROL DEVICES (SIGNS OR PAVEMENT MARKINGS), UNDER CITY OF LAS VEGAS JURISDICTION, THAT ARE DAMAGED, DISTURBED, DESTROYED, MOVED OR MODIFIED BY TRENCHING ACTIVITY OR DEMOLITION ACTIVITY, TO CITY OF LAS VEGAS SATISFACTION. ALL MATERIAL USED SHALL MEET CITY OF LAS VEGAS SPECIFICATIONS OR WILL BE AN APPROVED EQUIVALENT.
2. IN THE EVENT THAT THE TRAFFIC SIGNAL CONDUITS, LOOP DETECTORS OR ASSOCIATED EQUIPMENT ARE DAMAGED BY THE CONTRACTOR, THE CONTRACTOR WILL HIRE AN INMS LEVEL II ELECTRICAL CONTRACTOR TO MAKE REPAIRS PER UNIFORM SPECIFICATION NO. 623.3.01.02.

**NOTE**

— PROTECT IN PLACE AND ADJUST LVVWD EXISTING FACILITIES TO FINISH GRADE. ALL LVVWD FACILITIES SHALL BE ACCESSIBLE AT ALL TIMES.

ESN. 078

01/05/15

**BENCHMARK**  
CITY OF LAS VEGAS VERTICAL CONTROL V2003 (NAVD 88)  
BENCHMARK NO. 418203H NDOT BRASS CAP MONUMENT TOP CURB @ SE CORNER OF  
LAS VEGAS BLVD. & CHARLESTON BLVD. (STAMPED 418203H 1998 GIS CONTROL  
MONUMENT).  
NAVD 88 DATUM 615.624 METERS (2019.76 FEET)

## BASIS OF BEARING

NORTH 27°54'36" EAST BEING THE CENTERLINE OF LAS VEGAS BOULEVARD SOUTH BETWEEN PARK PASEO AND CHARLESTON BOULEVARD AS SHOWN ON RECORD OF SURVEY MAPS, FILE 82, PAGE 84 OF CLARK COUNTY, NEVADA OFFICIAL RECORDS.

APN: 162-03-112-034  
NOT A PART  
1133 S. LAS VEGAS BLVD  
MONTEREY MOTEL CORP.  
EX BUILDING  
FF=(2022.47)

APN:162-03-112-021  
SUBJECT PROPERTY  
1141 S. LAS VEGAS BLVD.  
3250 SPRING MOUNTAIN  
TRUST & LOVE LANNY D TRUSTEE  
AREA=47,606± SF  
=1.09 ACRES

APN:162-03-112-034  
NOT A PART  
1133 S. LAS VEGAS BLVD  
MONTEREY MOTEL CORP.

EX 1 1/2" METER  
ACCT. #8829  
TO BE ABANDONED  
PER SHEET 6


EX BUILDING  
FF=(2021.94'

APN: 162-03-113-00  
GUY WALKER AND  
1100S. 5TH PARK LLC

APN: 162-03-106-001  
DECATUR ENTERPRISE

APPROVED FOR CONSTRUCTION

7 / 1. SHAR, KAR. JS  
LAS VEGAS VALLEY WATER DISTRICT ENGINEERING SERVICES MANAGER  
DATE: 11/20/17 PROJECT No. 124710  
LVWD APPROVED FIRE FLOW 1500 GPM AT 20 PSI RESIDUAL

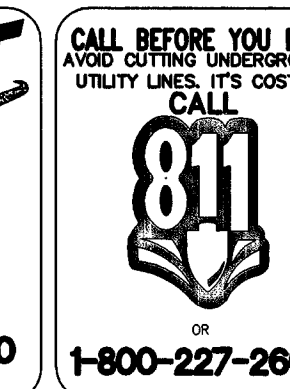

|         |  |
|---------|--|
| Job No. |  |
|---------|--|

FILE No. \_\_\_\_\_

REUSE OF DOCUMENTS

THIS DOCUMENT, AND THE IDEAS AND DESIGNS INCORPORATED HEREIN, AS AN INSTRUMENT OF PROFESSIONAL SERVICE IS THE PROPERTY OF

DWYER ENGINEERING, INC. AND IS NOT TO BE USED, IN THE WHOLE OR IN PART, FOR ANY OTHER PROJECT WITHOUT THE WRITTEN

OTHER PROJECT WITHOUT THE WRITTEN  
AUTHORIZATION OF DWYER ENGINEERING, INC.

|  |  |  |  |  |  |  |  |
|--|--|--|--|--|--|--|--|
|  |  |  |  |  |  |  |  |
|--|--|--|--|--|--|--|--|

|           |  |  |  |  |  |  |  |
|-----------|--|--|--|--|--|--|--|
| <b>ED</b> |  |  |  |  |  |  |  |
|-----------|--|--|--|--|--|--|--|

|      |  |  |  |  |  |  |
|------|--|--|--|--|--|--|
| NOV. |  |  |  |  |  |  |
|------|--|--|--|--|--|--|

|    |  |  |  |  |  |  |
|----|--|--|--|--|--|--|
| PR |  |  |  |  |  |  |
|----|--|--|--|--|--|--|

|     |  |  |  |  |  |
|-----|--|--|--|--|--|
| API |  |  |  |  |  |
|-----|--|--|--|--|--|

|   |  |  |  |  |  |  |
|---|--|--|--|--|--|--|
| 1 |  |  |  |  |  |  |
|---|--|--|--|--|--|--|

|  |  |  |  |  |  |  |
|--|--|--|--|--|--|--|
|  |  |  |  |  |  |  |
|--|--|--|--|--|--|--|

[illegible][illegible][illegible]



Job No.

FILE NO.

REUSE OF DOCUMENTS

THIS DOCUMENT AND THE IDEAS AND DESIGNS INCORPORATED HEREIN, AS AN INSTRUMENT OF PROFESSIONAL SERVICE, IS THE PROPERTY OF DWYER ENGINEERING, INC. AND IS NOT TO BE USED IN THE WHOLE OR IN PART FOR ANY OTHER PROJECT WITHOUT THE WRITTEN AUTHORIZATION OF DWYER ENGINEERING, INC.

APPROVED

REVISIONS

NO. DATE DESCRIPTION

NO. DATE

STATE OF NEVADA

DWYER ENGINEERING, INC.

DAVID A. DWYER

REGISTERED PROFESSIONAL CIVIL ENGINEER

NO. 7788

STAMP

DWYER ENGINEERING, INC.

CIVIL ENGINEERS

LAND SURVEYORS

WATER RIGHTS

LAND USE PLANNING

7710 BRIMMER RANCH RD., SUITE 8

LAS VEGAS, NEVADA 89126

(702) 854-2200

(702) 854-2209

FAX: (702) 854-2206

SECTIONS AND DETAIL SHEET

PARK PLACE

1141 S. LAS VEGAS BLVD.

CITY OF LAS VEGAS, NEVADA

APN: 162-03-112-021

JOB No.

15464

DATE:

10/30/17

VERT. SCALE:

N/A

HORIZ. SCALE:

N/A

DRAWN BY:

JGR

CHECKED BY:

DAD


SHEET

4 of 9

107V7142


CLV# 70003

10-30-17

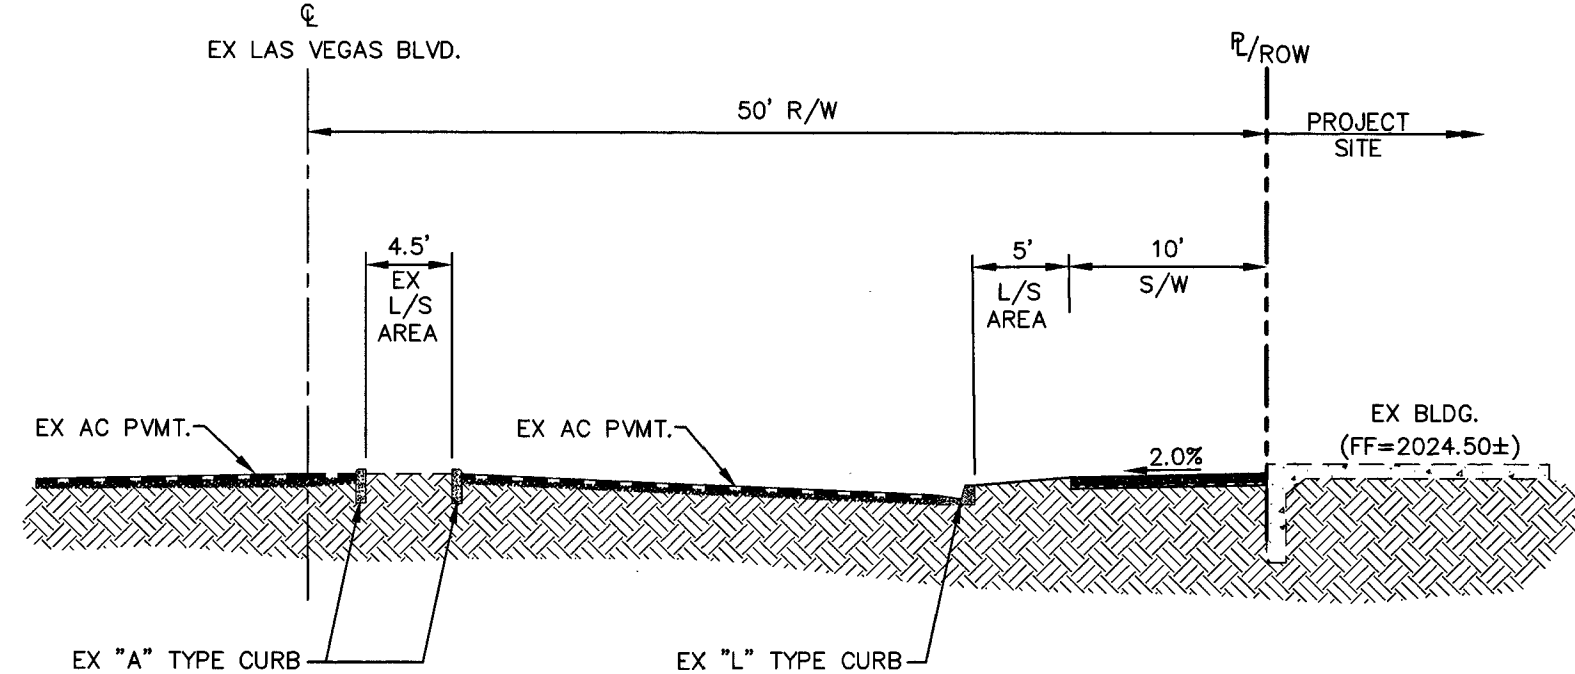


**GEOTECHNICAL NOTE:**  
ALL GRADING SHALL CONFORM TO THE SOIL REPORT.  
ENGINEER: NOVA GEOTECHNICAL  
DATE: FEBRUARY 29, 2016  
JOB NUMBER: E-16-020

**SECTION A - WEST P/L**  
NTS

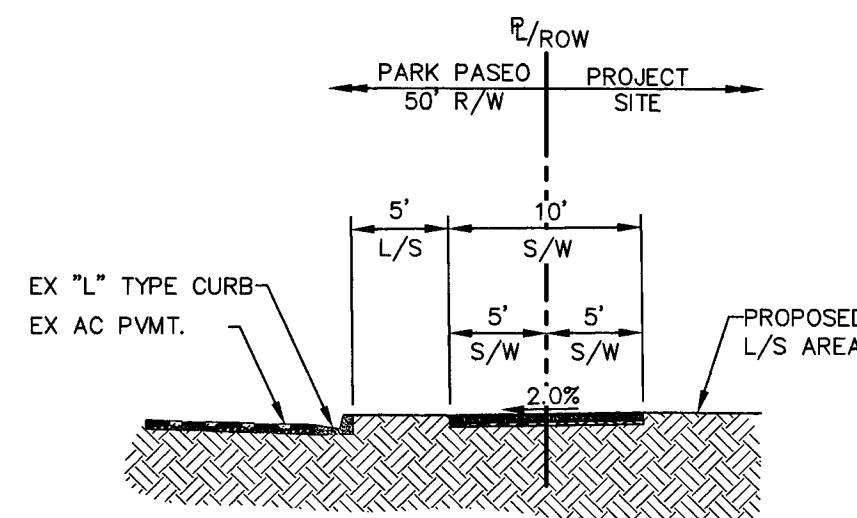


**GEOTECHNICAL NOTE:**  
ALL GRADING SHALL CONFORM TO THE SOIL REPORT.  
ENGINEER: NOVA GEOTECHNICAL  
DATE: FEBRUARY 29, 2016  
JOB NUMBER: E-16-020

**SECTION B - SOUTH P/L**  
NTS

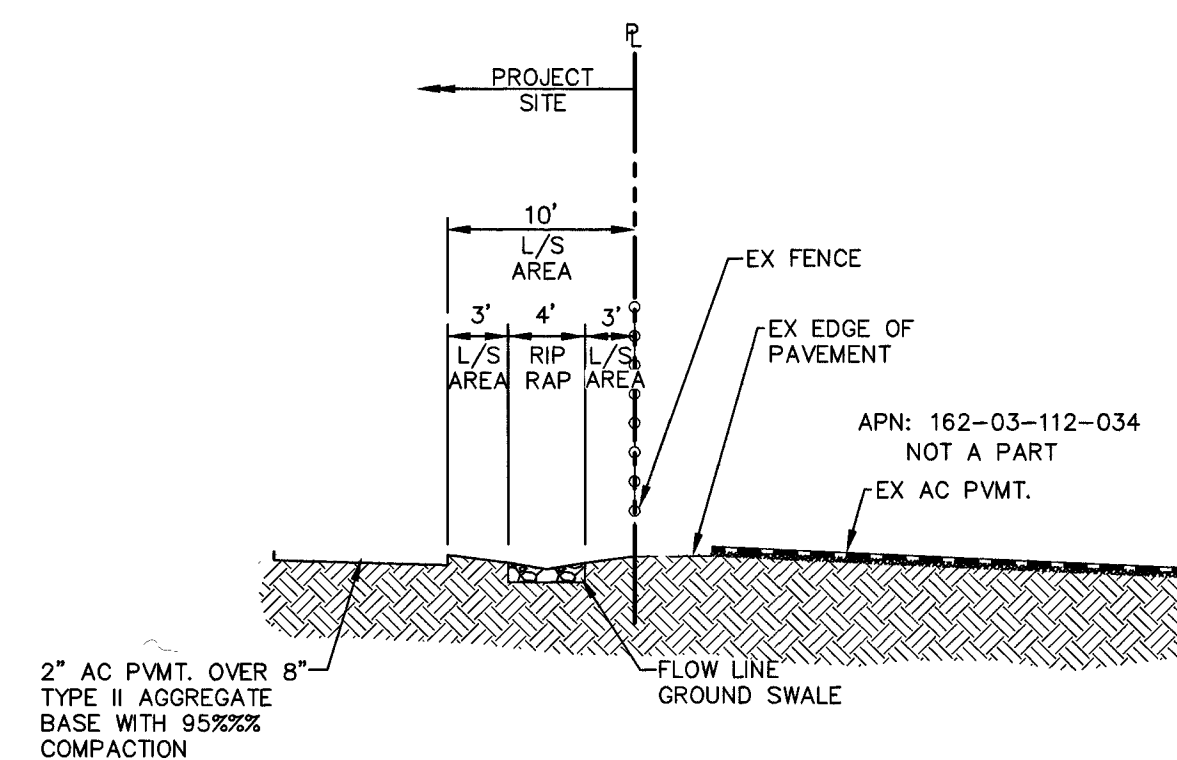



**GEOTECHNICAL NOTE:**  
ALL GRADING SHALL CONFORM TO THE SOIL REPORT.  
ENGINEER: NOVA GEOTECHNICAL  
DATE: FEBRUARY 29, 2016  
JOB NUMBER: E-16-020

**SECTION C - EAST P/L**  
NTS

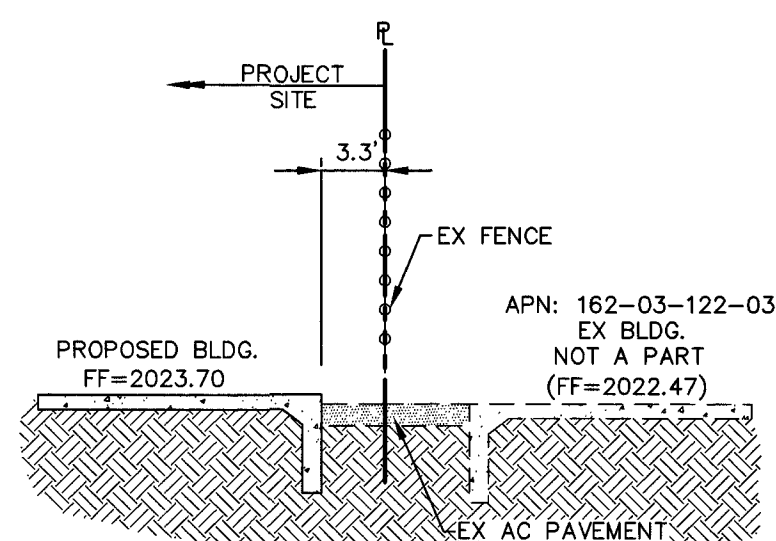


**GEOTECHNICAL NOTE:**  
ALL GRADING SHALL CONFORM TO THE SOIL REPORT.  
ENGINEER: NOVA GEOTECHNICAL  
DATE: FEBRUARY 29, 2016  
JOB NUMBER: E-16-020


**SECTION C - NORTH P/L**  
NTS

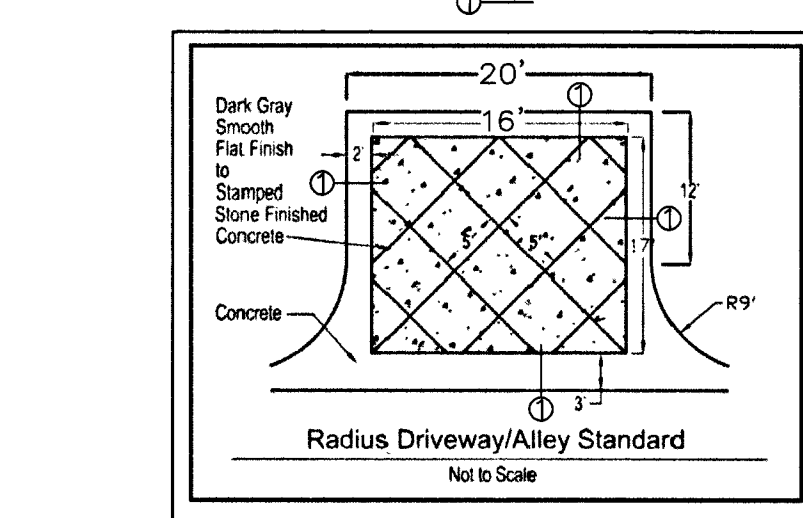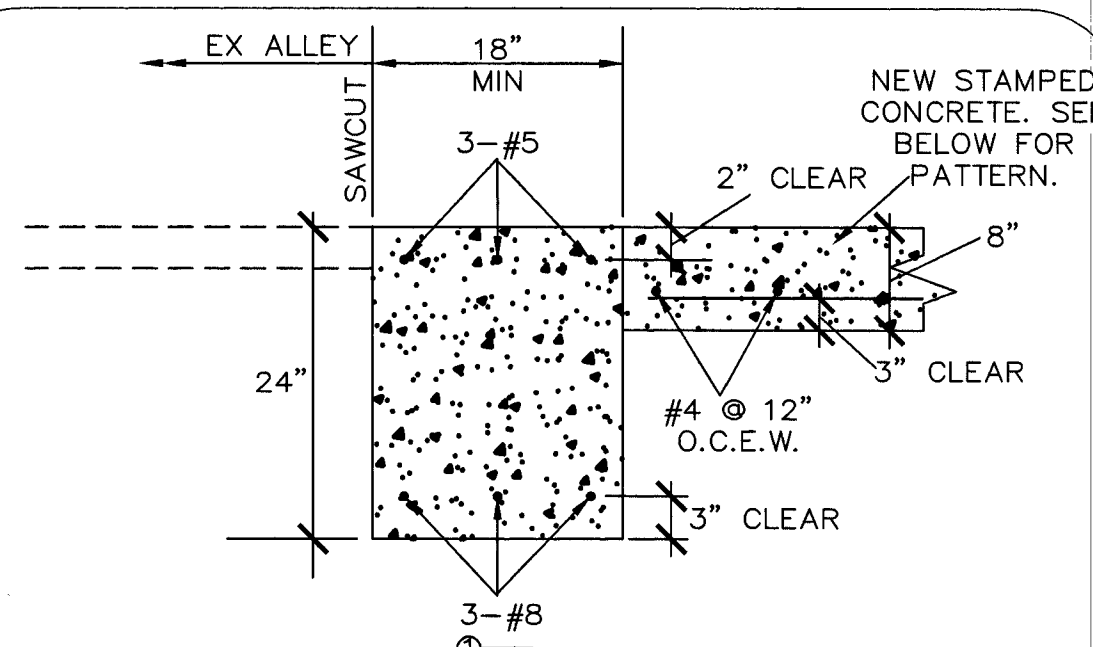

**DETAIL #1**  
**COMMERCIAL DRIVEWAY ENTRANCE**  
NTS

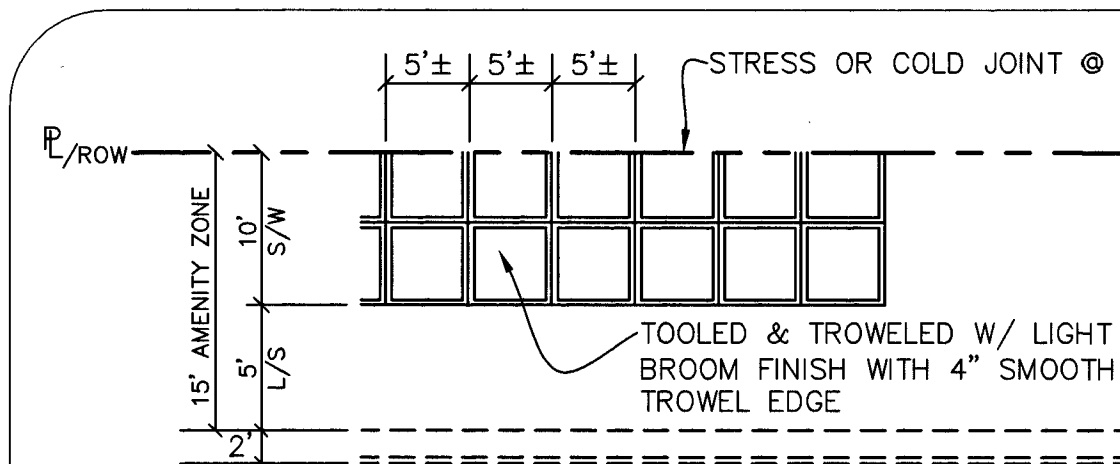


**DETAIL #2- SIDEWALK FINISH DETAIL**  
NTS

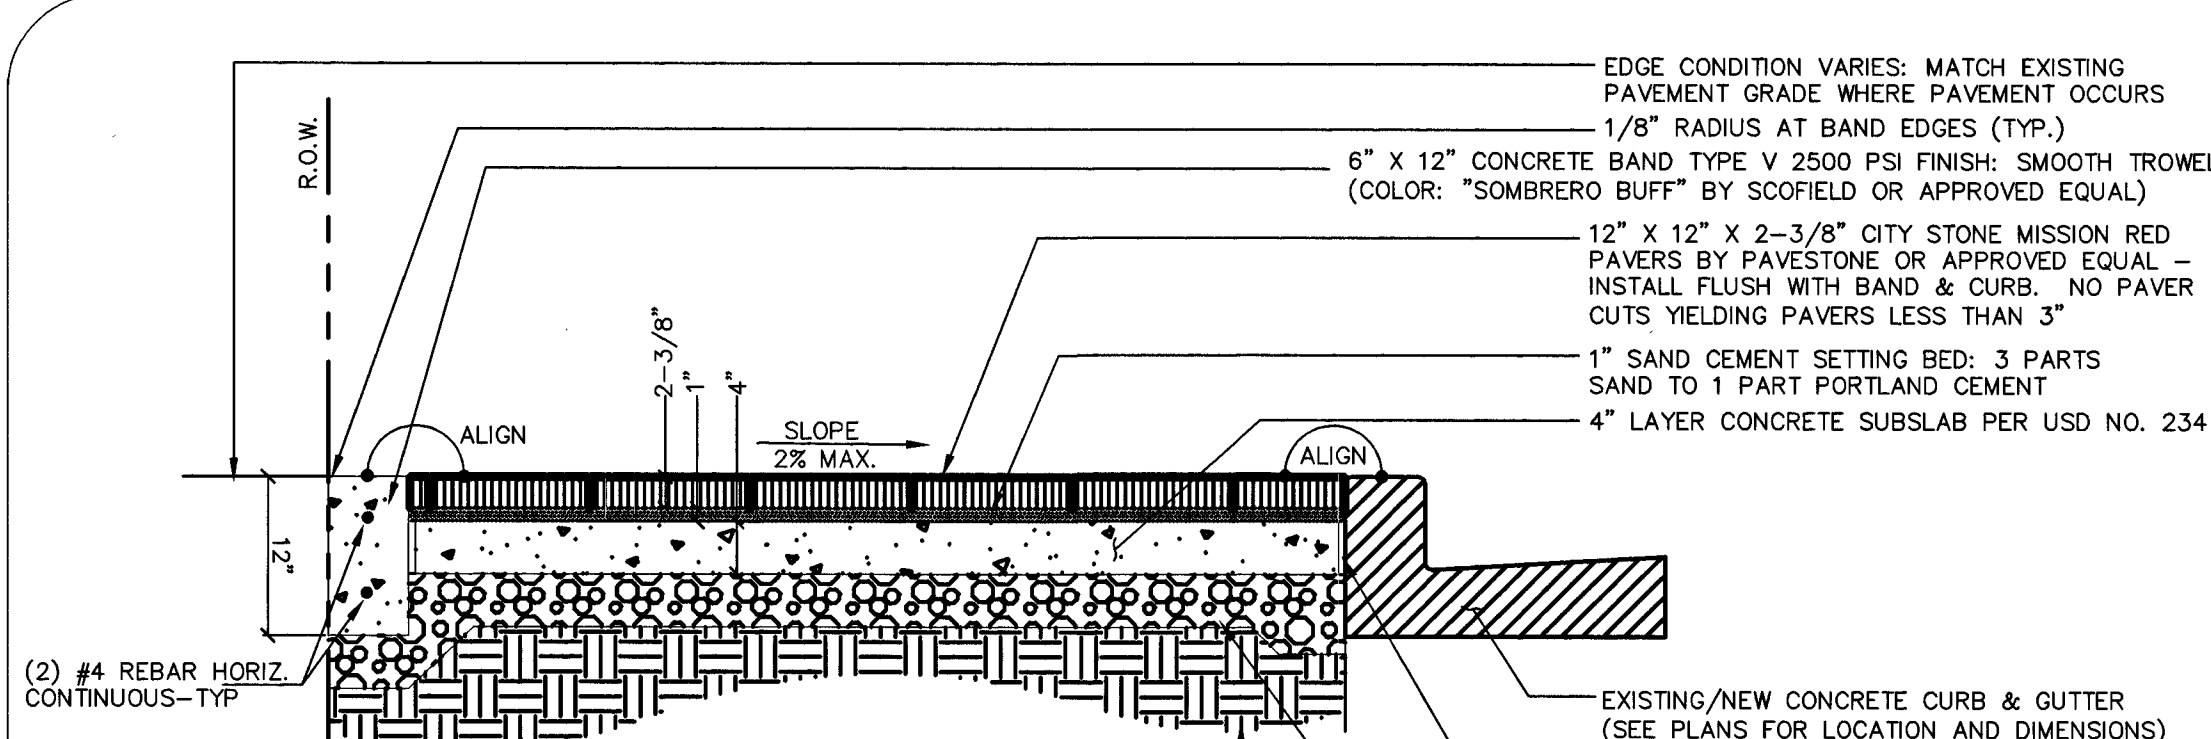


**NOTES:**  
1. ON ALL CURB RETURNS A 1/2" RADIUS EXPANSION JOINT SHALL BE CONSTRUCTED BETWEEN THE BACK OF CURB AND THE SIDEWALK FOR THE ENTIRE LENGTH OF THE RETURN. THE EXPANSION JOINT SHALL BE SEALED WITH SILICONE SEALANT AT THE SURFACE.  
2. LONGITUDINAL WEAKENED PLANE JOINT (CONTROL JOINT) REQUIRED AT MIDPOINT OF SIDEWALK 10' OR WIDER.  
3. SAND SWEEP ALL JOINTS - JOINTS BETWEEN PAVERS NOT TO EXCEED 1/8".


**DETAIL #3- TYPICAL SIDEWALK PAVERS W/6" BAND**  
NTS

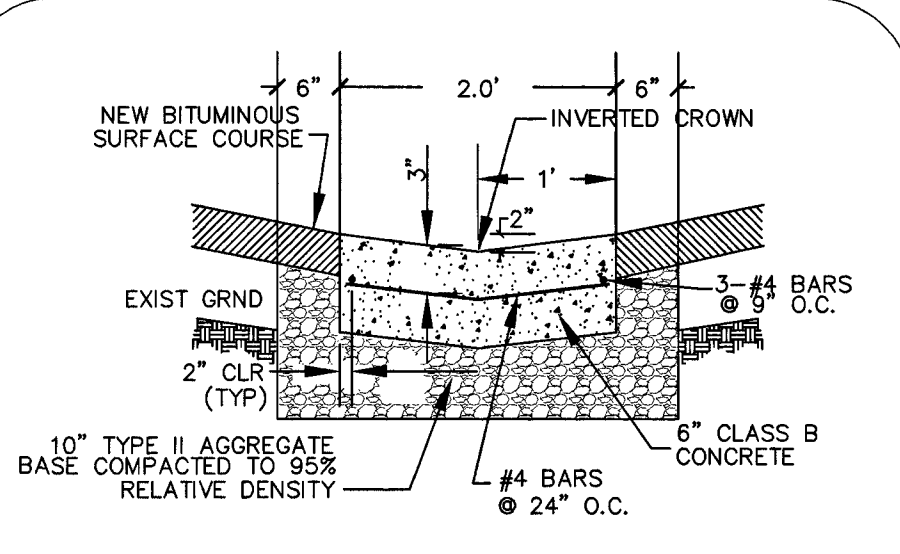


**DETAIL #4- 2' VALLEY GUTTER**  
NTS

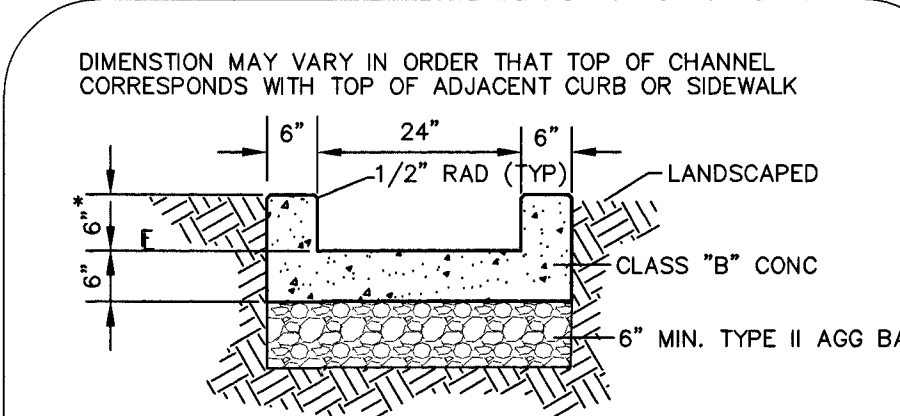

**DETAIL #5- 2' VALLEY GUTTER**  
NTS

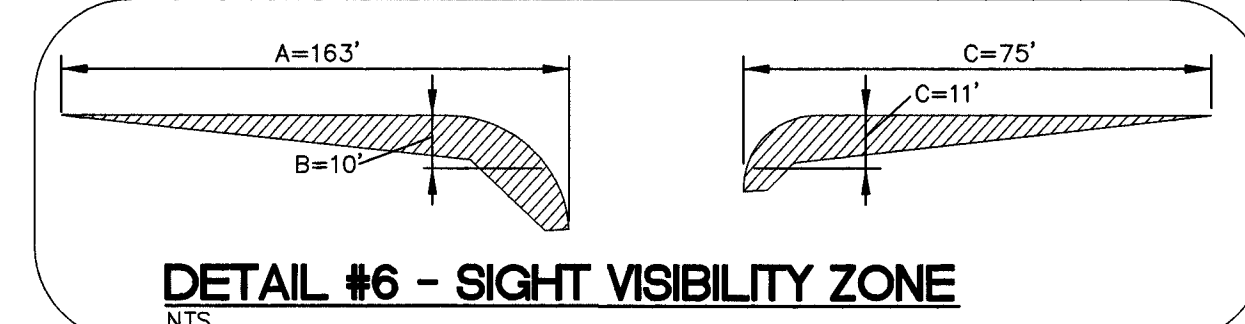


**DETAIL #6 - SIGHT VISIBILITY ZONE**  
NTS

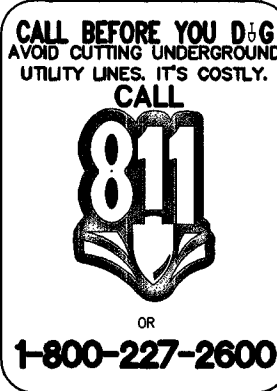



| CURVE TABLE |        |        |            |         |
|-------------|--------|--------|------------|---------|
| CURVE #     | LENGTH | RADIUS | DELTA      | TANGENT |
| C1          | 9.42'  | 9.00'  | 59°57'30"  | 5.19    |
| C2          | 9.41'  | 9.00'  | 59°52'30"  | 5.18    |
| C3          | 4.75'  | 3.00'  | 90°45'00"  | 3.04    |
| C4          | 20.51' | 10.00' | 117°30'00" | 16.48   |
| C20         | 9.42'  | 9.00'  | 60°00'00"  | 5.20    |
| C21         | 9.42'  | 9.00'  | 60°00'00"  | 5.20    |
| C25         | 4.11'  | 2.00'  | 117°45'00" | 3.31    |
| C26         | 6.12'  | 4.00'  | 87°40'00"  | 3.84    |
| C27         | 3.93'  | 2.50'  | 90°00'00"  | 2.50    |
| C30         | 3.93'  | 2.50'  | 90°10'30"  | 2.51    |
| C40         | 3.14'  | 2.00'  | 90°02'30"  | 2.00    |
| C41         | 32.46' | 27.50' | 67°38'00"  | 18.42   |
| C42         | 3.63'  | 2.00'  | 104°00'00" | 2.56    |
| C43         | 4.68'  | 3.00'  | 89°24'00"  | 2.97    |

NOTE: CURVE AND LINE DATA APPLIES TO BACK OF CURB.

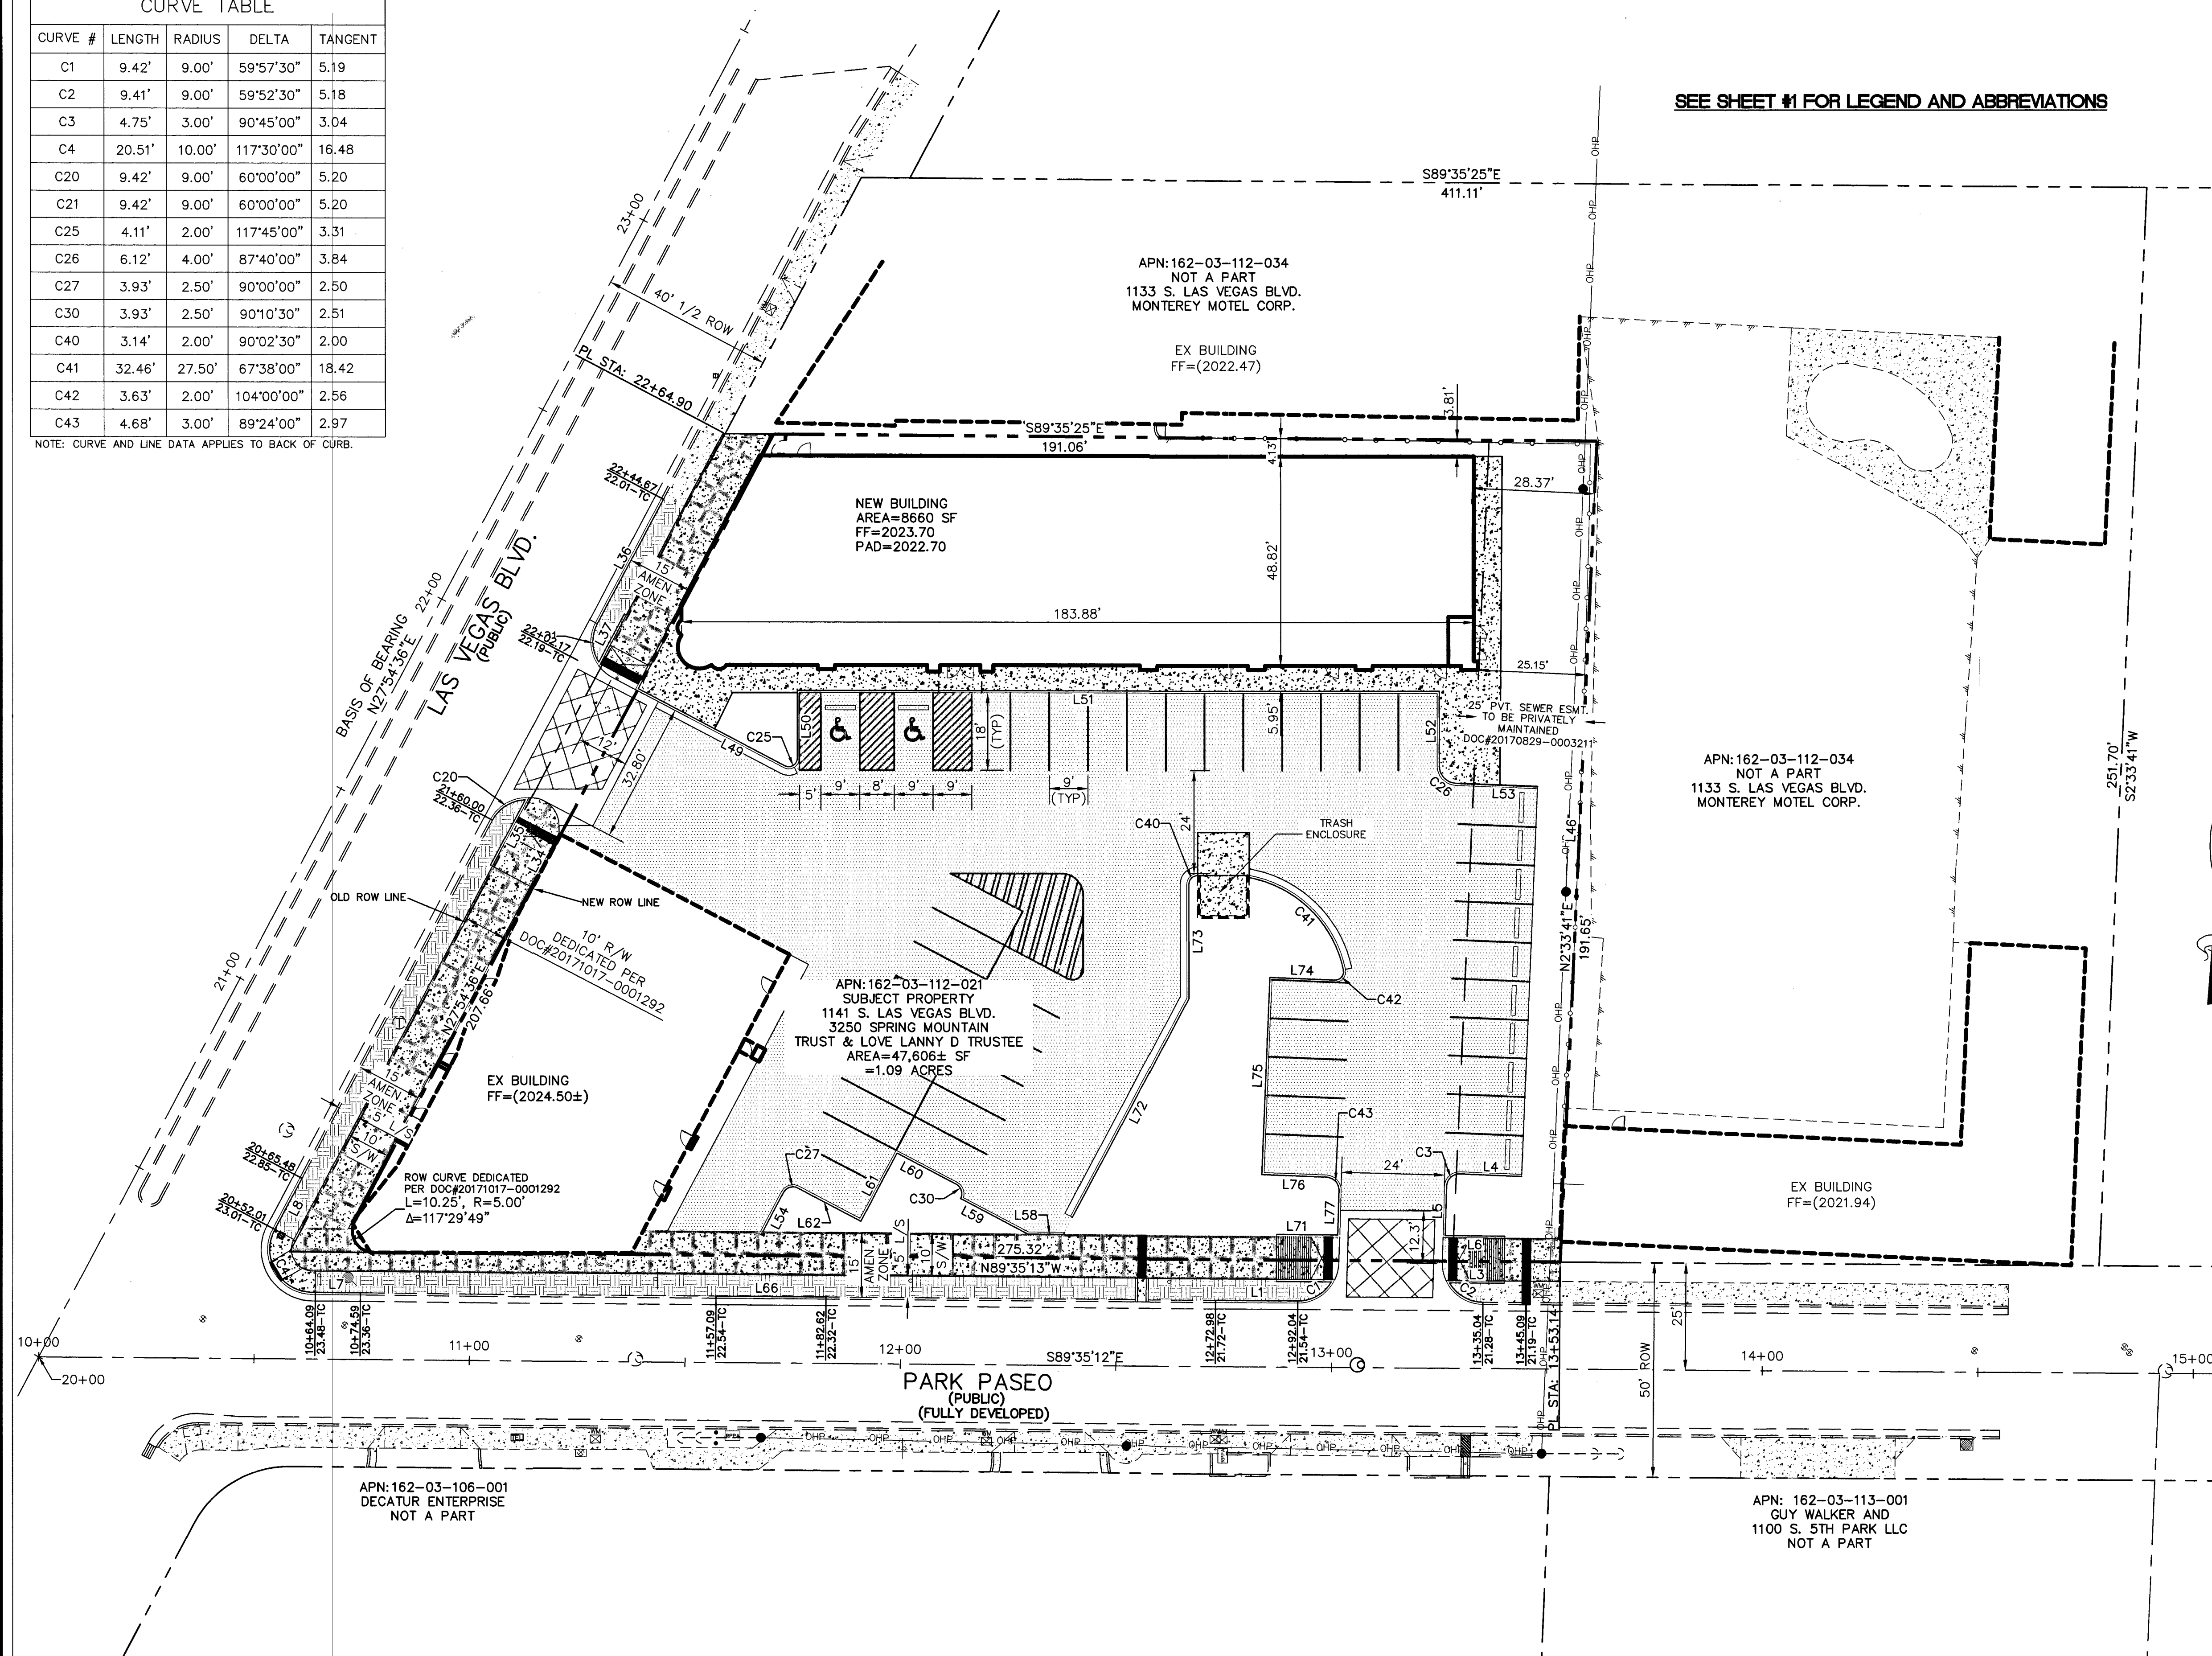


SEE SHEET #1 FOR LEGEND AND ABBREVIATIONS



VICINITY MAP  
T21S/R61E/ SEC 3

SCALE: NONE

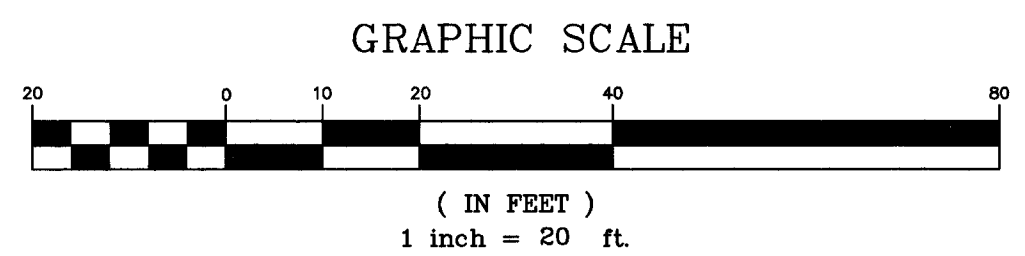

| LINE TABLE |         |                  |
|------------|---------|------------------|
| LINE #     | LENGTH  | DIRECTION        |
| L1         | 19.05'  | S89° 34' 55.39"E |
| L3         | 12.73'  | S89° 33' 32.15"E |
| L4         | 14.34'  | S87° 40' 00.00"E |
| L5         | 11.46'  | N1° 34' 48.34"E  |
| L6         | 13.82'  | N89° 33' 32.15"W |
| L7         | 11.09'  | S89° 35' 13.00"E |
| L8         | 13.47'  | S27° 54' 36.00"W |
| L34        | 12.06'  | N27° 54' 18.00"E |
| L35        | 17.27'  | S27° 54' 18.00"W |
| L36        | 32.79'  | N27° 54' 12.68"E |
| L37        | 12.73'  | N27° 54' 18.00"E |
| L46        | 191.65' | S2° 33' 41.00"W  |
| L49        | 38.40'  | N62° 15' 00.00"W |
| L50        | 15.76'  | S0° 00' 00.00"E  |
| L51        | 149.00' | N90° 00' 00.00"W |
| L52        | 17.46'  | N0° 00' 00.00"E  |
| L53        | 18.96'  | N87° 40' 00.00"W |
| L54        | 10.32'  | S27° 48' 47.51"W |
| L58        | 8.24'   | S89° 33' 32.15"E |
| L59        | 17.68'  | N62° 11' 12.49"W |
| L60        | 15.50'  | N62° 11' 12.49"W |
| L61        | 18.00'  | N27° 48' 47.51"E |
| L62        | 16.50'  | N62° 11' 12.49"W |
| L66        | 25.53'  | S89° 34' 55.39"E |
| L71        | 14.15'  | S89° 33' 32.15"E |
| L72        | 57.84'  | S27° 48' 47.51"W |
| L73        | 26.61'  | S0° 02' 22.80"E  |
| L74        | 15.03'  | S87° 40' 00.00"E |
| L75        | 46.00'  | N2° 20' 00.00"E  |
| L76        | 15.03'  | N87° 40' 00.00"W |
| L77        | 10.35'  | N1° 44' 08.55"E  |

NOTE: CURVE AND LINE DATA APPLIES TO BACK OF CURB.

**BENCHMARK**  
CITY OF LAS VEGAS VERTICAL CONTROL V2003 (NAVD 88)  
BENCHMARK NO. 418203H NDOT BRASS CAP MONUMENT TOP CURB @ SE CORNER OF LAS VEGAS BLVD. & CHARLESTON BLVD. (STAMPED 418203H 1998 GIS CONTROL MONUMENT).  
NAVD 88 DATUM 615.624 METERS (2019.76 FEET)

**BASIS OF BEARING**  
NORTH 27°54'36" EAST BEING THE CENTERLINE OF LAS VEGAS BOULEVARD SOUTH BETWEEN PARK PASEO AND CHARLESTON BOULEVARD AS SHOWN ON RECORD OF SURVEY MAPS, FILE 82, PAGE 84 OF CLARK COUNTY, NEVADA OFFICIAL RECORDS.

Job No. 15464

DATE: 11/06/17

VERT. SCALE: N/A

HORIZ. SCALE: 1"=20'

DRAWN BY: JGR

CHECKED BY: DAD

SHEET 5 of 9

107V7142

CLV# 70003

REUSE OF DOCUMENTS

THIS DOCUMENT AND THE DATA AND DESIGN INFORMATION INCORPORATED HEREIN, AS AN INSTRUMENT OF PROFESSIONAL SERVICE, IS THE PROPERTY OF DWYER ENGINEERING, INC. AND IS NOT TO BE USED IN ANY PROJECT WITHOUT THE WRITTEN AUTHORIZATION OF DWYER ENGINEERING, INC.

APPROVED

REVISIONS

NO. DATE DESCRIPTION

PROFESSIONAL SEAL OF NEVADA

DAVID A. DWYER

Exp. 12/22

CIVIL

STAMP

DWYER ENGINEERING, INC.

WATER RIGHTS

LAND USE PLANNING

CIVIL ENGINEERS

LAND SURVEYORS

7310 SMOKE RANCH RD., SUITE B

LAS VEGAS, NEVADA 89130

(702) 254-2800

Fax: (702) 254-2808


HORIZONTAL CONTROL PLAN

PARK PLACE

1141 S. LAS VEGAS BLVD.

CITY OF LAS VEGAS, NEVADA

APN: 162-03-112-021

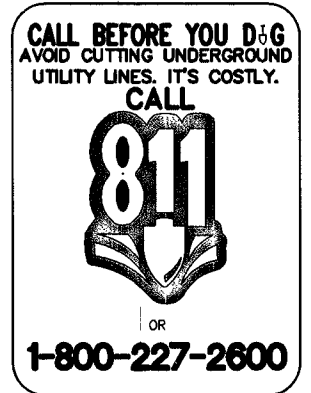

11-1-17



**UTILITY NOTE**  
THE LOCATION OF UNDERGROUND UTILITIES SHOWN HEREON HAS BEEN DETERMINED FROM SURFACE EVIDENCE OF THEIR EXISTENCE OR FROM VERY LIMITED INFORMATION OBTAINED FROM THE UTILITY COMPANIES. THE ENGINEER ACCEPTS NO LIABILITY FOR THE EXISTENCE OR NONEXISTENCE OF UTILITY LINES. CONTRACTORS AND OTHERS USING THIS MAP MUST CONFIRM THE LOCATION OF UNDERGROUND LINES OR STRUCTURES WITH THE UTILITY COMPANIES PRIOR TO COMMENCING ANY EXCAVATION.

**NOTE:** REPLACE ALL TRAFFIC CONTROL DEVICES (SIGNS OR PAVEMENT MARKINGS), UNDER CITY OF LAS VEGAS JURISDICTION, THAT ARE DISTURBED, DESTROYED, MOVED OR MODIFIED BY TRENCHING ACTIVITY TO CITY OF LAS VEGAS' SATISFACTION. ALL MATERIAL USED SHALL MEET CITY OF LAS VEGAS SPECIFICATIONS OR WILL BE AN APPROVED EQUAL.

**SOUTHWEST GAS CONSTRUCTION NOTES**

1. IN THE EVENT OF NATURAL GAS EMERGENCIES CALL 911 OR 1-877-860-6020.
2. THERE SHALL BE A MINIMUM HORIZONTAL AND VERTICAL CLEARANCE OF 12-INCHES BETWEEN NATURAL GAS FACILITIES AND ANY UNDERGROUND FACILITIES AND/OR STRUCTURES, INCLUDING BUT NOT LIMITED TO WATER, SEWER, STORM DRAIN, COMMUNICATIONS AND ELECTRIC.
3. FOR VALVE ADJUSTMENT CONTACT 702-668-6107 FORTY EIGHT (48) HOURS PRIOR TO CONSTRUCTION.
4. IN THE EVENT OF A NATURAL GAS CONFLICT WITH PROPOSED UTILITIES AND/OR STRUCTURES CONTACT 702-365-2099.
5. SOUTHWEST GAS STAND BY CONTACT IS 702-400-1789.

**EASEMENT WITH TREES, SHRUBS, DECORATIVE ROCKS, BLOCK WALL OR FENCE**

TREES, SHRUBS, OR DECORATIVE ROCKS, AND ANY BLOCK WALL OR OTHER FENCE MATERIAL, SHALL BE ASSIGNED AND CONSTRUCTED AROUND THE EASEMENT(S) TO ALLOW THE DISTRICT DIRECT ACCESS TO THE VAULT(S), BACKFLOW ASSEMBLIES, AND PIPING FROM THE ADJACENT RIGHT-OF-WAY.

**SEWER/WATER CROSSING NOTE**

SEWER/STORM DRAINS CROSSING WATER LINES MUST CONFORM TO SECTION 2.22 OF THE UNIFORM DESIGN AND CONSTRUCTION STANDARDS FOR POTABLE WATER SYSTEMS (UDACS) FOR WATER AND SEWER STORM MAIN CROSSINGS AND CLEARANCES.

**NOTE:**

NO SANITARY SEWER CLEANOUTS ALLOWED IN PUBLIC RIGHT-OF-WAY.

**SEWER CLEANOUT NOTE**

NO SEWER CLEANOUTS ARE ALLOWED IN PUBLIC RIGHT-OF-WAY.

**SEWER CONTRIBUTION**

|                             |            |
|-----------------------------|------------|
| AVERAGE DAILY CONTRIBUTION: | 3375 GPD   |
| PEAK FLOW:                  | 11,475 GPD |



**SOUTHWEST GAS CONSTRUCTION NOTES**

1. IN THE EVENT OF NATURAL GAS EMERGENCIES CALL 911 OR 1-877-860-6020.
2. THERE SHALL BE A MINIMUM HORIZONTAL AND VERTICAL CLEARANCE OF 12-INCHES BETWEEN NATURAL GAS FACILITIES AND ANY UNDERGROUND FACILITIES AND/OR STRUCTURES, INCLUDING BUT NOT LIMITED TO WATER, SEWER, STORM DRAIN, COMMUNICATIONS AND ELECTRIC.
3. FOR VALVE ADJUSTMENT CONTACT 702-668-6107 FORTY EIGHT (48) HOURS PRIOR TO CONSTRUCTION.
4. IN THE EVENT OF A NATURAL GAS CONFLICT WITH PROPOSED UTILITIES AND/OR STRUCTURES CONTACT 702-365-2099.
5. SOUTHWEST GAS STAND BY CONTACT IS 702-400-1789.

APN:162-03-112-034  
NOT A PART  
1133 S. LAS VEGAS BLVD.  
MONTEREY MOTEL CORP.


EX BUILDING  
FF=(2022.47)

NEW BUILDING  
AREA=8660 SF  
FF=2023.70  
PAD=2022.70

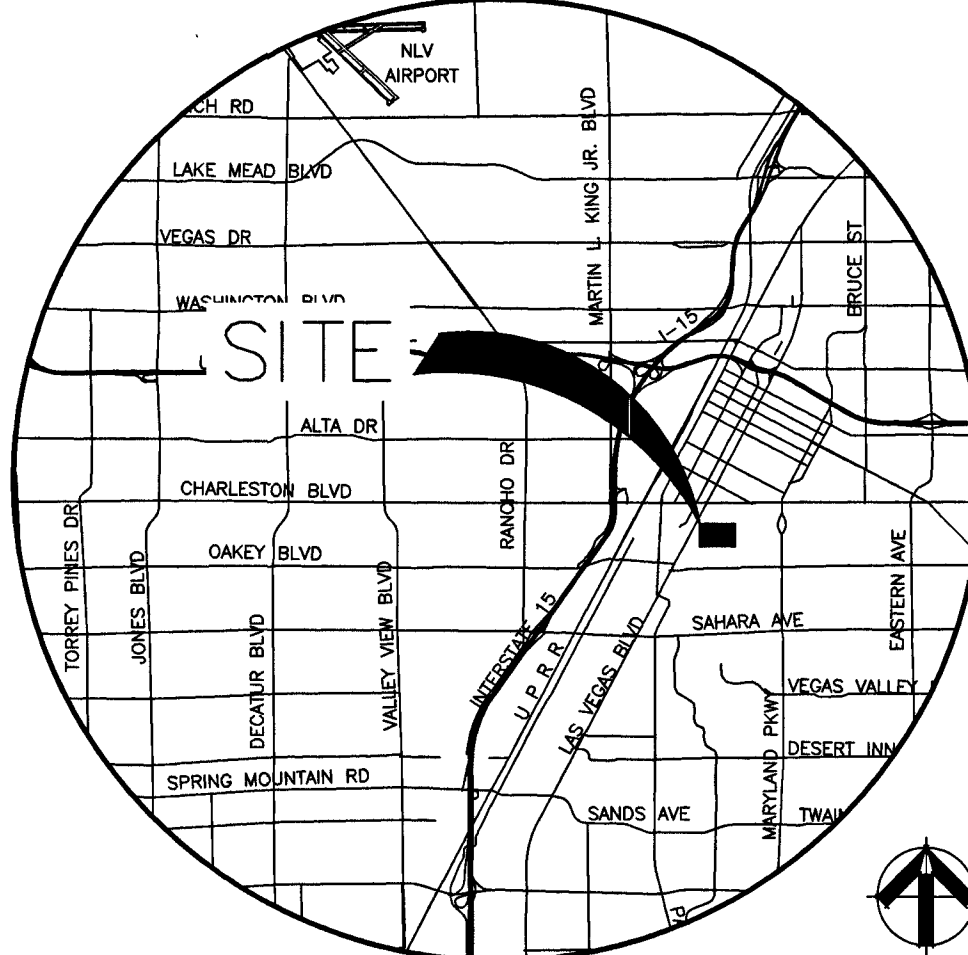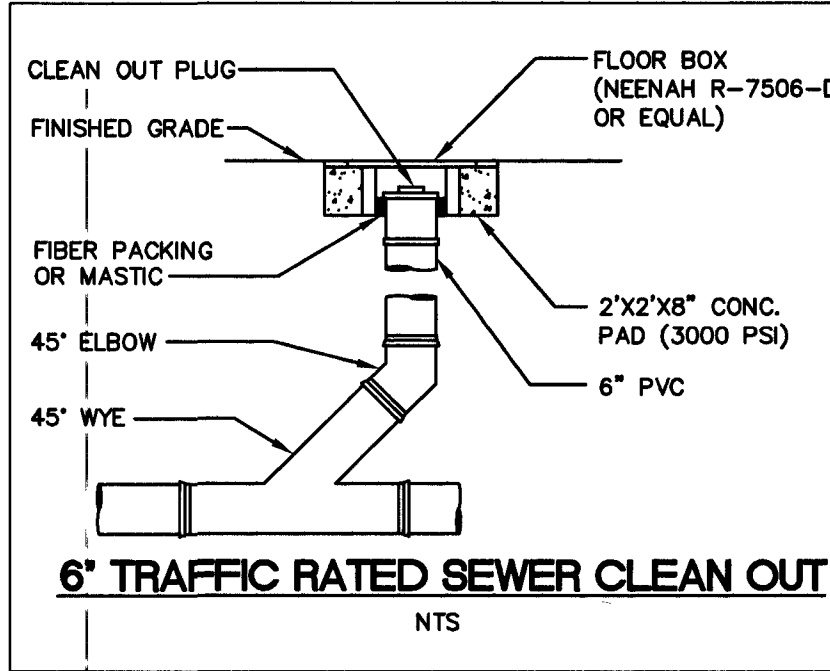

VICINITY MAP  
T21S/ R61E/ SEC 3  
GRAPHIC SCALE

SCALE: NONE

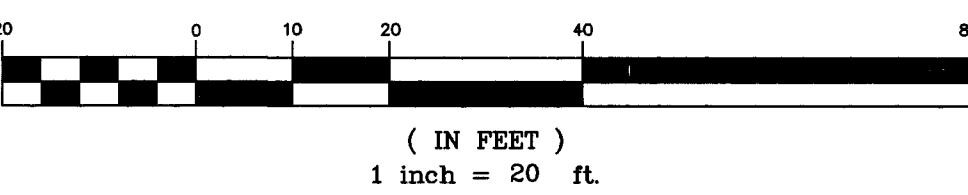

SEE SHEET #1 FOR LEGEND AND ABBREVIATIONS

**CONSTRUCTION NOTES**

1. INSTALL 1.5" DOMESTIC WATER SERVICE W/ 1.5" WATER METER PER UDACS PLATE NO. 4.
2. INSTALL 2" DOMESTIC WATER SERVICE W/ 2" WATER METER PER UDACS PLATE NO. 4. NOTE: THIS METER TO SERVICE EXISTING BUILDING UNTIL IT IS DEMO'D. THEN METER WILL SERVICE A POTENTIAL NEW BUILDING.
3. INSTALL 1.5" PVC WATER LINE (DOMESTIC) AND TRENCH BACKFILL PER UDACS PLATE NO. 16 & 17.
4. INSTALL 1.5" RPPA PER UDACS PLATE NO. 8. INSTALL BRASS LINE BETWEEN METER AND RPPA. SEE NOTE THIS SHEET.
5. INSTALL 8" x 8" TAPPING SLEEVE AND 8" TAPPING VALVE PER UDACS PLATE NO. 34 & 39 AND PER SECTION 2.24.01A OF UDACS.
6. INSTALL 8" RPPA PER UDACS PLATE NO. 56. SEE NOTE THIS SHEET.
7. INSTALL 8" PVC WATER LINE (FIRE) AND TRENCH BACKFILL PER UDACS PLATE NO. 16 & 17.
8. INSTALL 8" x 6" TEE PER UDACS PLATE NO. 31.
9. INSTALL 6" GATE VALVE PER UDACS PLATE NO. 30 & 39.
10. INSTALL 6" PVC WATER LINE (FIRE) AND TRENCH BACKFILL PER UDACS PLATE NO. 16 & 17.
11. INSTALL FIRE HYDRANT ASSEMBLY PER UDACS PLATE NO. 40.
12. INSTALL STANDARD 6" SEWER CLEANOUT AT BUILDING. SEE PLUMBING PLANS.
13. INSTALL TRAFFIC RATED 6" SEWER CLEANOUT PER DETAIL THIS SHEET.
14. INSTALL 8" C-900 WATER QUALITY PVC SEWER SERVICE LATERAL PER DCSWCS SD-17.
15. UTILITY PATCH PER STD DWG NO. 503 & 500.5. FINAL LIMITS OF RESTORATION SHALL BE DETERMINED BY FIELD INSPECTOR.
16. INSTALL 48" SEWER MANHOLE PER DCSWCS SD-1A & SD-1B.
17. INSTALL 90° BEND
18. INSTALL BOLLARDS PER UDACS PLATE NO. 75.
19. INSTALL 8" GATE VALVE PER UDACS PLATE NO. 30.
20. INSTALL 6" DUCTILE IRON PIPE (DIP)
21. INSTALL 2" RPPA PER UDACS PLATE NO. 8. INSTALL BRASS LINE BETWEEN METER AND RPPA. SEE NOTE THIS SHEET.
22. INSTALL 8" RPPA, 1 1/2" AND 2" RPPA'S WITH METERS PER SECTION A THIS SHEET.

**QUANTITIES**

- [1 EA (PUBLIC)]
- [1 EA (PUBLIC)]
- [139 LF (PRIVATE)]
- [1 EA (PRIVATE)]
- [1 EA LF (PUBLIC)]
- [1 EA (PUBLIC)]
- [25 LF (PUBLIC)]
- [141 LF (PRIVATE)]
- [1 EA (PRIVATE)]
- [1 EA (PRIVATE)]
- [46 LF (PRIVATE)]
- [1 EA (PRIVATE)]
- [1 EA (PRIVATE)]
- [160 LF (PRIVATE)]
- [25 SY (PUBLIC)]
- [1 EA (PUBLIC)]
- [1 EA (PRIVATE)]
- [2 EA (PRIVATE)]
- [2 EA (PUBLIC)]
- [13 LF (PUBLIC)]
- [1 EA (PRIVATE)]

**NOTE:**


ALL ABOVE GROUND UTILITY APPURTENANCES SHALL CONFORM TO THE REQUIREMENTS OF TITLE 19.06 & .08

**FIRE DEPARTMENT DATA**

FIRE REQUIREMENT IS 1500 GALLONS PER MINUTE AT 20 POUNDS PER SQUARE INCH RESIDUAL BASED ON:  
TOTAL SQUARE FOOTAGE 8660 SQ. FT.  
LARGEST AREA BETWEEN 4 HOUR SEPARATION WALLS: 8660 SQ. FT.  
BUILDING HEIGHT: 28 FEET  
NUMBER OF STORIES: 1  
TYPE OF CONSTRUCTION: V-B  
EXPOSURES:  
SPRINKLER SYSTEM: YES (1500 GPM)  
OCCUPANCY: W  
HIGH RISE STORAGE: NO  
ROOF CONSTRUCTION: WOOD  
**FIRE DEPARTMENT APPROVAL**  
APPROVAL BY THE FIRE DEPARTMENT HAVING JURISDICTION IS REQUIRED PRIOR TO OBTAINING FINAL APPROVAL FROM THE LVWD.

**APPROVALS**

CLV FIRE DEPARTMENT  
DATE 11/13/17

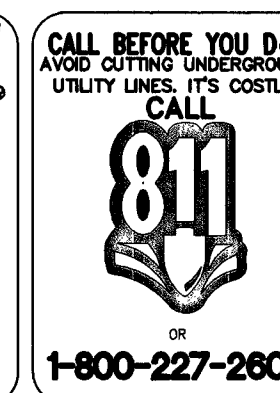

**APPROVAL**


SOUTHWEST GAS CORPORATION  
DATE  
APPROVED FOR CONSTRUCTION

LAS VEGAS VALLEY WATER DISTRICT ENGINEERING SERVICES MANAGER  
DATE: 11/20/17 PROJECT NO. 124710  
LVWD APPROVED FIRE FLOW 1500 GPM AT 20 PSI RESIDUAL SHEET #S 1, 2, 3 & 6

**BENCHMARK**  
CITY OF LAS VEGAS VERTICAL CONTROL V2003 (NAVD 88)  
BENCHMARK NO. 418203H NDOT BRASS CAP MONUMENT TOP  
CURB @ SE CORNER OF LAS VEGAS BLVD. & CHARLESTON BLVD. (STAMPED 418203H 1998 GIS CONTROL MONUMENT)  
NAVD 88 DATUM 615.624 METERS (2019.76 FEET)

**BASIS OF BEARING**

NORTH 27°54'36" EAST BEING THE CENTERLINE OF LAS VEGAS BOULEVARD SOUTH BETWEEN PARK PASEO AND CHARLESTON BOULEVARD AS SHOWN ON RECORD OF SURVEY MAPS, FILE 82, PAGE 84 OF CLARK COUNTY, NEVADA OFFICIAL RECORDS.

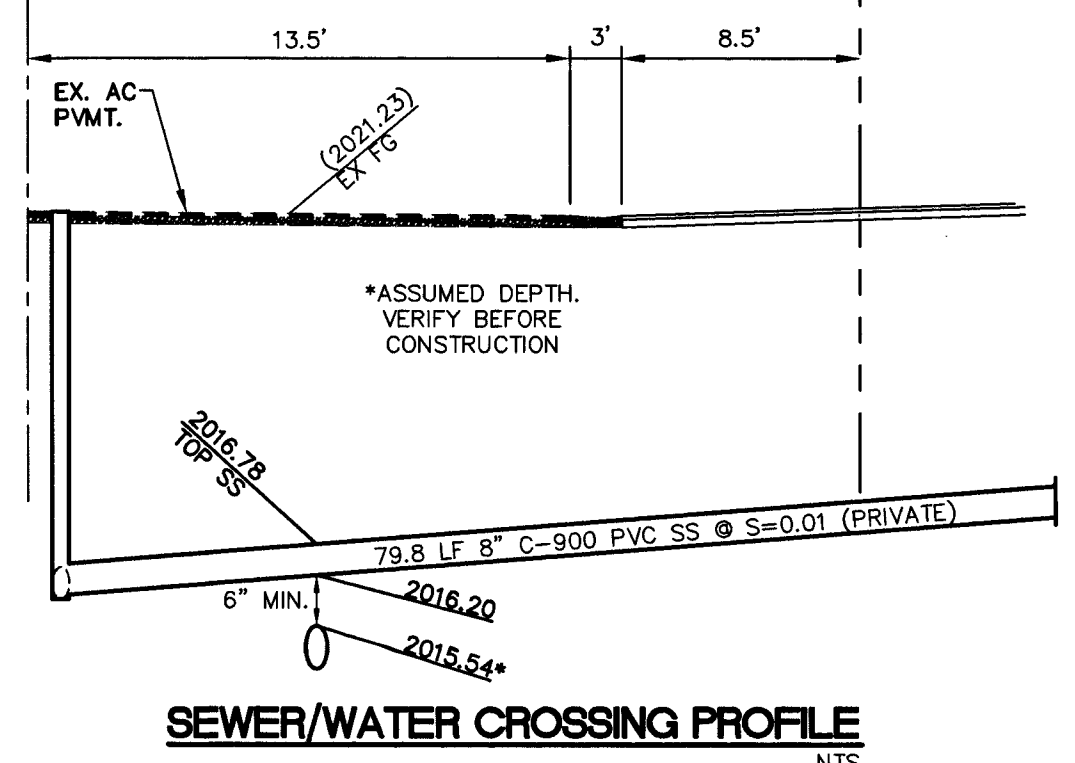

**REDUCED PRESSURE DETECTOR ASSEMBLY-RPDA (1-8")**

THE REDUCED PRESSURE DETECTOR ASSEMBLIES SHALL BE INSTALLED IN ACCORDANCE WITH THE UDACS PLATE NO. 56. NO WATER SHALL BE TAKEN FROM A SERVICE REQUIRING BACKFLOW PREVENTION UNTIL THE ASSEMBLY HAS BEEN SUCCESSFULLY TESTED BY THE CONTRACTOR. ANY BLOCK WALL OR OTHER FENCE MATERIAL SHALL BE DESIGNED AND CONSTRUCTED AROUND THE OUTSIDE OF THE EASEMENT(S) SO AS TO ALLOW BOLLARD CITY DIRECT ACCESS FROM THE ADJACENT RIGHT-OF-WAY. EASEMENTS SHALL BE CLEARLY MARKED OR STAKED PRIOR TO THE START OF CONSTRUCTION.


**REDUCED PRESSURE PRINCIPLE ASSEMBLY (1-2") (1-15")**

APPROVED PRESSURE PRINCIPLE ASSEMBLY(S) SHALL BE INSTALLED PER THE UDACS PLATE NO. 8. NO WATER SHALL BE TAKEN FROM A SERVICE REQUIRING BACKFLOW PREVENTION UNTIL THE REDUCED PRESSURE PRINCIPLE ASSEMBLY HAS BEEN SUCCESSFULLY TESTED BY THE CONTRACTOR. ANY BLOCK WALL OR OTHER FENCE MATERIAL SHALL BE DESIGNED AND CONSTRUCTED AROUND THE OUTSIDE OF THE EASEMENT(S) SO AS TO ALLOW BOLLARD CITY DIRECT ACCESS FROM THE ADJACENT RIGHT-OF-WAY. EASEMENTS SHALL BE CLEARLY MARKED OR STAKED PRIOR TO THE START OF CONSTRUCTION.

**ABANDONMENT OF EXISTING SERVICE(S) - 2" AND SMALLER**

THE CONTRACTOR SHALL NOTIFY THE INSPECTION DIVISION AT THE LVWD (702-258-3227) 48 HOURS PRIOR TO THE REQUESTED REMOVAL TIME TO ALLOW THE DISTRICT TO TAKE THE FINAL METER READING. AFTER THE FINAL READING THE CONTRACTOR MAY THEN BEGIN REMOVAL PROCEDURES FOR THE AFFECTED SERVICE AS FOLLOWS:  
EXISTING SERVICE LATERALS THAT ARE TO BE ABANDONED FROM THE EXISTING WATER MAINS SHALL HAVE THE CORPORATION STOPS TURNED OFF AT THE MAIN, A MINIMUM OF TWELVE (12) INCHES OF THE LATERAL CUT OUT NEAR THE CORPORATION STOPS, AND A BRASS CAP INSTALLED ON THE CORPORATION STOP. IF THE CORPORATION STOP IS DAMAGED BEYOND REPAIR OR PULLED FROM THE EXISTING WATER MAIN, THE MAIN SHALL BE REPAIRED AT THE CONTRACTORS EXPENSE, IN A MANNER APPROVED BY THE DISTRICT. IF THE CORPORATION STOP IS NOT WATER TIGHT, THE CONTRACTOR SHALL NOTIFY LVWD COMMUNICATION SUPPORT CENTER AT (702-258-7171) FOR FURTHER DIRECTION. THE EXISTING METER(S) SHALL BE REMOVED AND DELIVERED TO THE DISTRICT. THE CONTRACTOR SHALL REMOVE THE EXISTING SERVICE METER BOX AND APPURTENANCES, FILL AND GRADE ANY AND ALL RESULTING VOIDS, AND REPLACE OR RESTORE TO ORIGINAL CONDITIONS OR BETTER, ALL LANDSCAPING, IRRIGATION SYSTEMS, CONCRETE, SIDEWALKS, ASPHALT, OR ANY OTHER ITEMS DAMAGED OR REMOVED DURING THE REMOVAL OF THE EXISTING SERVICE METER BOX.

|                    |          |
|--------------------|----------|
| Job No.            | FILE No. |
| REUSE OF DOCUMENTS |          |
| APPROVED           |          |
| REVISIONS          |          |
| NO.                | DATE     |

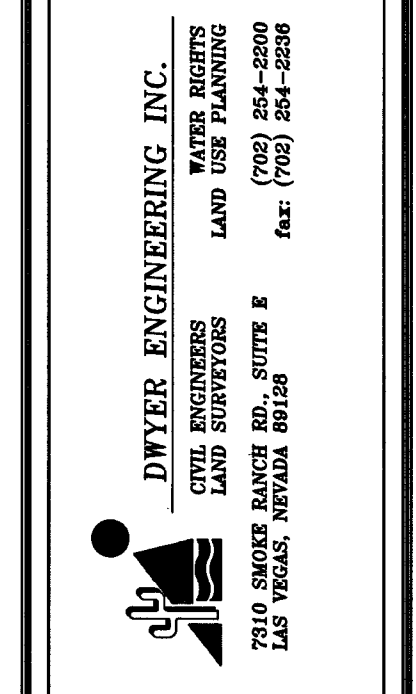

**UTILITY PLAN**  
PARK PLACE  
1141 S. LAS VEGAS BLVD.  
A.P.N.: 162-03-112-021  
CITY OF LAS VEGAS, NEVADA

|               |          |
|---------------|----------|
| Job No.       | 15464    |
| DATE:         | 11/06/17 |
| VERT. SCALE:  | N/A      |
| HORIZ. SCALE: | 1"=20'   |
| DRAWN BY:     | JGR      |
| CHECKED BY:   | DAD      |
| SHEET         | 6 of 9   |
| CLV# 70003    |          |


11-C-17

PROJ#:124710 AGR:115969 QS:162433-NW







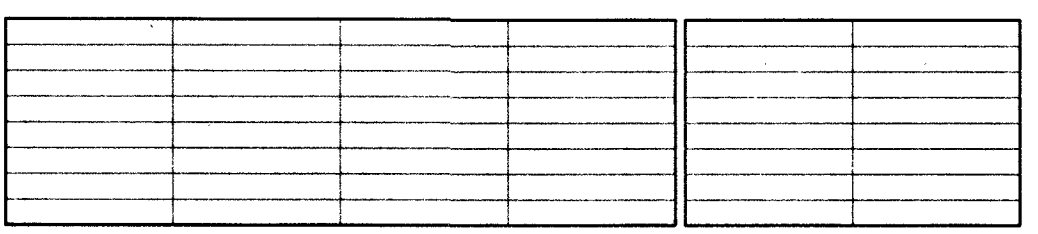

These plans are the sole property of : CHICAGO Landscaping

[illegible]

LANDSCAPE PLAN I

36x40



