
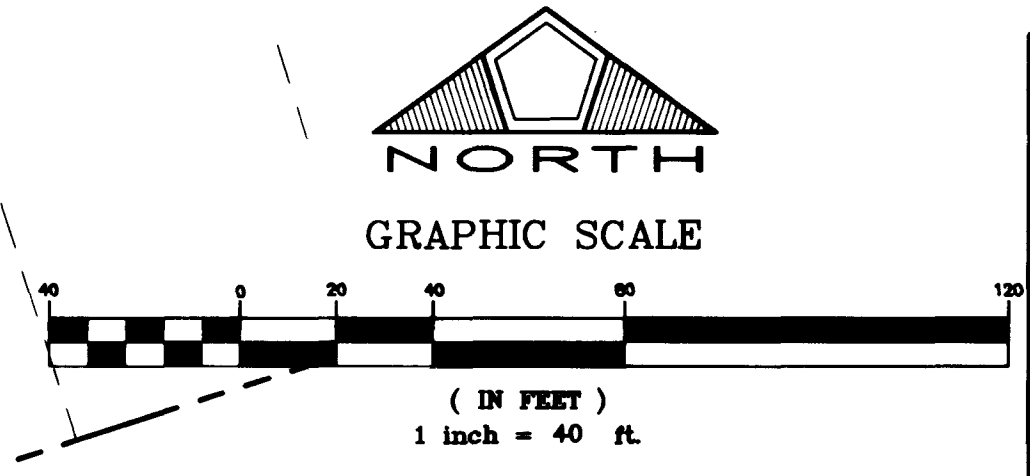


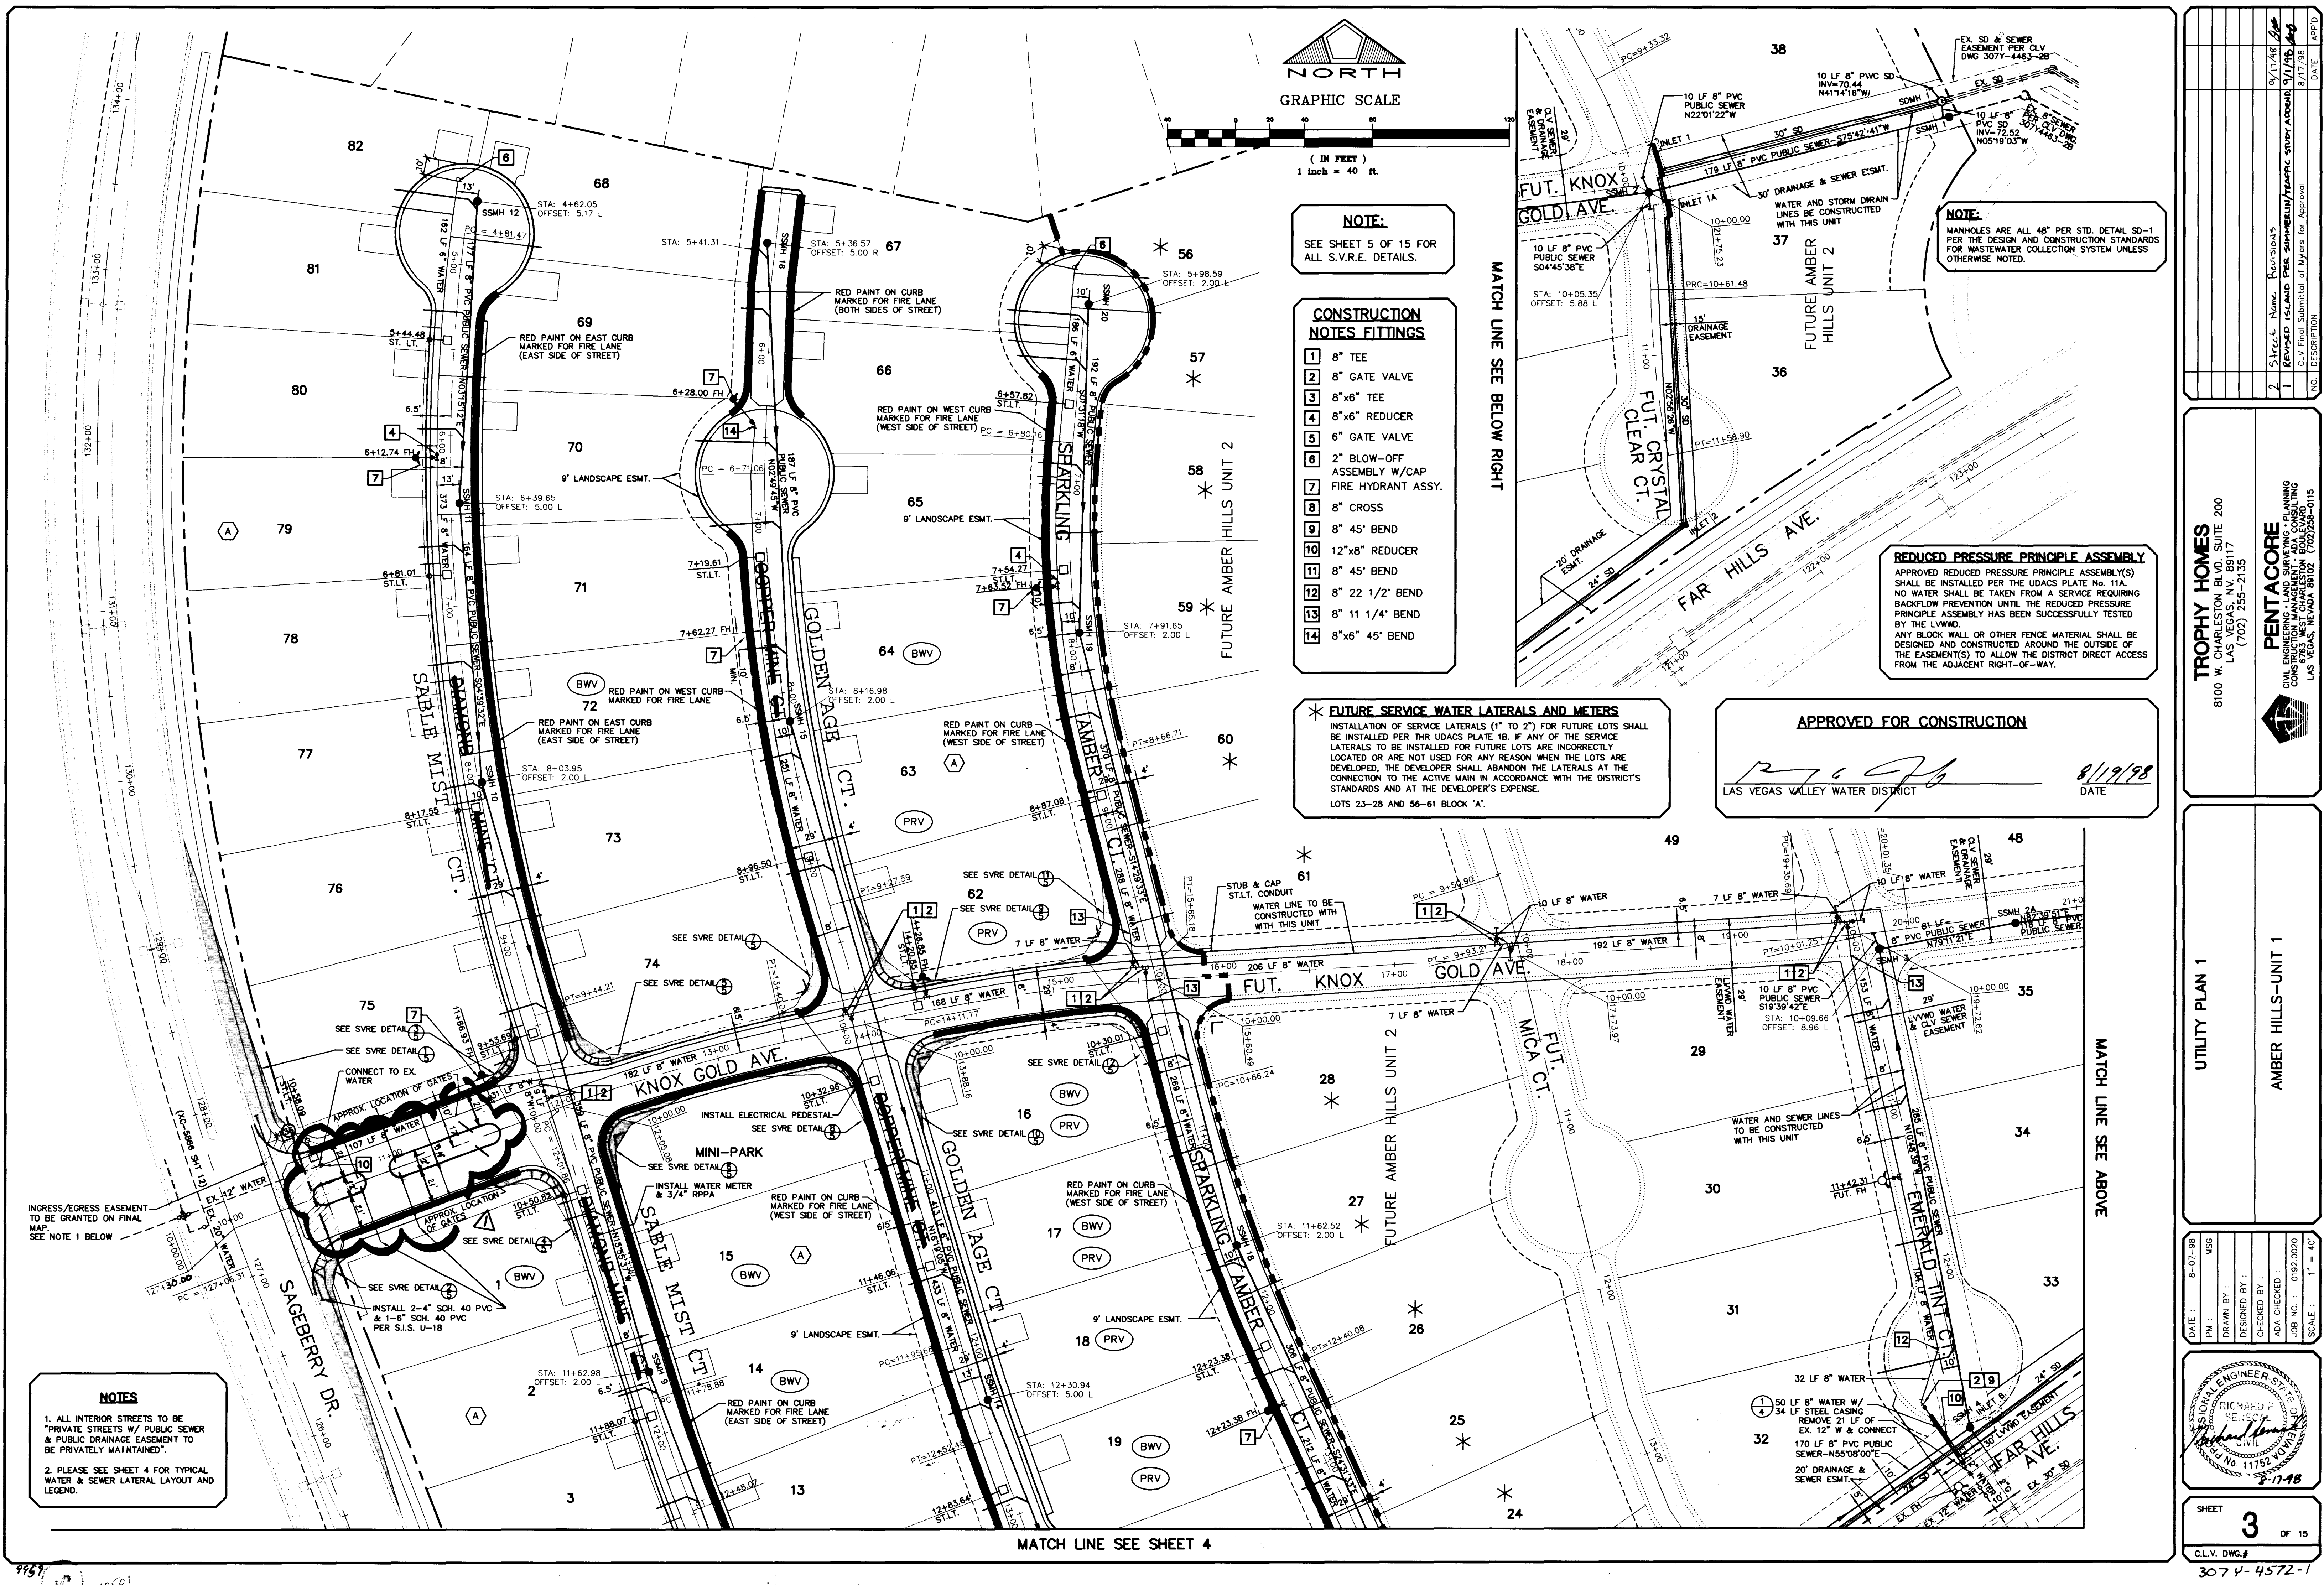

NOTE:
SEE SHEET 5 OF 15 FOR ALL S.V.R.E. DETAILS.

- CONSTRUCTION NOTES FITTINGS**
- 1 8" TEE
 - 2 8" GATE VALVE
 - 3 8"x6" TEE
 - 4 8"x6" REDUCER
 - 5 6" GATE VALVE
 - 6 2" BLOW-OFF ASSEMBLY W/CAP FIRE HYDRANT ASSY.
 - 7 8" CROSS
 - 8 8" 45° BEND
 - 9 12"x8" REDUCER
 - 10 8" 45° BEND
 - 11 8" 22 1/2° BEND
 - 12 8" 11 1/4° BEND
 - 13 8"x6" 45° BEND
 - 14

*** FUTURE SERVICE WATER LATERALS AND METERS**
INSTALLATION OF SERVICE LATERALS (1" TO 2") FOR FUTURE LOTS SHALL BE INSTALLED PER THE UDACS PLATE 1B. IF ANY OF THE SERVICE LATERALS TO BE INSTALLED FOR FUTURE LOTS ARE INCORRECTLY LOCATED OR ARE NOT USED FOR ANY REASON WHEN THE LOTS ARE DEVELOPED, THE DEVELOPER SHALL ABANDON THE LATERALS AT THE CONNECTION TO THE ACTIVE MAIN IN ACCORDANCE WITH THE DISTRICT'S STANDARDS AND AT THE DEVELOPER'S EXPENSE.
LOTS 23-28 AND 56-61 BLOCK 'A'.

APPROVED FOR CONSTRUCTION
[Signature]
LAS VEGAS VALLEY WATER DISTRICT
8/19/98
DATE

NOTE:
MANHOLES ARE ALL 48" PER STD. DETAIL SD-1 PER THE DESIGN AND CONSTRUCTION STANDARDS FOR WASTEWATER COLLECTION SYSTEM UNLESS OTHERWISE NOTED.

REDUCED PRESSURE PRINCIPLE ASSEMBLY
APPROVED REDUCED PRESSURE PRINCIPLE ASSEMBLY(S) SHALL BE INSTALLED PER THE UDACS PLATE No. 11A. NO WATER SHALL BE TAKEN FROM A SERVICE REQUIRING BACKFLOW PREVENTION UNTIL THE REDUCED PRESSURE PRINCIPLE ASSEMBLY HAS BEEN SUCCESSFULLY TESTED BY THE LVWD.
ANY BLOCK WALL OR OTHER FENCE MATERIAL SHALL BE DESIGNED AND CONSTRUCTED AROUND THE OUTSIDE OF THE EASEMENT(S) TO ALLOW THE DISTRICT DIRECT ACCESS FROM THE ADJACENT RIGHT-OF-WAY.

NOTES
1. ALL INTERIOR STREETS TO BE "PRIVATE STREETS W/ PUBLIC SEWER & PUBLIC DRAINAGE EASEMENT TO BE PRIVATELY MAINTAINED".
2. PLEASE SEE SHEET 4 FOR TYPICAL WATER & SEWER LATERAL LAYOUT AND LEGEND.

NO.	DESCRIPTION	DATE	APP'D
1	REVISION	8/17/98	
2	STREET NAME REVISIONS	9/1/98	
3	REVISED ISLAND PER SHIMMEL/TERRAF STUDY ADDITION	9/1/98	
4	CLV Final Submit of Meters for Approval	8/17/98	

TROPHY HOMES
8100 W. CHARLESTON BLVD., SUITE 200
LAS VEGAS, NV 89117
(702) 255-2135

PENTACORE
CIVIL ENGINEERING & SURVEYING
CONSULTING
8783 WEST CHARLESTON BOULEVARD
LAS VEGAS, NEVADA 89102 (702) 258-0115

UTILITY PLAN 1
AMBER HILLS-UNIT 1

DATE:	8-07-98
DESIGNED BY:	MSG
DRAWN BY:	
CHECKED BY:	
ADA CHECKED:	
JOB NO.:	0182.0020
SCALE:	1" = 40'

