



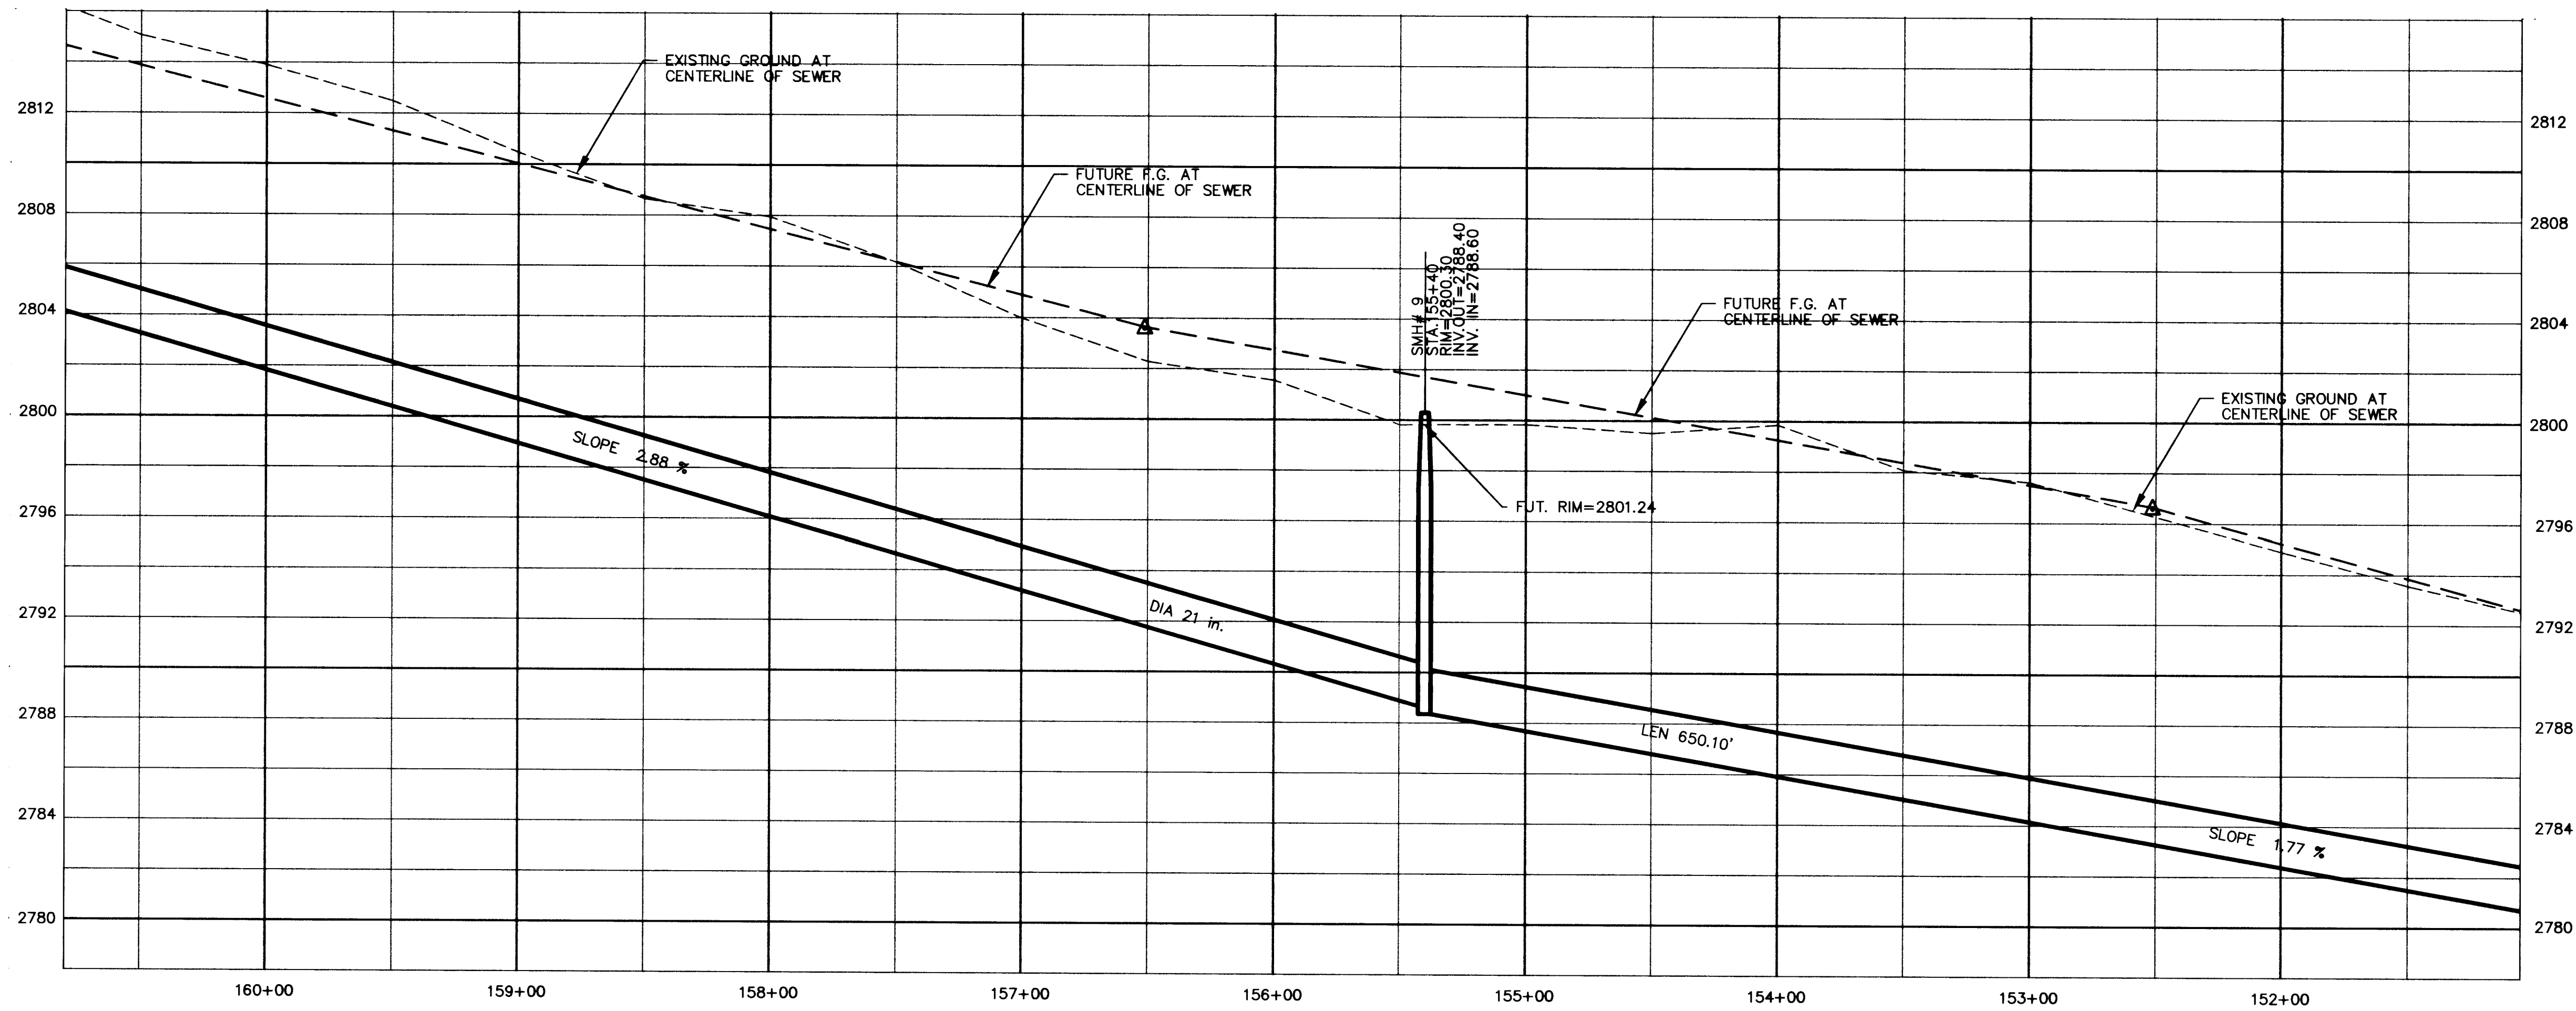

PROFILE

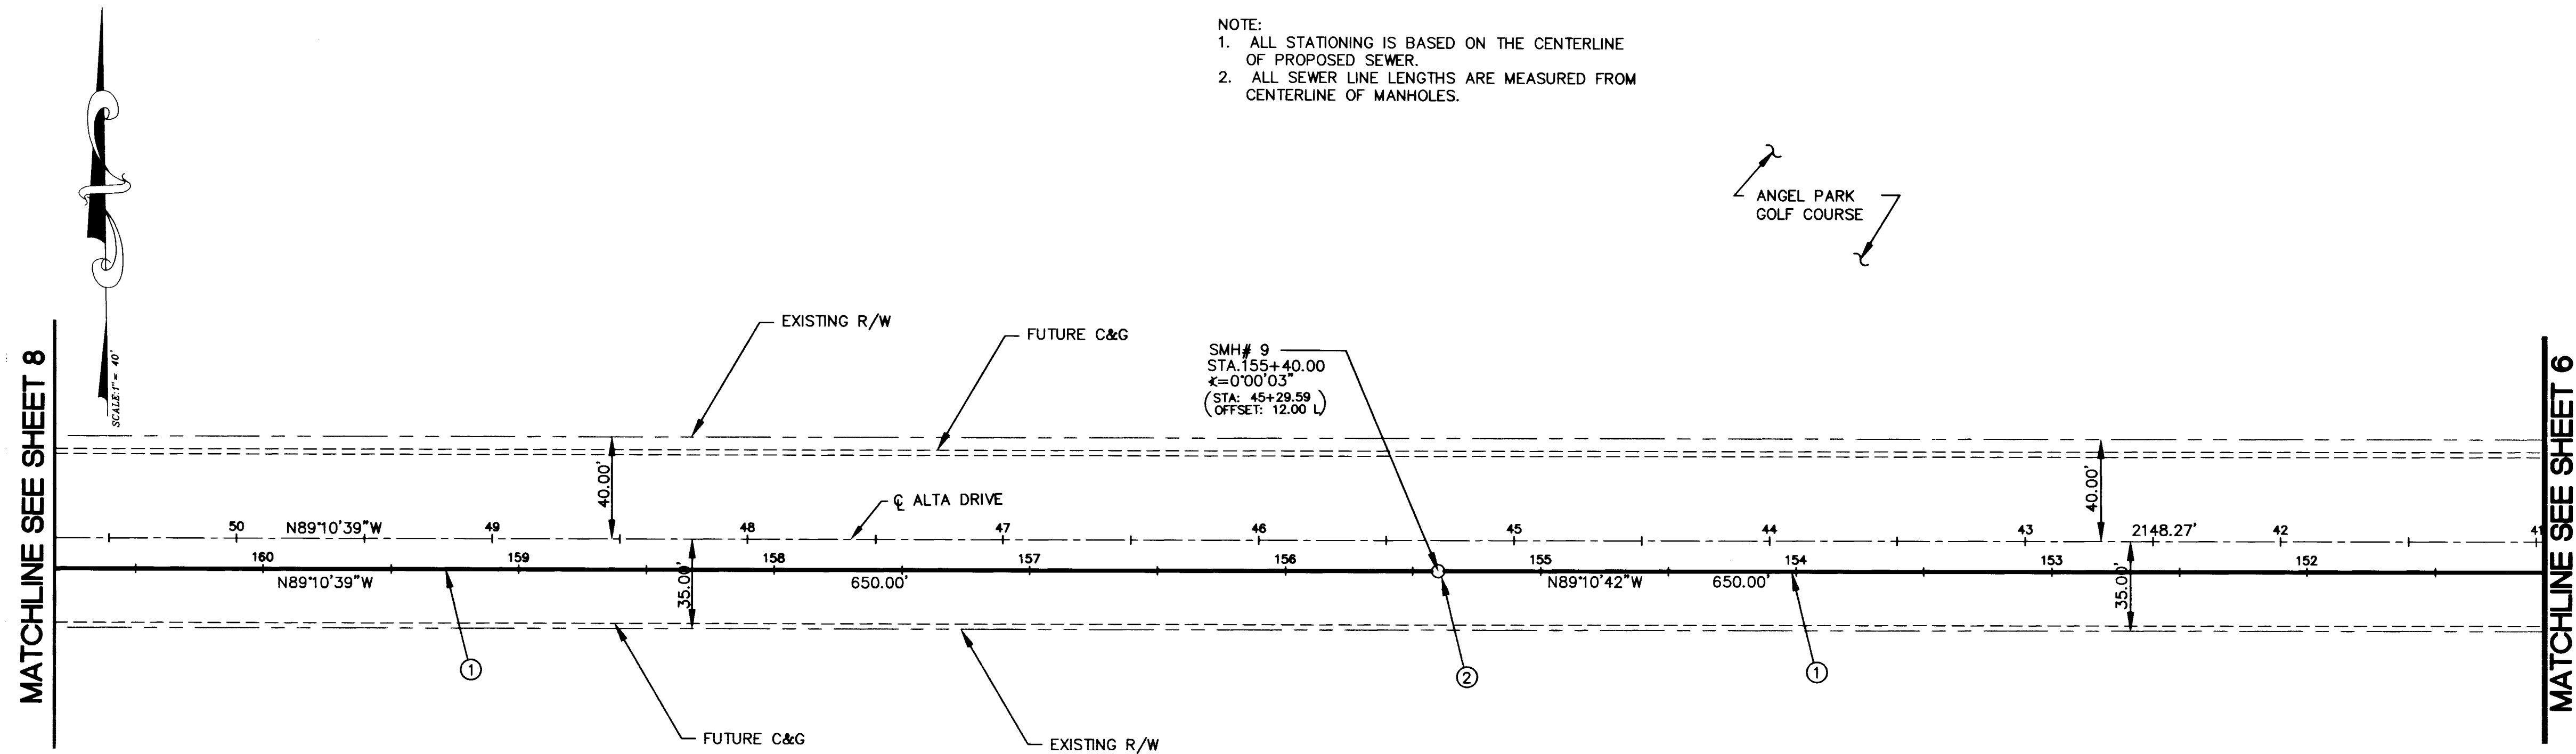

- NOTE:
 1. ALL STATIONING IS BASED ON THE CENTERLINE OF PROPOSED SEWER.
 2. ALL SEWER LINE LENGTHS ARE MEASURED FROM CENTERLINE OF MANHOLES.

ANGEL PARK GOLF COURSE

MATCHLINE SEE SHEET 8

MATCHLINE SEE SHEET 6

Call before you Dig

AVOID CUTTING UNDERGROUND UTILITY LINES. IT'S COSTLY!

1-800-227-2600
UNDERGROUND SERVICE (USA)


NOTICE

UTILITY LOCATIONS SHOWN HEREON ARE APPROXIMATE ONLY. IT SHALL BE THE CONTRACTOR'S RESPONSIBILITY TO DETERMINE THE EXACT VERTICAL AND HORIZONTAL LOCATION OF ALL EXISTING UNDERGROUND UTILITIES PRIOR TO COMMENCING CONSTRUCTION. NO REPRESENTATION IS MADE THAT ALL EXISTING UTILITIES ARE SHOWN HEREON. THE ENGINEER ASSUMES NO RESPONSIBILITY FOR UTILITIES NOT SHOWN OR UTILITIES NOT SHOWN IN THEIR PROPER LOCATION.

CALL BEFORE YOU DIG: 1-800-227-2600

- CONSTRUCTION NOTES**
- ① CONSTRUCT 21" SANITARY SEWER
- ② CONSTRUCT 60" SEWER MANHOLE PER DWG. No. SD-1 OF "SEWER STD'S"

PLAN: ALTA DRIVE-SEWER

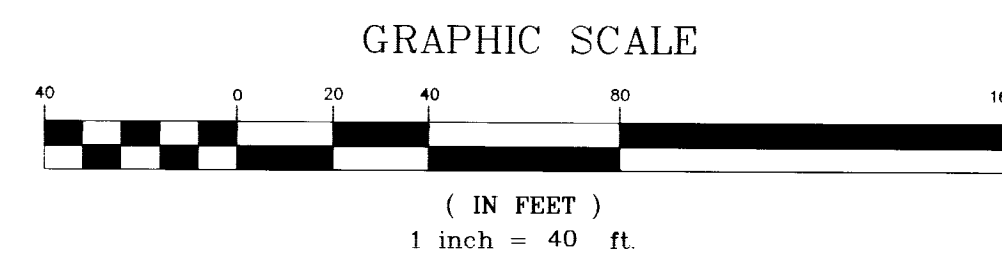


STANLEY CONSULTANTS

1771 EAST FLAMINGO ROAD, SUITE 104-B
LAS VEGAS, NEVADA 89119 (702) 369-9396

INTERNATIONAL CONSULTANTS IN ENGINEERING, PLANNING AND MANAGEMENT

DATE	REVISIONS	W.A. # N/A	SCALE (V) 1"= 4'	SCALE (H) 1"= 40'
		DESIGN BY A/V/ROB	FEB 26, 1997	F.L.D. BK. # N/A
ENGINEERING DESIGN SECTION CITY ENGINEER: DENNIS ANDERSON, P.E. DESIGN ENGINEER: STANLEY CONSULTANTS				
DEPARTMENT OF PUBLIC WORKS PROJECT: ALTA SEWER INTERCEPTOR SHEET: SEWER PLAN AND PROFILE DRAWING NO. 7 307-V751				

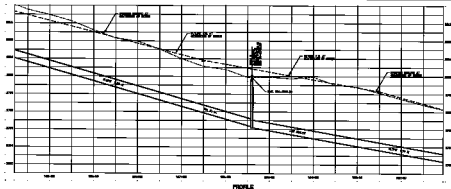

1. ALL ELEVATIONS ARE BASED ON THE DATUM
2. ELEVATIONS ARE BASED ON THE DATUM
3. ELEVATIONS ARE BASED ON THE DATUM

1. ALL ELEVATIONS ARE BASED ON THE DATUM
2. ELEVATIONS ARE BASED ON THE DATUM
3. ELEVATIONS ARE BASED ON THE DATUM

1. ALL ELEVATIONS ARE BASED ON THE DATUM
2. ELEVATIONS ARE BASED ON THE DATUM
3. ELEVATIONS ARE BASED ON THE DATUM

PLAN ALTA CORRECTION

SCALE: 1" = 40'



CONSTRUCTION NOTES
1. ELEVATIONS ARE BASED ON THE DATUM
2. ELEVATIONS ARE BASED ON THE DATUM
3. ELEVATIONS ARE BASED ON THE DATUM

STANLEY CONSULTANTS
1000 WEST 10TH AVENUE
DENVER, COLORADO 80202
TELEPHONE: 333-1111
FACSIMILE: 333-1111

DEPARTMENT OF PUBLIC WORKS
ALTA CORRECTION
INTERCEPTOR



DATE OF PLAN	10/1/80
DATE OF FIELD	10/1/80
DATE OF REVIEW	10/1/80
DATE OF APPROVAL	10/1/80
DATE OF SUBMITTAL	10/1/80
DATE OF CLOSURE	10/1/80
DATE OF REMOVAL	10/1/80